


Photo 25 Loading bay level layout. Entry point at the north of the building and Vodafone shop in unit 20. Drilling and traywork to be done 8am - 6pm. Cabling to be done at night. MEWP required.

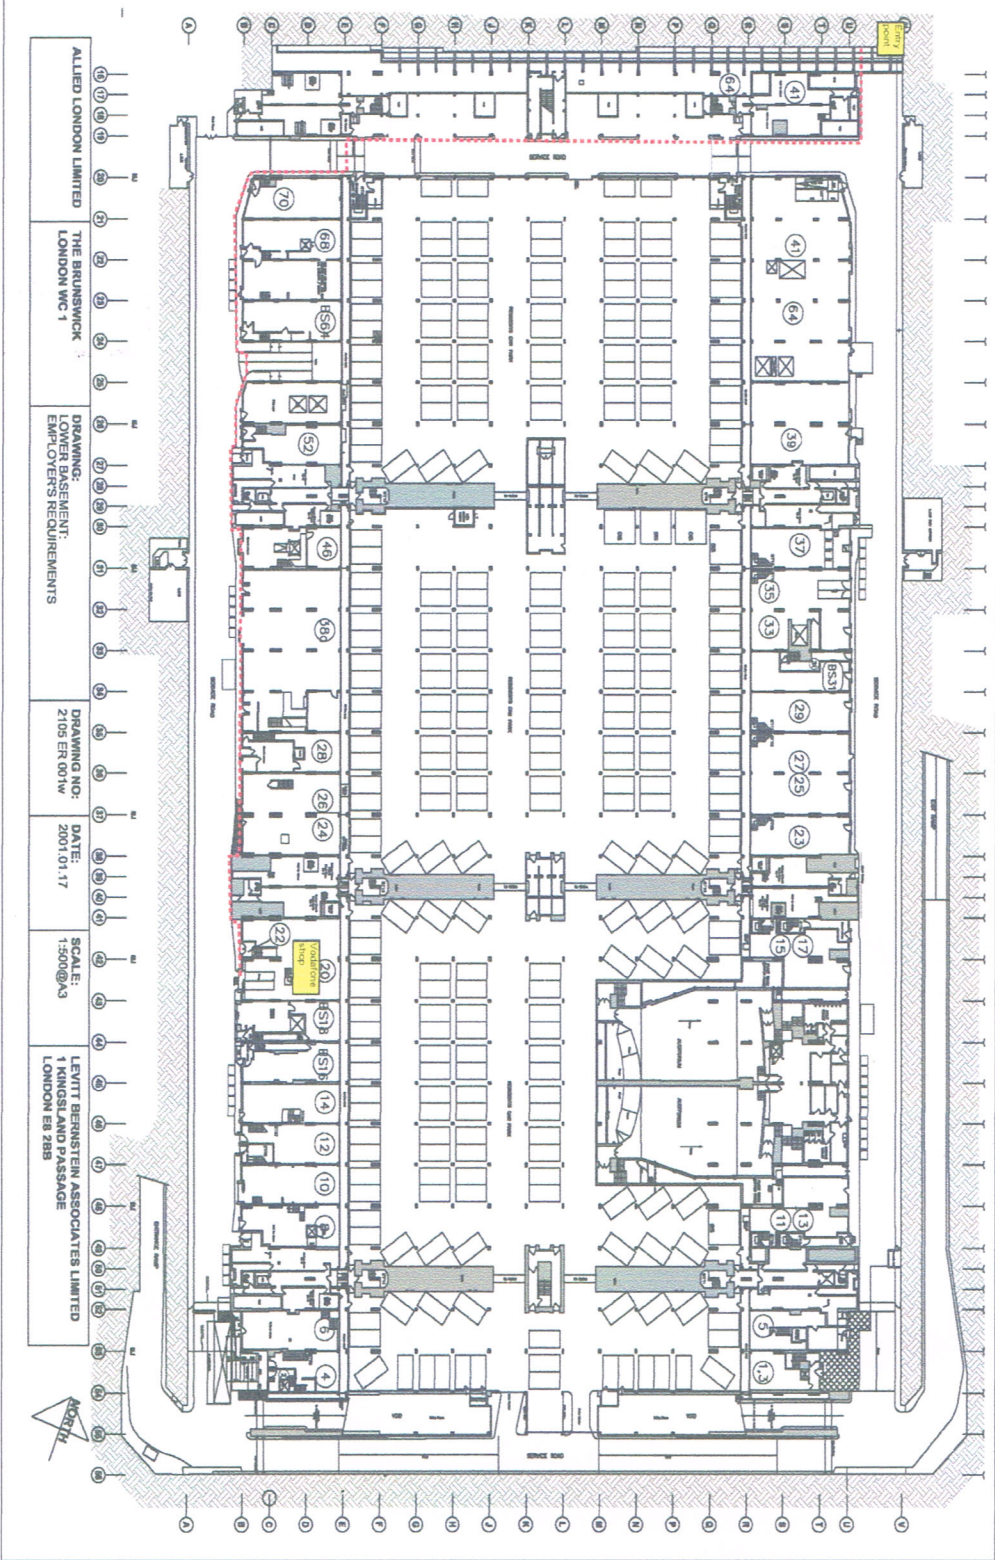

ALLIED LONDON LIMITED THE BRUNSWICK LONDON WC1
DRAWING: LOWER BASEMENT: EMPLOYER'S REQUIREMENTS
DRAWING NO: 2105 ER 001W DATE: 2001.01.17 SCALE: 1:500 @ A3
LEVITT BERNSTEIN ASSOCIATES LIMITED LONDON E8 2BB

Notes

EXTERNAL CIVILS

- Existing duct route
- Existing Chamber
- Existing Duct entry
- New Duct route
- New duct route
- Existing Street Cabinet
- New Street Cabinet

EXTERNAL CABLING

- New cable route in existing duct



INTERNAL - Floor Plan/photographic schedule

- Existing rack or equipment housing (aerial view)
- New rack or equipment housing (aerial view)
- New Building Flexibility Point
- Existing Building Flexibility Point
- New Customer termination point
- New cable route (labelled as required)



UNMAINTAINED COPY FOR INFORMATION ONLY LATEST REVISION HELD BY DRAWING OFFICE

THIS DRAWING IS NOT TO SCALE

Issue	Date	Dept	Order No	DRN	CHND
1	06/04/2017	FS	Chris Hughton		



Vodafone Limited (No 01471597) registered office is at Vodafone House, The Connection, Newbury, Berkshire, RG14 2FN

UNIT 20, BRUNSWICK SQUARE, BRUNSWICK, LONDON, WC1N 1AY

Drawing Title

Cable Proposals

Drawn	Date	Checked	Date
Chris Hughton	06/04/2017		
Drawing No	Sheet No	of	5
Q5181481-4-1-1/003	5		