



 

© Crown Copyright 2010 Licence Number 03663783

1 SITE LOCATION PLAN

1:1250 @ A3




RUGBY STREET

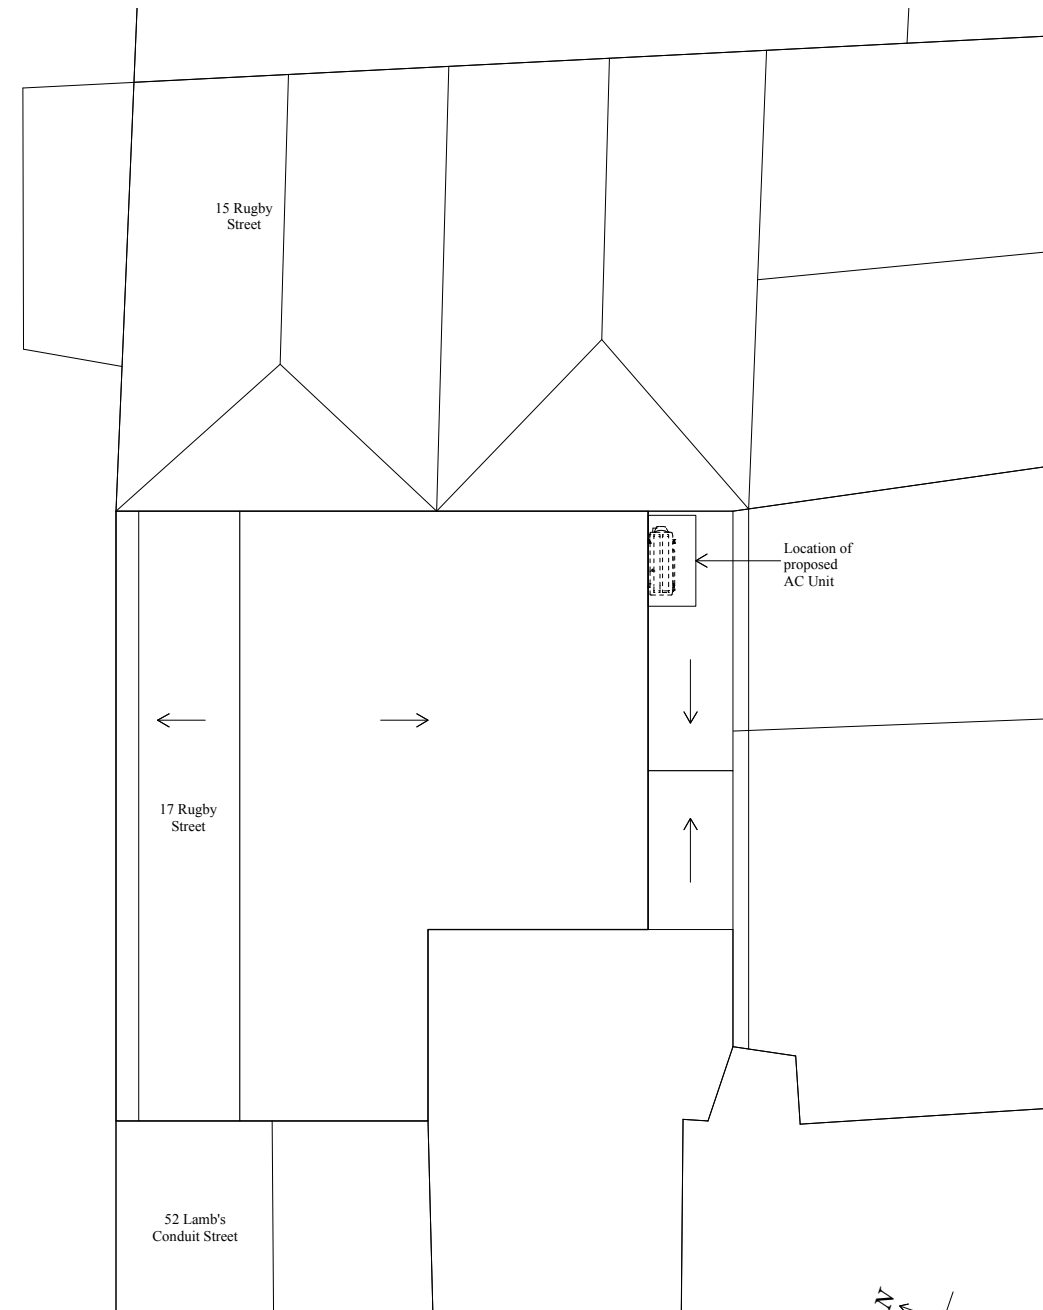

2 ROOF PLAN

 1:100 @ A3



REV. NO.	AMENDMENT	DATE

<b>Ben Pentreath</b>		3 Lamp Office Court Lamb's Conduit Street London WC1N 3NF T +44 (0) 20 7430 2424 benpentreath.com
PROJECT: 17 RUGBY STREET		
TITLE: SITE LOCATION PLAN & PROPOSED PLAN		
DRAWING NO: A-100	REV. NO: -	
SCALE: 1:1250 @ A3 1:100 @ A3	DRAWN BY: AB	
DATE: 15.05.2017	CHECKED BY: BP	
All dimensions to be checked on site. All designs © Ben Pentreath Ltd 2016. Not to be reproduced without permission.		