

PLANNING ISSUE

REVISIONS

NOTES

143C CONSTANTINE ROAD, NW3 2LR

PROPOSED DRAINAGE PLAN GF

DWG No: 143CR/D101


SCALE: 1 - 50 @A3

DATE: JUL 2017

BELSIZE ARCHITECTS

48 PARKHILL ROAD, LONDON NW3 2YP
TEL 020 7482 4420 - FAX 020 7482 4186
MAIL@BELSIZEARCHITECTS.COM

© COPYRIGHT
NOT TO BE REPRODUCED OR USED
WITHOUT PERMISSION

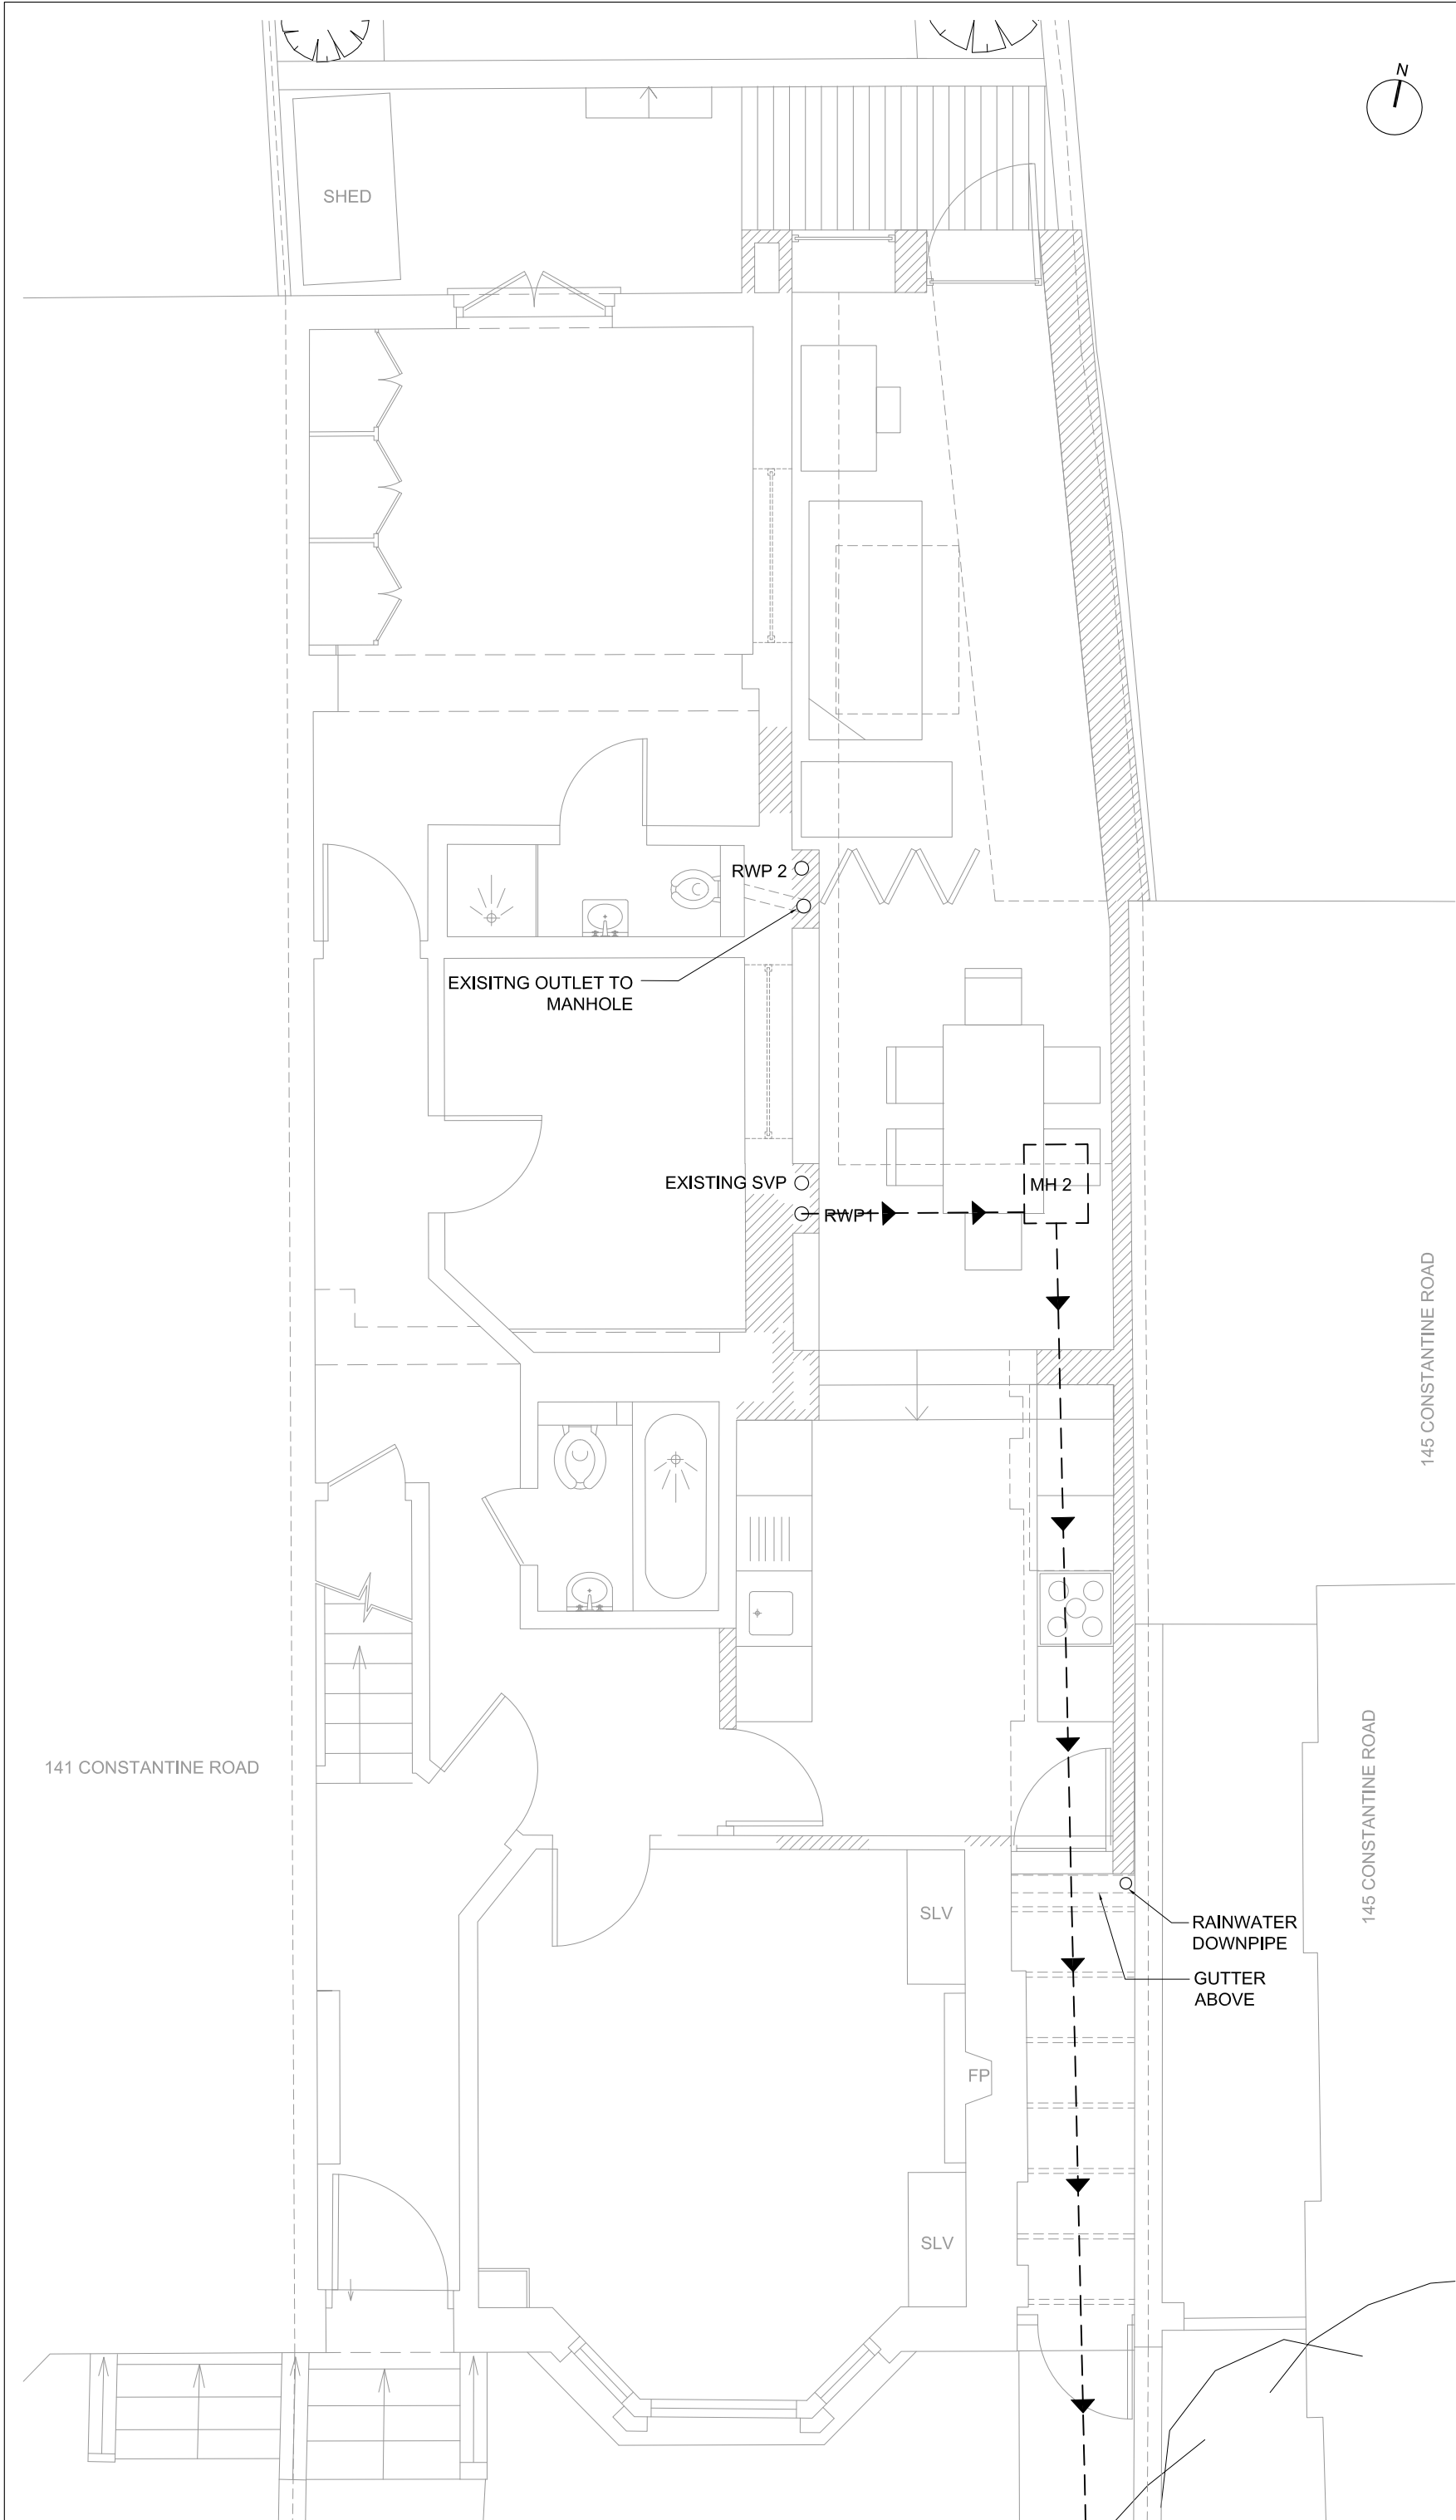

PROPOSED DRAINAGE GROUND FLOOR PLAN