

REV	DESCRIPTION	DATE	DRWN

Kinleigh, Folkard & Hayward
Chartered Surveyors

kfh.co.uk


KFH House, 5 Compton Road,
Wimbledon,
London SW19 7QA
Tel 0800 328 8898
Fax 0208 739 2095

DRAWN JP
CHECKED I
SCALE 1:50
DATE 22/06/17
JOB TITLE **Queensmead
St Johns Wood Road
NW8 6RE**


DRAWING DESCRIPTION
**Proposed New Concierge Office
Floor, Ceiling & Roof plans
Sections**

JOB NO 17.08


DRAWING NO 02

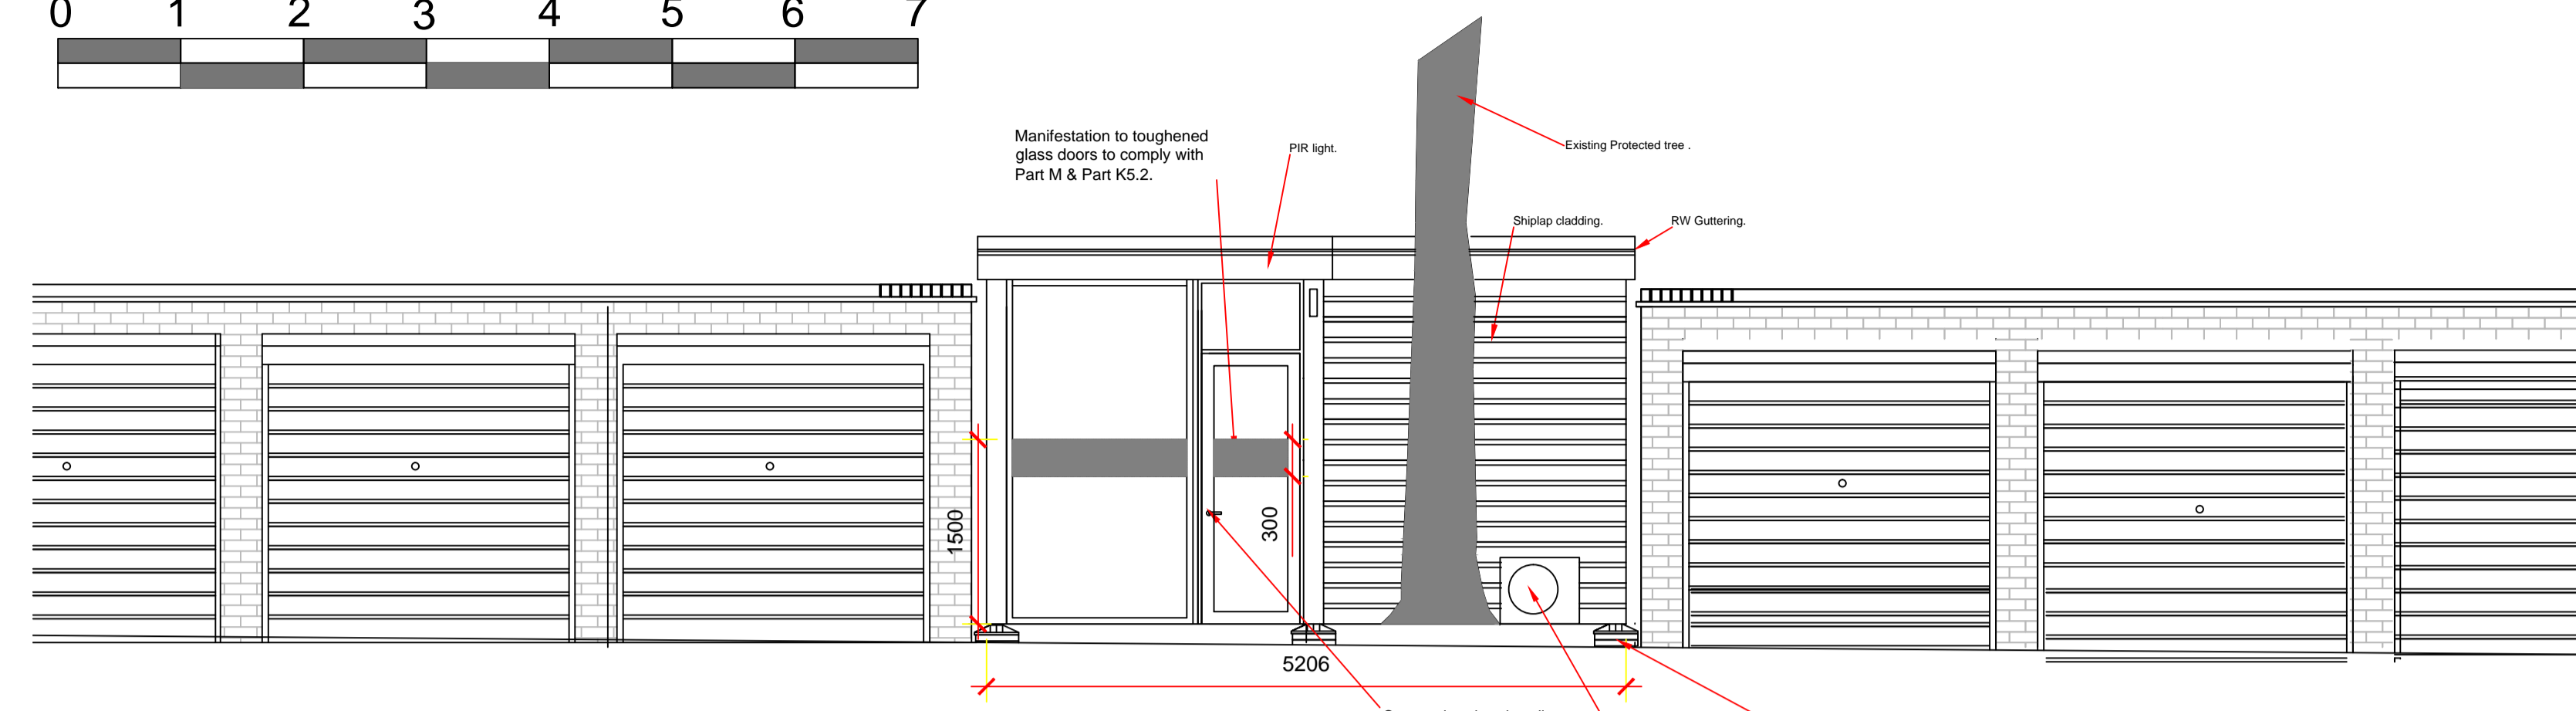


PROPOSED FRONT ELEVATION

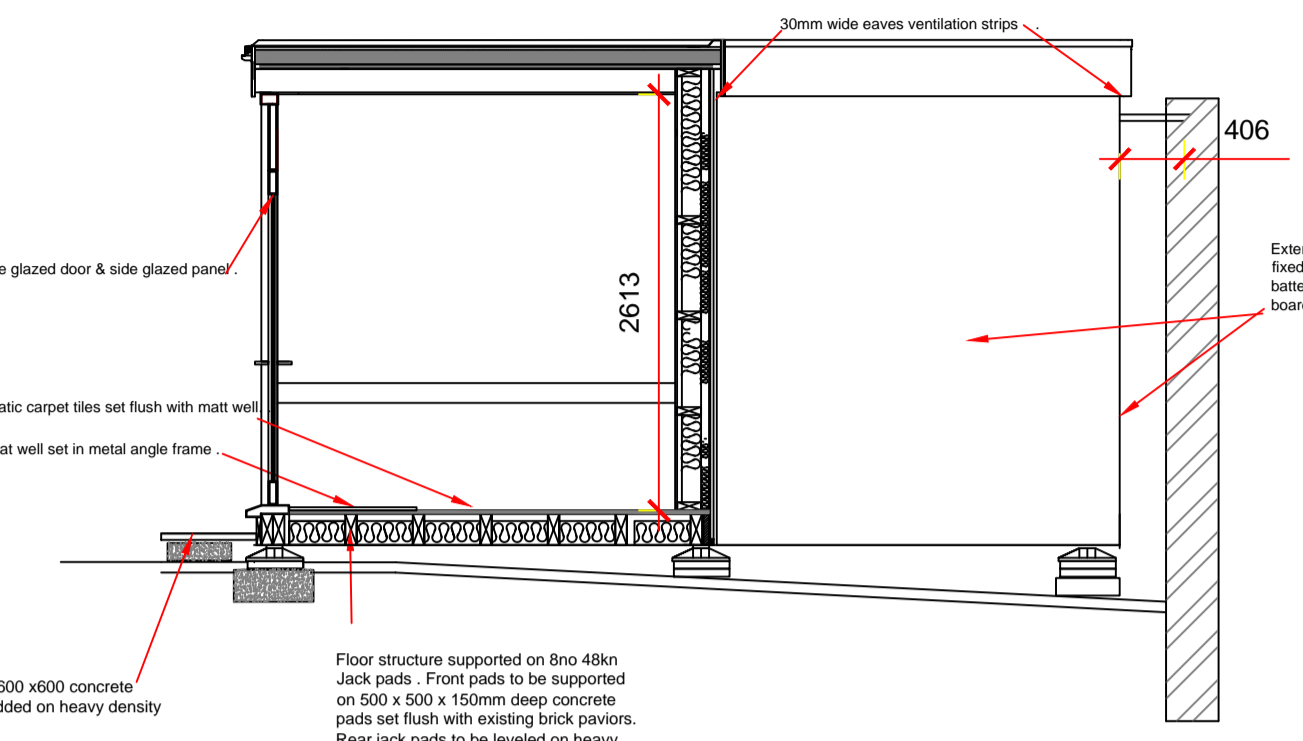


SIDE SECTION B - B

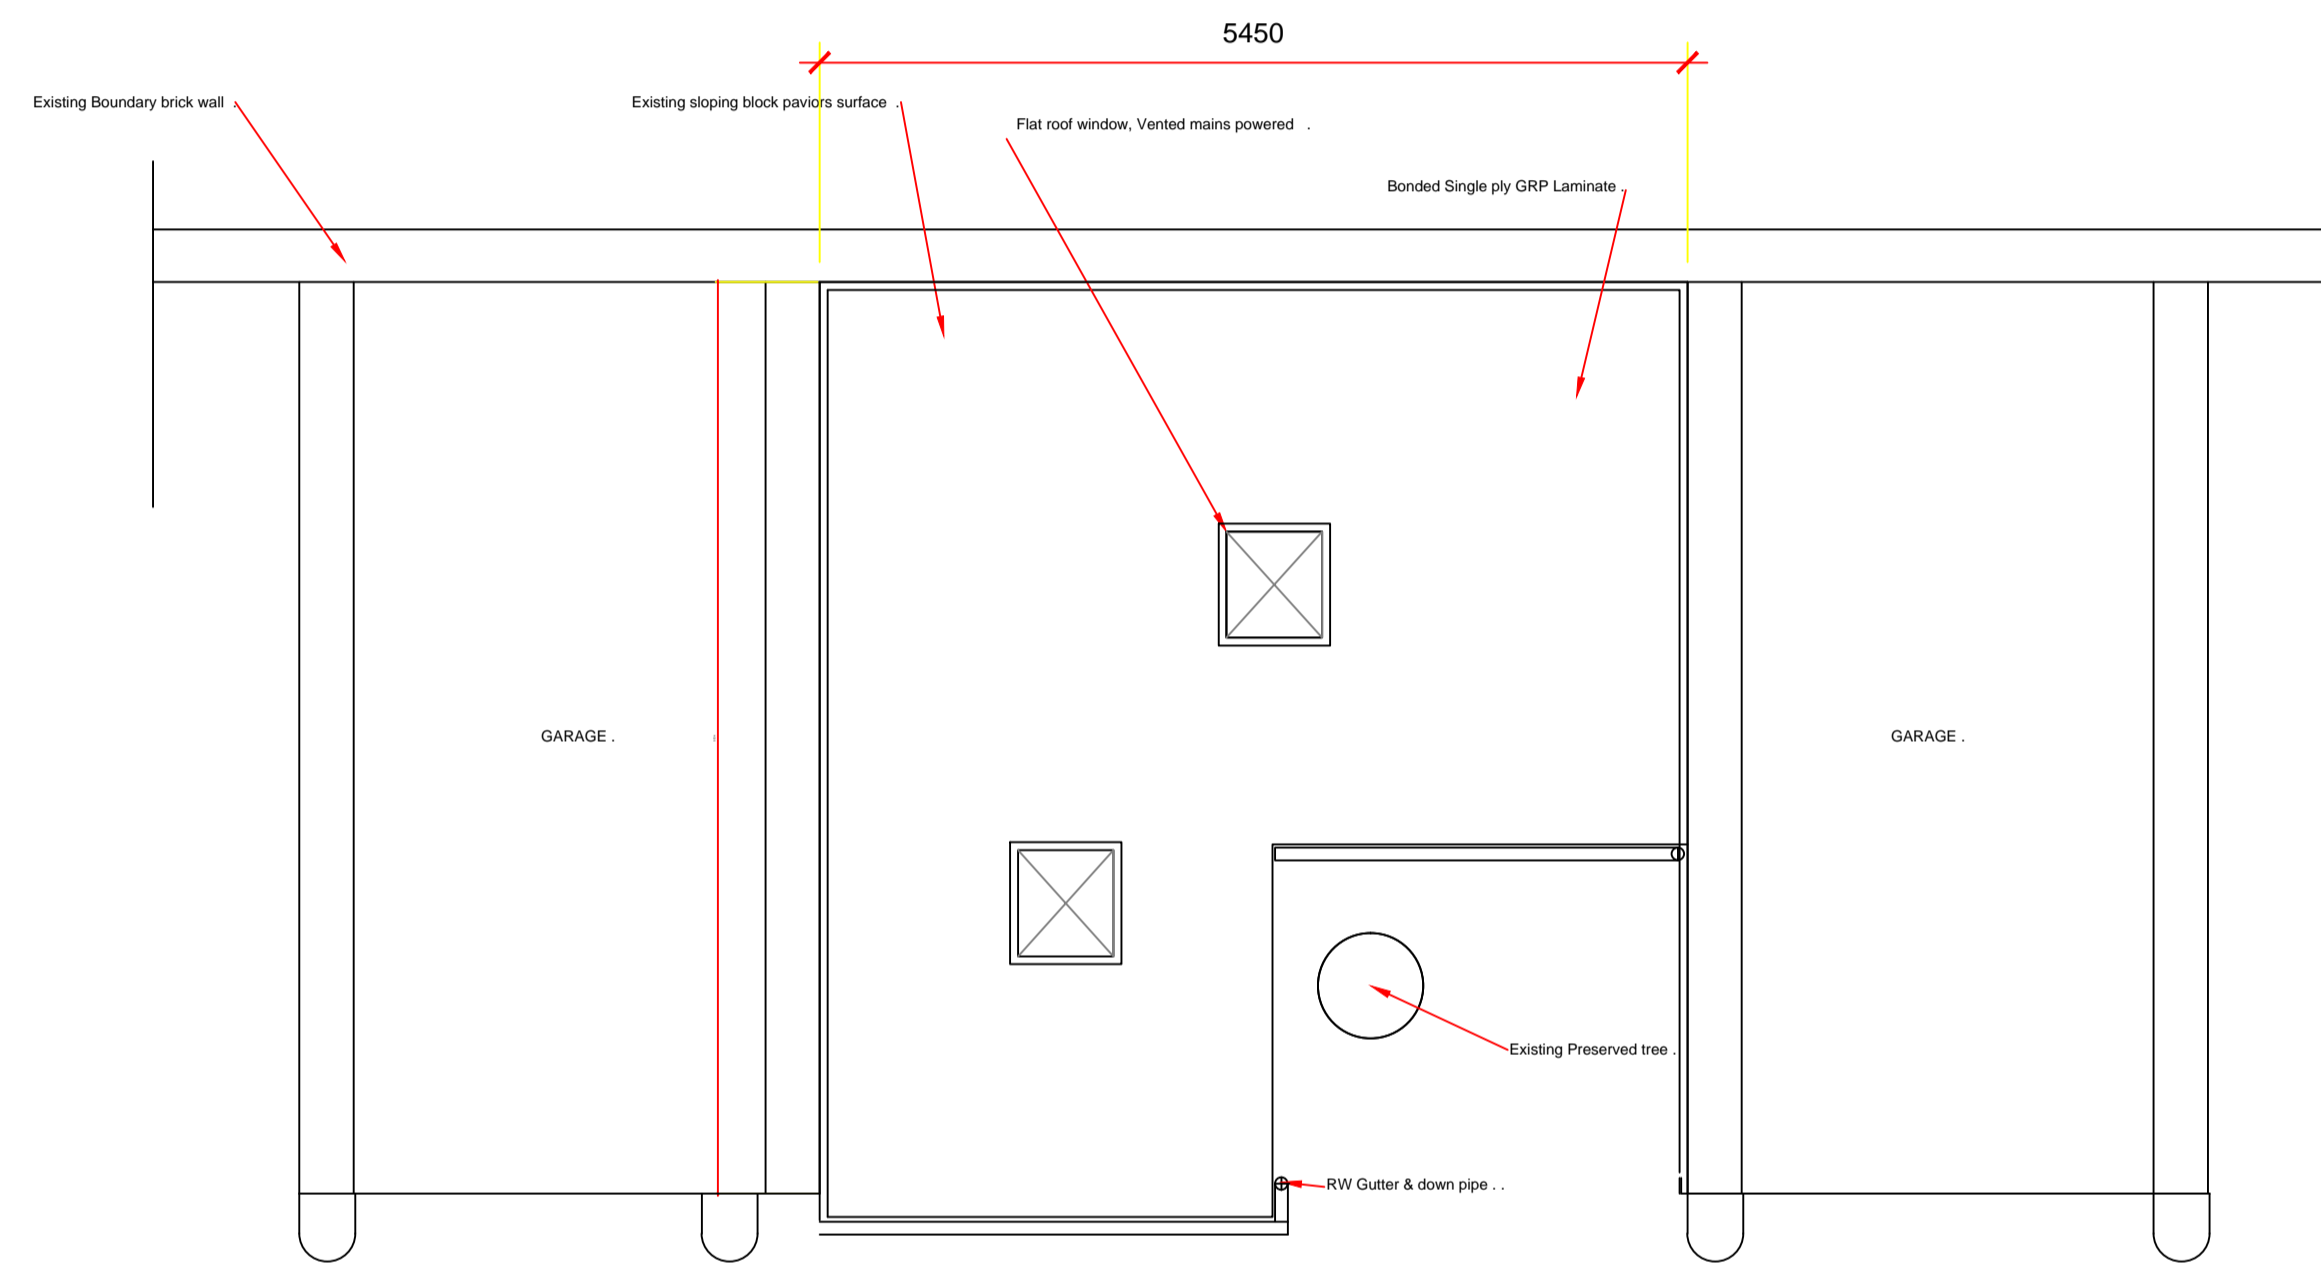


ROOF PLAN LAYOUT

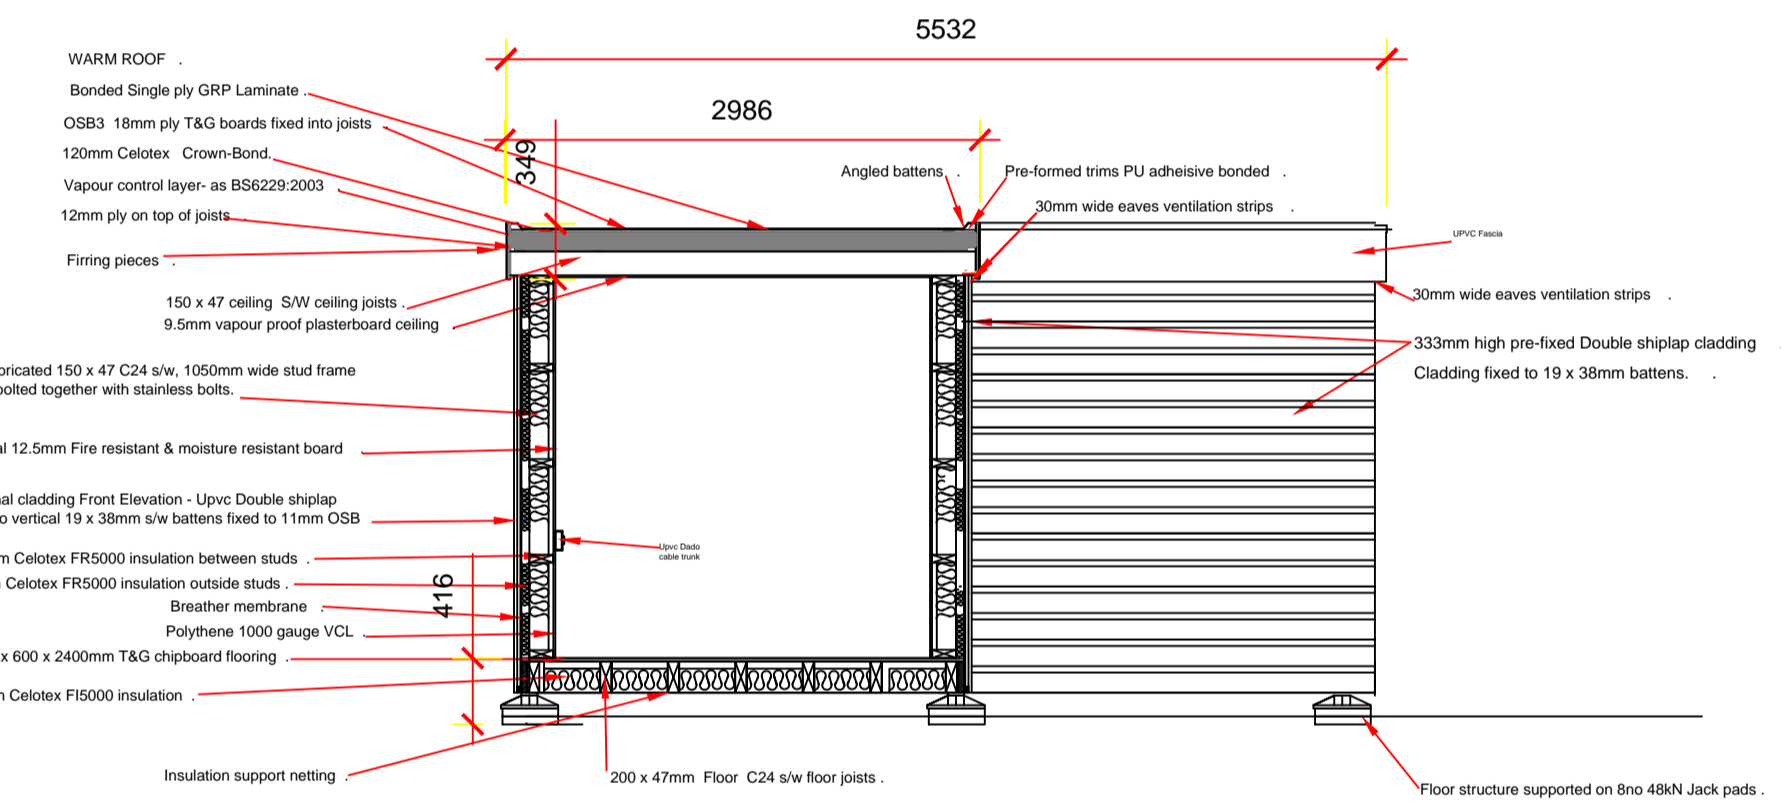


Front Section A - A

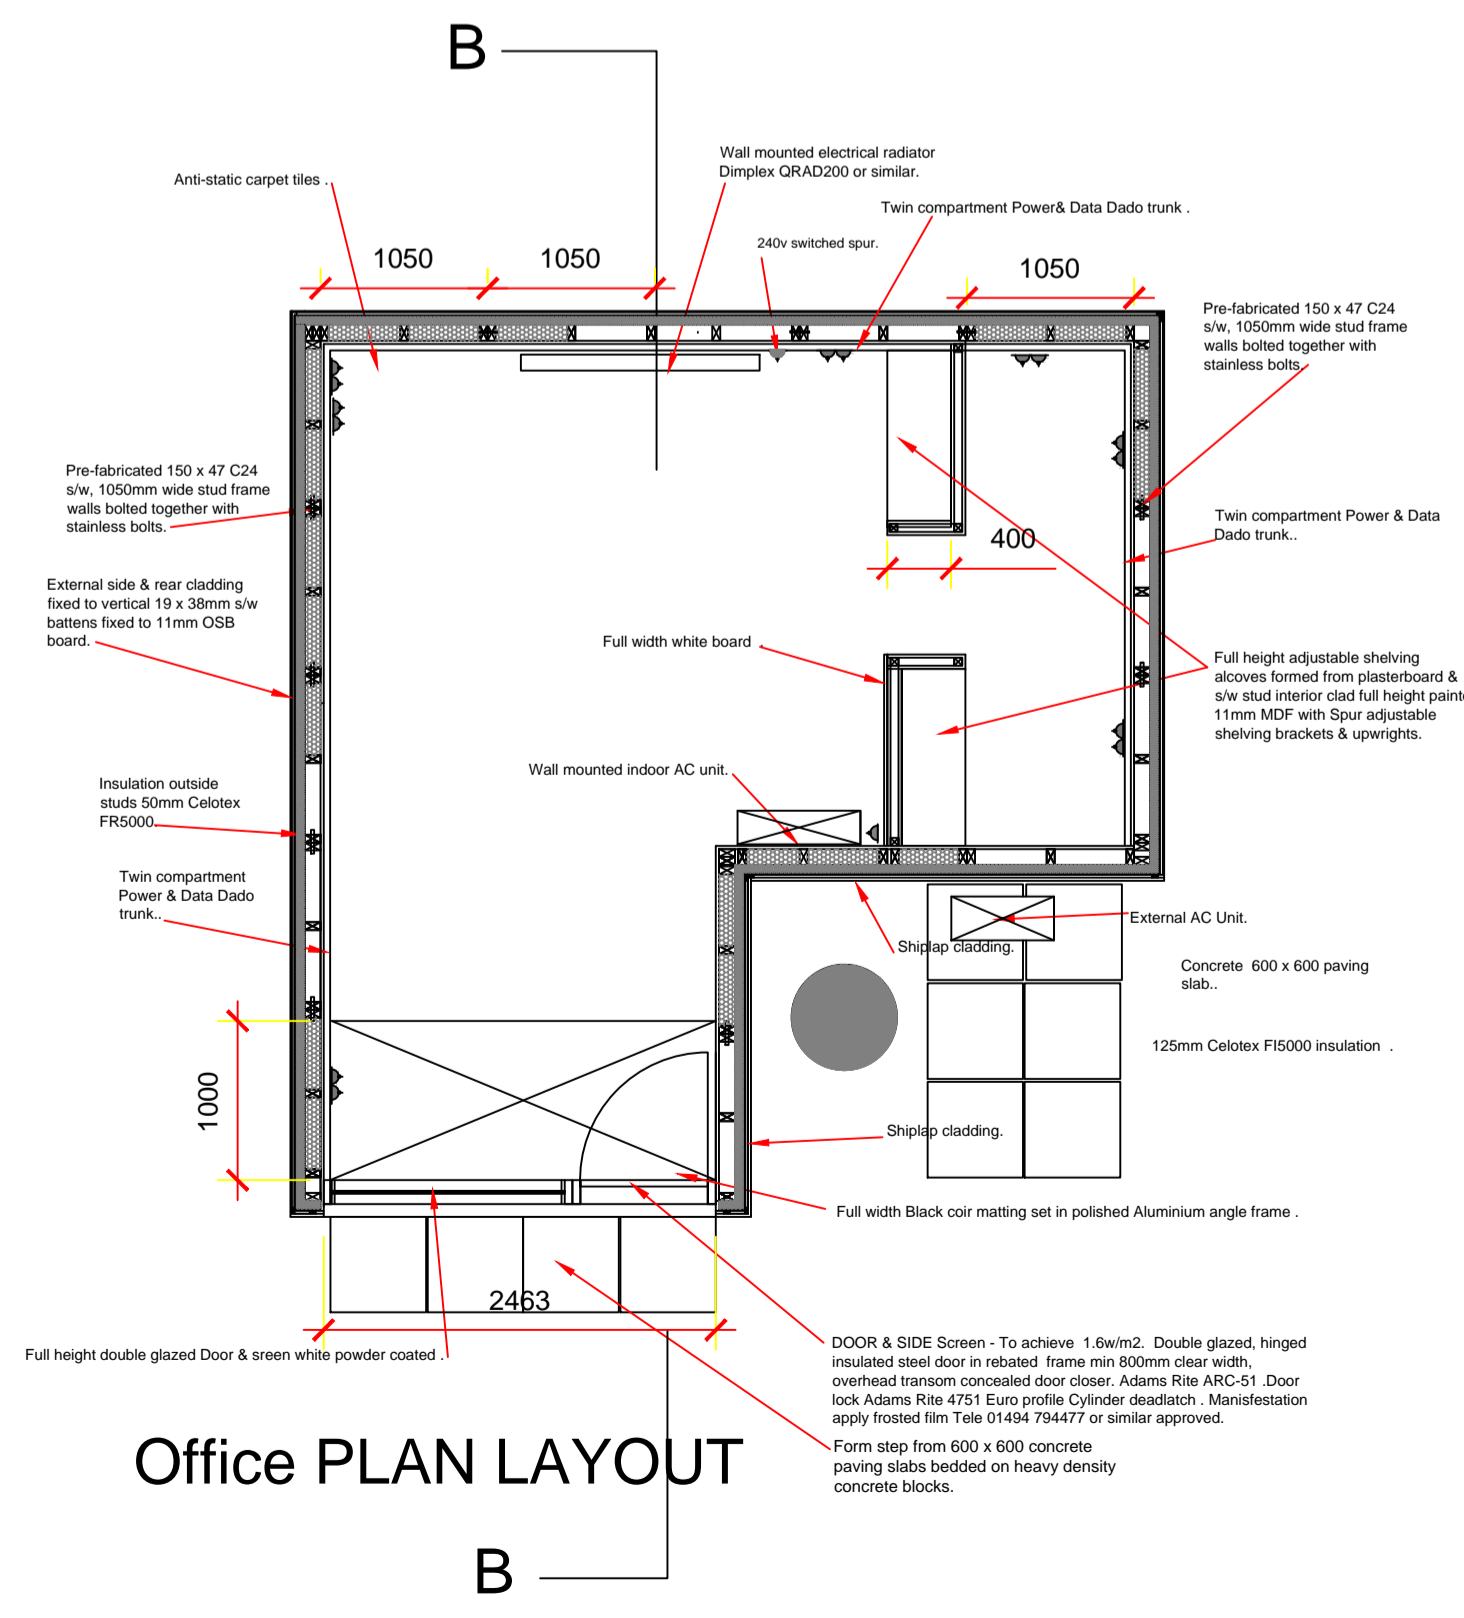


Office PLAN LAYOUT

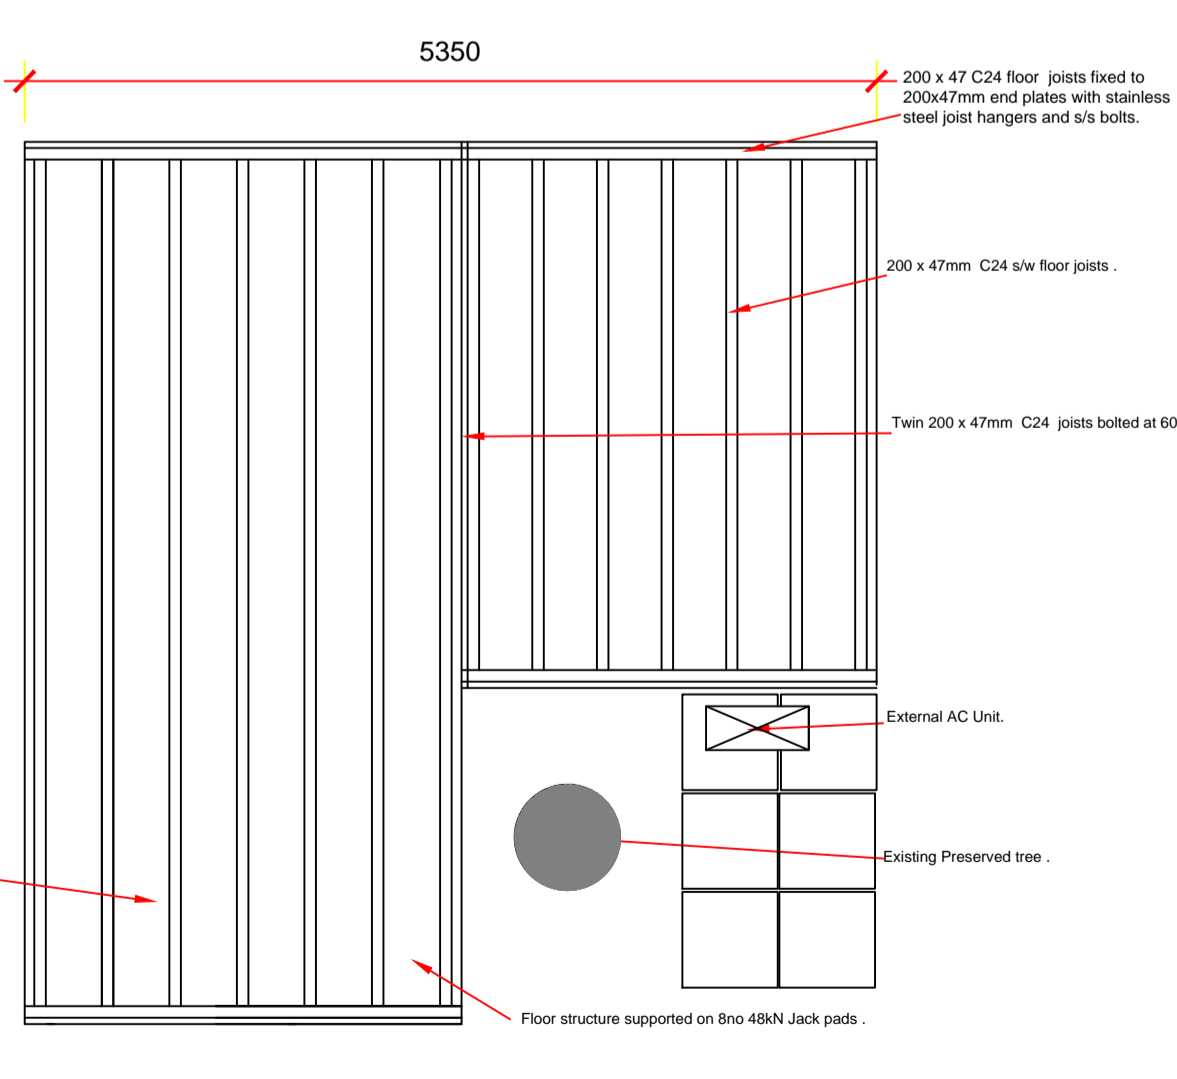

FLOOR JOIST LAYOUT

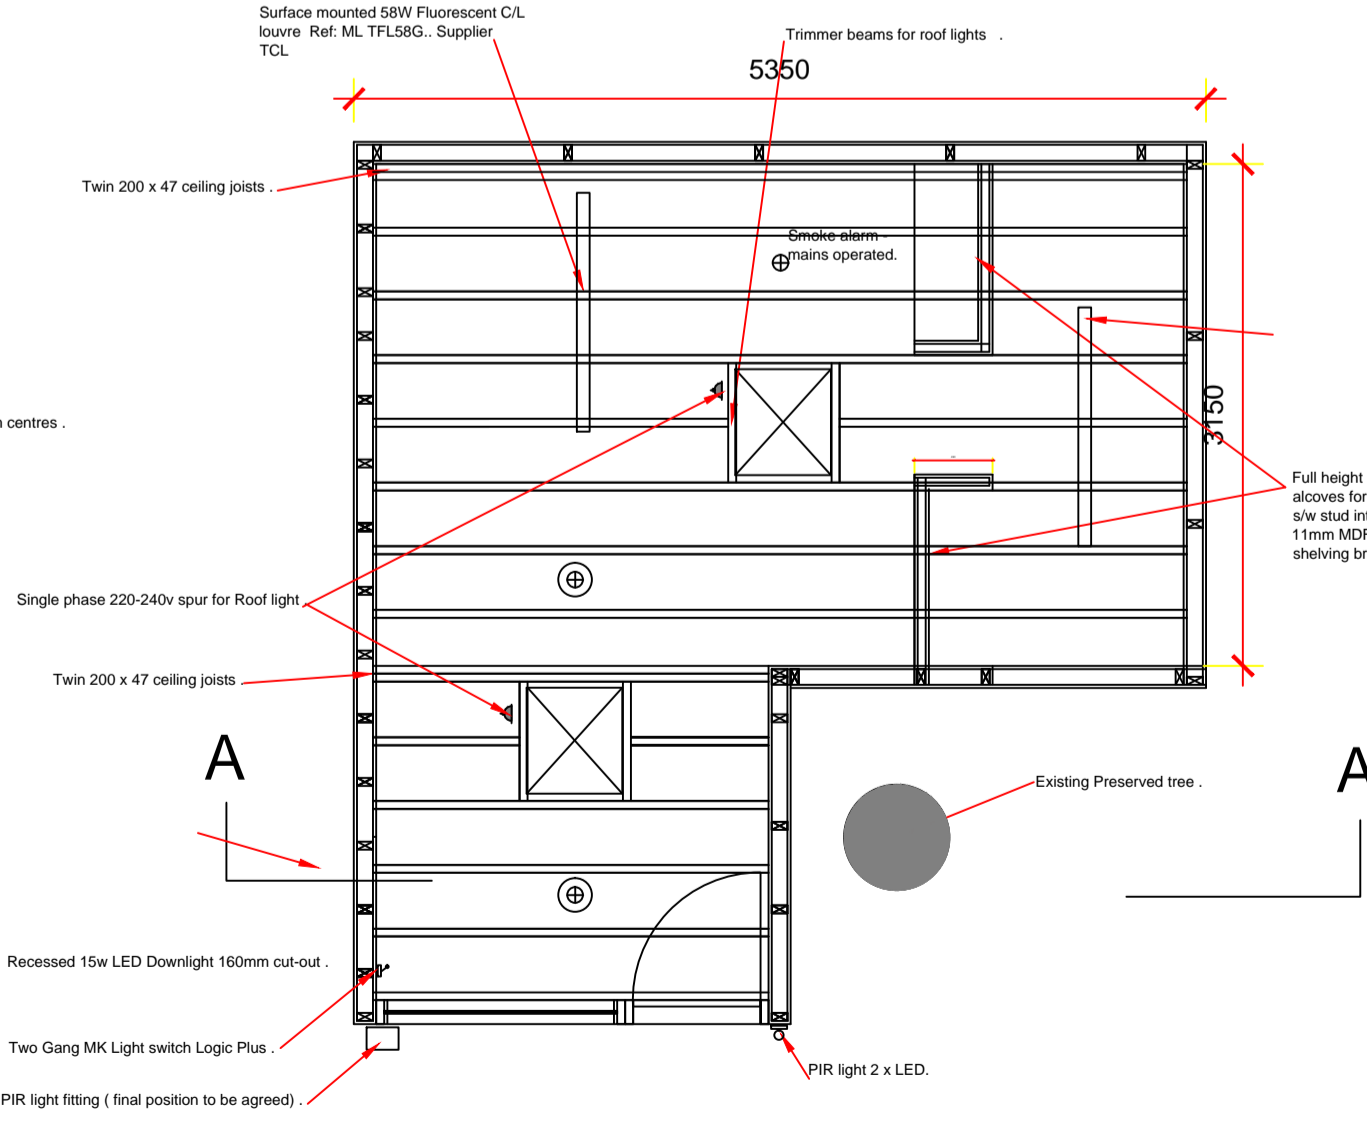

CEILING & LIGHTING LAYOUT

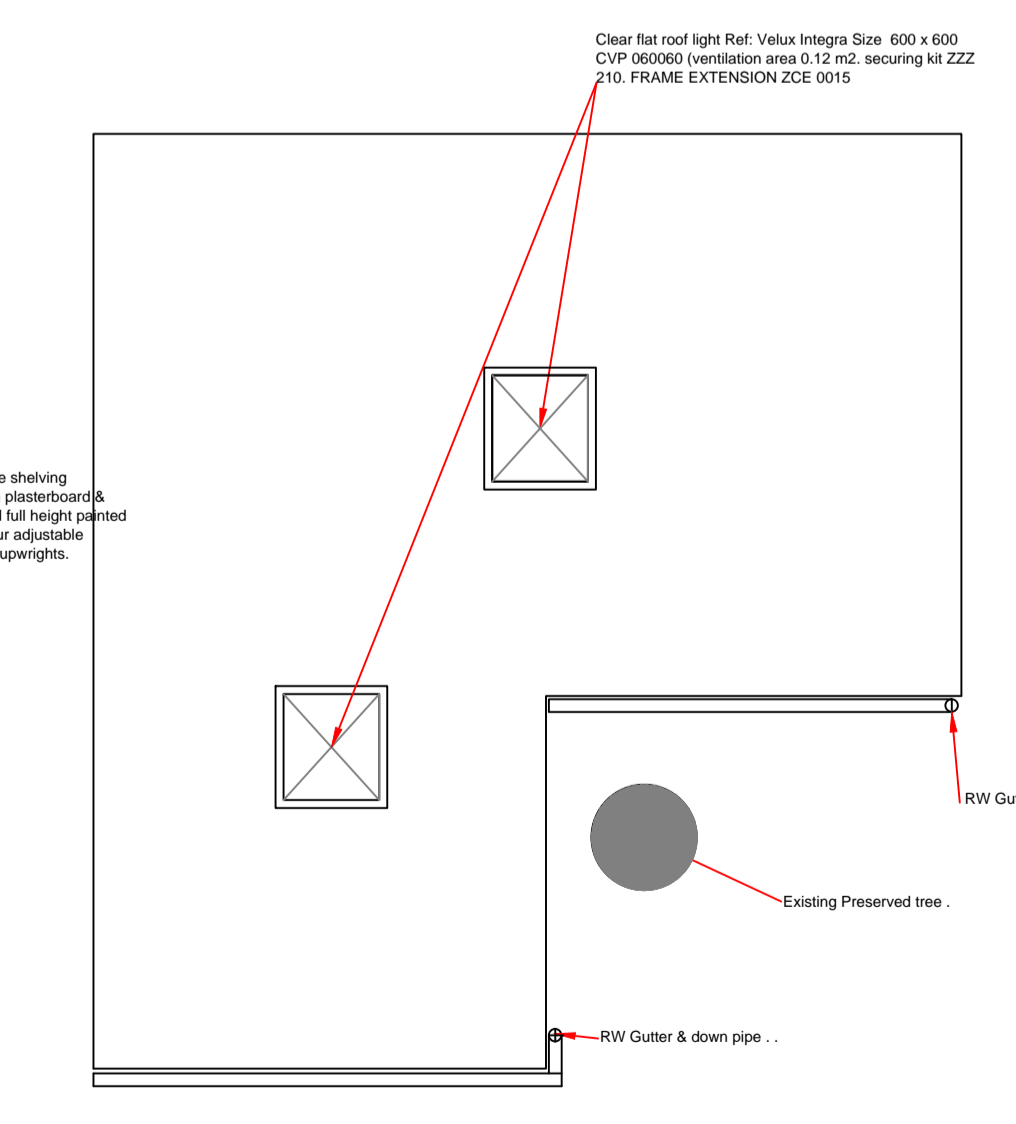

ROOF PLAN LAYOUT