


 

 
 
 

 
 
 
 


 
 




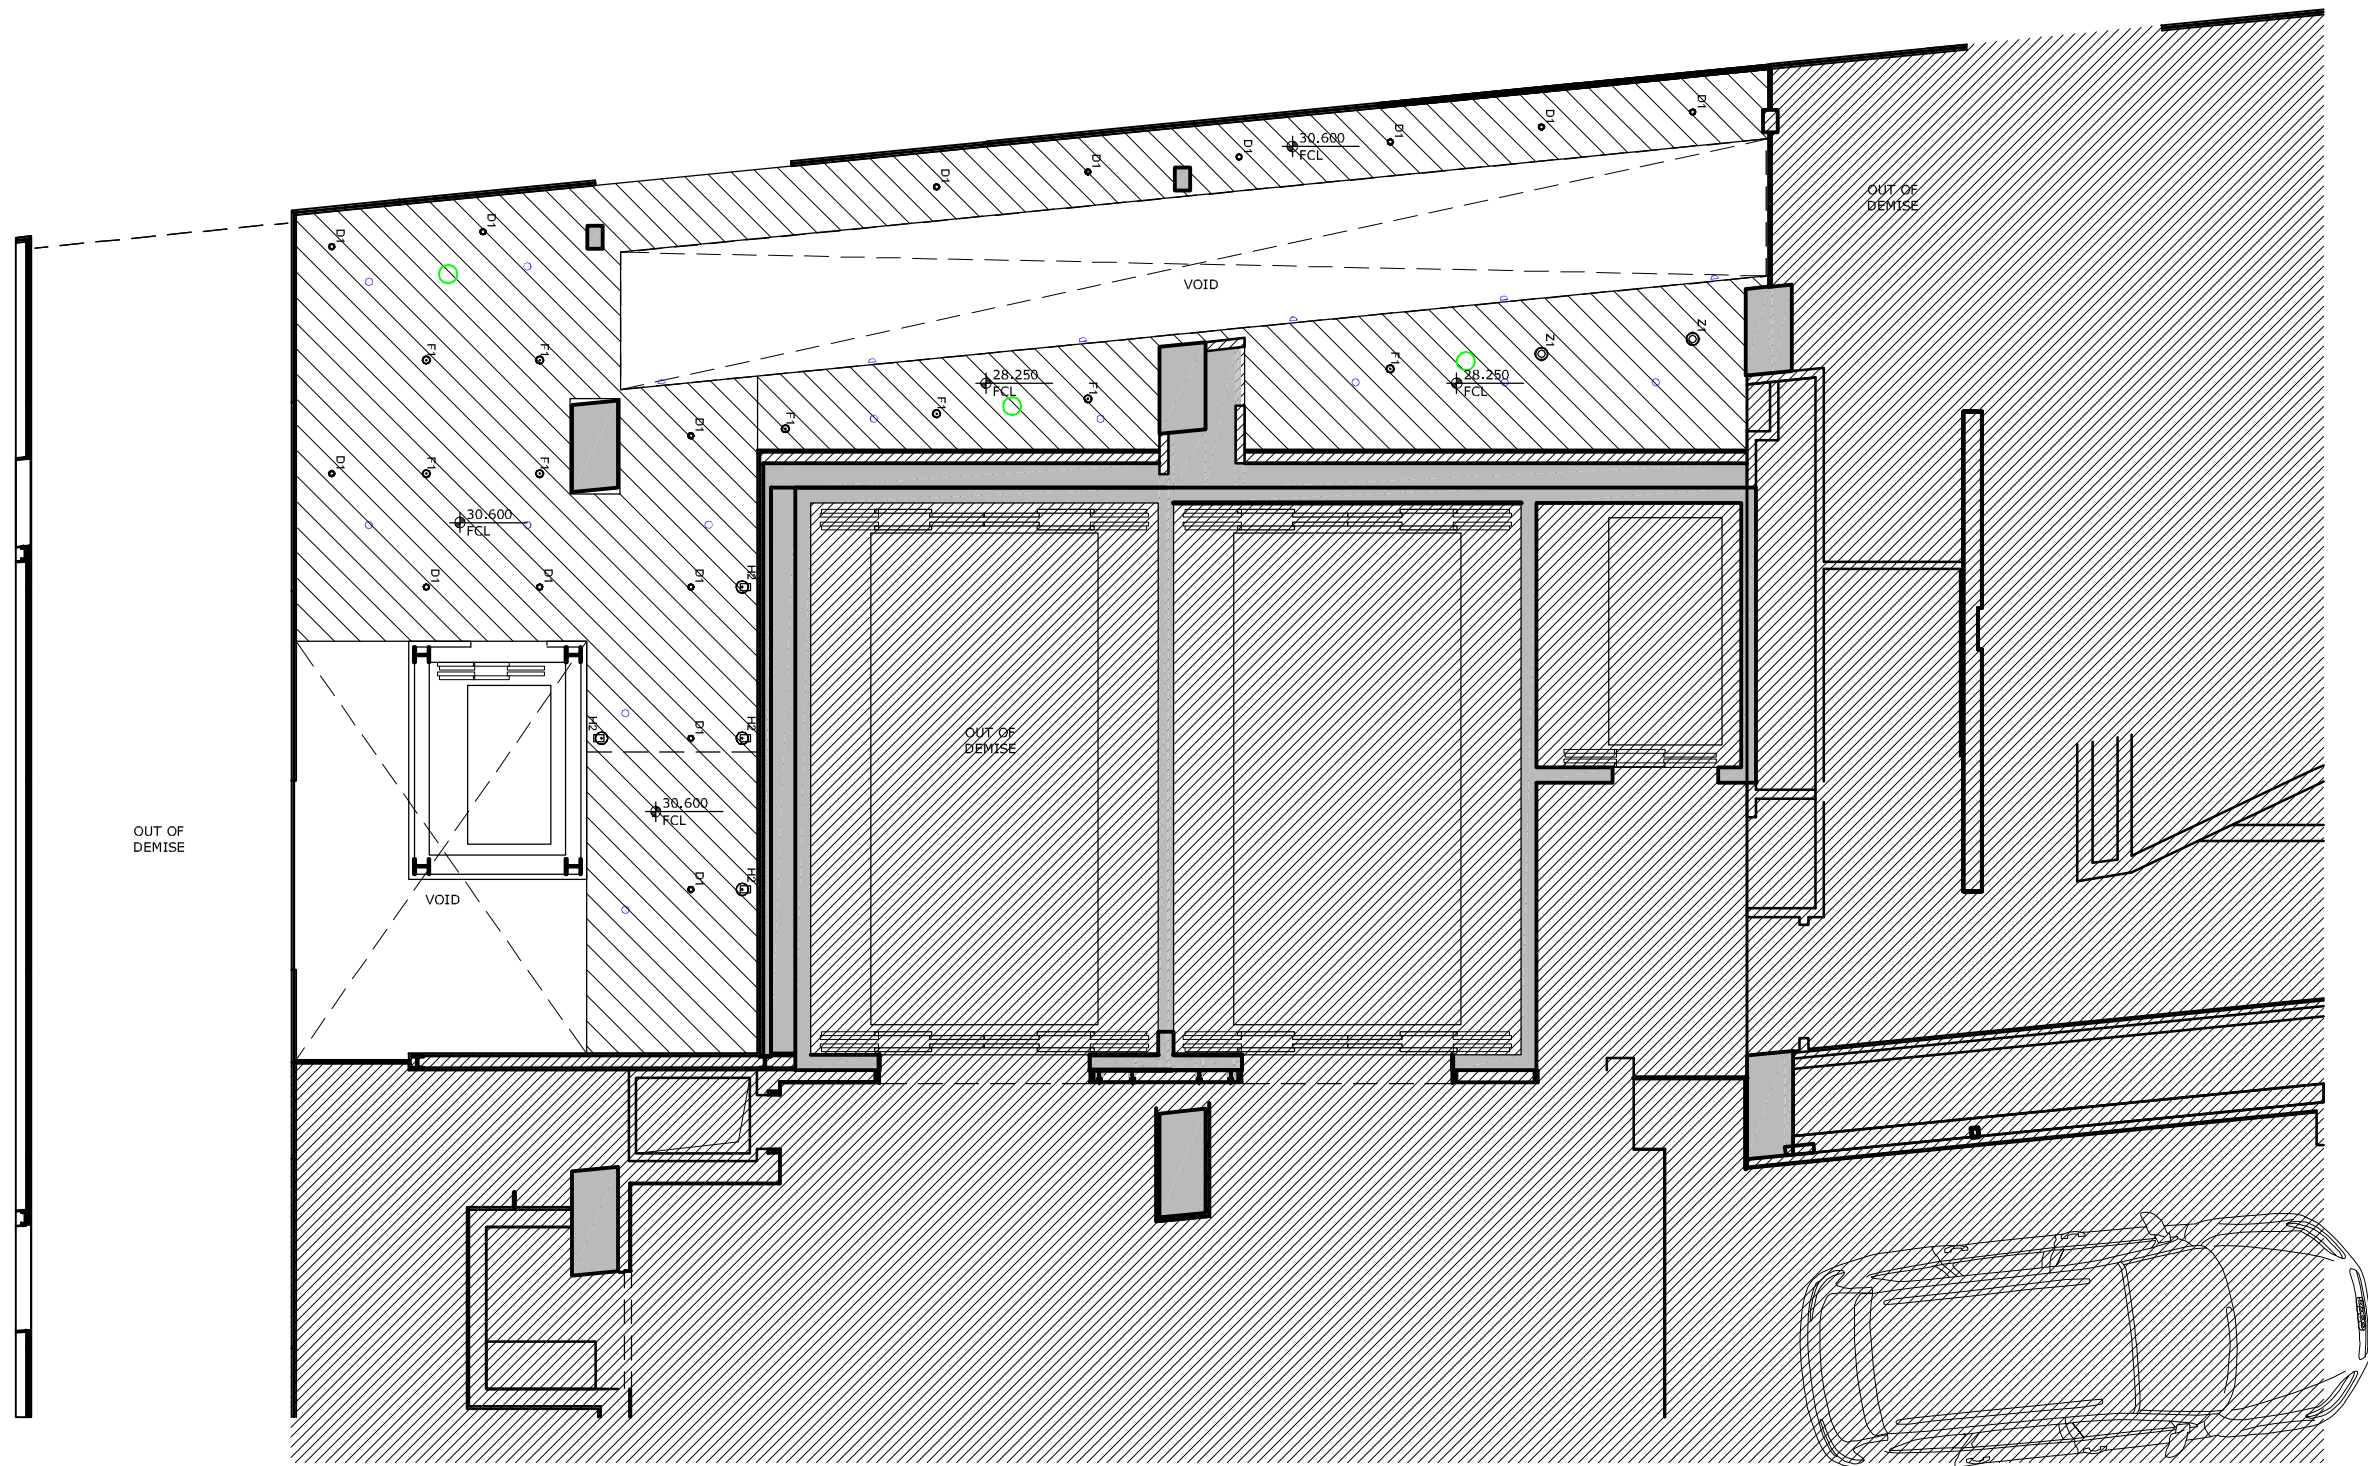
KEY:

-  CEILING TYPE A: MF PLASTERBOARD (K10/220A)
-  SOUNDBLOCK CEILING BY LL
-  CEILING TYPE B: MF PLASTERBOARD, MOISTURE RESISTANT (K10/225A)
-  CEILING TYPE D: SUSPENDED CEILING TILES, HYGIENIC (K40/110)
-  XXXX M
FCL FINISHED CEILING HEIGHT (FCL)

-  C2 RECESSED DOWNLIGHT / WALL WASHER FOR MENU BOARD
-  D1 RECESSED DOWNLIGHT
-  D2 RECESSED DOWNLIGHT FOR KITCHEN WALKING AREA
-  D3 RECESSED DOWNLIGHT FOR WC
-  D5 RECESSED DOWNLIGHT FOR PIZZA OVEN
-  F1 RECESSED DOWNLIGHT FOR HERBARIUM, FEATURE LIGHTING & BAR COUNTER

-  H3 WALL MOUNTED SPOTLIGHT FOR OLIVE TREE/GREEN WALL
-  Z1 RECESSED DOWNLIGHT FOR PASTA MANIFATTURA/ HOOD INTEGRATED
-  LED LED LIGHTING STRIP TO WRAP AROUND THE BOTTOM OF UPPER PORTION OF COLUMN
-  TL SUPPLY POINT FOR TABLE LIGHTING. FOR FINAL LOCATION PLEASE REFER TO TABLE SETTING OUT DRAWING.
-  EH SURFACE MOUNTED DOWNLIGHT FOR GENERAL ILLUMINATION AND EMERGENCY LIGHTING


-  FL FLOOR RECESSED WALL WASHER TO ILLUMINATE THE LOWER PORTION OF THE COLUMNS
-  S SPEAKER - APART CM 20T, CUT OUT Ø 186MM, 80MM DEEP
-  SPRINKLER - REFER TO SERVICE ENGINEER DWGS



GENERAL NOTES:

ALL DIMENSIONS TO BE CHECKED ON SITE
ANY OMISSIONS OR DISCREPANCIES TO BE REPORTED TO THE ARCHITECT IMMEDIATELY IF IN DOUBT ASK

NOTE:
ALL EXPOSED CEILING GRILLES TO BE RAL 9001 TO MATCH CEILING FINISH.
BACK OF HOUSE LIGHTS TO BE SPECIFIED BY SERVICE ENGINEER TO SUIT LAY-IN GRID.
LAY-IN GRID TO BE CENTRED BETWEEN WALLS, OUT TILE > 1/2 TILE.
ACCESS HATCHES WILL BE REQUIRED. REFER TO MECHANICAL ENGINEER DRAWINGS.

-  EXISTING WALLS
-  NEW INTERIOR WALLS

P1	05.06.17	PLANNING	FG
REV	DATE	NOTES	DR
DRAWING STATUS			

PLANNING

CLIENT
VAPIANO®
PASTA | PIZZA | BAR

ARCHITECT
FINKERNAGEL ROSS
Third Floor
Unicorn House
221-222 Shoreditch High Street
London E1 6PJ
Tel: 020 7377 5114
info@finkernagelross.com
www.finkernagelross.com

PROJECT
**VAPIANO LONDON 4
CENTRE POINT
LONDON WC2H**

DRAWING TITLE
**PROPOSED GROUND FLOOR
REFLECTED CEILING PLAN**



 
 

DRAWN	DR. DATE	CHECKED	CH. DATE
FG	11.05.17	ND	15.05.17


 
 

 
 
SCALE	SHEET SIZE
1:100	A3

 
 


 
DRAWING NO	REVISION
VAP-LON4-151	P1

 


1 PROPOSED GROUND FLOOR RCP
1:100 @ A3

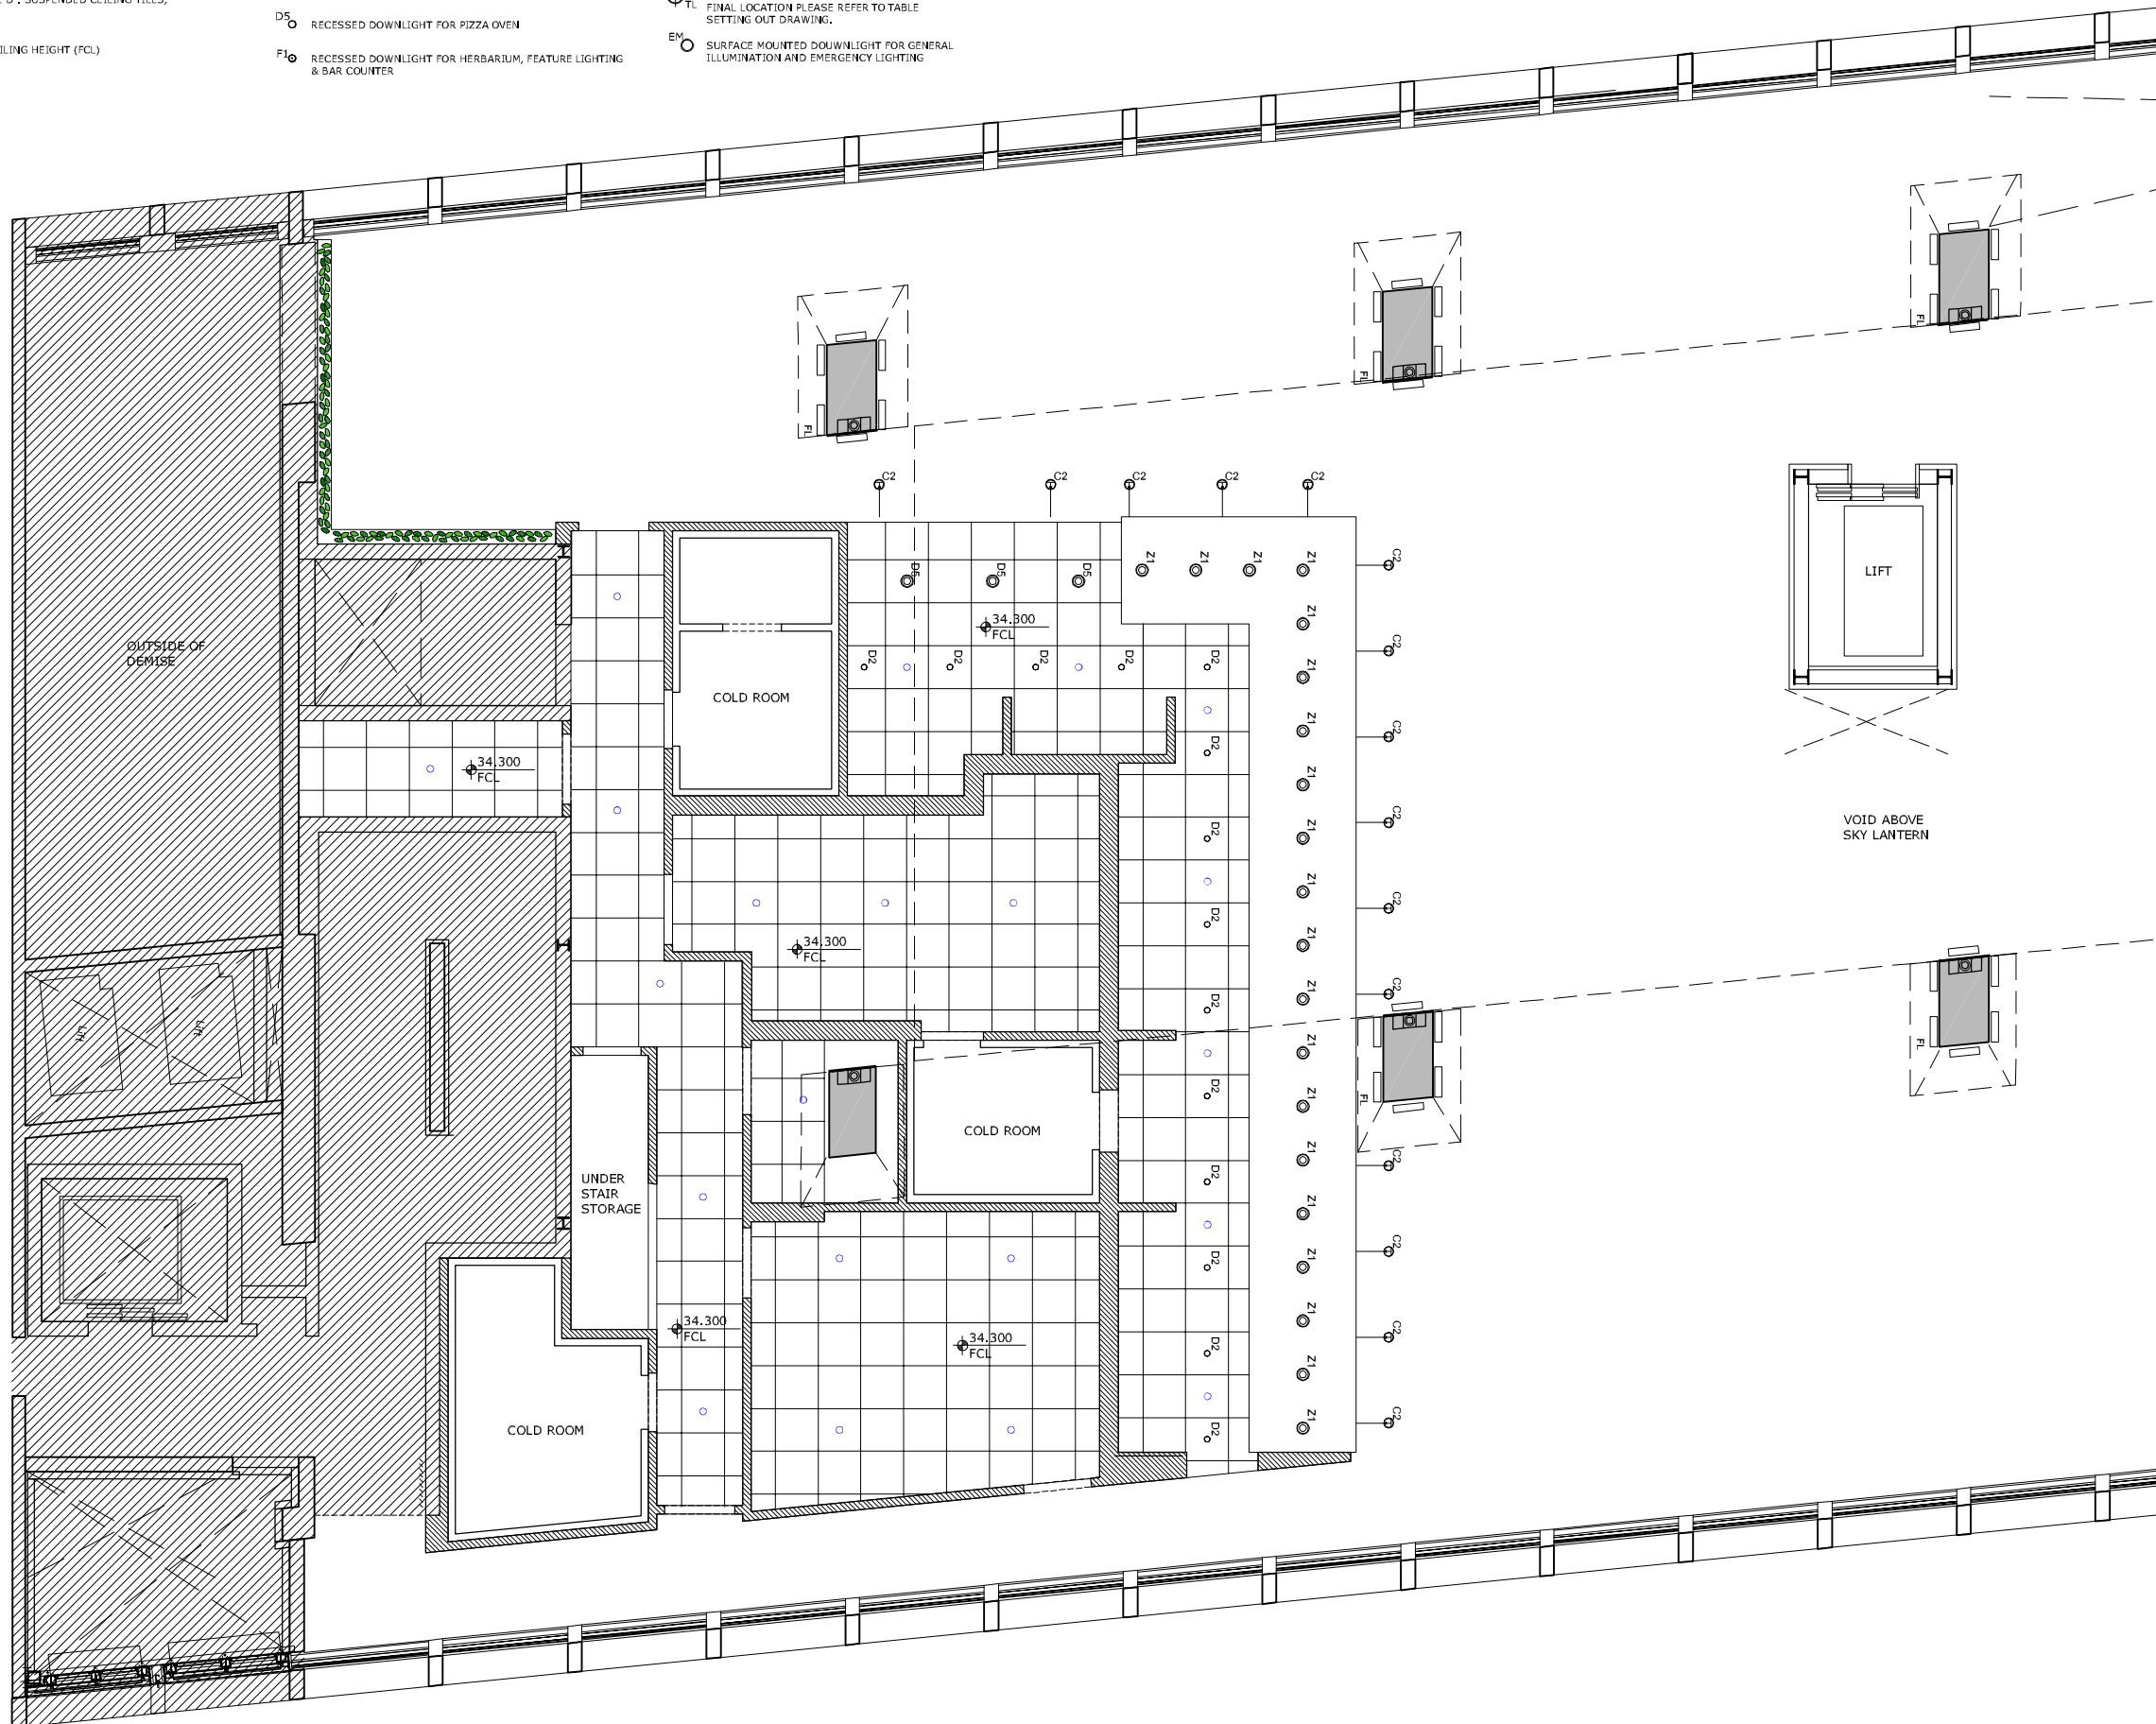
KEY:

-  CEILING TYPE A: MF PLASTERBOARD (K10/220A)
-  SOUNDBLOCK CEILING BY LL
-  CEILING TYPE B: MF PLASTERBOARD, MOISTURE RESISTANT (K10/225A)
-  CEILING TYPE D: SUSPENDED CEILING TILES, HYGIENIC (K40/110)
-  XXXX M FCL FINISHED CEILING HEIGHT (FCL)

-  C2 RECESSED DOWNLIGHT / WALL WASHER FOR MENU BOARD
-  D1 RECESSED DOWNLIGHT
-  D2 RECESSED DOWNLIGHT FOR KITCHEN WALKING AREA
-  D3 RECESSED DOWNLIGHT FOR WC
-  D5 RECESSED DOWNLIGHT FOR PIZZA OVEN
-  F10 RECESSED DOWNLIGHT FOR HERBARIUM, FEATURE LIGHTING & BAR COUNTER

-  H3 WALL MOUNTED SPOTLIGHT FOR OLIVE TREE/GREEN WALL
-  Z1 RECESSED DOWNLIGHT FOR PASTA MANIFATTURA/ HOOD INTEGRATED
-  CS LED LIGHTING STRIP TO WRAP AROUND THE BOTTOM OF UPPER PORTION OF COLUMN
-  TL SUPPLY POINT FOR TABLE LIGHTING, FOR FINAL LOCATION PLEASE REFER TO TABLE SETTING OUT DRAWING.
-  EM SURFACE MOUNTED DOWNLIGHT FOR GENERAL ILLUMINATION AND EMERGENCY LIGHTING

-  FL FLOOR RECESSED WALL WASHER TO ILLUMINATE THE LOWER PORTION OF THE COLUMNS
-  SPEAKER - APART CM 20T, CUT OUT Ø 186MM, 80MM DEEP
-  SPRINKLER - REFER TO SERVICE ENGINEER DWGS





GENERAL NOTES:

ALL DIMENSIONS TO BE CHECKED ON SITE
 ANY OMISSIONS OR DISCREPANCIES TO BE REPORTED TO THE ARCHITECT IMMEDIATELY
 IF IN DOUBT ASK

NOTE:

- ALL EXPOSED CEILING GRILLES TO BE RAL 9001 TO MATCH CEILING FINISH.
- BACK OF HOUSE LIGHTS TO BE SPECIFIED BY SERVICE ENGINEER TO SUIT LAY-IN GRID.
- LAY-IN GRID TO BE CENTRED BETWEEN WALLS, CUT TILE > 1/2 TILE.
- ACCESS HATCHES WILL BE REQUIRED. REFER TO MECHANICAL ENGINEER DRAWINGS.

-  EXISTING WALLS
-  NEW INTERIOR WALLS

P2	16.06.17	AMENDMENT	FC
P1	05.06.17	PLANNING	FC
REV	DATE	NOTES	DF
DRAWING STATUS			

PLANNING

CLIENT



ARCHITECT

FINKERNAGEL ROSS

Third Floor
 Unicom House
 221-222 Shoreditch High Street
 London E1 6PJ

Tel: 020 7377 5114
 info@finkernagelross.com
 www.finkernagelross.com

PROJECT

**VAPIANO LONDON 4
 CENTRE POINT
 LONDON WC2H**

DRAWING TITLE

**PROPOSED FIRST FLOOR
 REFLECTED CEILING PLAN**

 

 
 
 
DRAWN	DR. DATE	CHECKED	CH. DATE
FG	11.05.17	ND	15.05.17

 
 
 

 
 
SCALE	SHEET SIZE
1:100	A3

 
 


 
DRAWING NO	REVISION
VAP-LON4-152	P2




1 PART FIRST FLOOR RCP
 1:100 @ A3

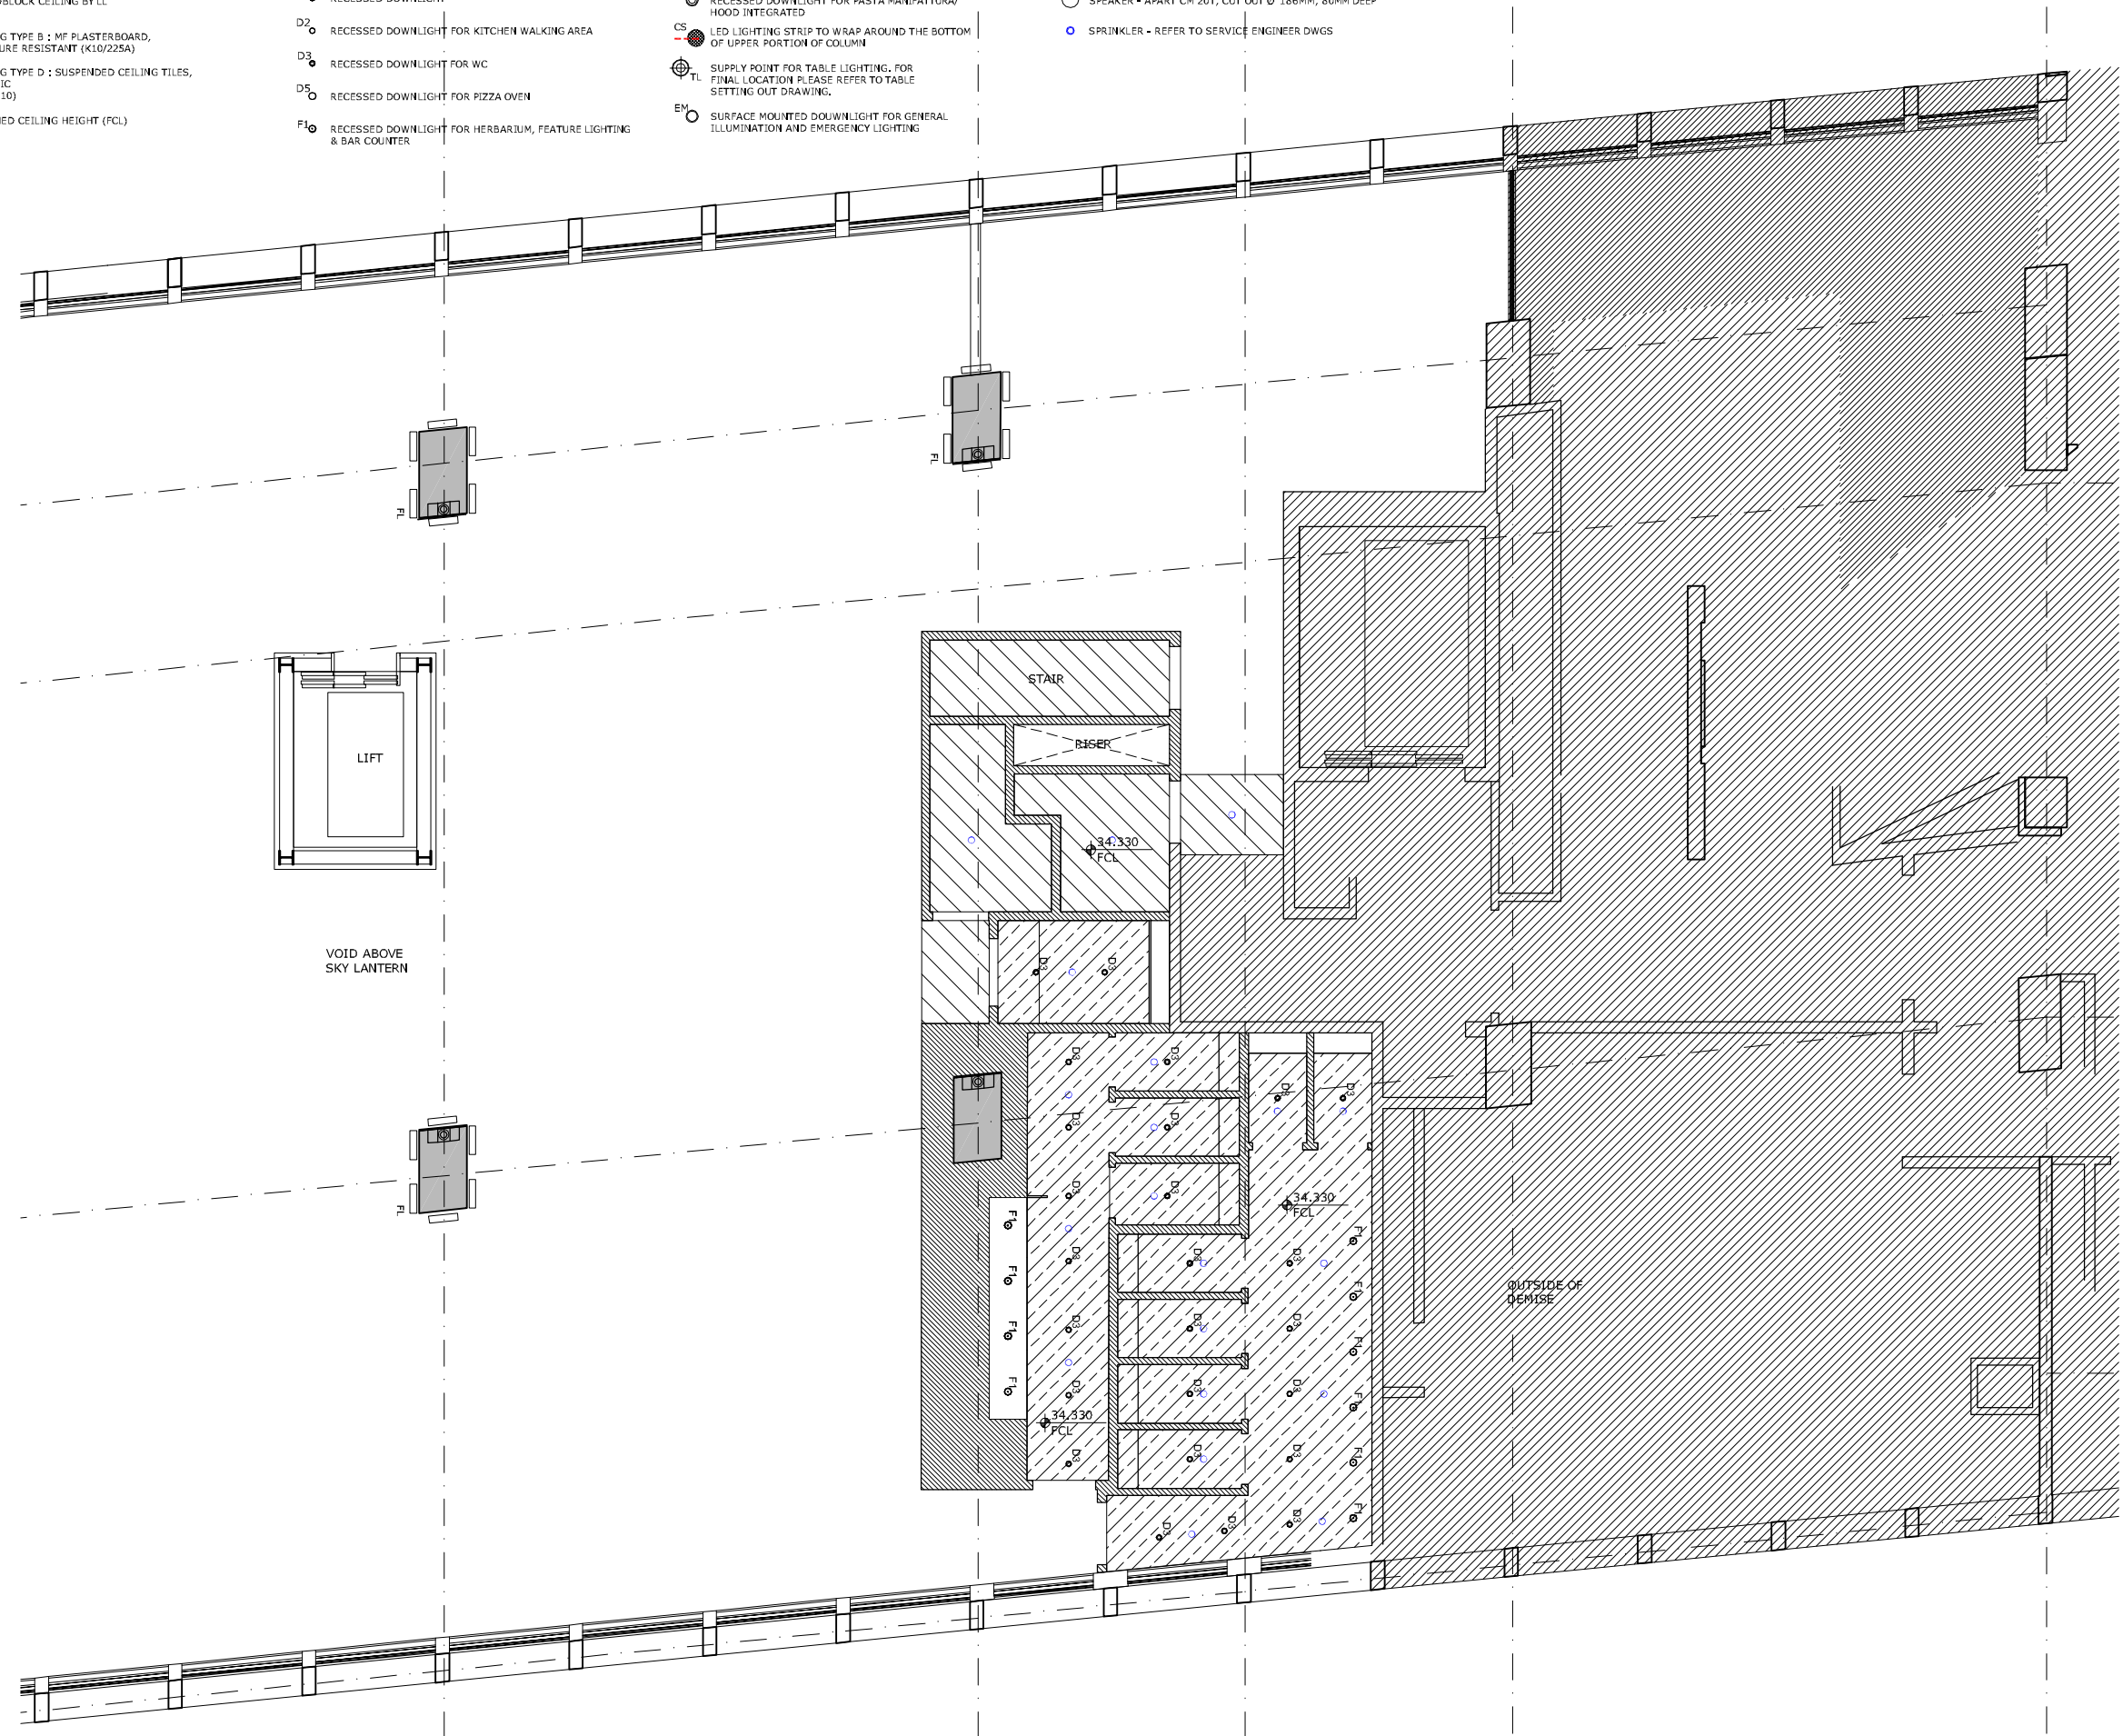
KEY:

-  CEILING TYPE A: MF PLASTERBOARD (K10/220A)
-  SOUNDBLOCK CEILING BY LL
-  CEILING TYPE B: MF PLASTERBOARD, MOISTURE RESISTANT (K10/225A)
-  CEILING TYPE D: SUSPENDED CEILING TILES, HYGENIC (K40/110)
-  XXXX M
FCL
FINISHED CEILING HEIGHT (FCL)

-  C2 RECESSED DOWNLIGHT / WALL WASHER FOR MENU BOARD
-  D1 RECESSED DOWNLIGHT
-  D2 RECESSED DOWNLIGHT FOR KITCHEN WALKING AREA
-  D3 RECESSED DOWNLIGHT FOR WC
-  D5 RECESSED DOWNLIGHT FOR PIZZA OVEN
-  F1 RECESSED DOWNLIGHT FOR HERBARIUM, FEATURE LIGHTING & BAR COUNTER

-  H3 WALL MOUNTED SPOTLIGHT FOR OLIVE TREE/GREEN WALL
-  Z1 RECESSED DOWNLIGHT FOR PASTA MANIFATTURA/ HOOD INTEGRATED
-  CS LED LIGHTING STRIP TO WRAP AROUND THE BOTTOM OF UPPER PORTION OF COLUMN
-  TL SUPPLY POINT FOR TABLE LIGHTING. FOR FINAL LOCATION PLEASE REFER TO TABLE SETTING OUT DRAWING.
-  EM SURFACE MOUNTED DOWNLIGHT FOR GENERAL ILLUMINATION AND EMERGENCY LIGHTING


 
-  FL FLOOR RECESSED WALL WASHER TO ILLUMINATE THE LOWER PORTION OF THE COLUMNS
-  SPEAKER - APART CM 20T, CUT OUT Ø 186MM, 80MM DEEP
-  SPRINKLER - REFER TO SERVICE ENGINEER DWGS



GENERAL NOTES:

ALL DIMENSIONS TO BE CHECKED ON SITE
 ANY OMISSIONS OR DISCREPANCIES TO BE REPORTED TO THE ARCHITECT IMMEDIATELY IF IN DOUBT ASK

NOTE:
 ALL EXPOSED CEILING GRILLES TO BE RAL 9001 TO MATCH CEILING FINISH.
 BACK OF HOUSE LIGHTS TO BE SPECIFIED BY SERVICE ENGINEER TO SUIT LAY-IN GRID.
 LAY-IN GRID TO BE CENTRED BETWEEN WALLS, OUT TILE > 1/2 TILE.
 ACCESS HATCHES WILL BE REQUIRED. REFER TO MECHANICAL ENGINEER DRAWINGS.

-  EXISTING WALLS
-  NEW INTERIOR WALLS

P2	13.06.17	LISTED BUILDING CONSENT	FG
P1	05.06.17	PLANNING	FG
REV	DATE	NOTES	DR
DRAWING STATUS			

PLANNING

CLIENT

VAPIANO®
 PASTA | PIZZA | BAR

ARCHITECT

FINKERNAGEL ROSS

Third Floor
 Unicorn House
 221-222 Shoreditch High Street
 London E1 6PJ

Tel: 020 7377 5114
 info@finkernagelross.com
 www.finkernagelross.com

PROJECT

**VAPIANO LONDON 4
 CENTRE POINT
 LONDON WC2H**

DRAWING TITLE

**PROPOSED FIRST FLOOR
 REFLECTED CEILING PLAN**

 

 
 
 
DRAWN	DR. DATE	CHECKED	CH. DATE
FG	11.05.17	ND	15.05.17

 
 
 


 
SCALE	SHEET SIZE
1:100	A3

 
 


 
DRAWING NO	REVISION
VAP-LON4-153	P2




1 PART FIRST FLOOR RCP
 1:100 @ A3

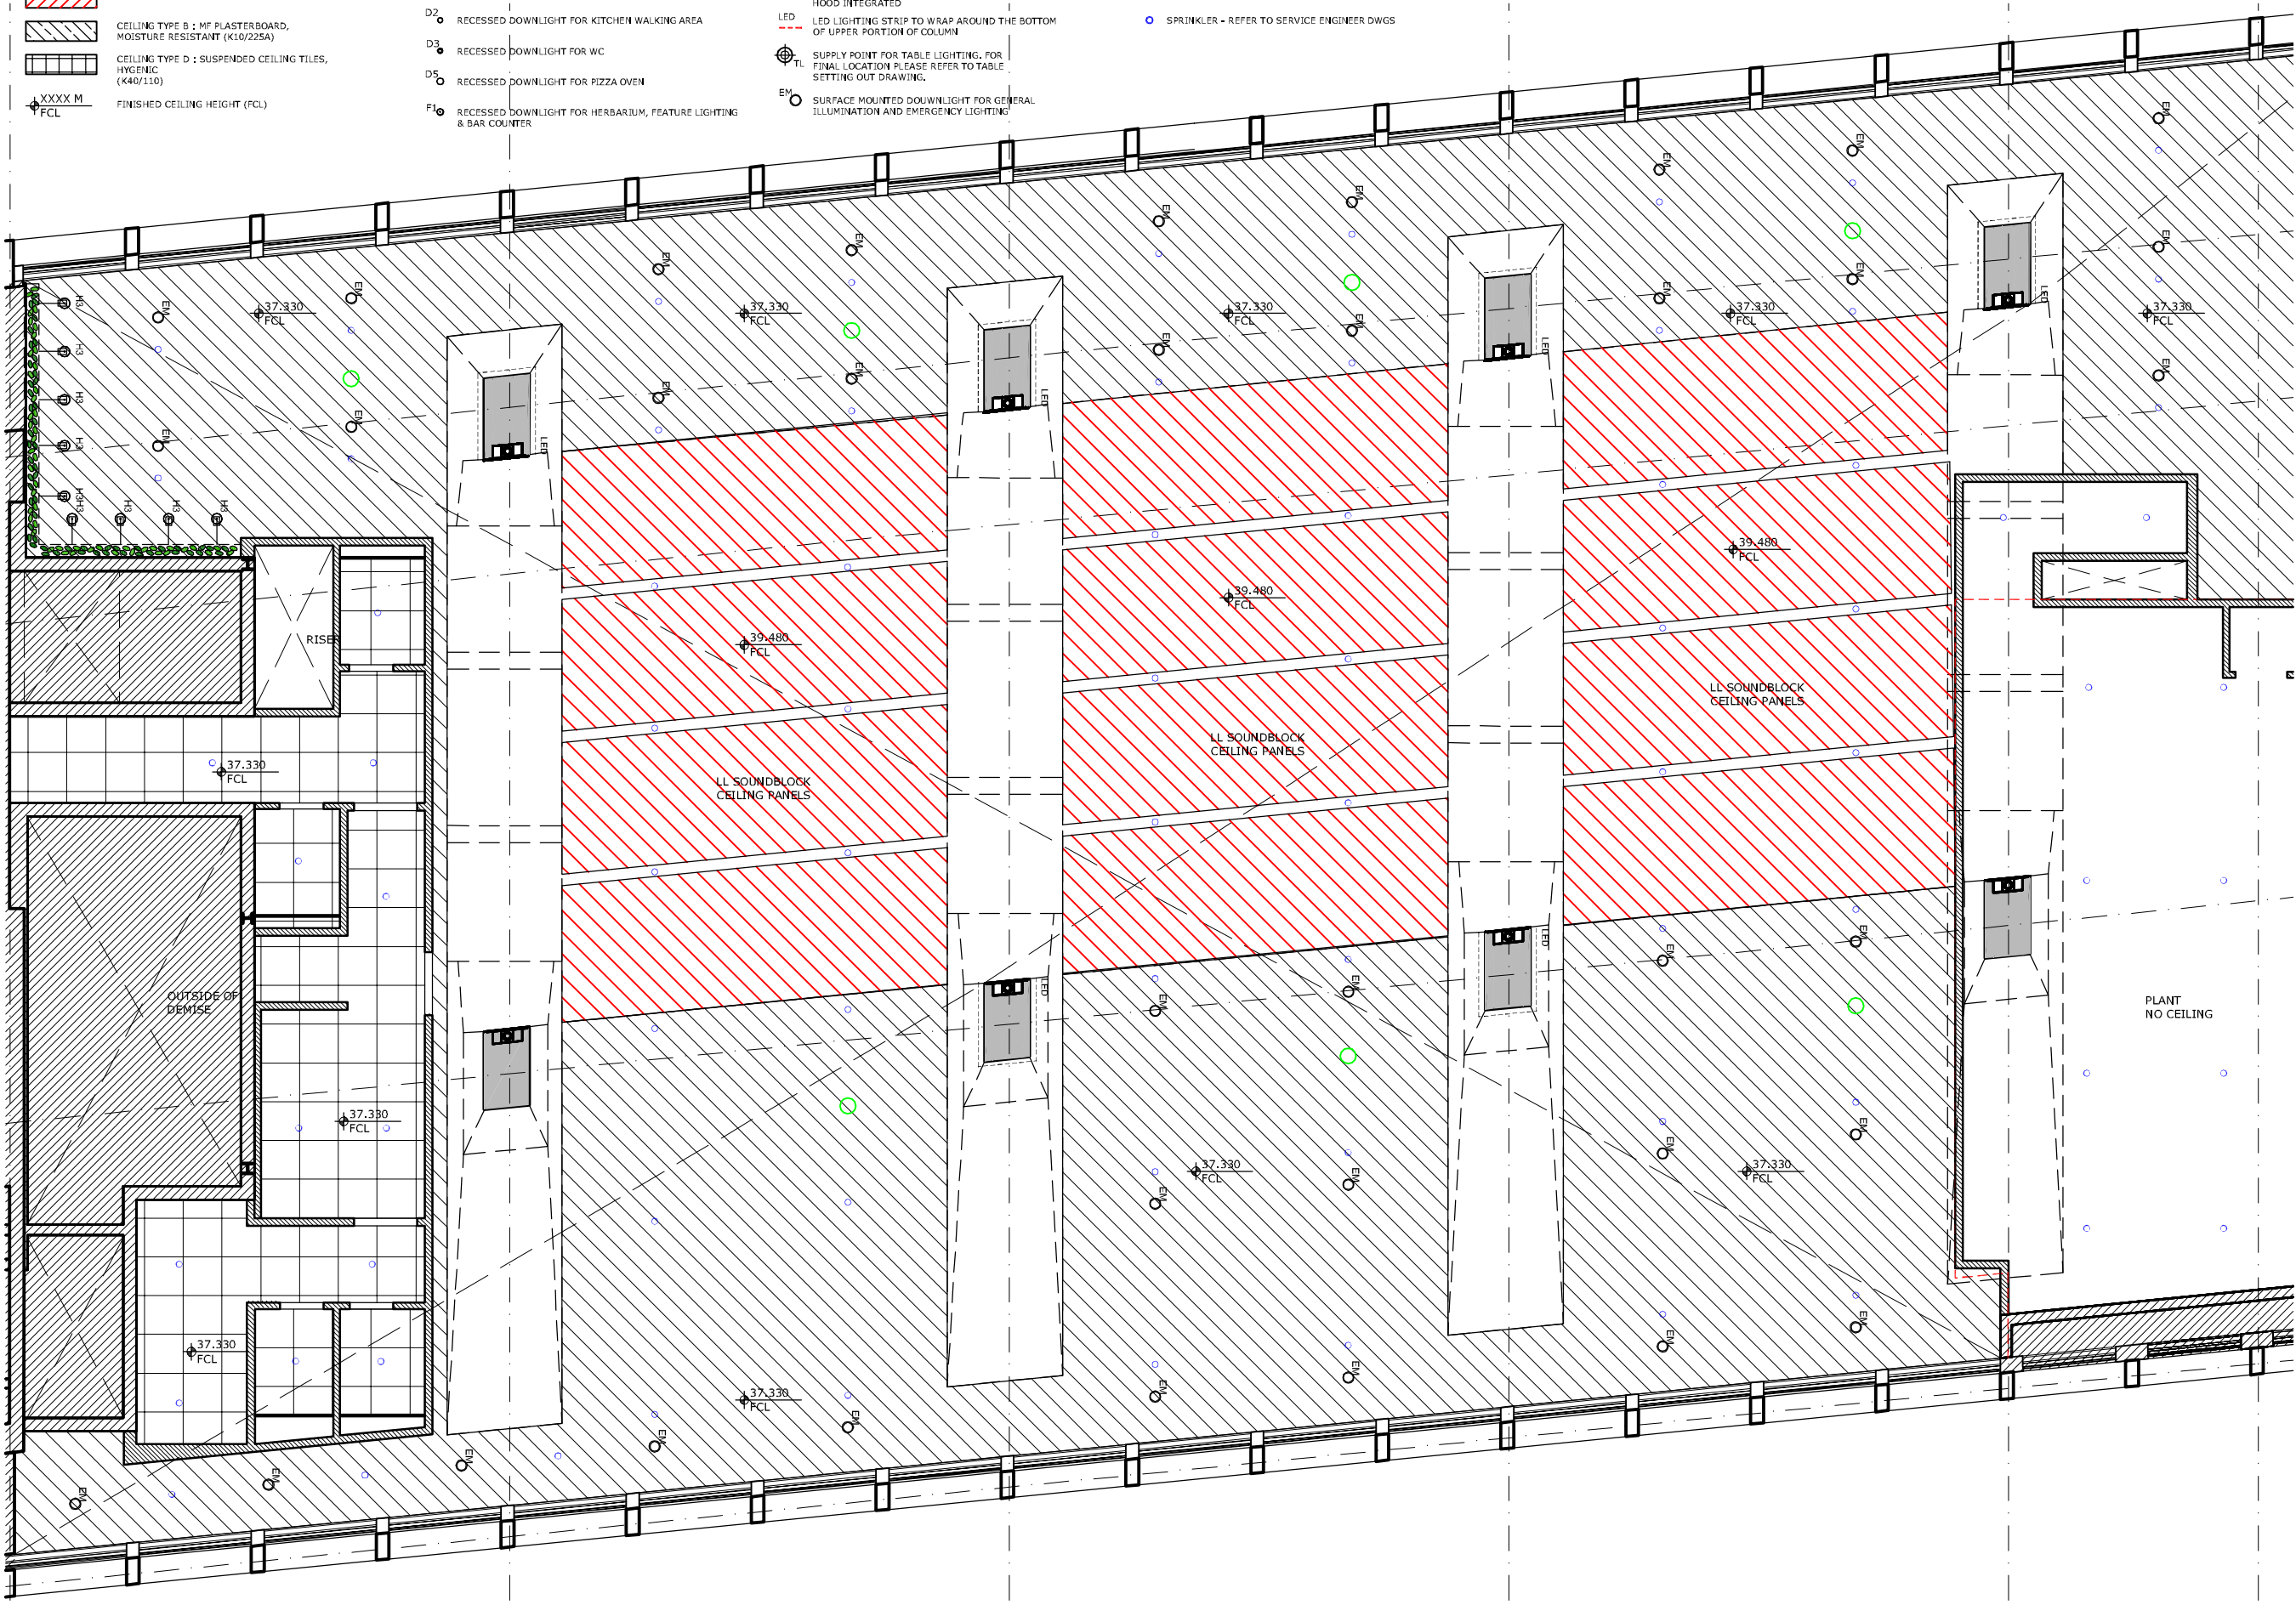
KEY:

-  CEILING TYPE A: MF PLASTERBOARD (K10/220A)
-  SOUNDBLOCK CEILING BY LL
-  CEILING TYPE B: MF PLASTERBOARD, MOISTURE RESISTANT (K10/225A)
-  CEILING TYPE D: SUSPENDED CEILING TILES, HYGIENIC (K40/110)
-  XXXX M FCL FINISHED CEILING HEIGHT (FCL)

-  C2 RECESSED DOWNLIGHT / WALL WASHER FOR MENU BOARD
-  D1 RECESSED DOWNLIGHT
-  D2 RECESSED DOWNLIGHT FOR KITCHEN WALKING AREA
-  D3 RECESSED DOWNLIGHT FOR WC
-  D5 RECESSED DOWNLIGHT FOR PIZZA OVEN
-  F1 RECESSED DOWNLIGHT FOR HERBARIUM, FEATURE LIGHTING & BAR COUNTER



-  H3 WALL MOUNTED SPOTLIGHT FOR OLIVE TREE/GREEN WALL
-  Z1 RECESSED DOWNLIGHT FOR PASTA MANIFATTURA/ HOOD INTEGRATED
-  LED LED LIGHTING STRIP TO WRAP AROUND THE BOTTOM OF UPPER PORTION OF COLUMN
-  TL SUPPLY POINT FOR TABLE LIGHTING. FOR FINAL LOCATION PLEASE REFER TO TABLE SETTING OUT DRAWING.
-  EH SURFACE MOUNTED DOWNLIGHT FOR GENERAL ILLUMINATION AND EMERGENCY LIGHTING

-  FL FLOOR RECESSED WALL WASHER TO ILLUMINATE THE LOWER PORTION OF THE COLUMNS
-  S SPEAKER - APART CM 20T, CUT OUT Ø 186MM, 80MM DEEP
-  SP SPRINKLER - REFER TO SERVICE ENGINEER DWGS



GENERAL NOTES:
 DO NOT SCALE FROM THIS DRAWING
 ALL DIMENSIONS TO BE CHECKED ON SITE
 ANY OMISSIONS OR DISCREPANCIES TO BE REPORTED TO THE ARCHITECT IMMEDIATELY IF IN DOUBT ASK

NOTE:
 ALL EXPOSED CEILING GRILLES TO BE RAL 9001 TO MATCH CEILING FINISH.
 BACK OF HOUSE LIGHTS TO BE SPECIFIED BY SERVICE ENGINEER TO SUIT LAY-IN GRID.
 LAY-IN GRID TO BE CENTRED BETWEEN WALLS, CUT TILE > 1/2 TILE.
 ACCESS HATCHES WILL BE REQUIRED, REFER TO MECHANICAL ENGINEER DRAWINGS.

-  EXISTING WALLS
-  NEW INTERIOR WALLS

P1	05.06.17	PLANNING	FG
REV	DATE	NOTES	DR
DRAWING STATUS			

PLANNING

CLIENT

VAPIANO®
 PASTA | PIZZA | BAR

ARCHITECT

FINKERNAGEL ROSS

Third Floor
 Unicorn House
 221-222 Shoreditch High Street
 London E1 6PJ

Tel: 020 7377 5114
 info@finkernagelross.com
 www.finkernagelross.com

PROJECT

**VAPIANO LONDON 4
 CENTER POINT
 LONDON WC 2H**

DRAWING TITLE

**PROPOSED GROUND FLOOR
 REFLECTED CEILING PLAN**

DRAWN	DR. DATE	CHECKED	CH. DATE
FG	11.05.17	ND	15.05.17

SCALE	SHEET SIZE
1:100	A3

DRAWING NO	REVISION
VAP-LON4-151	P1

1 MEZZANINE RCP
 1:100 @ A3