


**GA** FOURTH FLOOR ROOF PLAN - PLAN  
SCALE 1:20



INDICATIVE RED LINE FOR PROPOSED LOCATION OF NEW AC CONDENSER UNIT  
**FOURTH FLOOR ROOF PLAN - OVERVIEW CONDENSER UNIT LOCATION**  
SCALE NTS

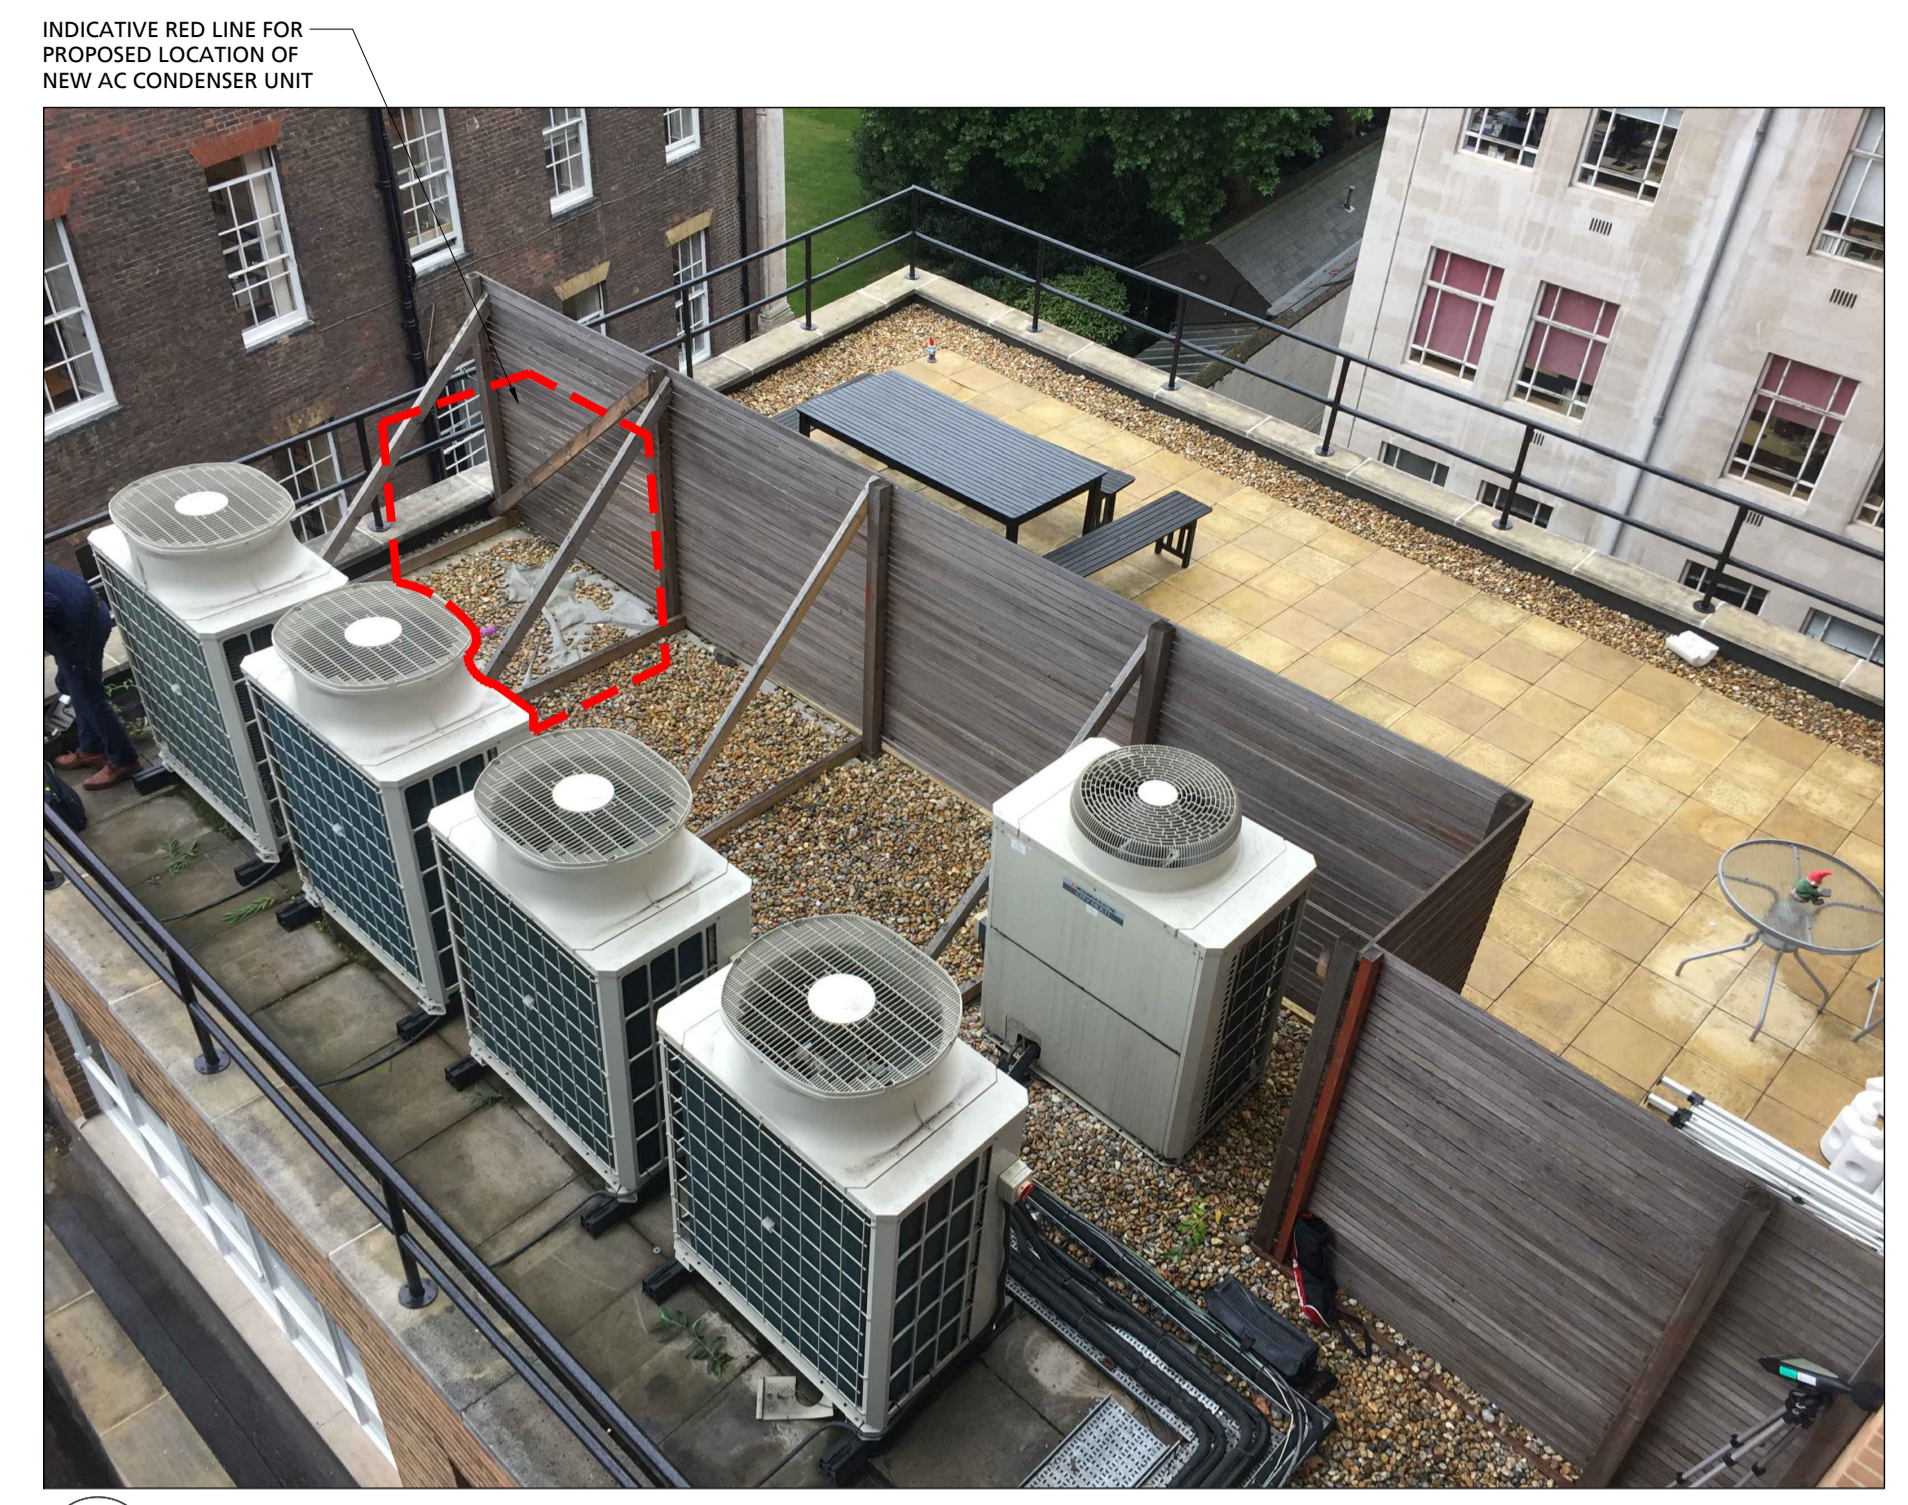


INDICATIVE RED LINE FOR PROPOSED LOCATION OF NEW AC CONDENSER UNIT ALIGNED WITH LAST UNIT POSITION  
**CONDENSER UNIT LOCATION**  
SCALE NTS



ADJACENT BUILDING ELEVATION BEYOND PLANT ENCLOSURE TO THE SOUTH  
**FOURTH FLOOR ROOF PLAN - ELEVATION VIEW BEYOND**  
SCALE NTS



**01** FOURTH FLOOR ROOF PLAN - SOUTH ELEVATION 01  
SCALE 1:50

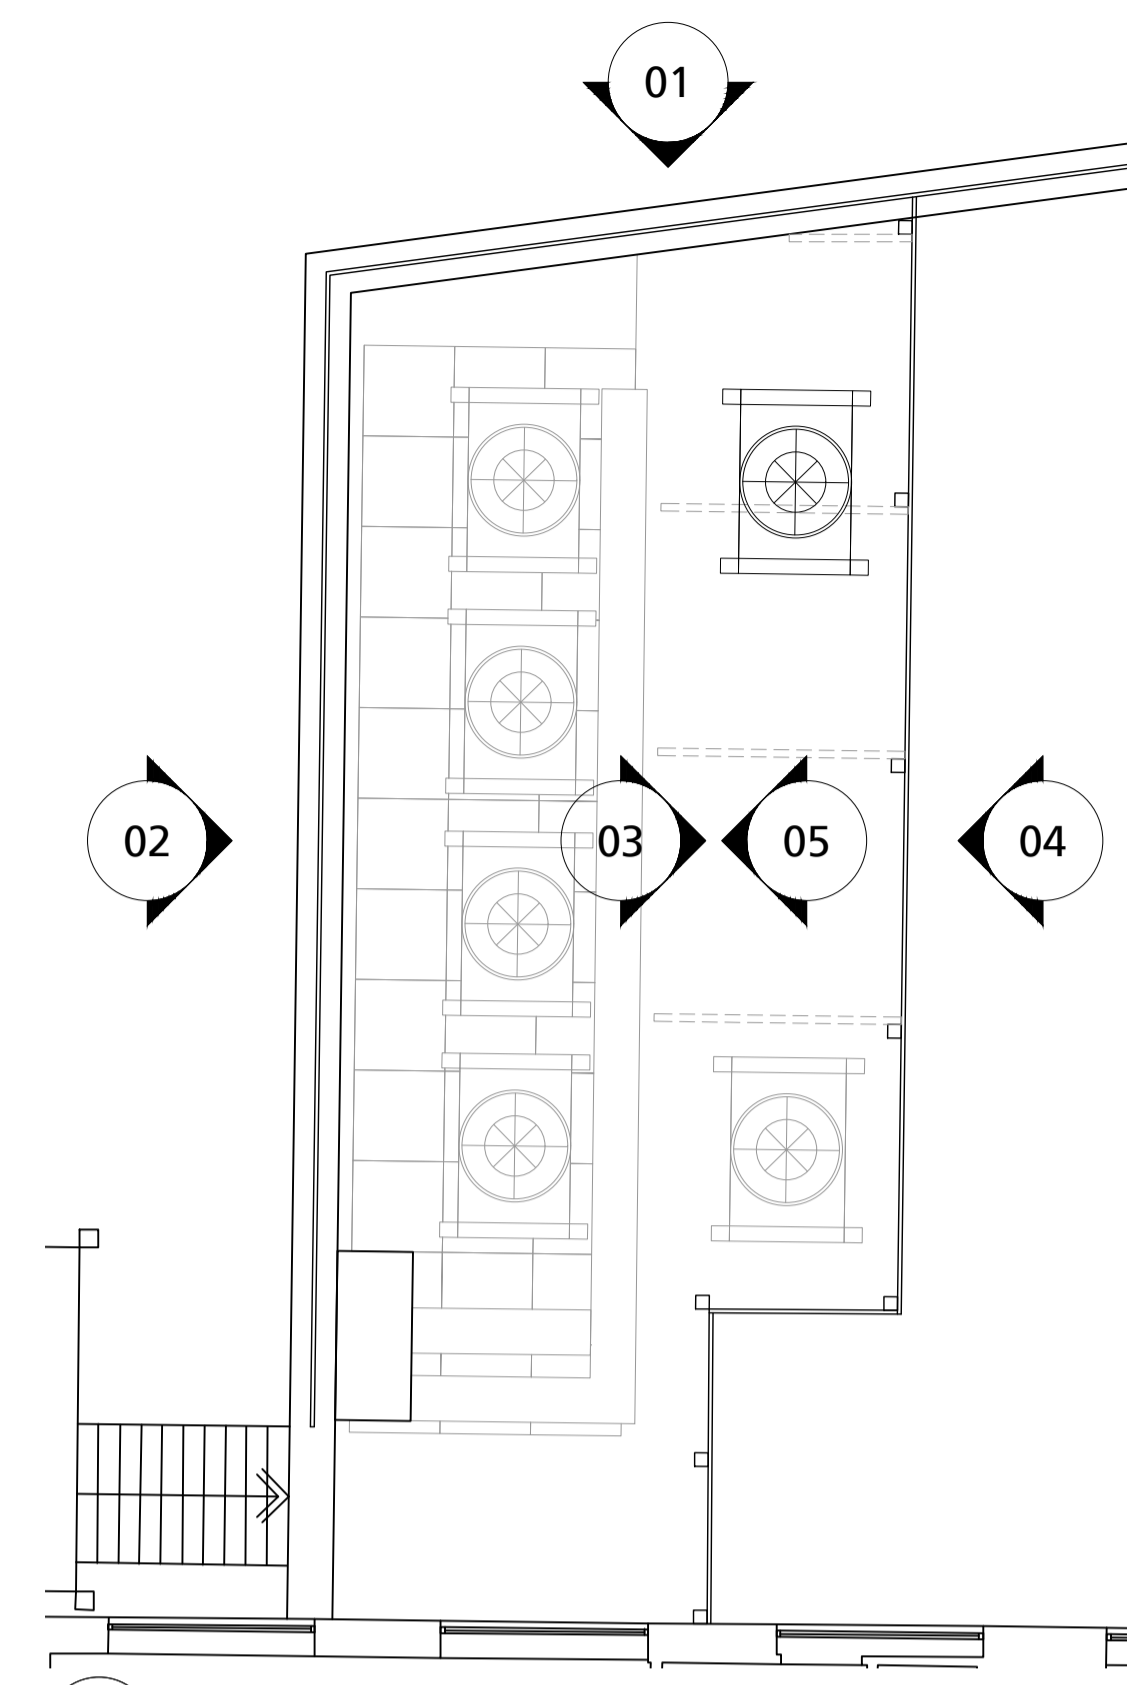

**RP** FOURTH FLOOR ROOF PLAN - KEY PLAN  
SCALE 1:50

THIS DRAWING IS PROTECTED UNDER COPYRIGHT. THIS DRAWING IS NOT TO BE REPRODUCED IN WHOLE OR PART UNLESS AUTHORISED BY **area** © COPYRIGHT. THIS DRAWING IS NOT TO BE SCALED. THE GENERAL CONTRACTOR IS TO CHECK ALL DIMENSIONS AND NOTIFY THE DESIGNER OF ANY DISCREPANCIES OR OMISSIONS.

DRAWING TO BE READ IN CONJUNCTION WITH SCOPE OF WORKS

CEILING HEIGHT	-	
BEAM HEIGHT	-	
WINDOW HEIGHT	-	
SILL HEIGHT	-	

THIS DRAWING IS ON RECYCLED PAPER

03.08.17	-	DRAWING FIRST ISSUED	DB	TK
DATE	REV	REVISIONS	SIGN	CHKD

**area**

The Old Post Office  
33 Station Road,  
Egham,  
Surrey TW20 9LA  
T. 01784 274000

5th Floor,  
Counting House,  
53 Tooley Street,  
London SE1 2QN  
T. 020 7089 6000

info@areasq.co.uk    www.areasq.co.uk

DRAWING STATUS  
**INFORMATION ONLY**

CLIENT  
**ELECTRALINK**

PROJECT  
**3RD FLOOR  
NORTHUMBERLAND HOUSE  
303-306 HIGH HOLBORN  
LONDON  
WC1**

TITLE  
**ROOF PLAN PLAN & ELEVATION  
FOURTH FLOOR**

SCALE 1:50 @ A1

DATE	-	DRAWN	DB	CHECKED	GW
------	---	-------	----	---------	----

PROJECT NO	BLDG.	FLOOR	DETAIL	REV.
AR18288	2	4	EL1	-