
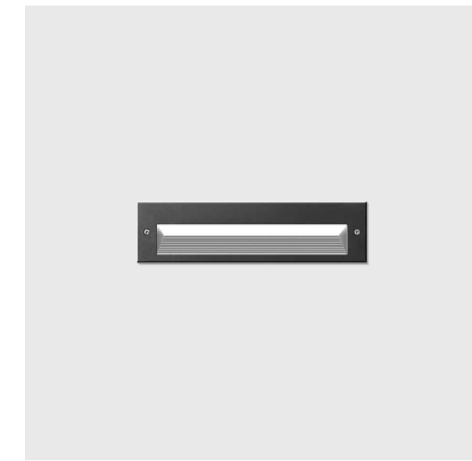



Proposed 600mm High Bollard Light
Product: 77239 ground /77249 podium
Supplier: BEGA

01 Reference Images - BL Bollard Light
Scale NTS

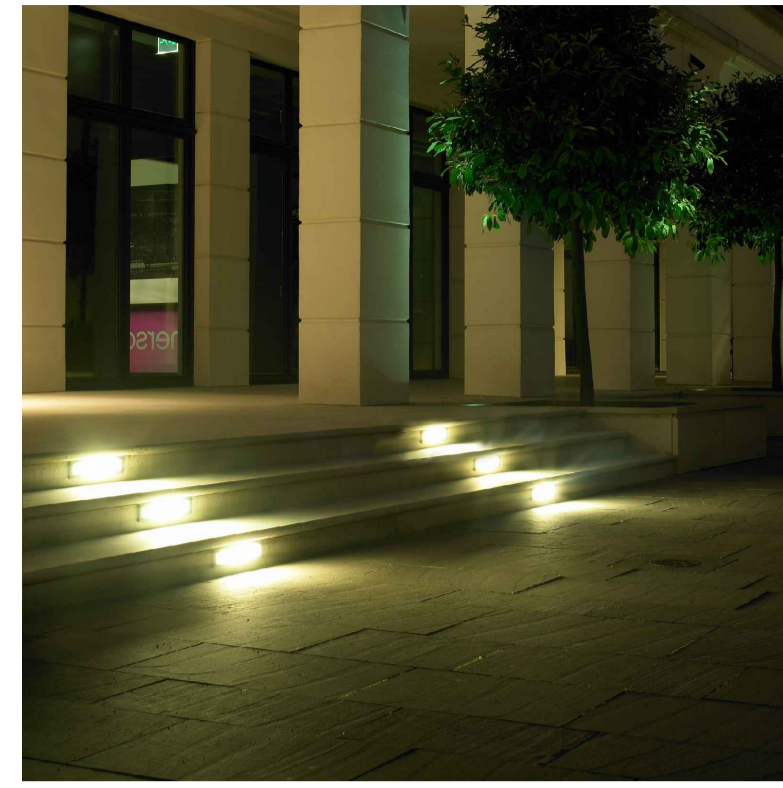



Proposed Recessed Light to Steps & Ramps
Product: 33054
Supplier: BEGA

02 Reference Images - SL Step Light
Scale NTS

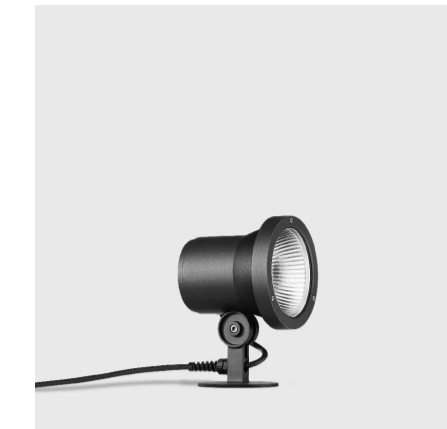


Proposed Spike Mounted Flood light
Product: 77326
Supplier: BEGA

03 Reference Images - UL Tree Up-lighter
Scale NTS

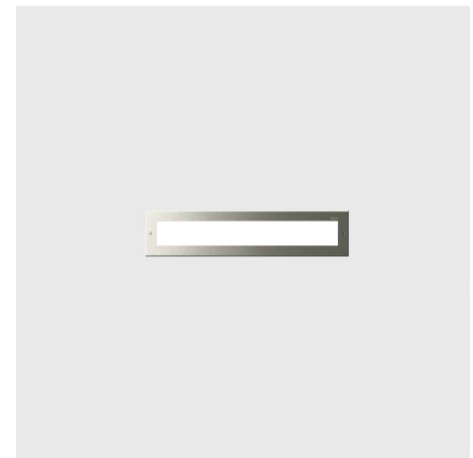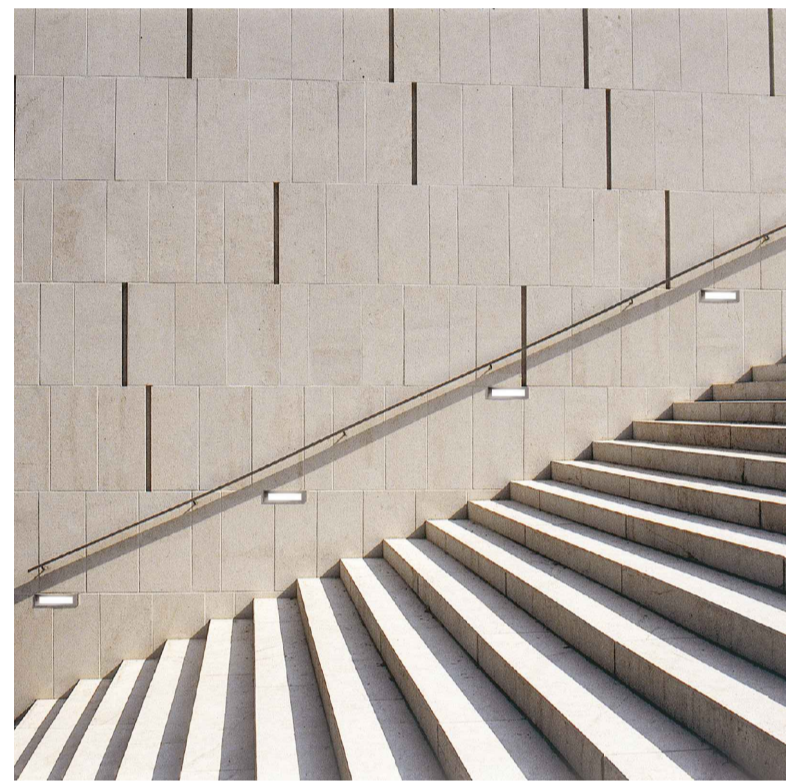


Proposed Recessed Luminaire to Planter Wall
Product: 33172
Supplier: BEGA

04 Reference Images - RL Recessed Light
Scale NTS

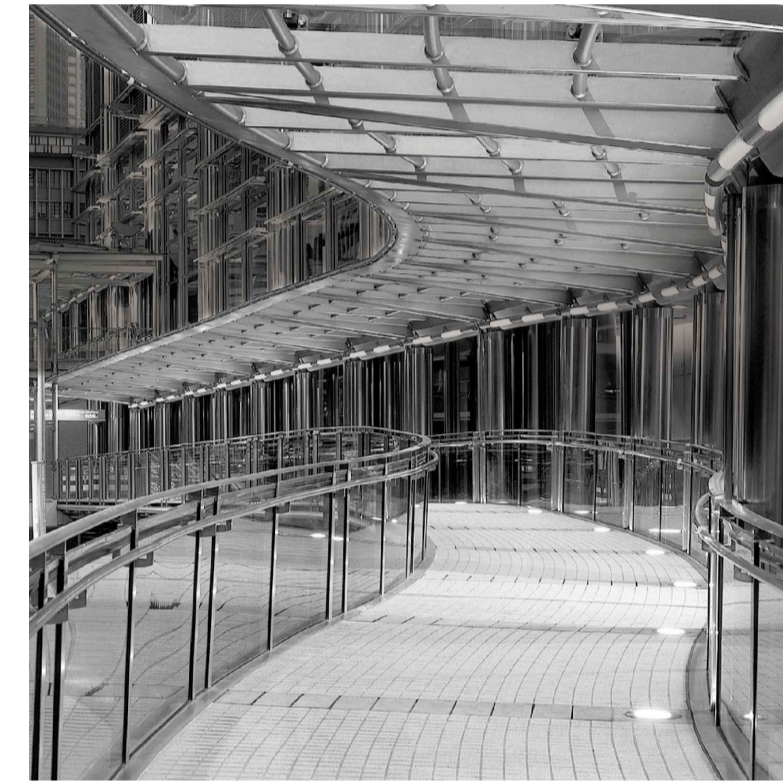


Proposed Ground Recessed Uplight
Product: 77163
Supplier: BEGA

05 Reference Images - GU Ground Recessed Uplight
Scale NTS

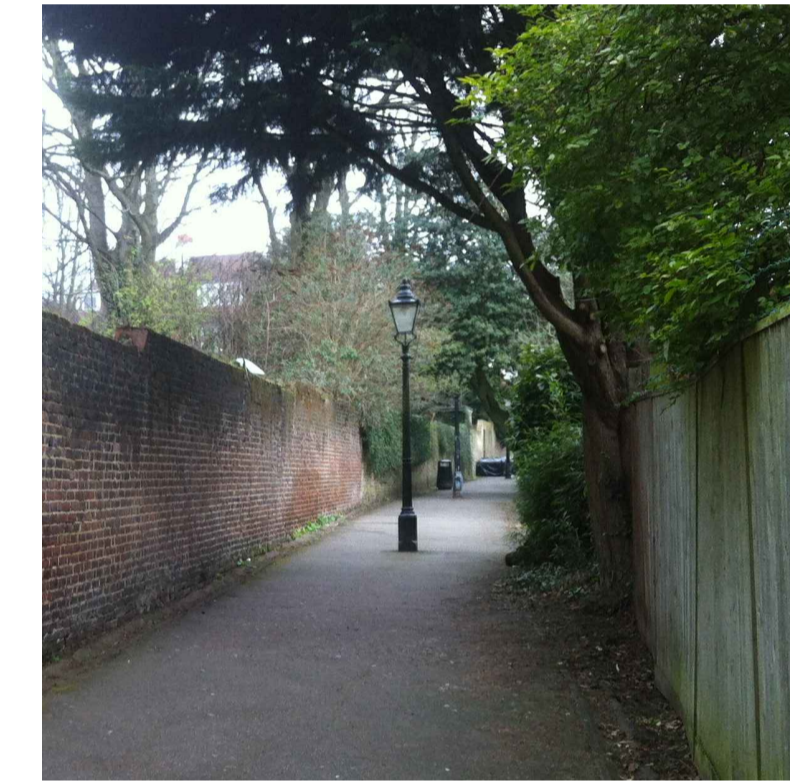

Existing Lighting Column - To Be Retained

06 Reference Image - EL Retained Lamp Posts in Croft Way
Scale NTS

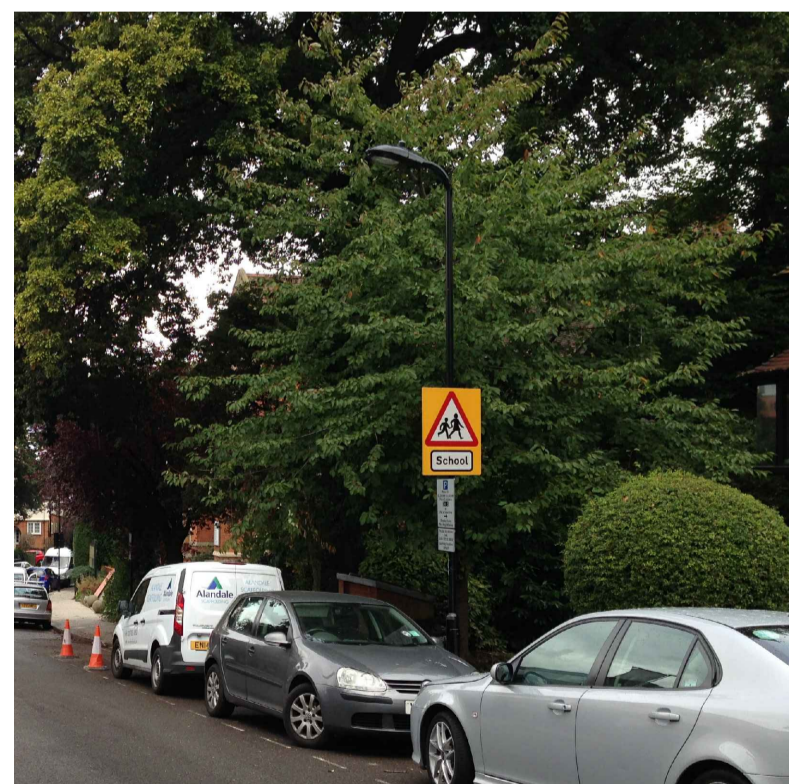

Existing Column Lighting to be Relocated

07 Reference Image - LP-R Existing Street Lighting Column to be Repositioned
Scale NTS



Proposed Column Light
Product: Crown Asymmetrical on 4m column
Supplier: iGuzzini

08 Reference Images - LC Column Light
Scale NTS

Notes:
Refer to MKP specification, wiring details and luminaire schedule.

This sheet to be read in conjunction with dwgs 9300-DRG-DE029 Lighting Installation Typical Details, 9300-DRG-PE009 Landscape Lighting Strategy Plan, and Landscape Legend and General Arrangement Plans

Notes

1. This drawing is the property of fabrik ltd. It must not be copied or reproduced without written consent.
2. Only figured dimensions are to be taken from this drawing. All contractors must visit site and be responsible for taking and checking all dimensions related to the works shown on the drawing.

fabrik

Lenten House
16 Lenten Street
Alton
Hampshire
GU34 1HG

T: 01420 593250
E: alton@fabrikuk.com
W: www.fabrikuk.com

MOUNT ANVIL	
NO COMMENT	A STATUS A
MINOR COMMENTS	B STATUS B
REVISED DRAWING TO FOLLOW	C STATUS C-REJECTED
DATE:	
REVIEWED BY:	

T3	10-03-17	Sheet updated. Issued for Tender
T2	25-11-16	updated to coordinate with MKP
T1	03-10-16	Issued for Tender
PO1	19-08-16	Additional column lighting unit added
-	14-07-16	Issued for comment

No. Date Reason

Revisions

External References:

•

NB	JR
HvK	NB
HvK	NB
HvK	NB
HvK	NB
Drawn	Checked

Project
Kidderpore Avenue, Hampstead
for Mount Anvil

Drawing
Lighting Fixture Details

Scale
NTS @ A1

Date
July '16

Checked
NB

Drawn
HvK


Drawing No.
9300-DRG-DE018

Revision
T3

<input type="checkbox"/> Preliminary	<input type="checkbox"/> Issued for Design/Information
<input type="checkbox"/> Issued for Planning Approval	<input checked="" type="checkbox"/> Issued for Tender
<input type="checkbox"/> Issued for Construction	<input type="checkbox"/> As Built


Drawing sheet size - A1

Copyright Reserved ©

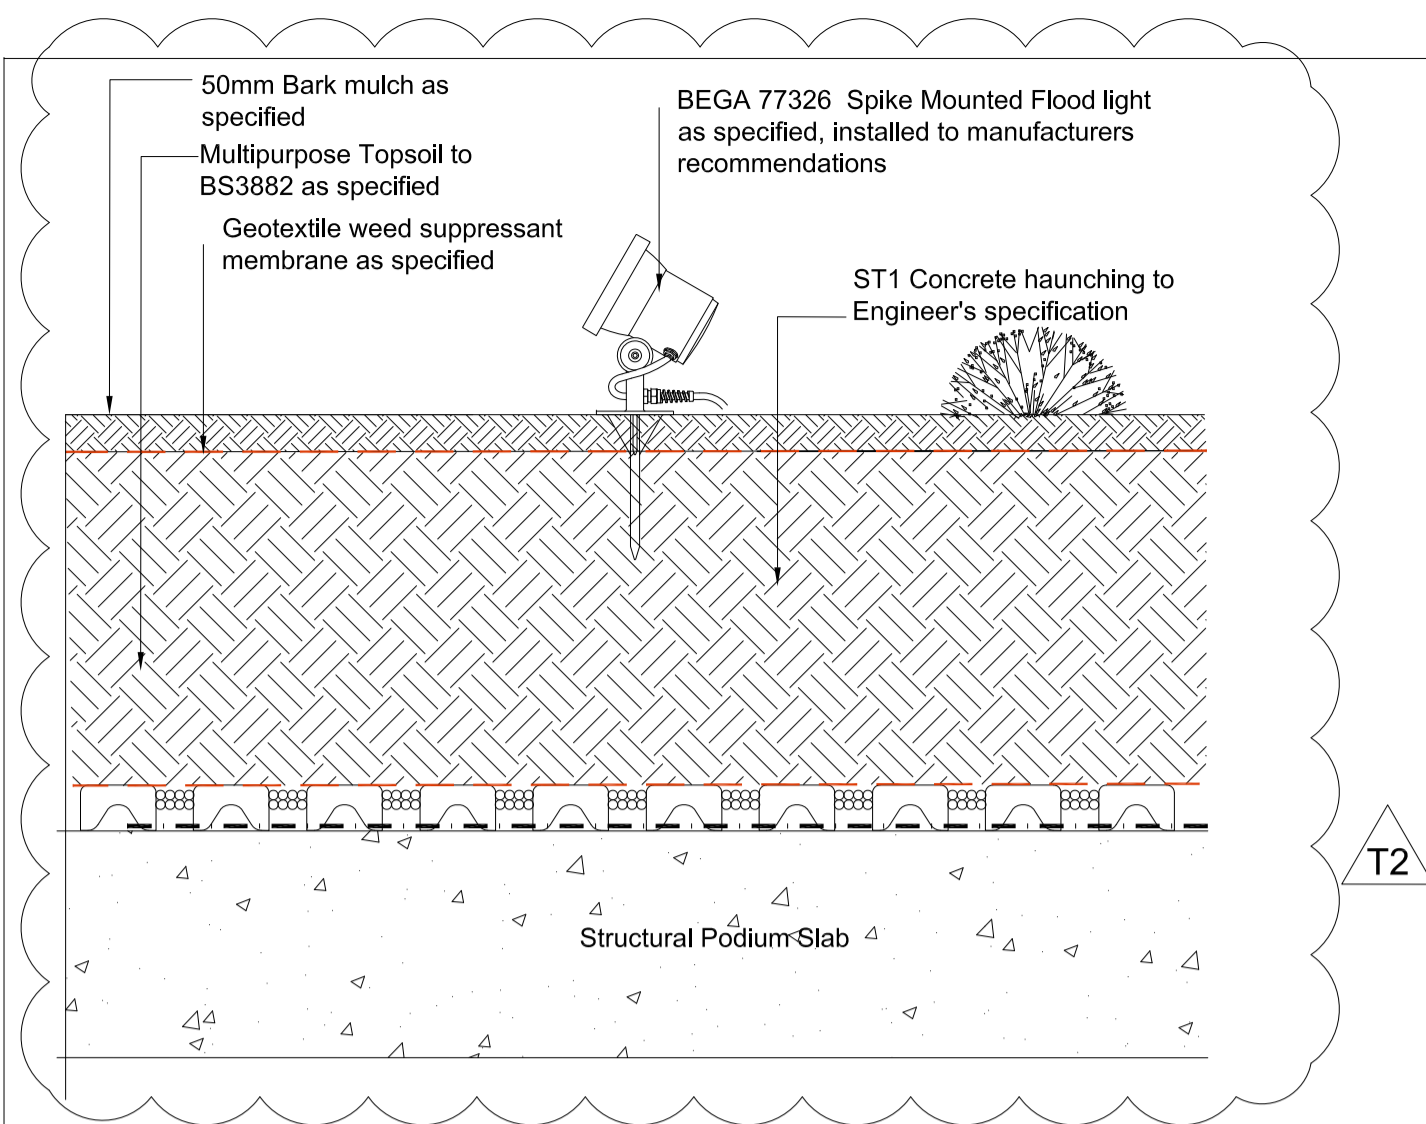


1 Tree uplighter
Scale 1:10


T2

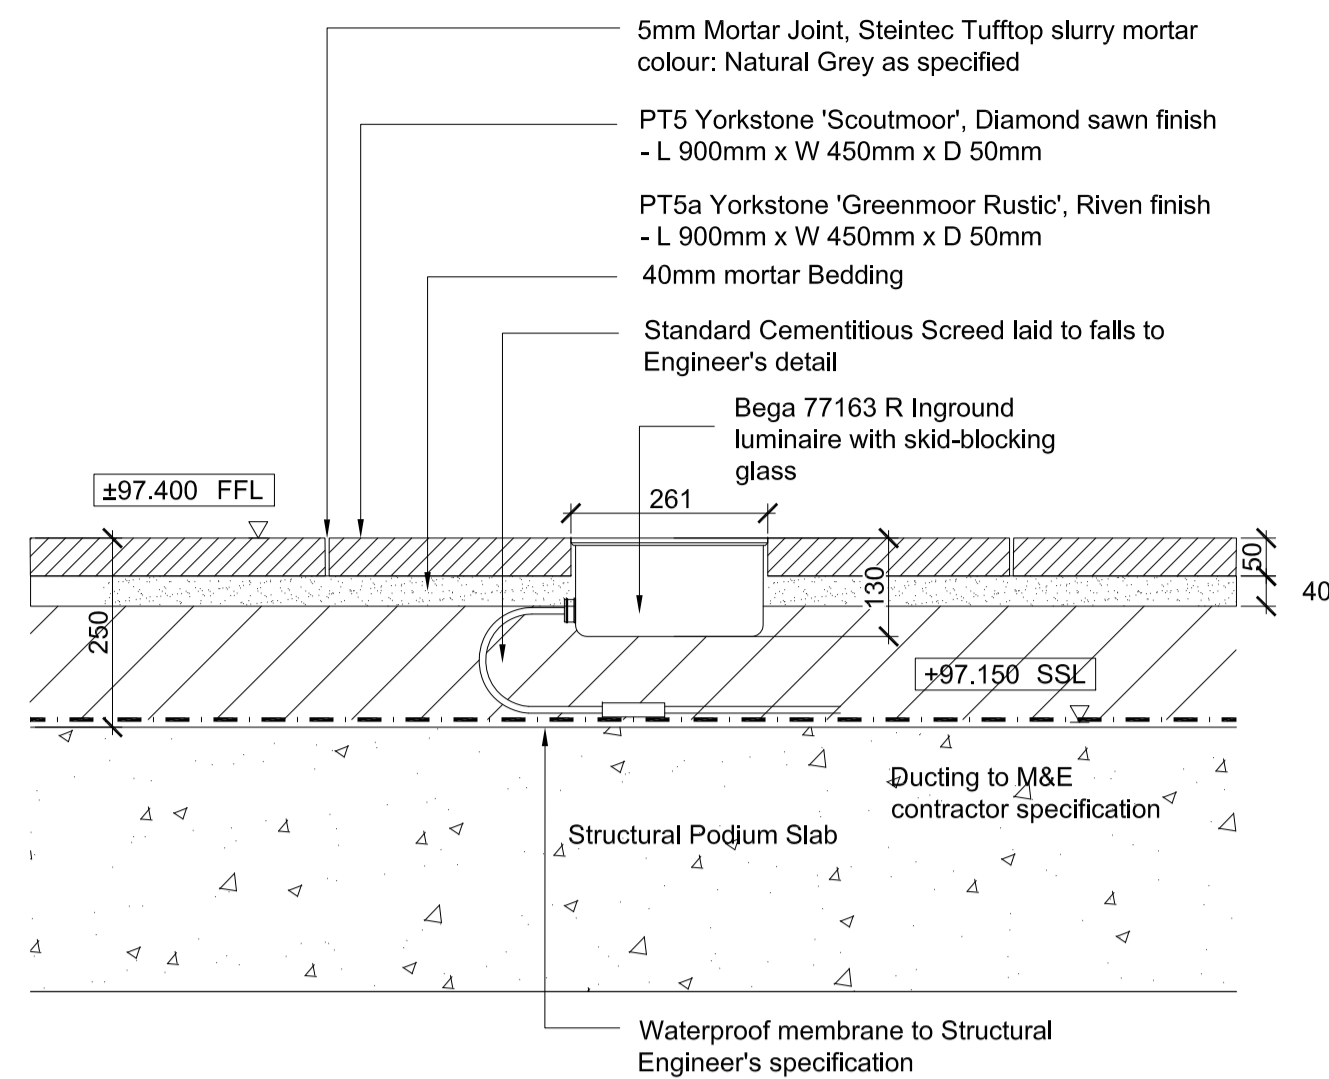


2 Inground uplighter in paving
Scale 1:10

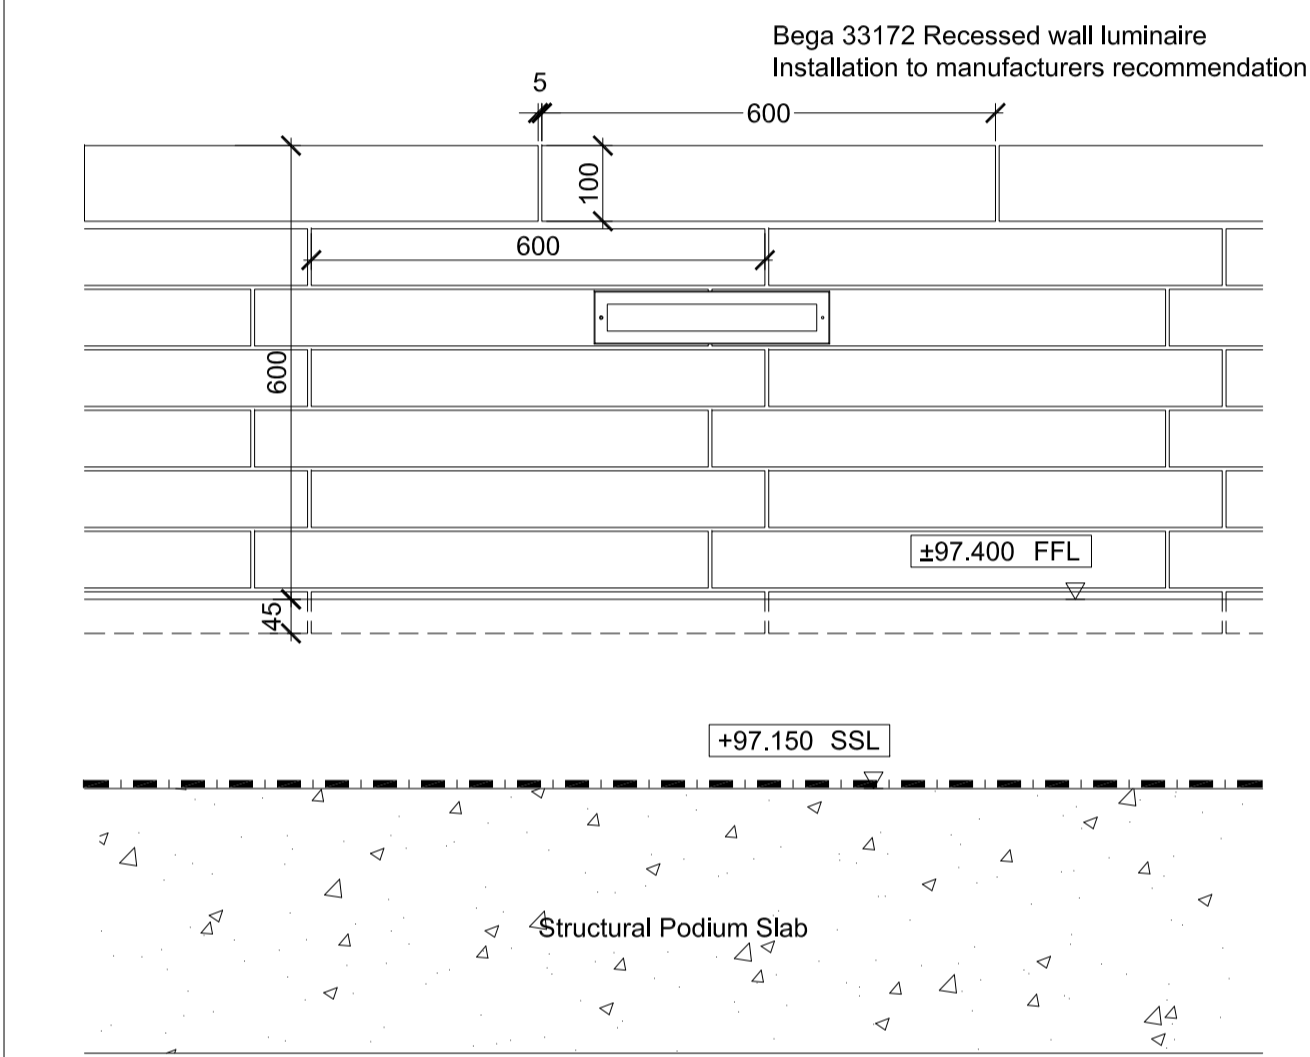


3 Wall Recessed Light - Elevation
Scale 1:10

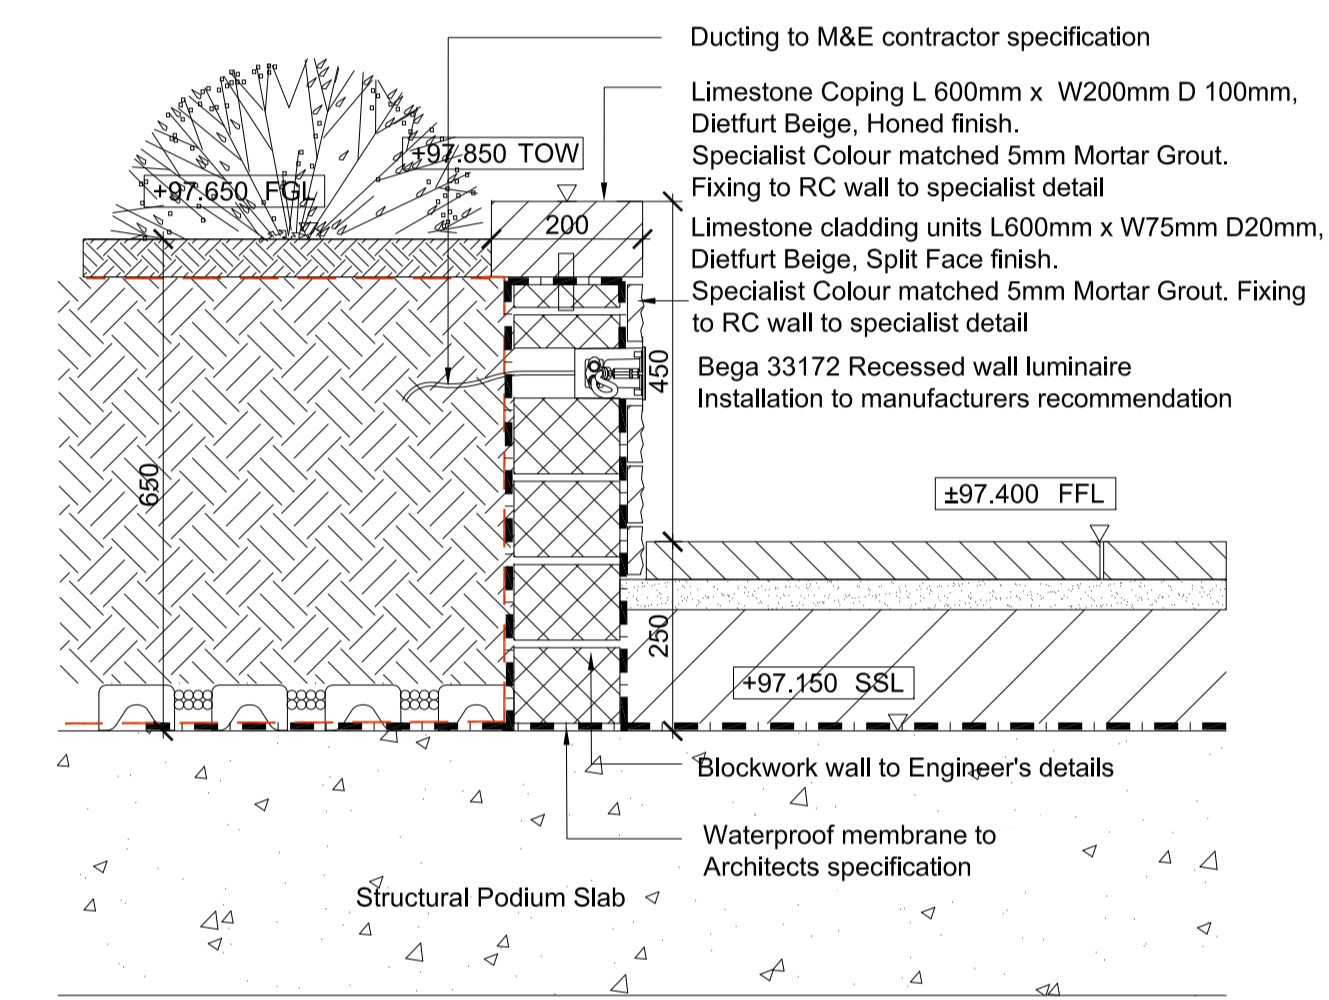


4 Wall Recessed light - Section
Scale 1:10

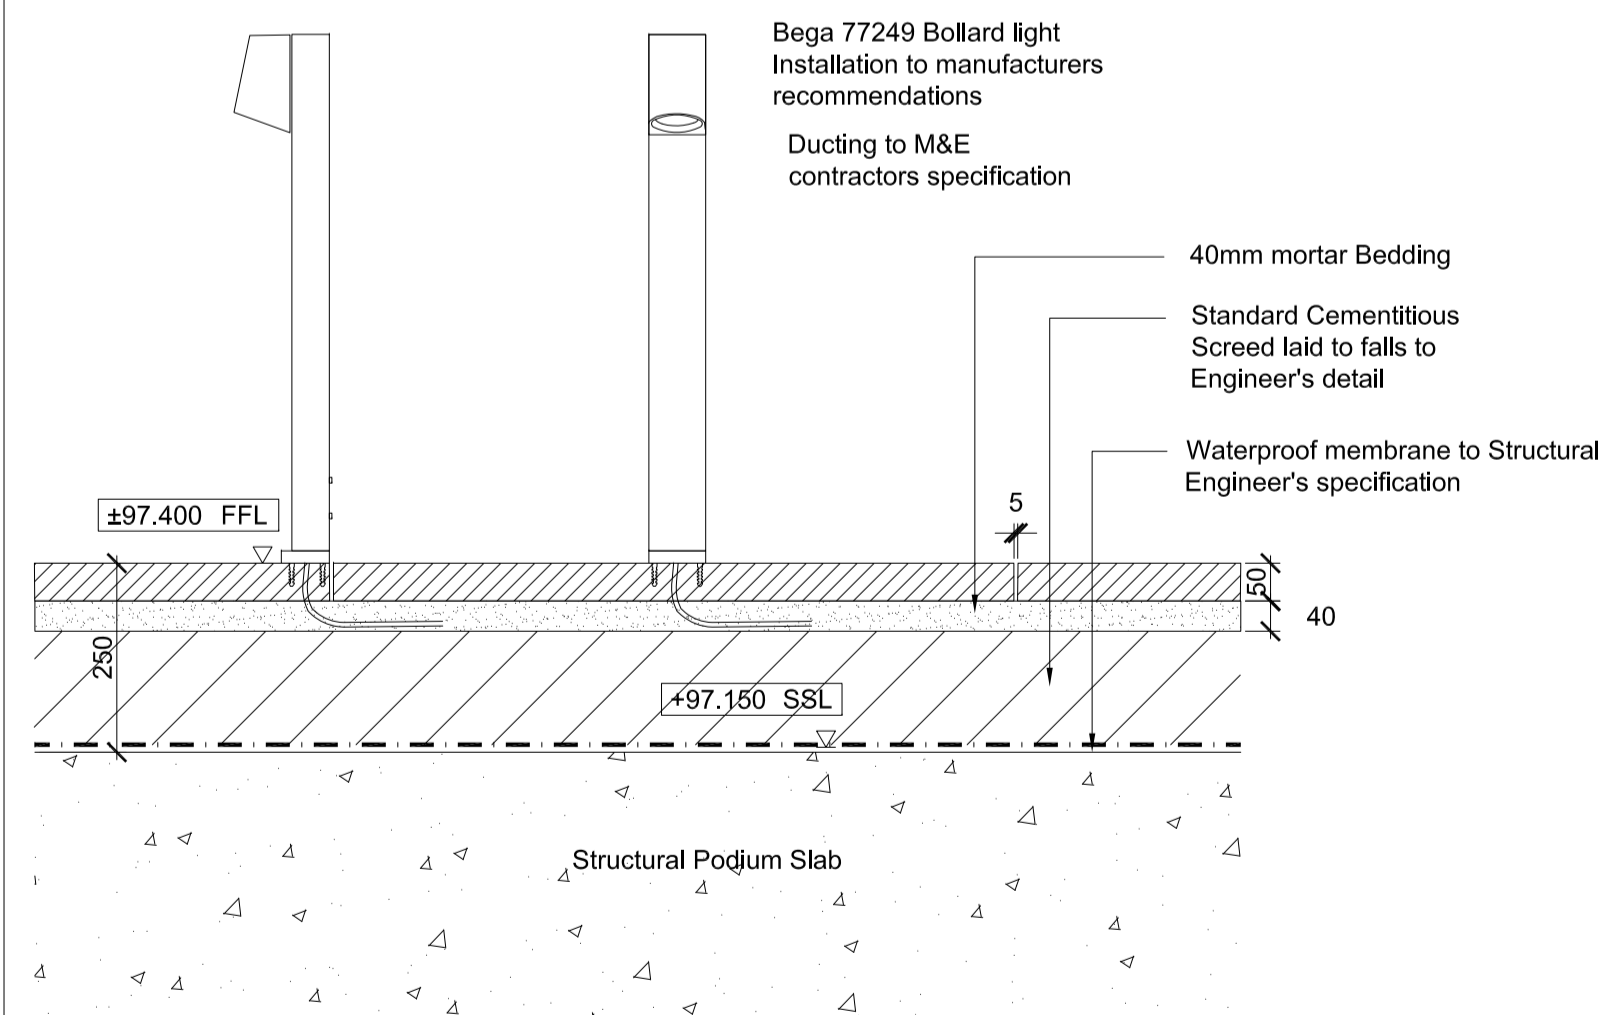

5 Bollard Light over Podium
Scale 1:10

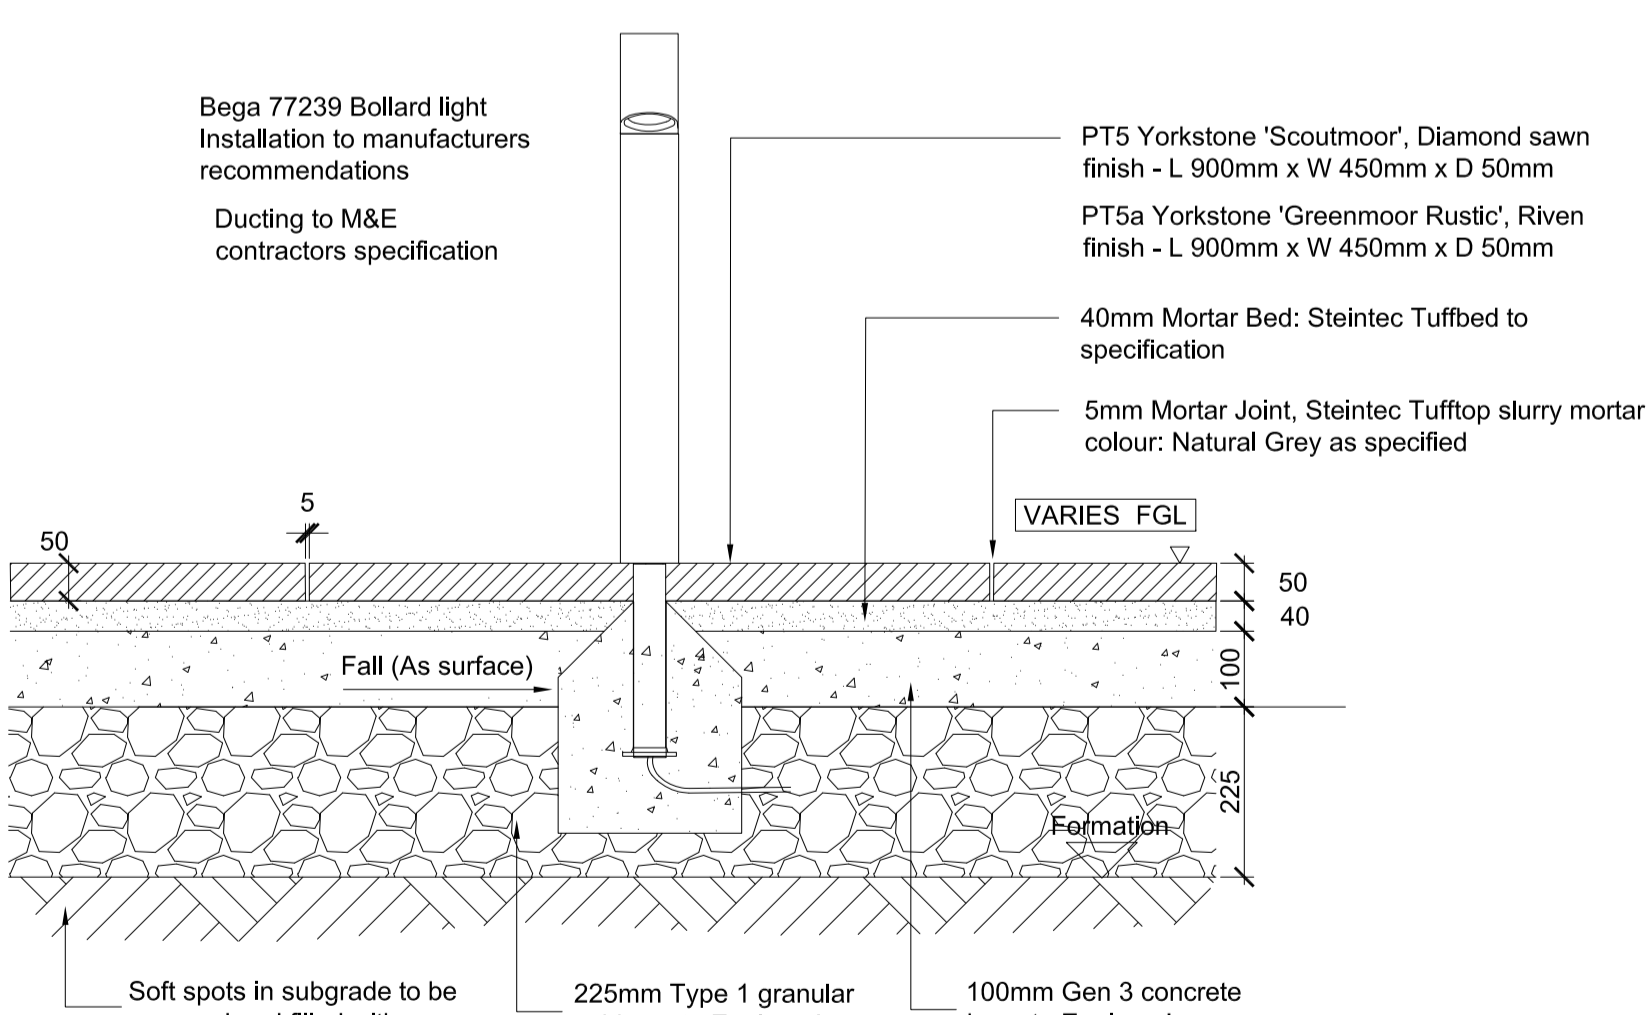

6 Bollard Light in Ground
Scale 1:10

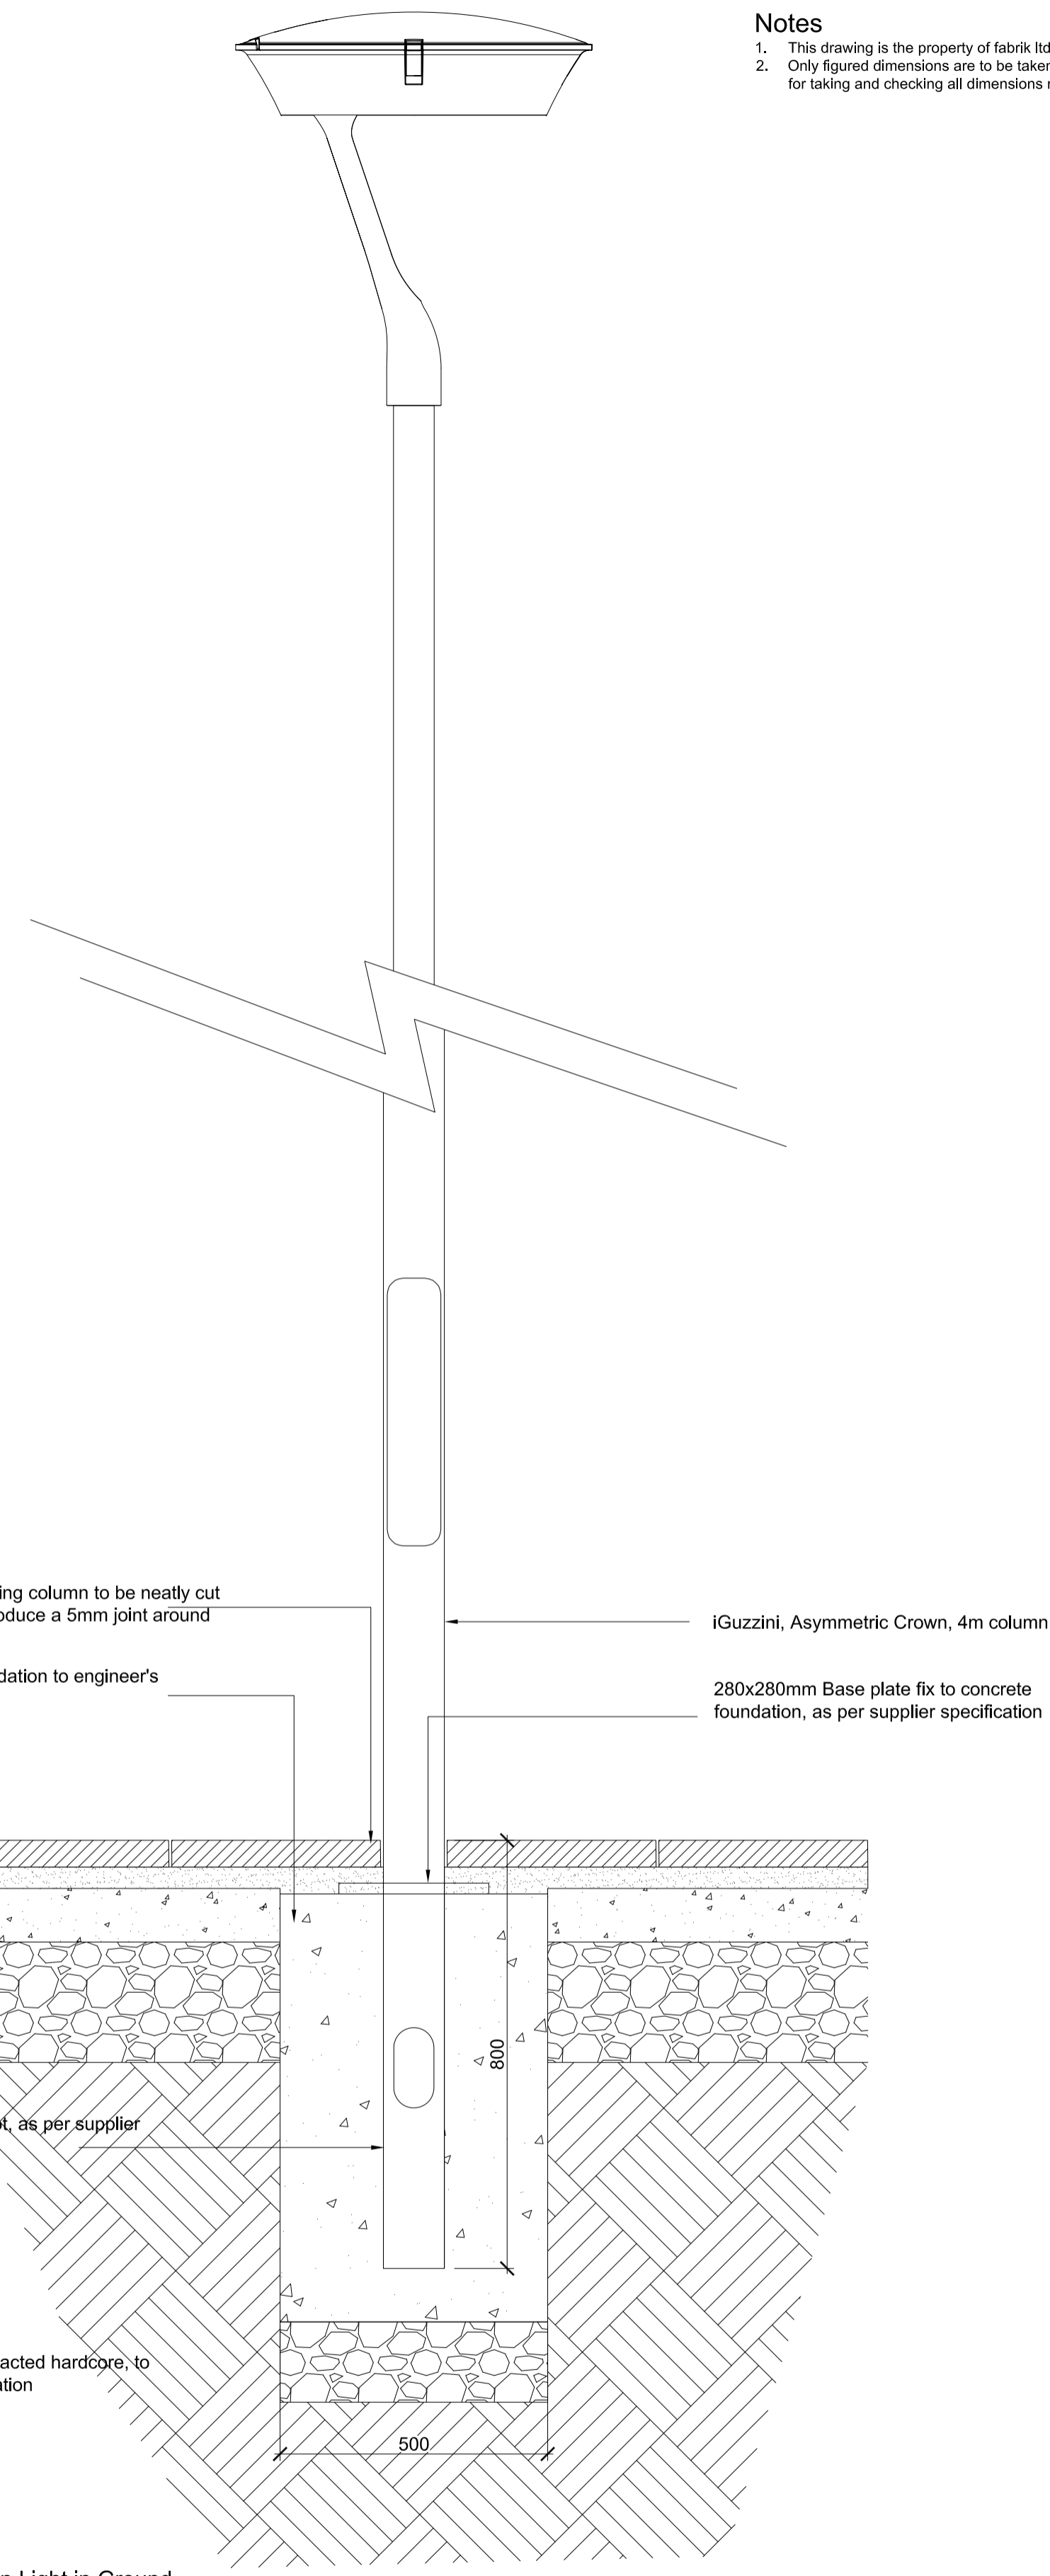

7 Column Light in Ground
Scale 1:10

- Notes**
- This drawing is the property of fabrik ltd. It must not be copied or reproduced without written consent.
 - Only figured dimensions are to be taken from this drawing. All contractors must visit site and be responsible for taking and checking all dimensions related to the works shown on the drawing.

fabrik

Lenten House
16 Lenten Street
Alton
Hampshire
GU34 1HG
T: 01420 593250
E: alton@fabrikuk.com
W: www.fabrikuk.com

MOUNT ANVIL

NO COMMENT	A	STATUS A
MINOR COMMENTS	B	STATUS B
REVISED DRAWING TO FOLLOW	C	STATUS C- REJECTED
DATE:		
REVIEWED BY:		

T2 25-11-16 Updated to coordinate with MKP proposals
T1 03-10-16 Issued for Tender
No. Date Reason
Revisions

External References:


HvK NB
HvK NB
Drawn Checked

Project
Kidderpore Avenue, Hampstead
for Mount Anvil


Drawing
Lighting Installation - Typical Details

Scale	Date	Checked	Drawn
1:10 @ A1	Sept '16	NB	HvK
Drawing No.	Revision		
9300-DRG-DE029	T2		
<input type="checkbox"/> Preliminary	<input type="checkbox"/> Issued for Design/Information	<input type="checkbox"/> Issued for Tender	<input type="checkbox"/> As Built
<input type="checkbox"/> Issued for Planning Approval	<input type="checkbox"/> Issued for Construction		
Drawing sheet size - A1 Copyright Reserved ©			

Note:
Refer to Electrical Engineer's specification,
circuit diagrams and details.
Details of all lamps and luminaires to be
submitted for approval.
Installation details to be submitted for
approval.

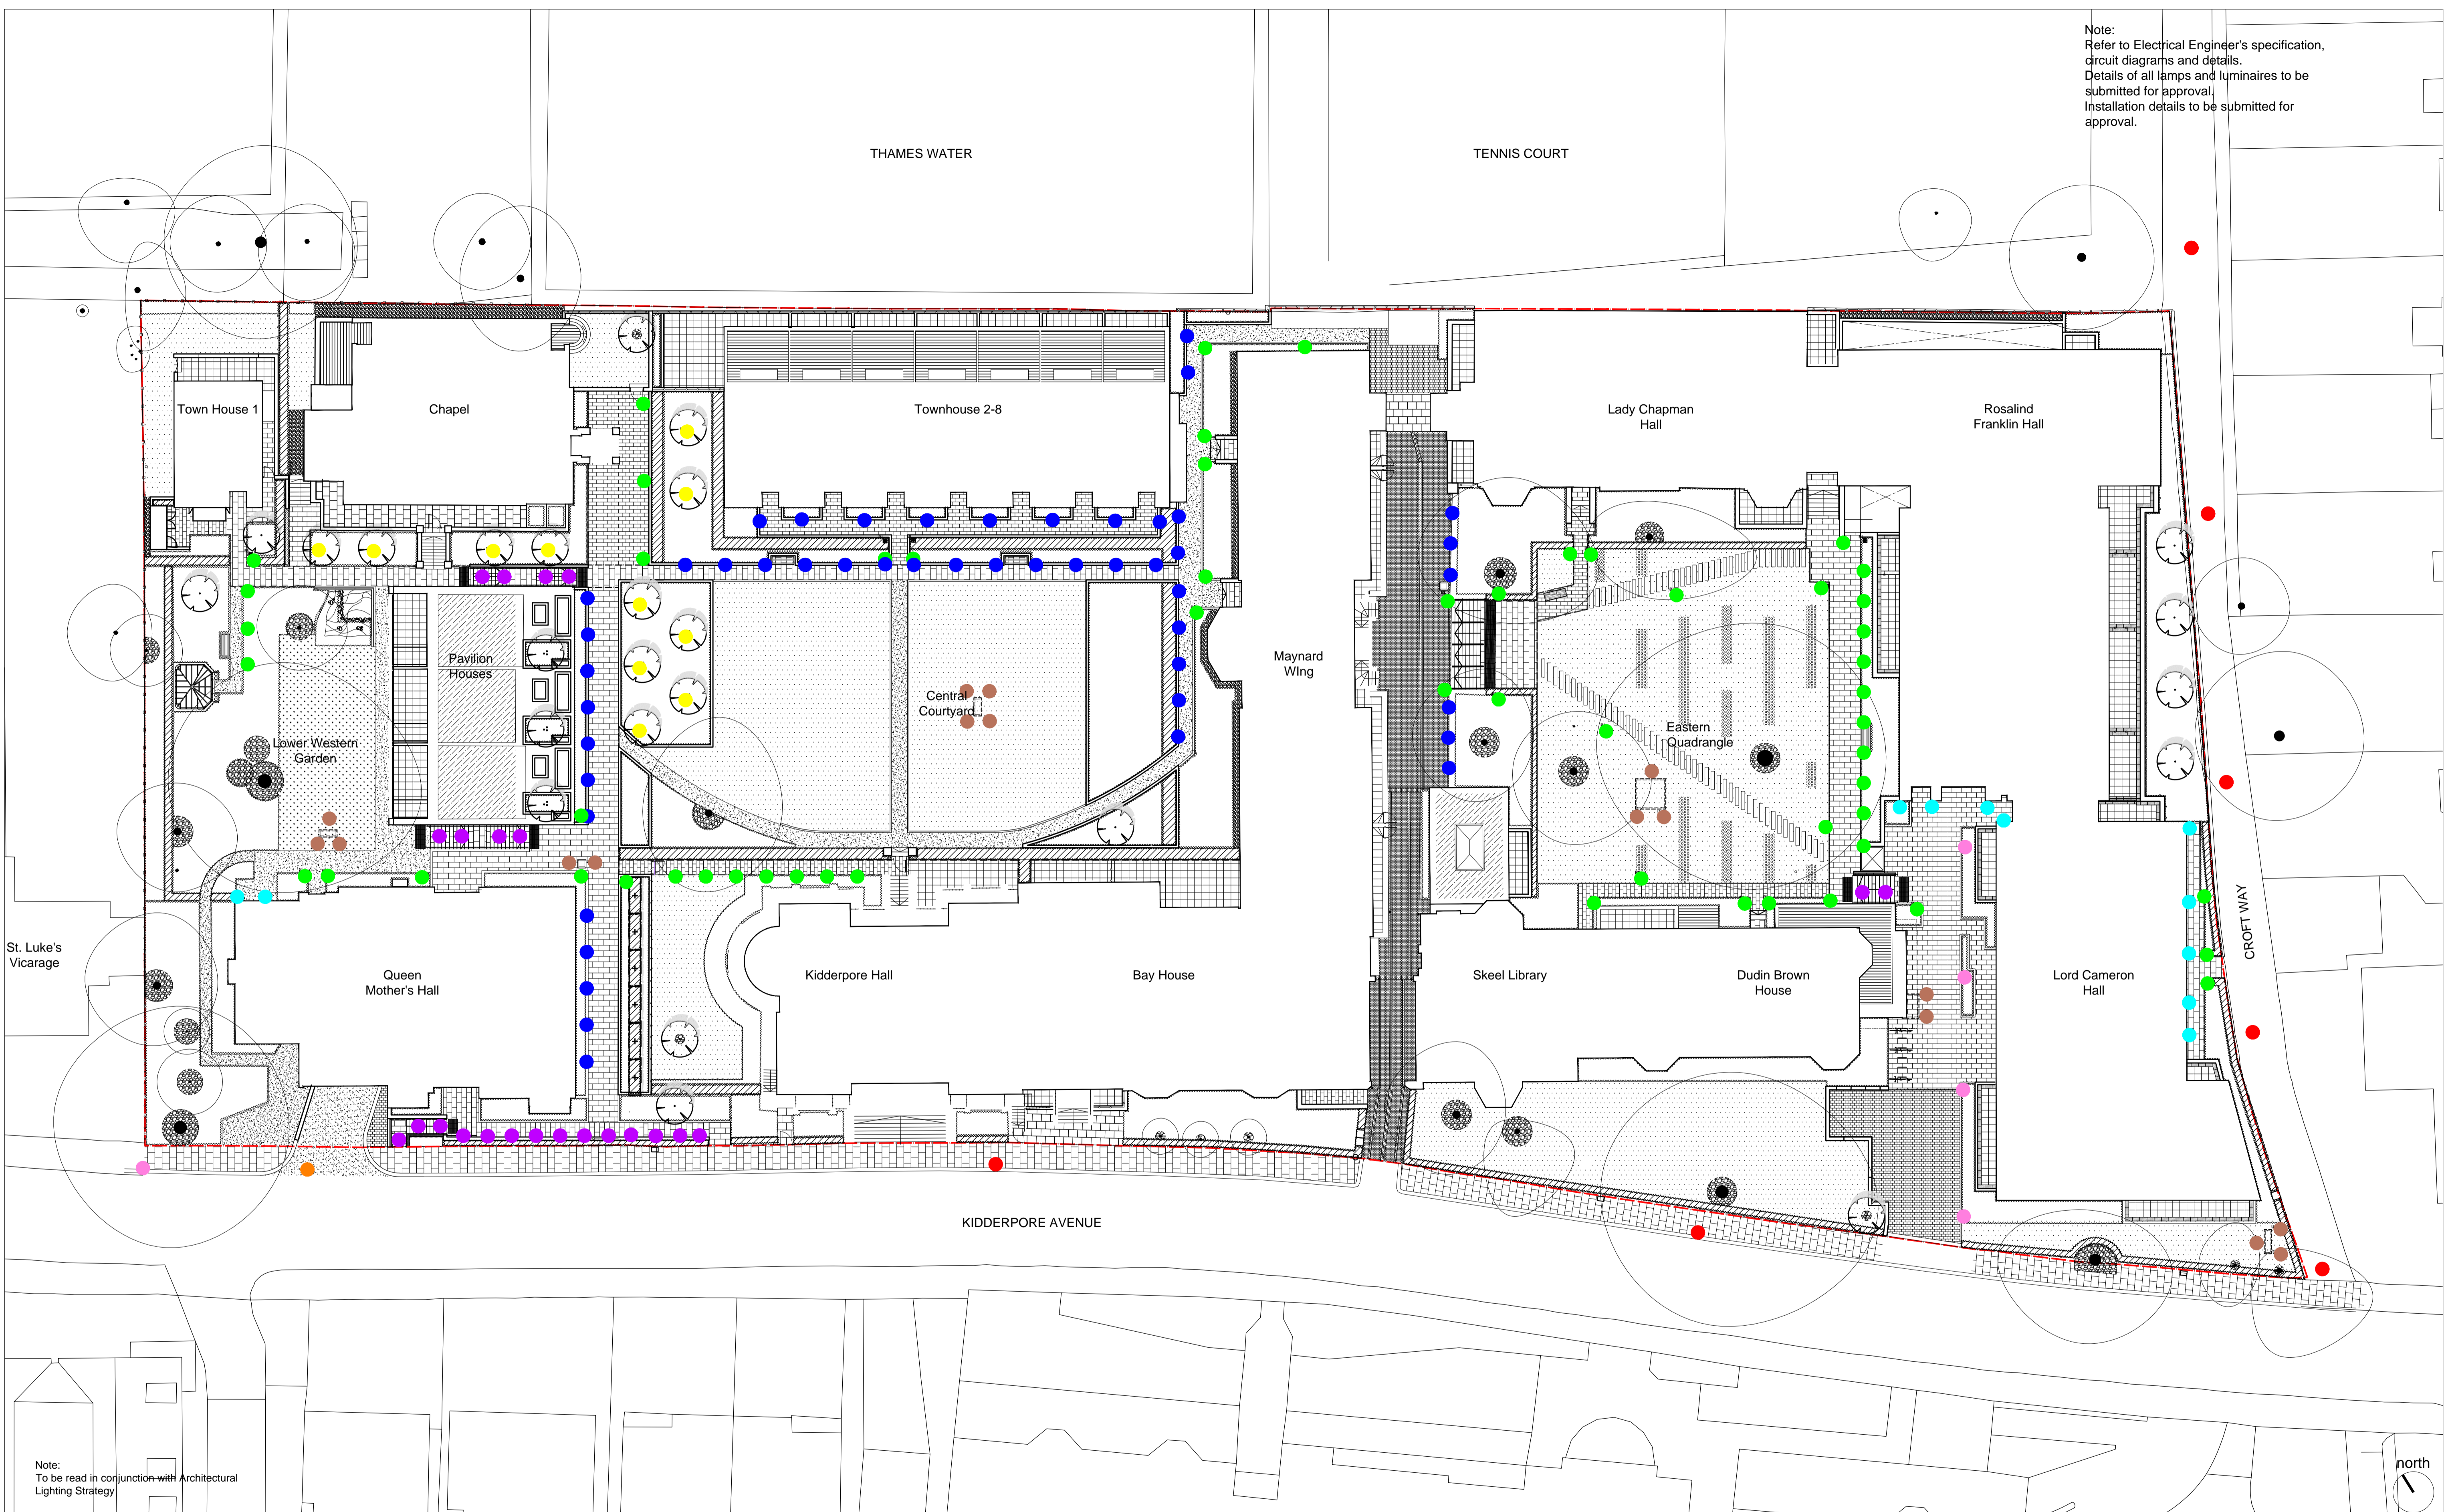

Note:
To be read in conjunction with Architectural
Lighting Strategy

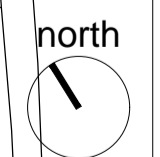

fabrik

Lenten House
16 Lenten Street
Alton
Hampshire
GU34 1HG

T: 01420 593250
E: alton@fabrikuk.com
W: www.fabrikuk.com

- | | | | | | |
|--|--|--|---|--|--|
| | Existing Lighting Column Retained (EL) | | Proposed 600mm High Bollard Light (BL)
Product: 77239 ground /77249 podium
Supplier: BEGA | | Proposed Recessed Light at Steps & Low Wall Edges (SL)
Product: 33054
Supplier: BEGA |
| | Existing Column Light to be Relocated (LP-R)
(refer to Highways Design details) | | Proposed Ground Recessed Up-light (GU)
Product: 77163
Supplier: BEGA | | Proposed Spike Mounted Tree Up-light (UL)
Product: 77326
Supplier: BEGA |
| | Proposed Column Light (LC)
Product: Crown Asymmetrical
Supplier: iGuzzini | | Proposed Recessed Wall Light (RL)
Product: 33172
Supplier: BEGA | | Proposed Up-light (UL) to Sculptures
Product: TBC
Supplier: TBC |

T5	17.03.17	Sculpture spot lights amended. Issued for Tender
T4	16.03.17	Sculpture locations and sculpture spot lights amended
T3	24.02.17	Sheet Updated. Issued for Tender
T2	25.11.16	Updated luminaire specification to coordinate with M&E proposals
T1	03.10.16	Issued for Tender
P01	19.08.16	Additional fittings added to MA comments
No.	Date	Reason
Revisions		
External References:		
• fabrikWorkingAutoCAD\ID2280 working 100.dwg		
• Tree Survey\recvd-15-04-08\09166 Draft Impact Assessment rev 5fab.dwg		
• Architect\recvd-14-11-26\157780 OS map.dwg		

Project
**Kidderpore Avenue, Hampstead
for Mount Anvil**

Drawing
Landscape Lighting Strategy Plan

Scale 1:250 @ A1	Date July '16	Checked NB	Drawn HvK
Drawing No. 9300-DRG-PE009	Revision T5		
<input type="checkbox"/> Preliminary	<input type="checkbox"/> Issued for Design/Information	<input type="checkbox"/> Issued for Tender	<input type="checkbox"/> As Built
<input type="checkbox"/> Issued for Planning Approval	<input type="checkbox"/> Issued for Construction	<input type="checkbox"/> As Built	
Drawing sheet size - A1			
Copyright Reserved ©			