


GROUND FLOOR

- BATH
- 2 RING COOKER
- WC
- BASIN
- SHOWER
- SMOKE DETECTOR
- HEAT DETECTOR
- CALL POINT
- CONTROL UNIT
- FIRE EXTINGUISHER
- FIRE ALARM
- EMERGENCY LIGHT

ZINE
 07970 647449
 FLOOR PLANS
 97 FORDWICH


DATE: 02 JULY 2006

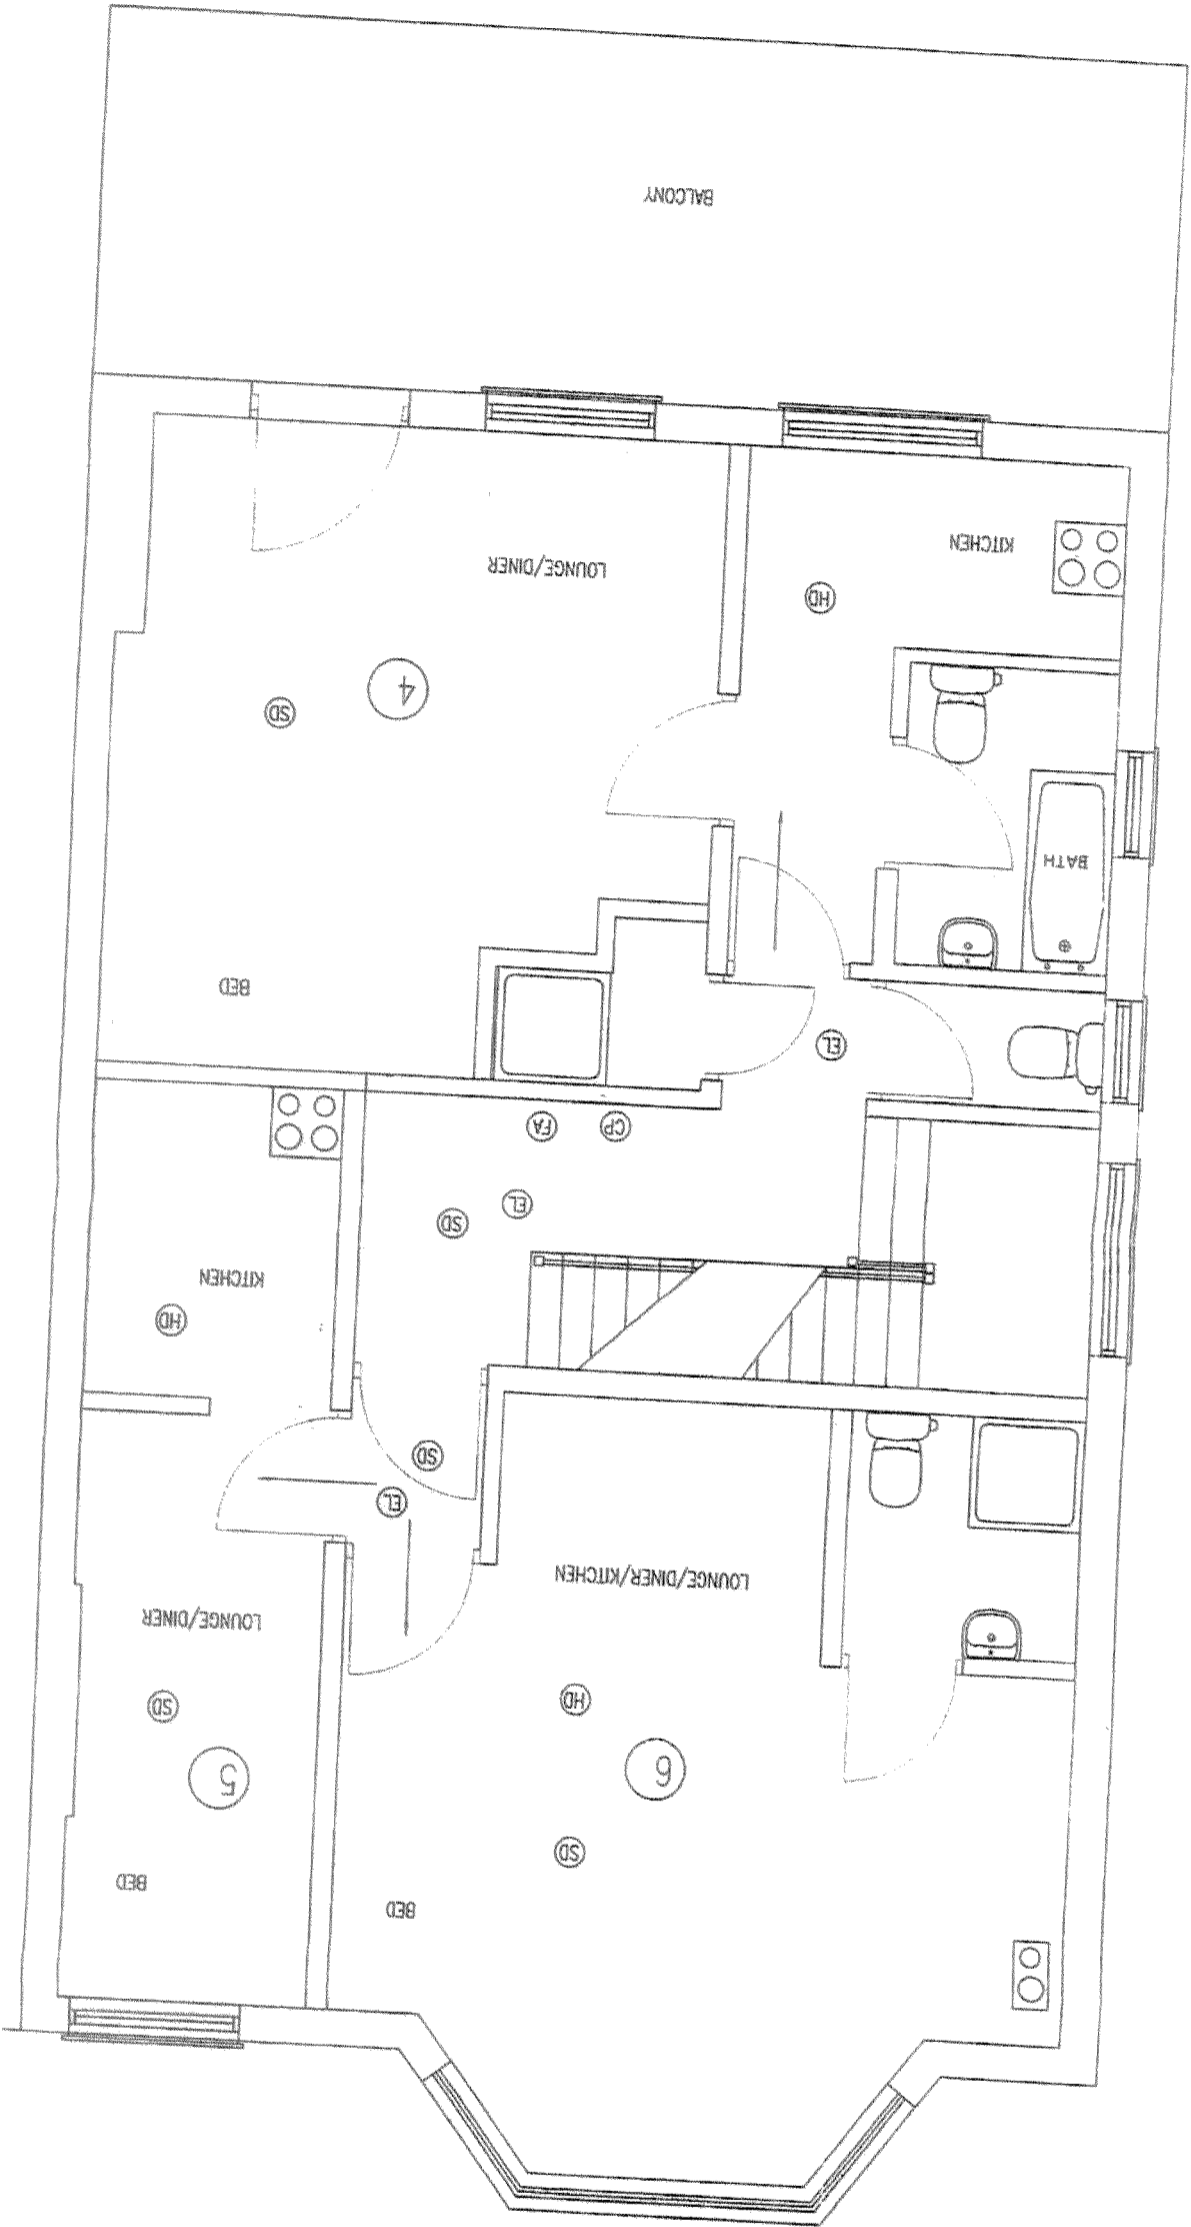

FIRST FLOOR

- BATH
- 2 RING COOKER
- W.C.
- BASIN
- SHOWER
- SMOKE DETECTOR
- HEAT DETECTOR
- CALL POINT
- CONTROL UNIT
- FIRE EXTINGUISHER
- FIRE ALARM
- EMERGENCY LIGHT


07970 647449
GINE
 FLOOR PLANS
 97 TORWINGI
 1:50
 02 JULY 2006
 OZ

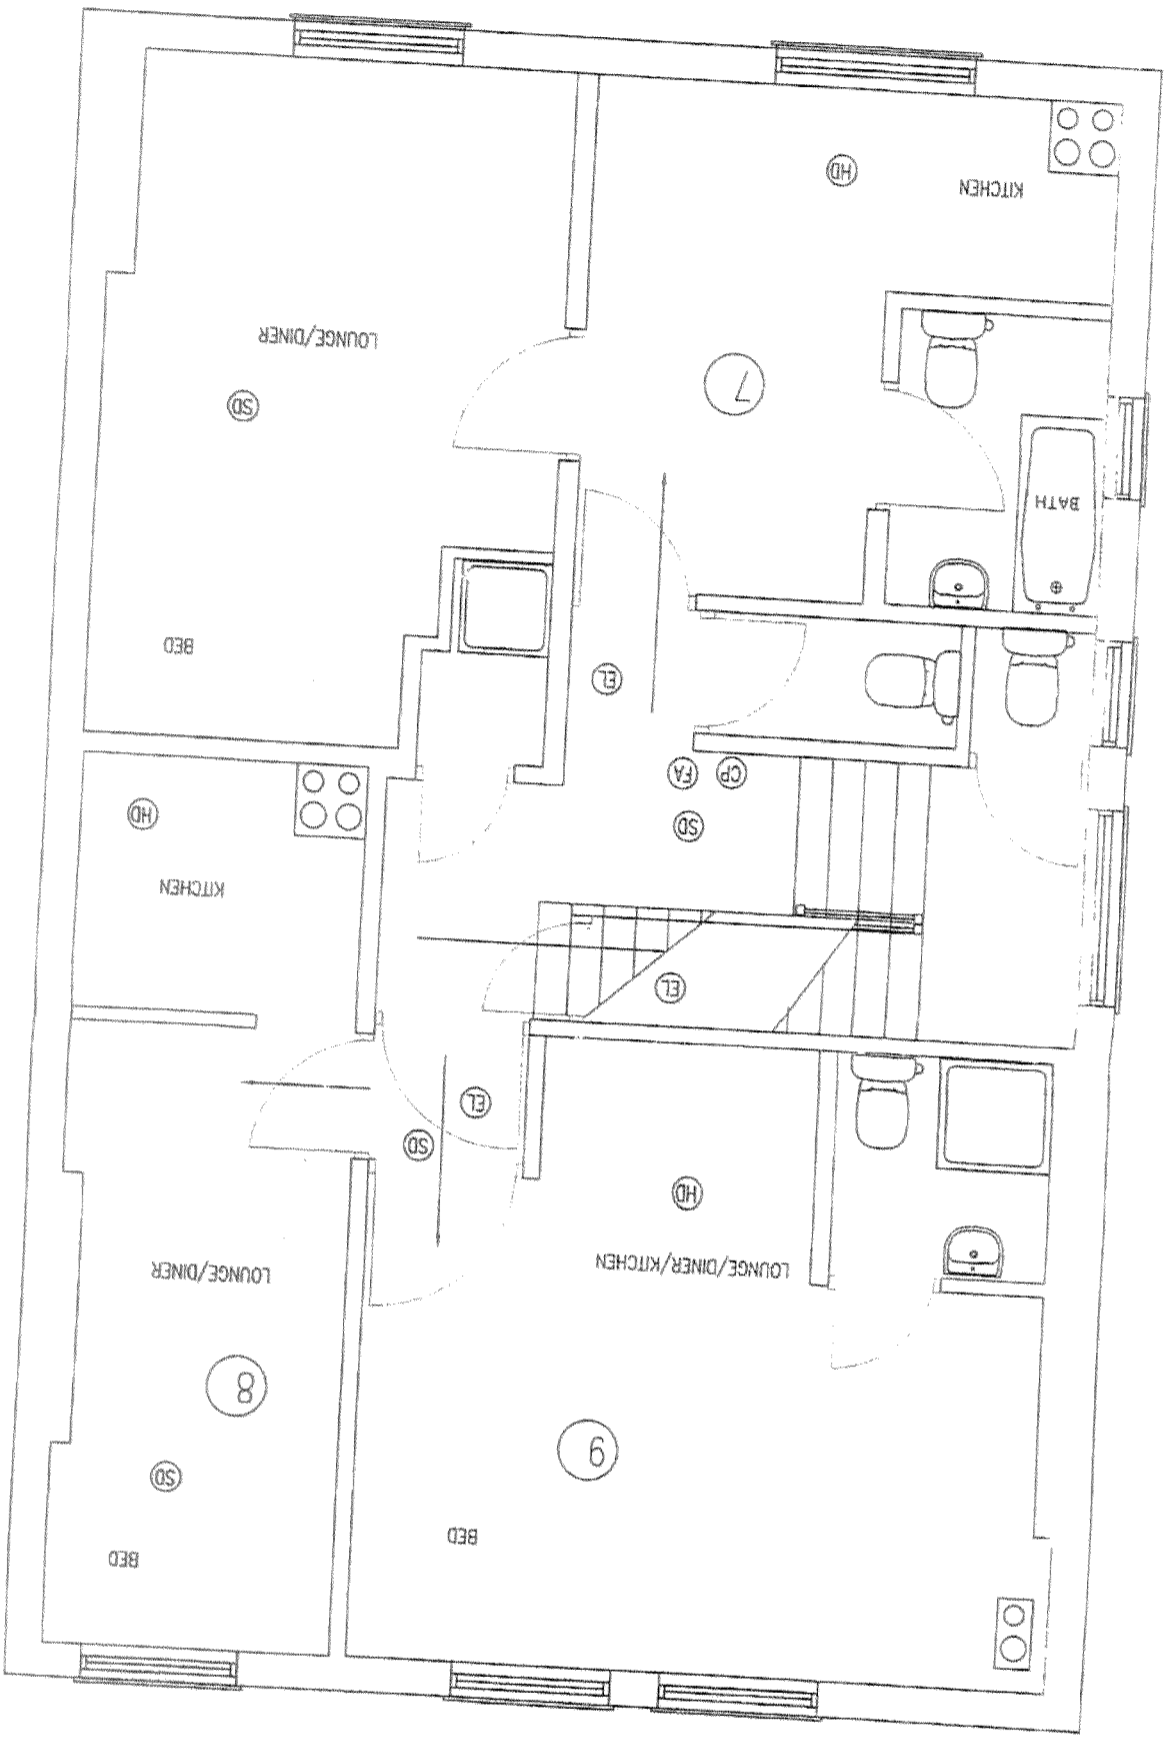

SECOND FLOOR

- BATH
- 2 RING COOKER
- WC
- BASIN
- SHOWER
- SMOKE DETECTOR
- HEAT DETECTOR
- CALL POINT
- CONTROL UNIT
- FIRE EXTINGUISHER
- FIRE ALARM
- EMERGENCY LIGHT

07970 647449
 FLOOR PLANS
 97 FORDMACH
 DATE: 02/11/2008
 DRAWN BY: OS

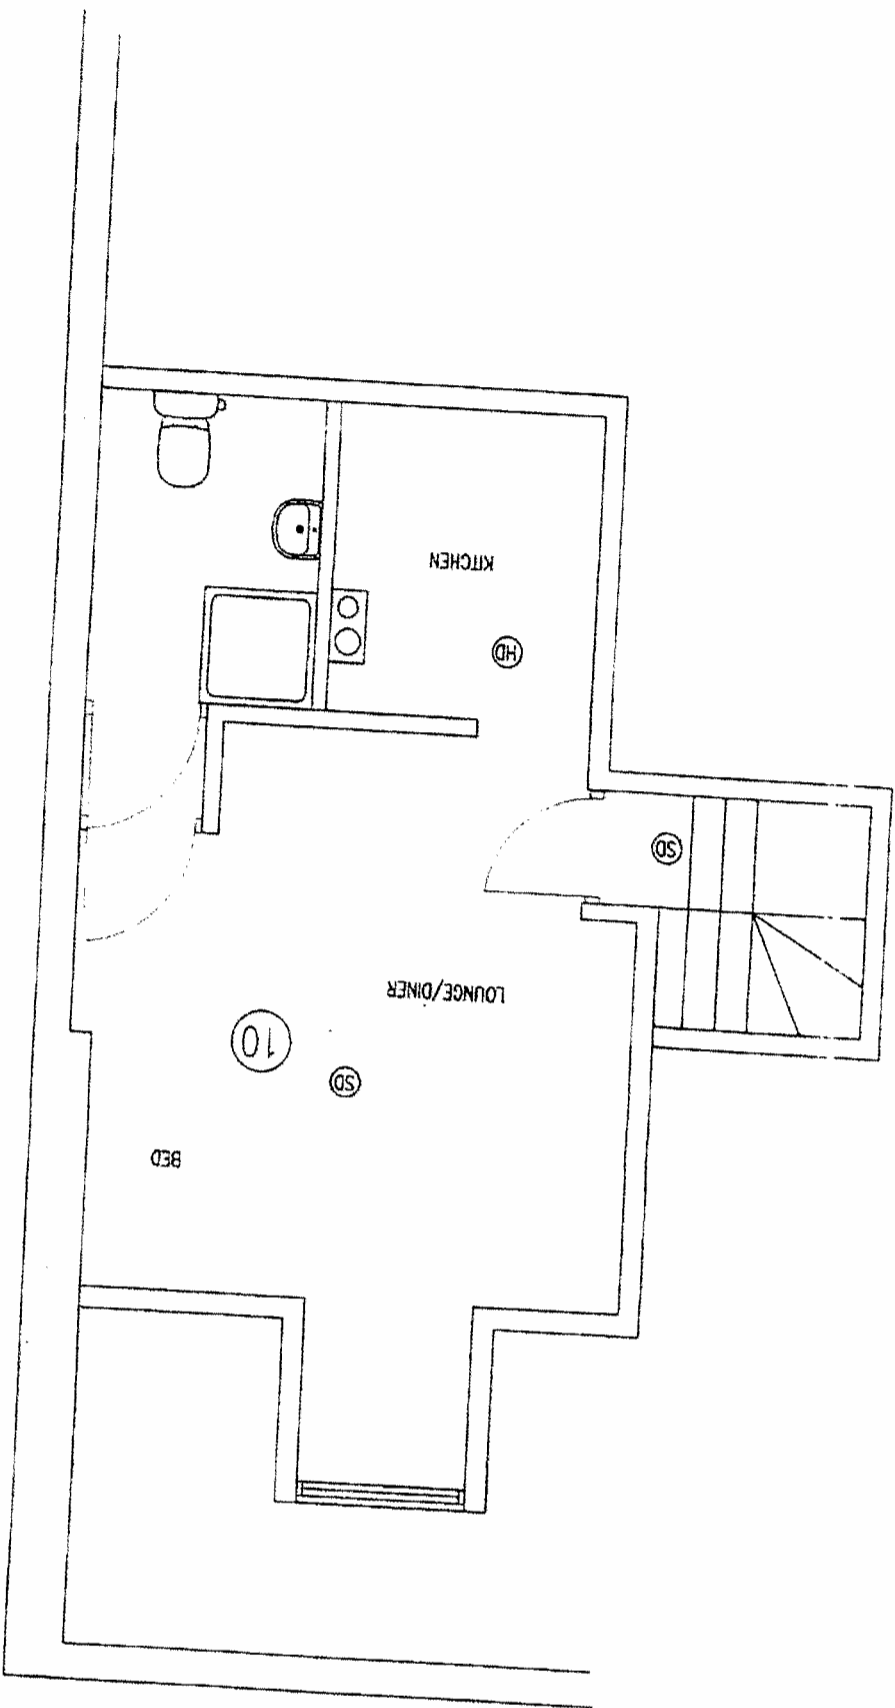

THIRD FLOOR

- BATH
- 2 RING COOKER
- WC
- BASIN
- SHOWER
- SMOKE DETECTOR
- HEAT DETECTOR
- CALL POINT
- CONTROL UNIT
- FIRE EXTINGUISHER
- FIRE ALARM
- EMERGENCY LIGHT

07970 647449

1000 PLANS

 877 0274441

1500

 0241 Y 2006

04