 



8 - 9 Long Yard, London WC1N:
Proposed Roof Plan
1:100 Scale

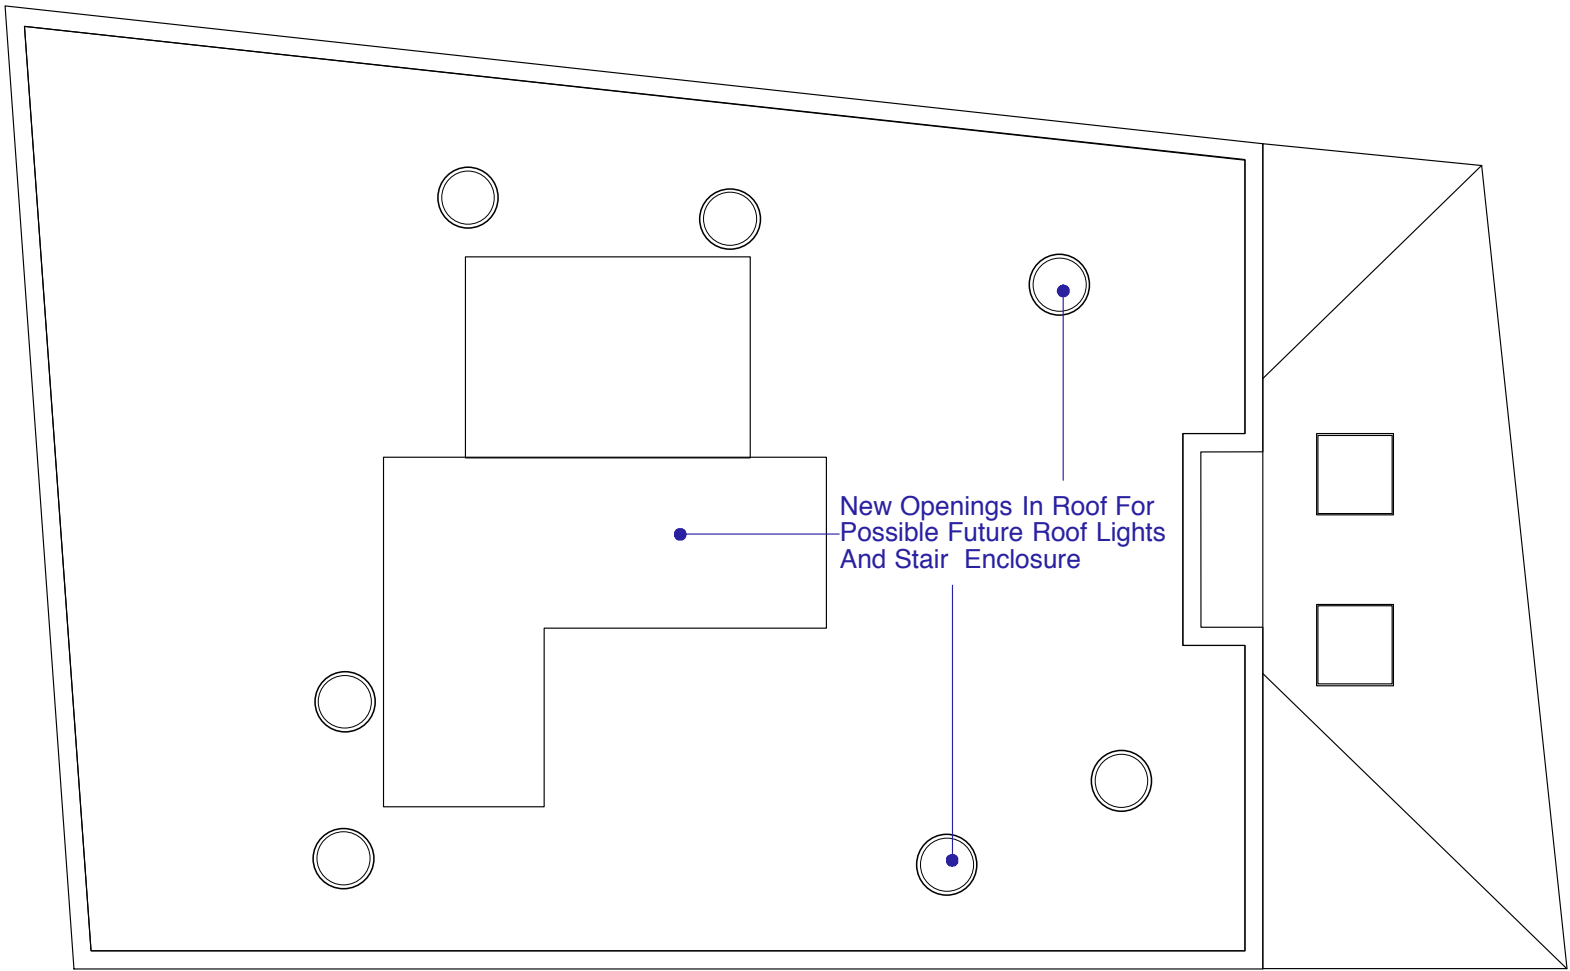

Rev. A 6.9.17 Drawing corrected to show Water Tank enclosure to roof

Monahan Blythen Hopkins architects	
166 Clerkenwell Road London EC1R 5DE Tel 020 7833 9616 Email : admin@mbharchitects.co.uk	
Client : G.O.S.H Job Title : 8-9 Long Yard Drawing: Proposed Second Floor Plan	
Scale : 1:100@A3 Dwg No: LY_P17	Date: June 2017 Rev : A
All Dimensions Must Be Checked On Site and Not Scaled From This Drawing Copyright Monahan Blythen Hopkins Architects Ltd	