

Services legend

	Twin 13A Socket
	Fused Connection unit - switched
	Extract Fan
	Shaver Socket
	Television Socket
	Phone Socket
	Fuse board
	Gas point with isolator

Security legend


	Vibration Sensors
	Alarm Panic Alarm
	Alarm Keypad
	Alarm PIR
	Alarm Door Contacts

Lighting legend

	Pendant Fitting
	Decorative Wall Light
	Recessed Spot Lights
	Micro Spot Lights
	Single 5Amp Socket
	Under Floor Heating Thermostat

1 Existing Electrical Layout
Scale: 1:50 @ A1 & 1:100 @ A3

Notes:
Copyright of this drawing and the contents remain with Pennington Phillips Limited.
Do not scale from the drawings. The contractor is to verify dimensions on site prior to the commencement of work. Any discrepancies are to be reported to the designer. If in doubt - seek clarification.

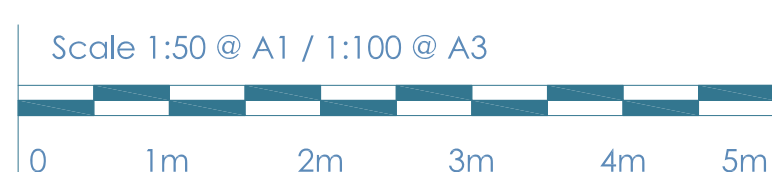

Rev.	Date	Remarks

Client:	—	Drawing Number:	5879/15
Project:	Flat 4, 55 Fitzjohns Avenue, London NW3 6PH	Revision:	
Drawing:	Existing Electrical Layout	Date:	18/09/17
Status:	Planning		