


C

THE RELEASE POINT OF VENTILATION AT FLAT ROOF 220mm DIAMETER PIPE APPROXIMATELY 1M. ABOVE FLAT ROOF

THE ASSOCIATED FAN EQUIPMENT WITHIN THE VOID.

2No. OF AIR CONDITIONING UNITS 970x330x940 DEEP POSITIONED ON FLAT ROOF

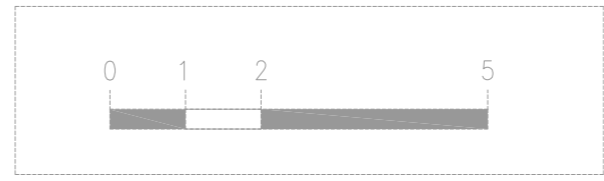

PROPOSED ROOF PLAN
Scale: 1:100

NOTES

Do not scale this drawing.

All dimensions and levels to be checked by contractor on site prior to commencement or manufacture.

Rev	Date	By	Chk	Comment
C	30/10/17	AI	ai	Revision as per planning officer's comments
B	26/10/17	AI	ai	Revision as per planning officer's comments
A	10/10/17	AI	ai	Revision as per planning officer's comments

Client

Maison Vie Ltd
68 King William Street
EC4N 7DZ London

Project Title

Planning
to
200 Kilburn High Road, Camden
London NW6 4JD

Drawing Title

Proposed Roof plan
Location of the release point
for ventilation and
air conditioning units

Drawn by: AI	Scale: 1=100 @ A3	Date: October 2017
Designed by: AI	Checked by: ai	Approved by: -

File Ref.: Leinweber - Camden

Drawing No. 04	Rev. C
-------------------	-----------