
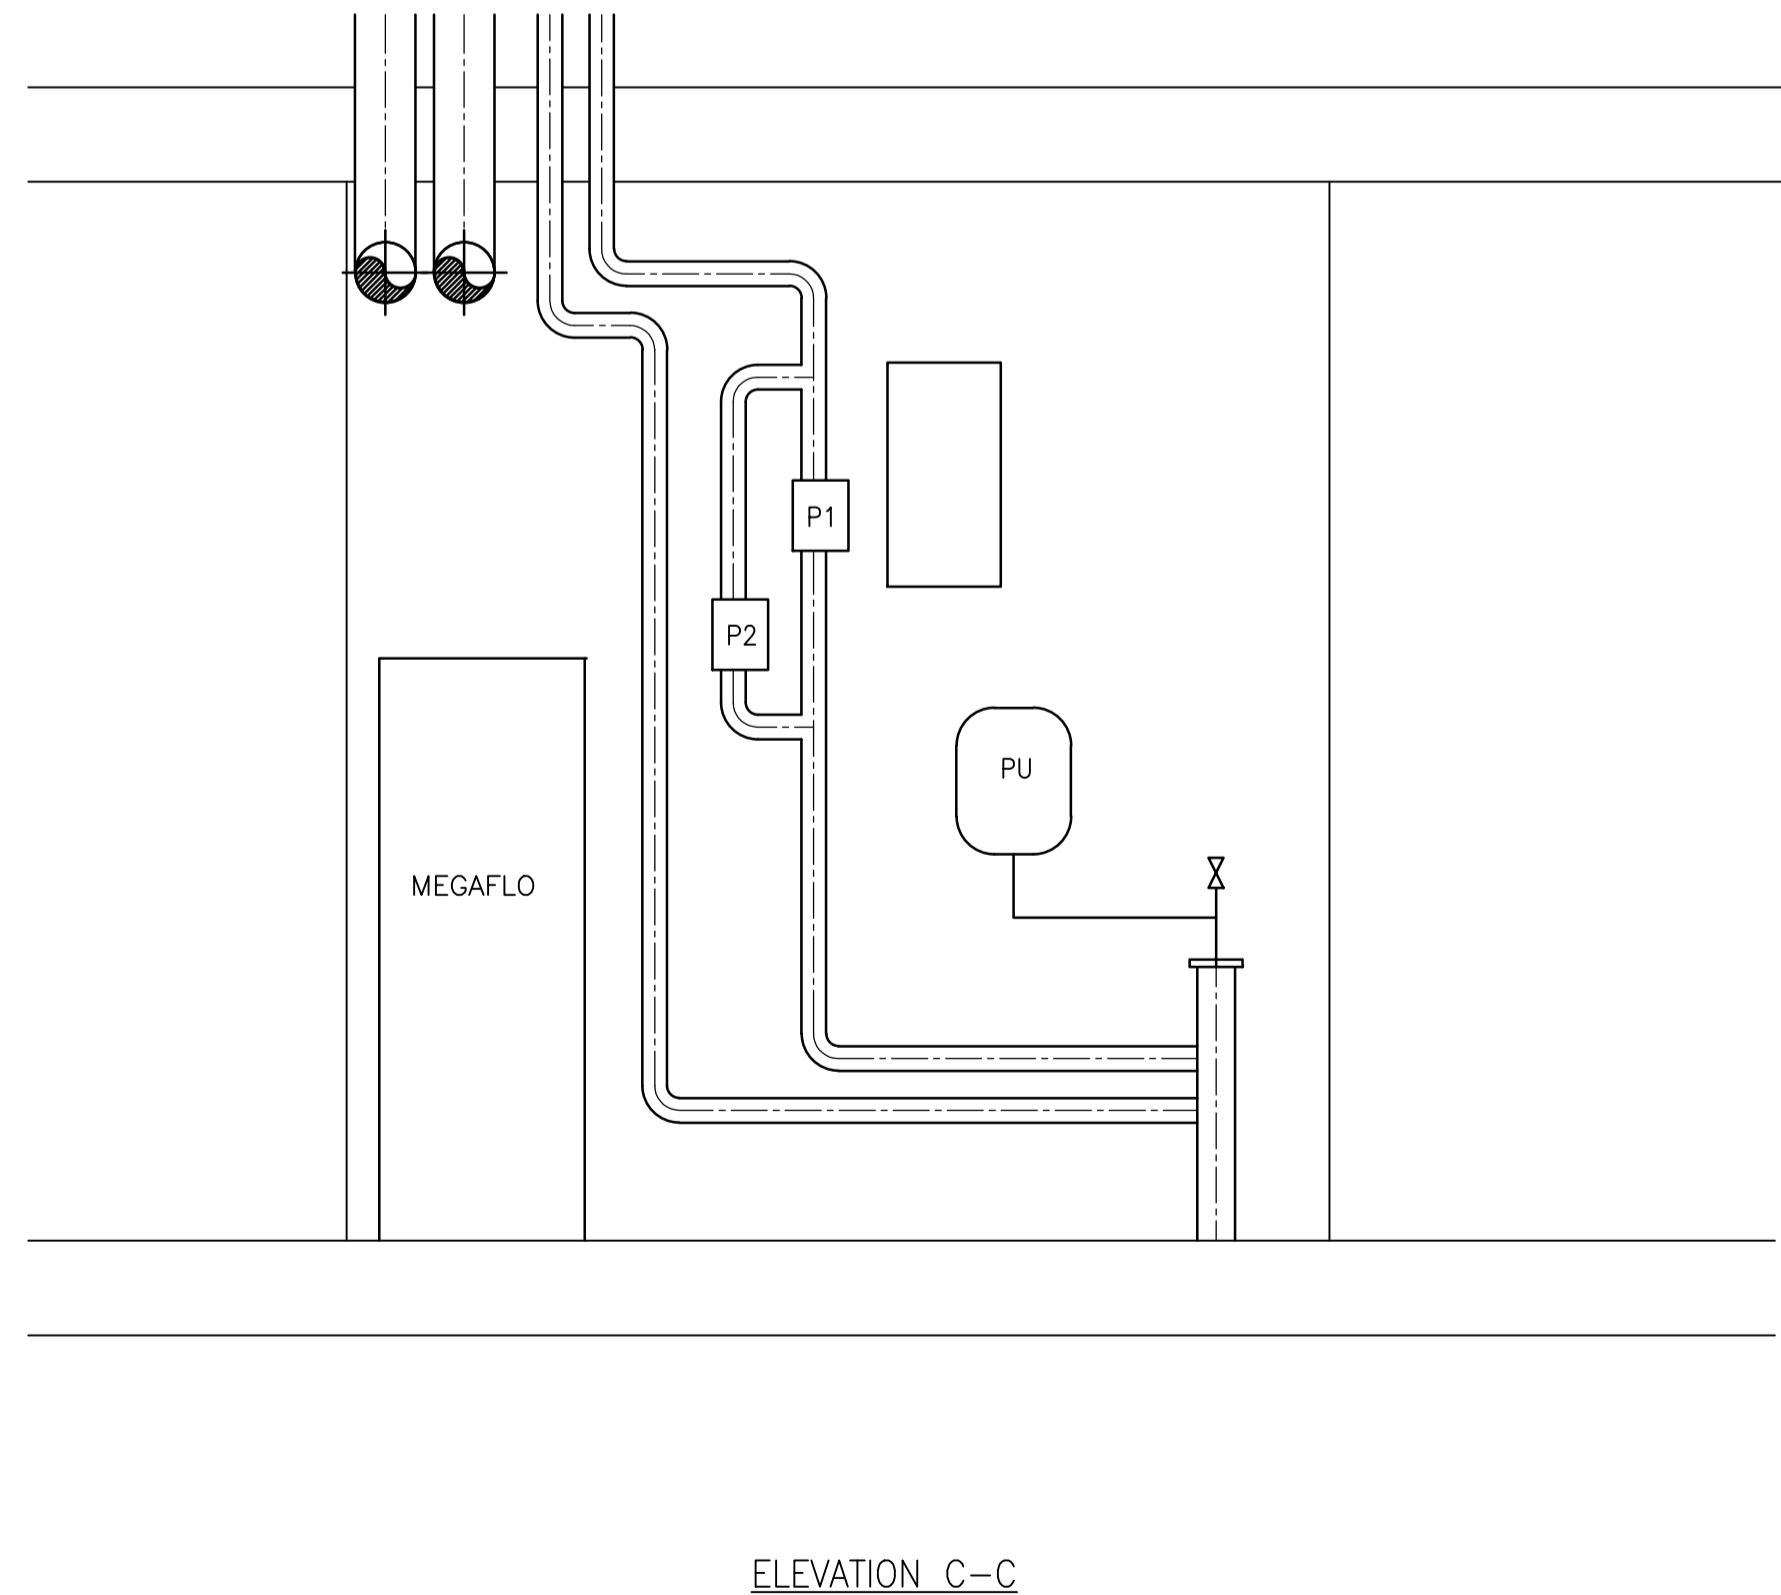


REFER TO DRAWING NUMBER 6000-DRG-S-002 FOR VALVE ARRANGEMENT

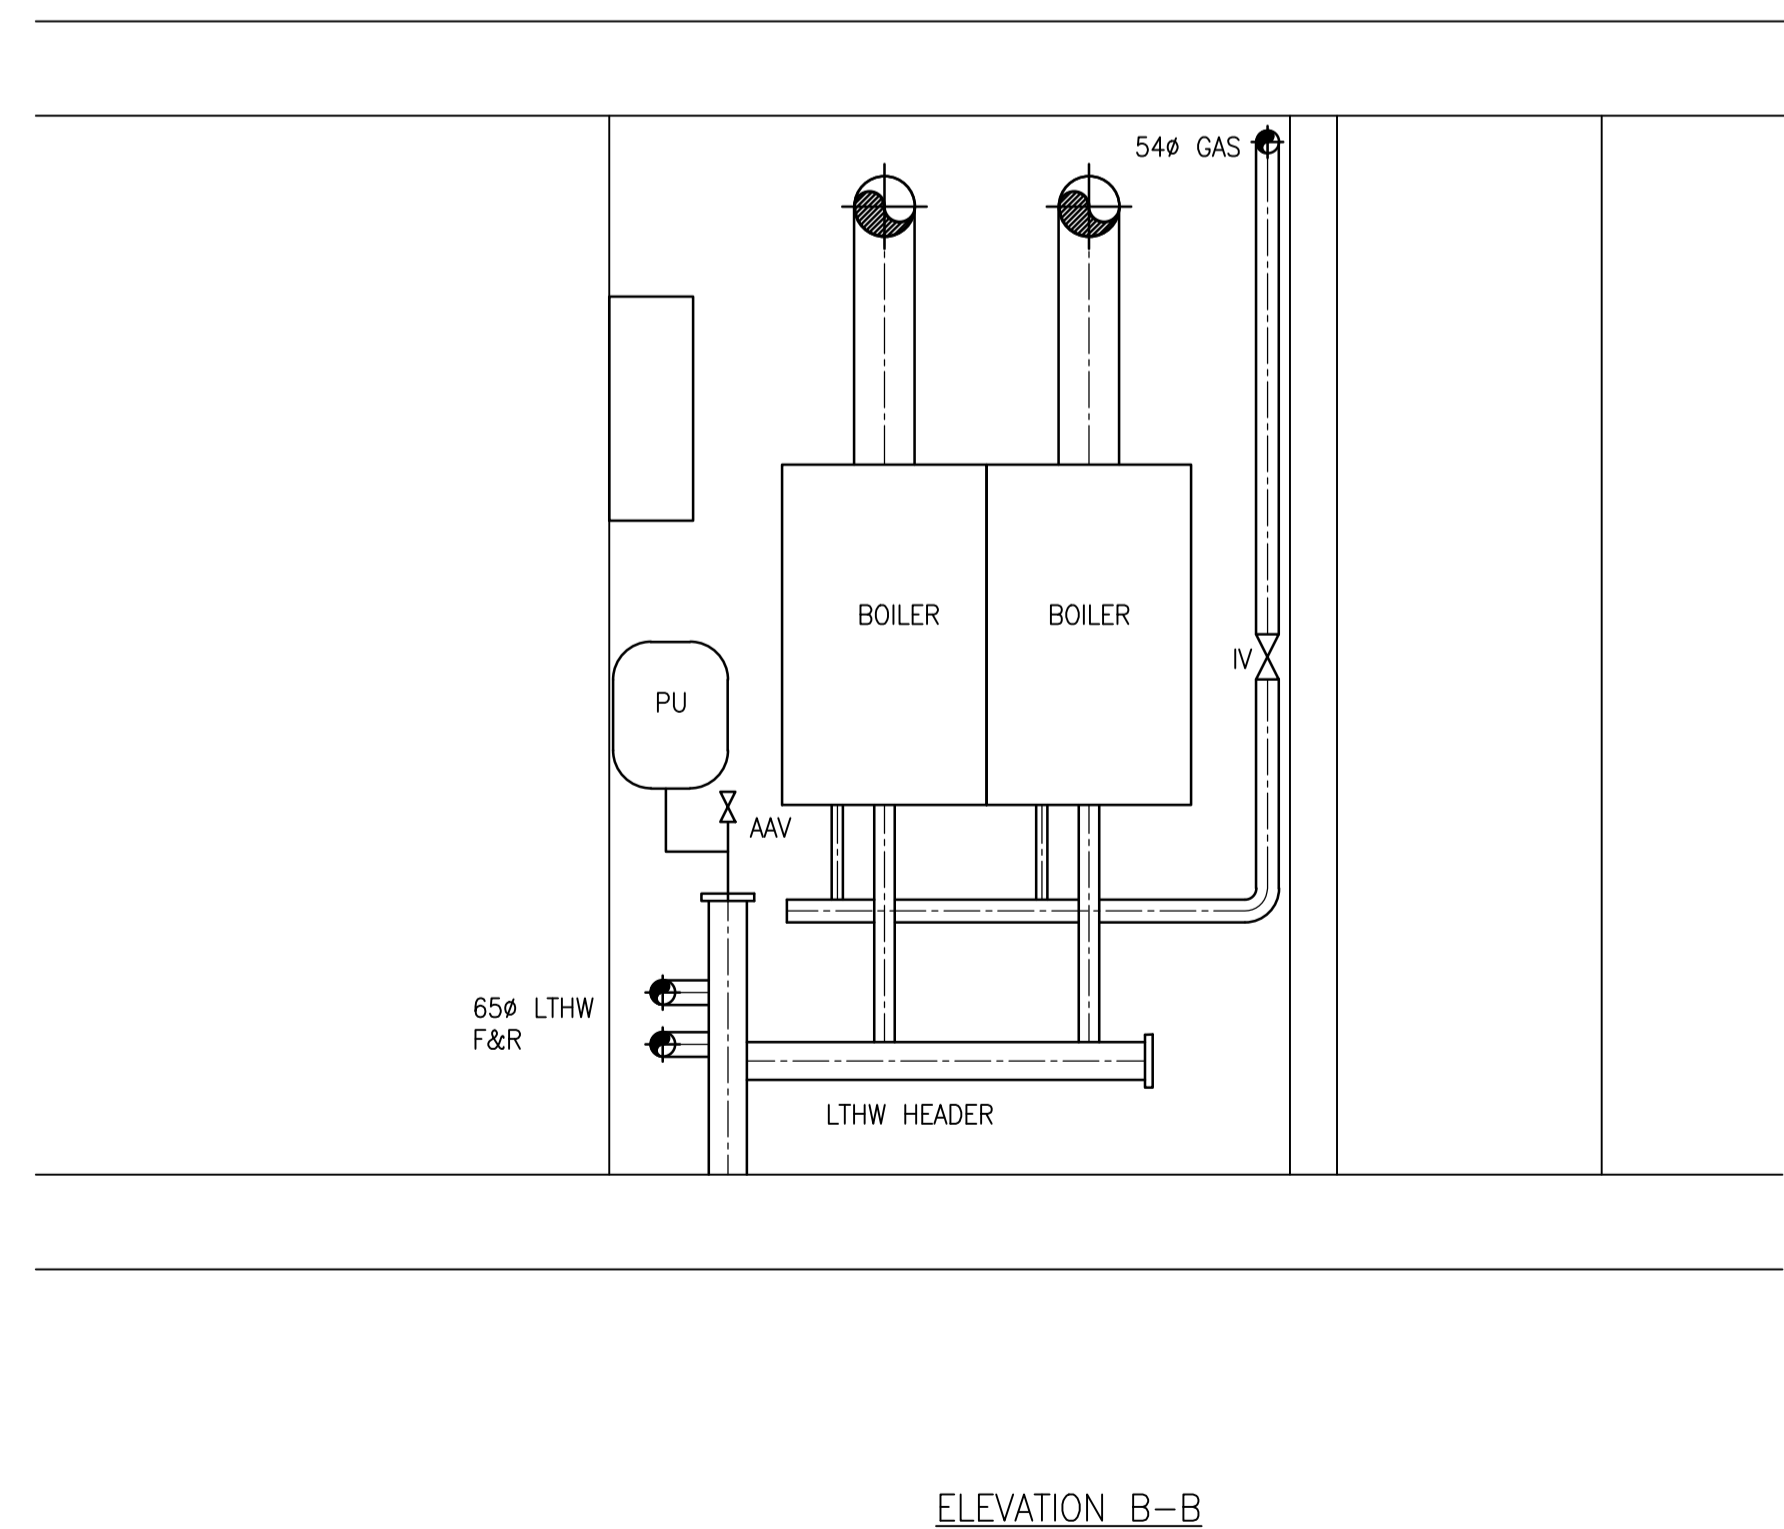

RD1	RECORD DRAWING	20/10		
REV	DESCRIPTION	DATE		
STATUS				
RECORD DRAWING				
Sale Service & Maintenance Ltd Sale House 25 Upper Mulgrave Road Cheam, Surrey SM2 7AY Tel 0203 892 7888 www.salegroup.co.uk				
CLIENT				
ISG				
PROJECT				
ACADEMIC HOUSE CAT B REFURBISHMENT				
TITLE				
SIXTH FLOOR PLANT ROOM LAYOUT				
SCALE:	SIZE:	DATE:	DRAWN:	CHECKED:
1:20		APR 17 17	CMB	TH
JOB:	DRAWING:	REV:		
MJ5150	6000-DRG-112	RD1		