

# PRELIMINARY

## NOTES

- THIS DRAWING IS TO BE READ IN CONJUNCTION WITH ALL ENGINEERS & ARCHITECTS DRAWINGS FIGURED DIMENSIONS ONLY (NOT SCALING) TO BE USED. WHERE A CONFLICT OF INFORMATION EXISTS OR IF IN ANY DOUBT - 'ASK'.
- CONSULTANTS TO BE INFORMED IMMEDIATELY OF ANY DISCREPANCIES BEFORE WORK PROCEEDS.

## CIVIL LEGEND

EX. FOUL MANHOLE	Ex.F	○
EX. FOUL PIPE	PIPE DESCRIPTION	---
NEW FOUL MANHOLE	F	●
NEW FOUL PIPE	PIPE DESCRIPTION	---
EX. SURFACE WATER MANHOLE	Ex.S	□
EX. SURFACE WATER PIPE	PIPE DESCRIPTION	---
NEW SURFACE WATER MANHOLE	S	■
NEW SURFACE WATER PIPE	PIPE DESCRIPTION	---
EX. COMBINED MANHOLE	Ex.C	□
EX. COMBINED PIPE	PIPE DESCRIPTION	---
NEW COMBINED MANHOLE	C	■
NEW COMBINED PIPE	PIPE DESCRIPTION	---
NEW RISING MAIN	PIPE DESCRIPTION	---
PIPE CROSSOVER	---	---
EX. ROOF RAIN WATER MANHOLE	Ex.R	□
EX. ROOF RAIN WATER PIPE	PIPE DESCRIPTION	---
NEW ROOF RAIN WATER MANHOLE	R	■
NEW ROOF RAIN WATER PIPE	PIPE DESCRIPTION	---
FOUL ACCESS JUNCTION	AJ	◇
SURFACE ACCESS JUNCTION	AJ	◇
RAINWATER PIPE	RWP	○
SOIL VENT PIPE	SVP	●
ROAD GULLEY	RG	■
BACK INLET GULLEY TRAP	BIGT	◇
FOUL RODDING EYE	RE	●
SURFACE RODDING EYE	RE	●
GULLEY TRAP	GT	■
EXISTING UKPN HV CABLES	---	---
UKPN DUCT	---	---
COMMS DUCT	---	---
WATER PIPE	---	---
GAS DUCT	---	---

## PIPE SIZES AND FALLS TBC

P1	10/11/17	ISSUED FOR COMMENT	EP	SL
ISSUE	DATE	DESCRIPTION	DRN	P.E.
			ORIG	P.D.

ISSUE STATUS	<input checked="" type="checkbox"/> PRELIMINARY (P1, P2, P3 etc.)	<input type="checkbox"/> PLANNING (PL1, PL2, PL3 etc.)
	<input type="checkbox"/> TENDER (T1, T2, T3 etc.)	<input type="checkbox"/> CONSTRUCTION (C0, 1, 2 etc.)

**Barrett Mahony** Consulting Engineers, Civil, Structural, Project Management.  
 E-mail: info@bmceuk.com Web: www.bmceuk.com  
 London Office: 12 Mill Street, London SE1 2AY, United Kingdom  
 Tel: +44 (0) 20 3750 3530  
 Dublin Office: Sandwith House, 52-54 Lower Sandwith Street, Dublin 2, Ireland.  
 Tel: (01) 677 3200 Fax: (01) 677 3164




CLIENT  
**BRIAN COYNE AND KIRSTY MITCHELL**

PROJECT TITLE  
**No. 35 TEMPLEWOOD AVENUE  
 NW3 7UY, LONDON**

DRAWING TITLE  
**PROPOSED DRAINAGE PLAN  
 GROUND FLOOR**

SCALE @ A1	JOB NO.	DRAWING NO.	ISSUE
AS SHOWN	<b>16848</b>	<b>C-1001</b>	<b>P1</b>

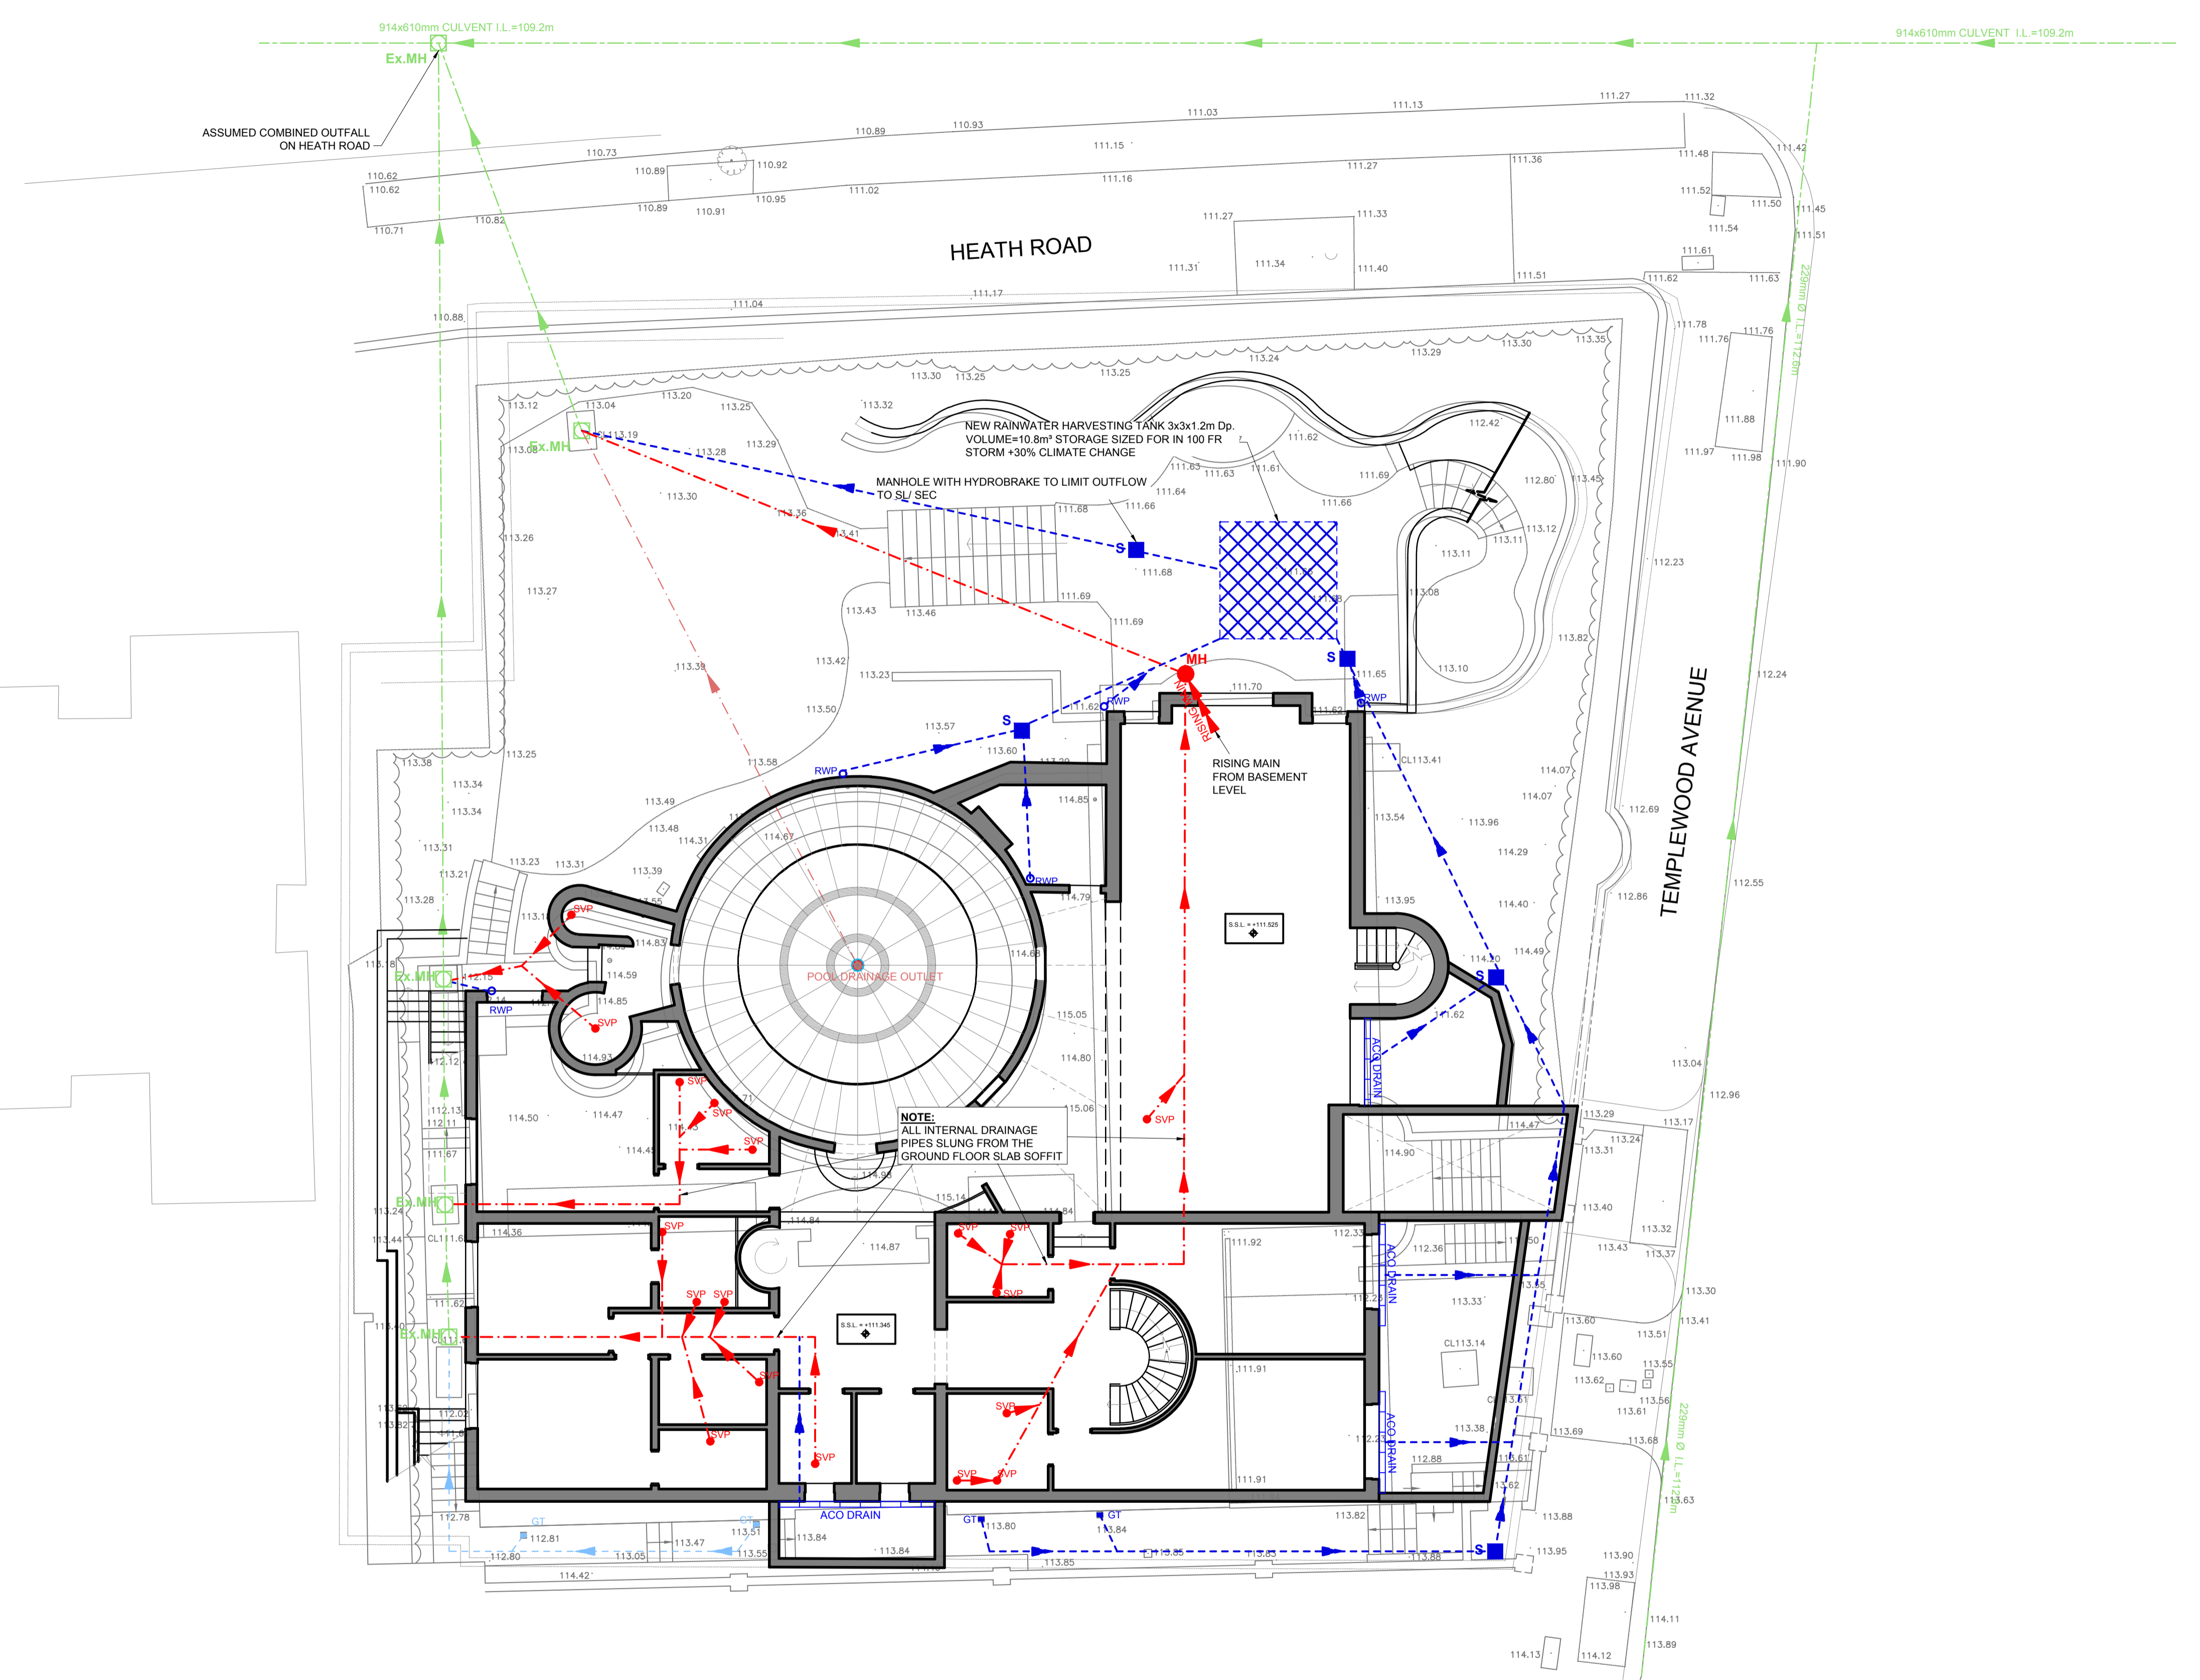

## PROPOSED GROUND FLOOR DRAINAGE PLAN

(SCALE @ A1: 1:100)  
 (SCALE @ A3: 1:200)