


# PRELIMINARY

## NOTES

- THIS DRAWING IS TO BE READ IN CONJUNCTION WITH ALL ENGINEERS & ARCHITECT'S DRAWINGS FIGURED DIMENSIONS ONLY (NOT SCALING) TO BE USED. WHERE A CONFLICT OF INFORMATION EXISTS OR IF IN ANY DOUBT - 'ASK'.
- CONSULTANTS TO BE INFORMED IMMEDIATELY OF ANY DISCREPANCIES BEFORE WORK PROCEEDS.

## CIVIL LEGEND

EX. COMBINED MANHOLE	Ex.C
EX. COMBINED PIPE	PIPE DESCRIPTION
EX. SURFACE WATER PIPE	PIPE DESCRIPTION
RAINWATER PIPE	RWP
GULLEY TRAP	GT
EX. FOUL MANHOLE	Ex.MH
NEW FOUL MANHOLE	F
NEW FOUL PIPE	PIPE DESCRIPTION
NEW RISING MAIN	PIPE DESCRIPTION
SOIL VENT PIPE	SVP
NEW COMBINED MANHOLE	C

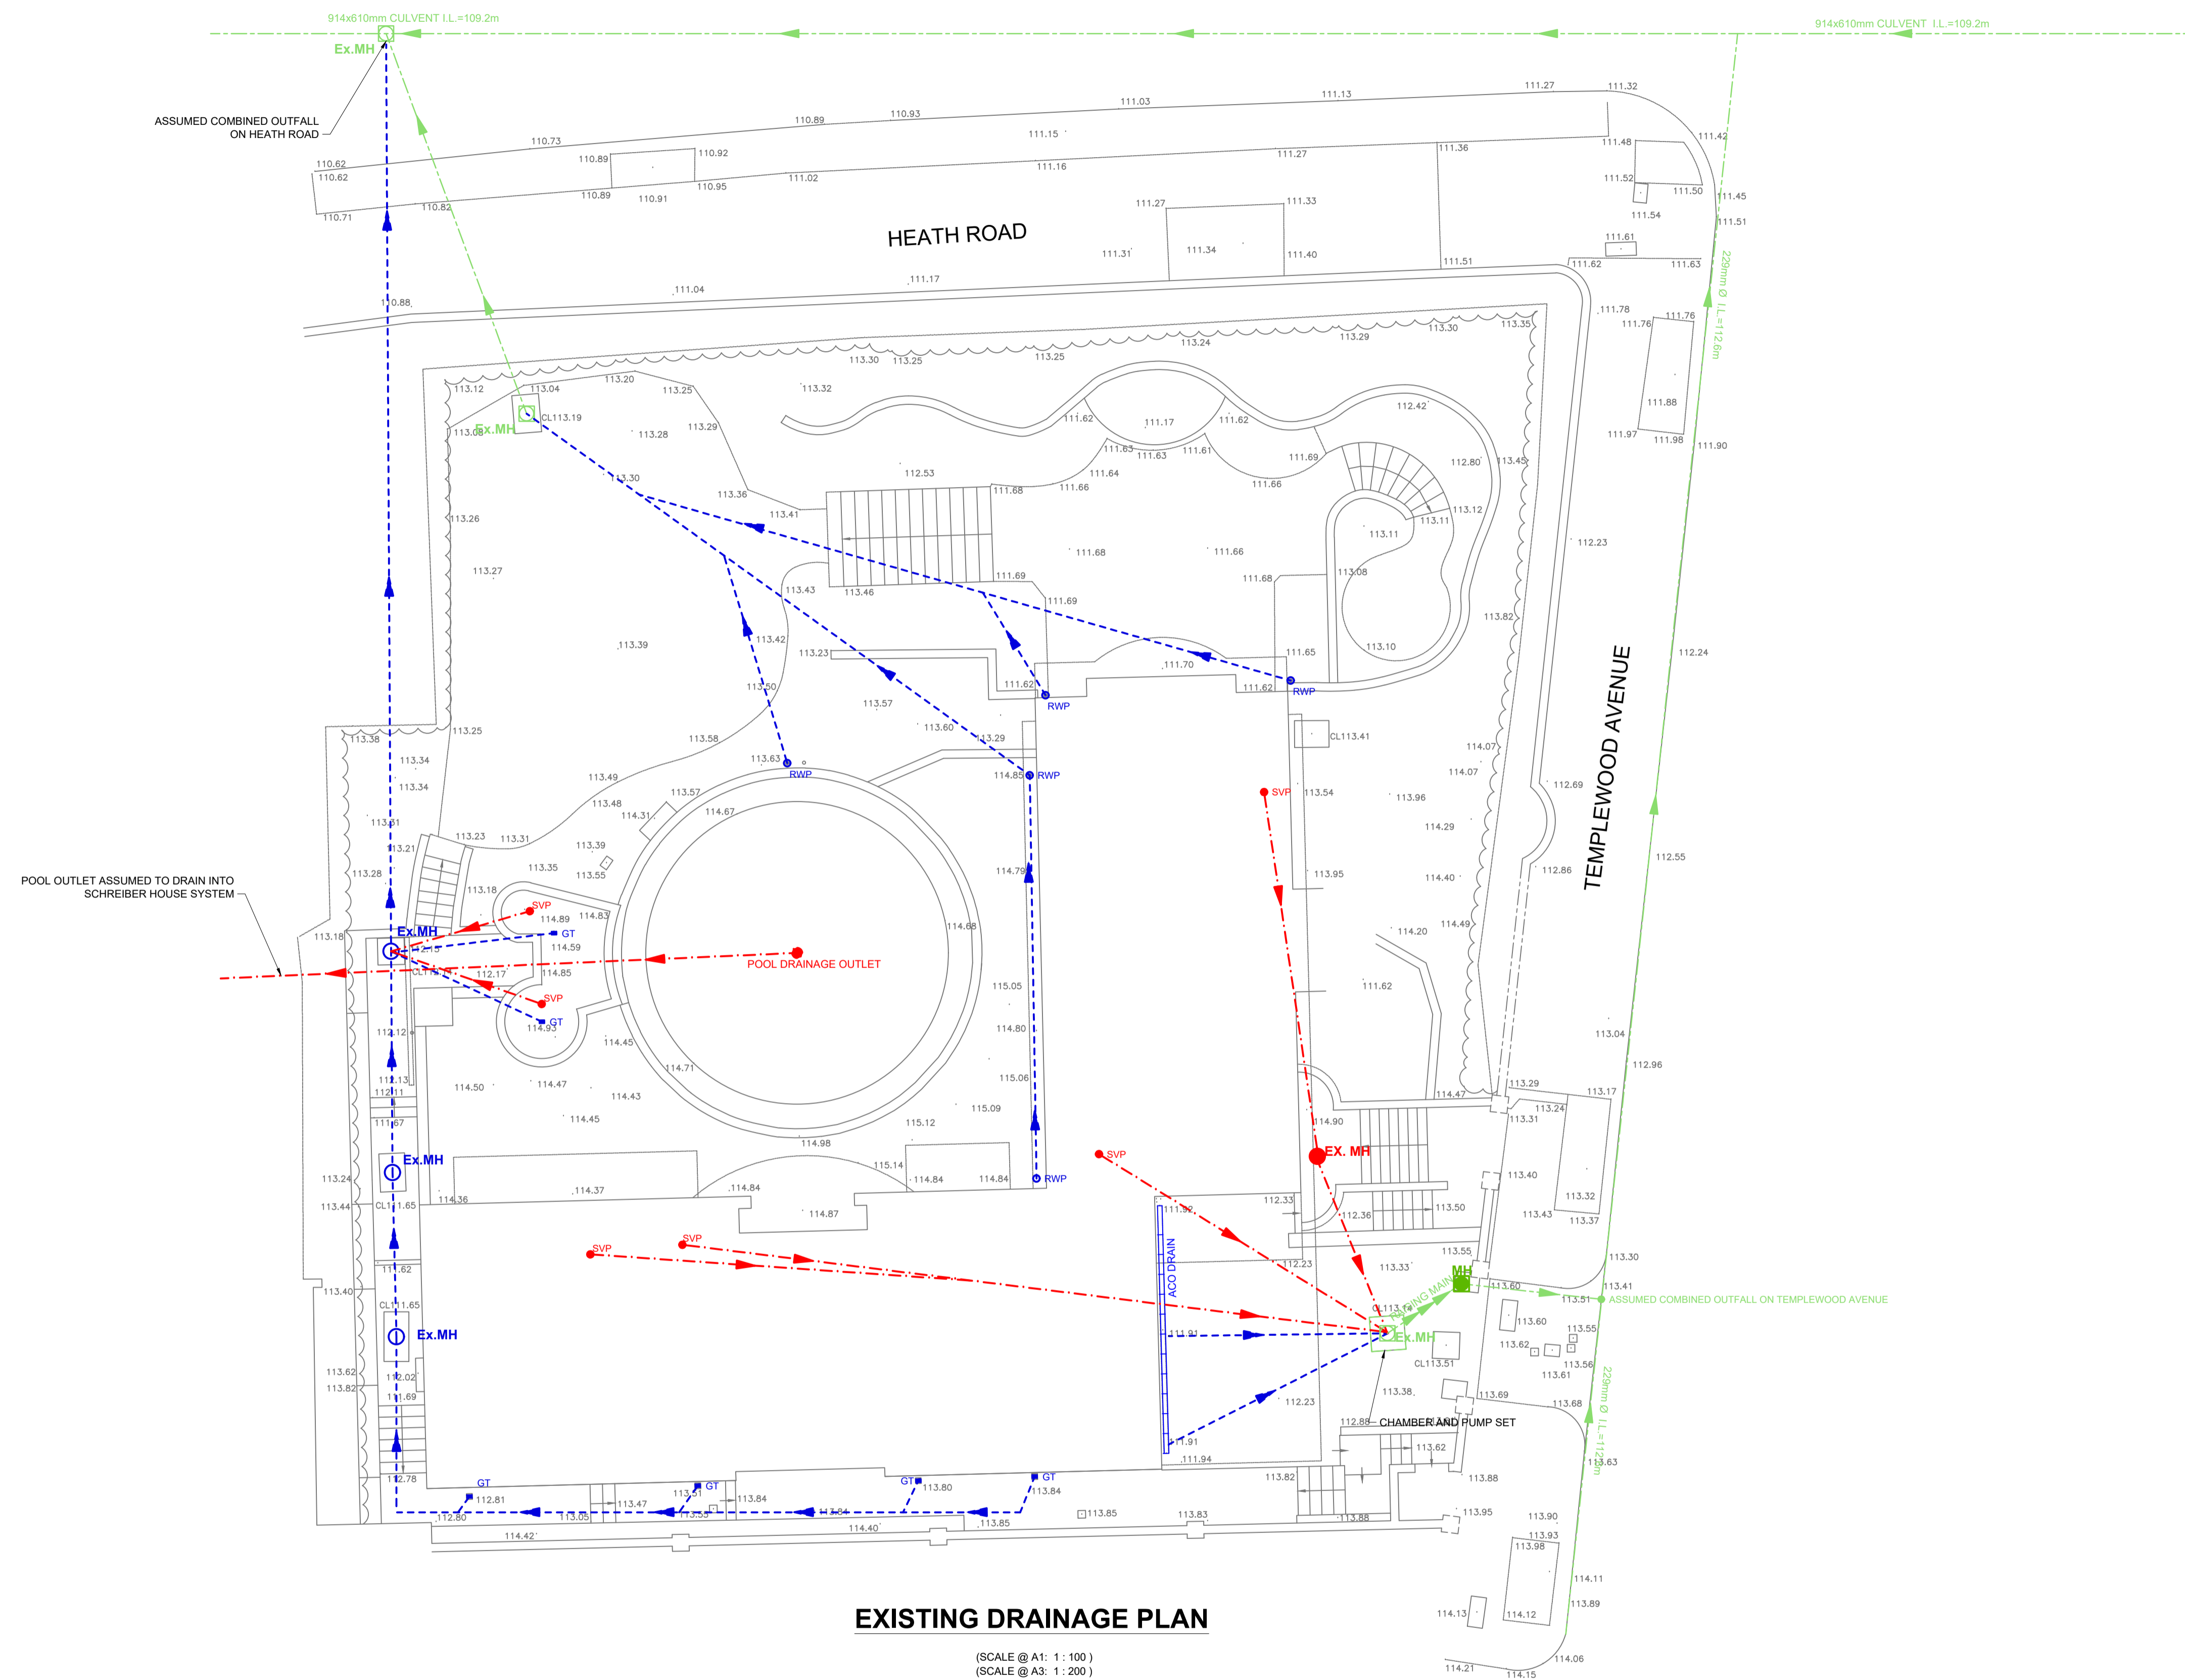

### EXISTING DRAINAGE PLAN

(SCALE @ A1: 1:100)  
(SCALE @ A3: 1:200)

ISSUE	DATE	DESCRIPTION	DRN	EP	PE	P.D.
P2	14/11/17	ISSUED FOR COMMENT				
P1	10/11/17	ISSUED FOR COMMENT				

ISSUE STATUS:  PRELIMINARY (P1, P2, P3 etc.)  PLANNING (PL1, PL2, PL3 etc.)  
 TENDER (T1, T2, T3 etc.)  CONSTRUCTION (C1, C2 etc.)

**Barrett Mahony** Consulting Engineers, Civil, Structural, Project Management.  
E-mail: info@bmcuk.com Web: www.bmcuk.com  
London Office: 12 Mill Street, London SE1 2AY, United Kingdom  
Tel: +44 (0) 20 3750 3530  
Dublin Office: Sandwith House, 52-54 Lower Sandwith Street, Dublin 2, Ireland.  
Tel: (01) 677 3200 Fax: (01) 677 3164



CLIENT  
**BRIAN COYNE AND KIRSTY MITCHELL**

PROJECT TITLE  
**No. 35 TEMPLEWOOD AVENUE  
NW3 7UY, LONDON**

DRAWING TITLE  
**EXISTING DRAINAGE PLAN**

SCALE @ A1 AS SHOWN	JOB NO. <b>16848</b>	DRAWING NO. <b>C-1000</b>	ISSUE <b>P2</b>
------------------------	-------------------------	------------------------------	--------------------