

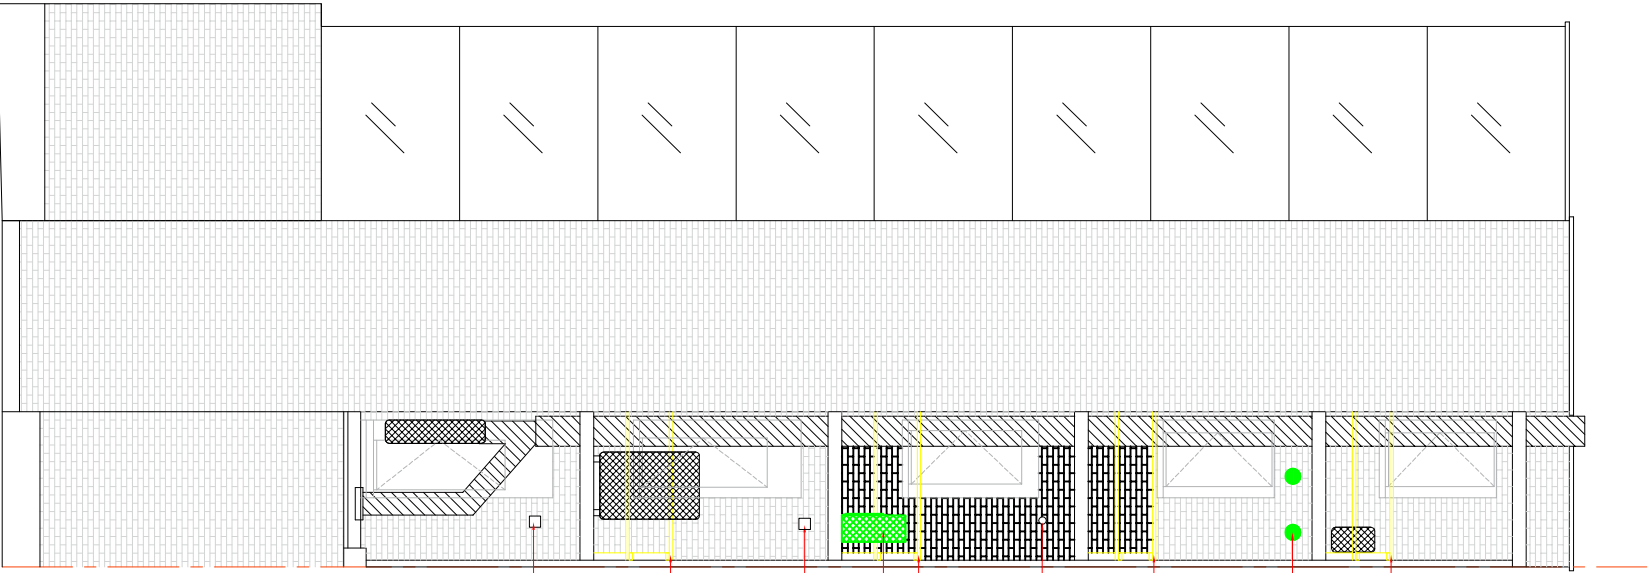
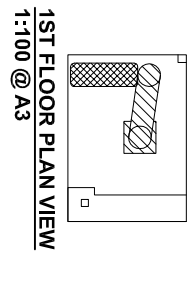
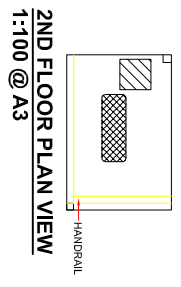
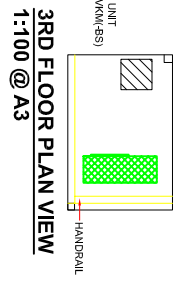


**SIDE ELEVATION**  
1:100 @ A3

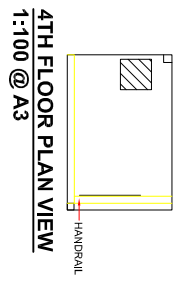

**REAR ELEVATION**  
1:100 @ A3

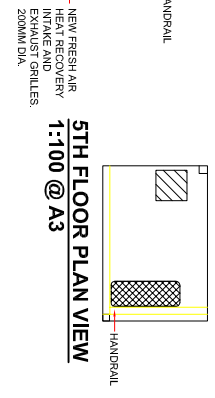

LEGEND  
 AC UNIT  
 DUCTWORK

Note:  
 Do not scale from this drawing. All dimensions to be checked on site.  
 This drawing is protected under Copyright and cannot be reproduced or copied without permission.

**Revisions**

No.	Description	Date



Office Design | Office Fit Out  
 Stabb Limited,  
 10 Northington Street  
 London WC1N 2JG.

t: +44 (0)20 7952 1500

Client  
 Nordic Cryobank  
 Project  
 48 Gray's Inn Road  
 London W1CX 8LT

Drawing  
 Proposed Elevations - AC units  
 and duct positions

Scale	1:100 @ A3	Date	Jul 2017
Project no.	S4354	Status	SK
Dwg no.	5-000	Rev	A

Size A3