

Services legend

	Twin 13A Socket
	Fused Connection unit - switched
	Extract Fan
	Shaver Socket
	Television Socket
	Phone Socket
	Fuse board
	Gas point with isolator

Security legend

	Vibration Sensors
	Alarm Panic Alarm
	Alarm Keypad
	Alarm PIR
	Alarm Door Contacts

Lighting legend


	Pendant Fitting
	Decorative Wall Light
	Recessed Spot Lights
	Micro Spot Lights
	Single 5Amp Socket
	Under Floor Heating Thermostat

**EXISTING ELECTRICS SHOWN IN BLUE**  
 all retained existing electrical points including sockets switches and light fittings to be removed and rewired with new fittings installed

**PROPOSED ELECTRICS SHOWN IN GREEN**  
 all new low level electrical points to be installed surface mounted to existing skirting boards and placed as close to original sockets as possible.  
 no new electrical points to be fitted to existing paneling  
 all sockets to be fitted within new jainery have been noted on the electrical plan

**1 Proposed Electrical Layout**  
 Scale: 1:50 @ A1 & 1:100 @ A3

Notes:  
 Copyright of this drawing and the contents remain with Pennington Phillips Limited.  
 Do not scale from the drawings. The contractor is to verify dimensions on site prior to the commencement of work. Any discrepancies are to be reported to the designer. If in doubt - seek clarification.

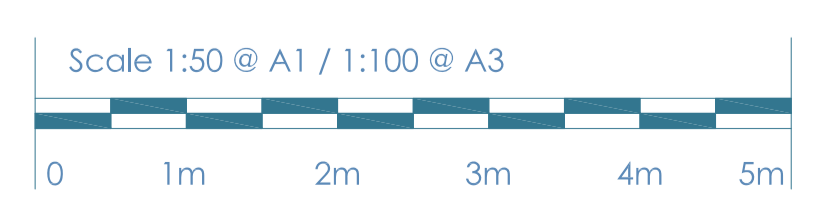

Rev.	Date	Remarks
A	30/10/17	Surface mounted electrical sockets

Client:	Drawing Number:
Project:	5879/16
Flat 4, 55 Fitzjohns Avenue, London NW3 6PH	Revision:
Drawing:	A
Proposed Electrical Layout	Date:
	18/09/17
	Status:
	Planning