



ground floor plan

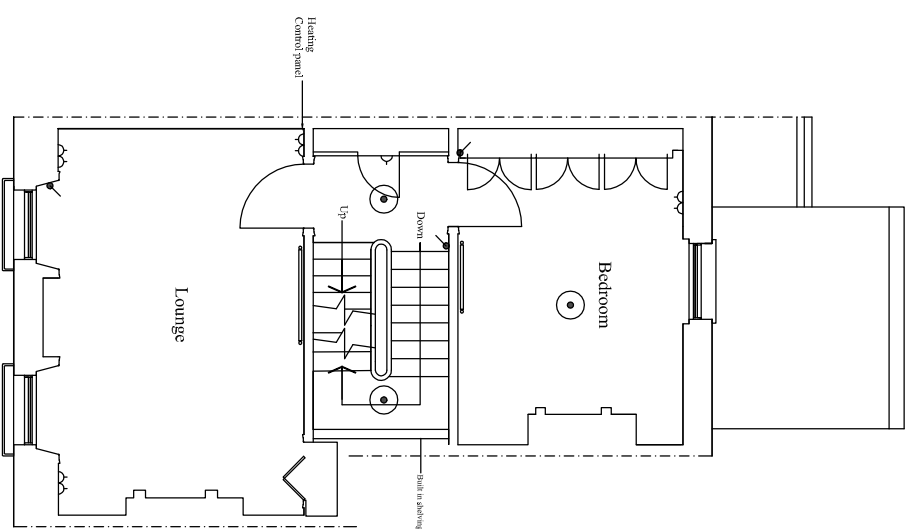



first floor plan

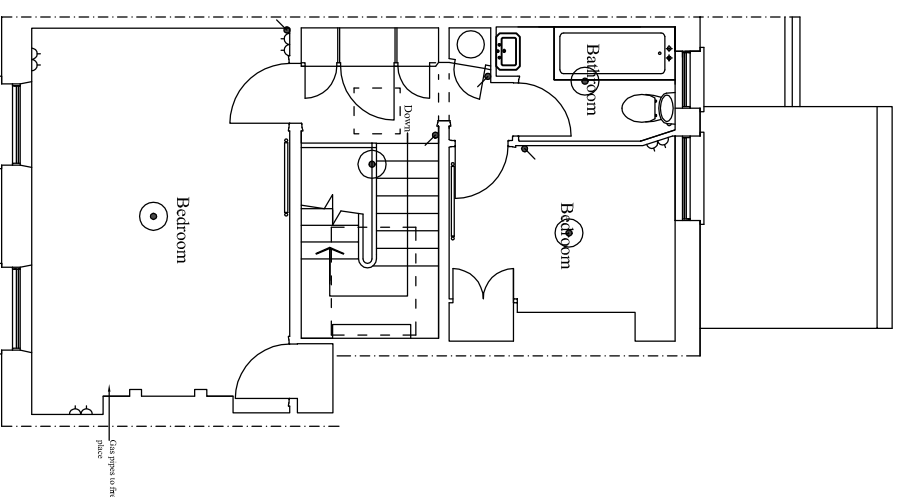


second floor plan

KEY	
	Double switched socket outlet
	5 Amp socket
	Fixed Spur
	Shaver socket
	Single switched socket
	Switch
	Radiators
	wall lights
	Recess downlights
	Feature lighting
	Gas point
	TV point
	Towel rail
	Heat detector
	Smoke detector
	Emergency Lighting
	Extract fan (section/plan)

 Scale 1:1000 @ A3 & 1:500 @ A1

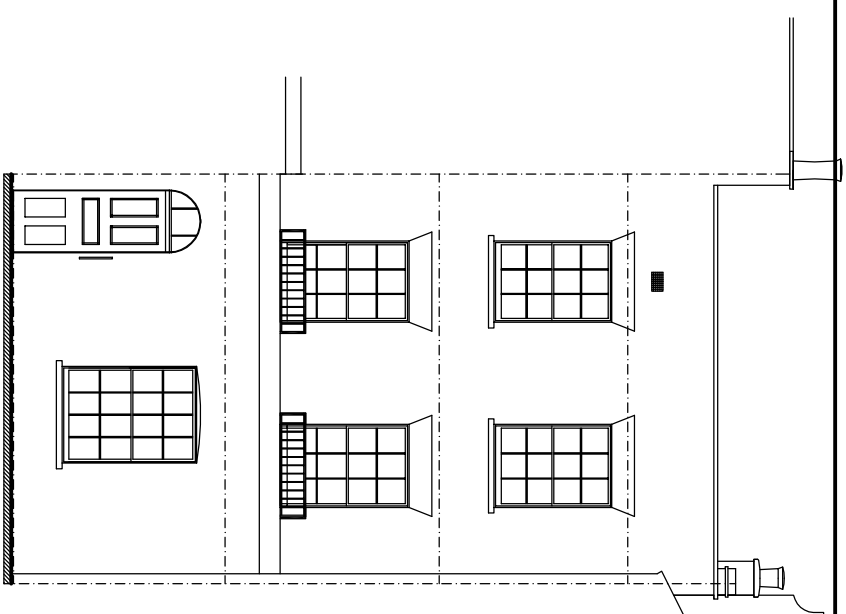

front elevation

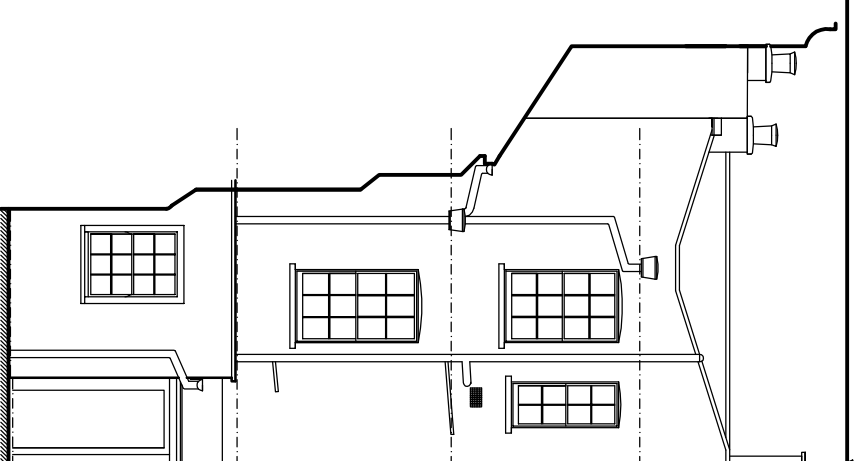

rear elevation

project	5 Holly Place, London NW3
date	December 2017
scale	1:100 @ A3 & 1:50 @ A1
client	SURVEYED AS EXISTING, INCLUDING ELECTRICAL FITTINGS
architect	<b>STEVEN GRAY</b> ARCHITECTURAL & SURVEYING SERVICES 36 Ladbroke Crescent, Bayswater, London W2 Tel: 020 3371 0629 Email: steven@sgay-designs.co.uk Web: www.sgray-designs.co.uk
drawing number	2352/1