


existing
HVAC plant equipment elevation CC
scale 1:50

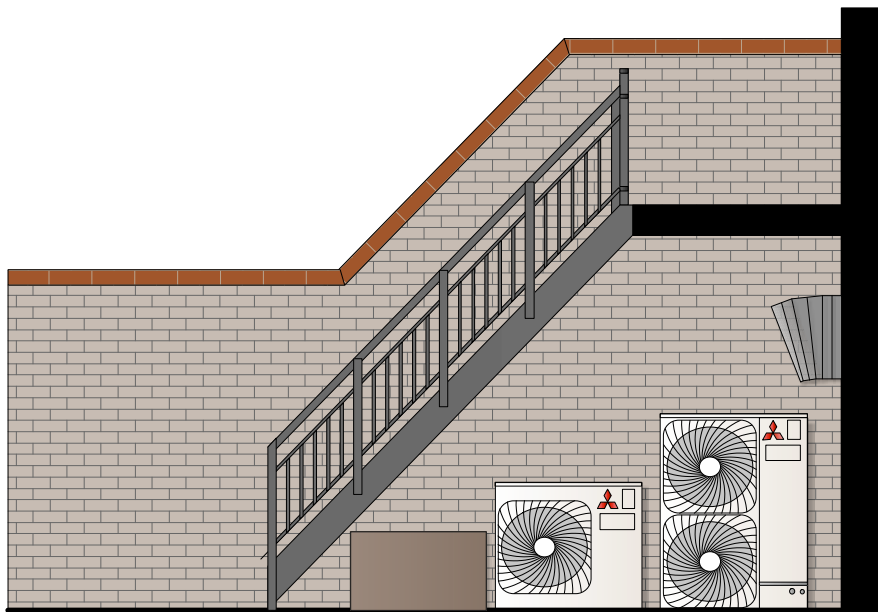

existing
HVAC plant equipment elevation BB
scale 1:50




existing
HVAC plant equipment elevation AA
scale 1:50

PLANT KEY:

CU1	existing - mitsubishi fdc200vs double unit 970w x 370d x 1300h
CU3	existing - mitsubishi fdc100vs single unit 970w x 370d x 845h

REVISIONS

 A: elevations revised & side elevation CC added.



PROJECT
★ PRET A MANGER ★

LOCATION
KENTISH TOWN
341 KENTISH TOWN ROAD LONDON NW5 2TJ

TITLE
existing HVAC plant area
elevations


DRAWING No.
TD17-PM57-7.2

REVISION	DATE	SCALE @ A3
A	03.01.18	1:100



All dimensions to be confirmed on site by Contractor.
Structural works to be confirmed by Structural Engineer.
All elements to comply with statutory requirements.

Copyright Tanner Design Limited
2b/4b Gosport Street Lymington Hampshire SO41 9BE
tel. 01590 689609 email. studio@tannerdesign.co.uk
www.tannerdesign.co.uk

Tannerdesign

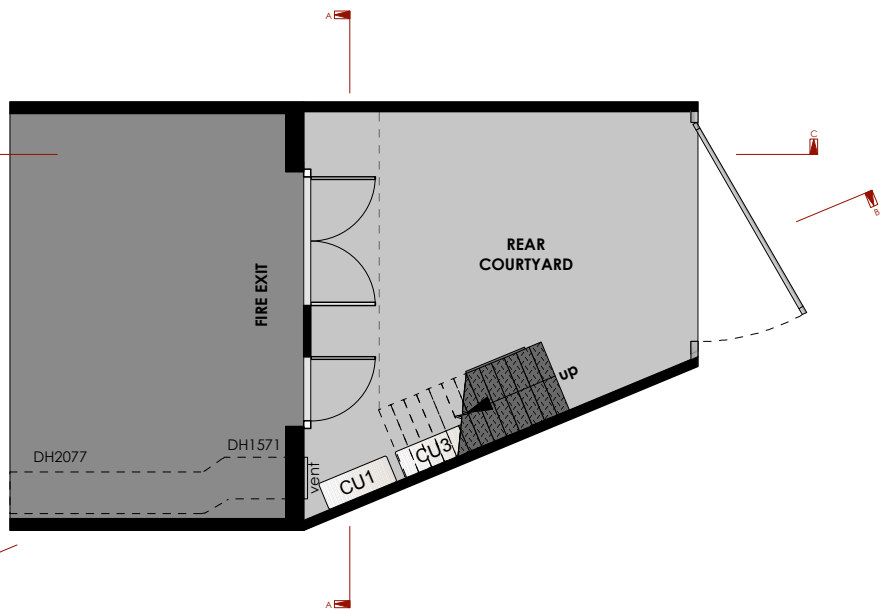

existing
key plan
scale 1:100

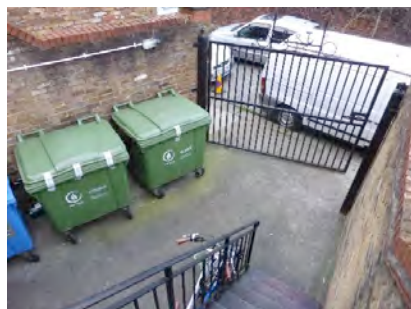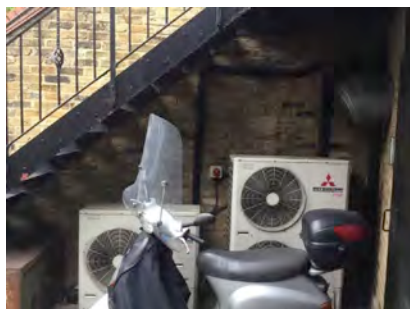

existing
plant area photos