


10 RUGBY STREET TYPICAL TIMBER PANELLING DETAIL

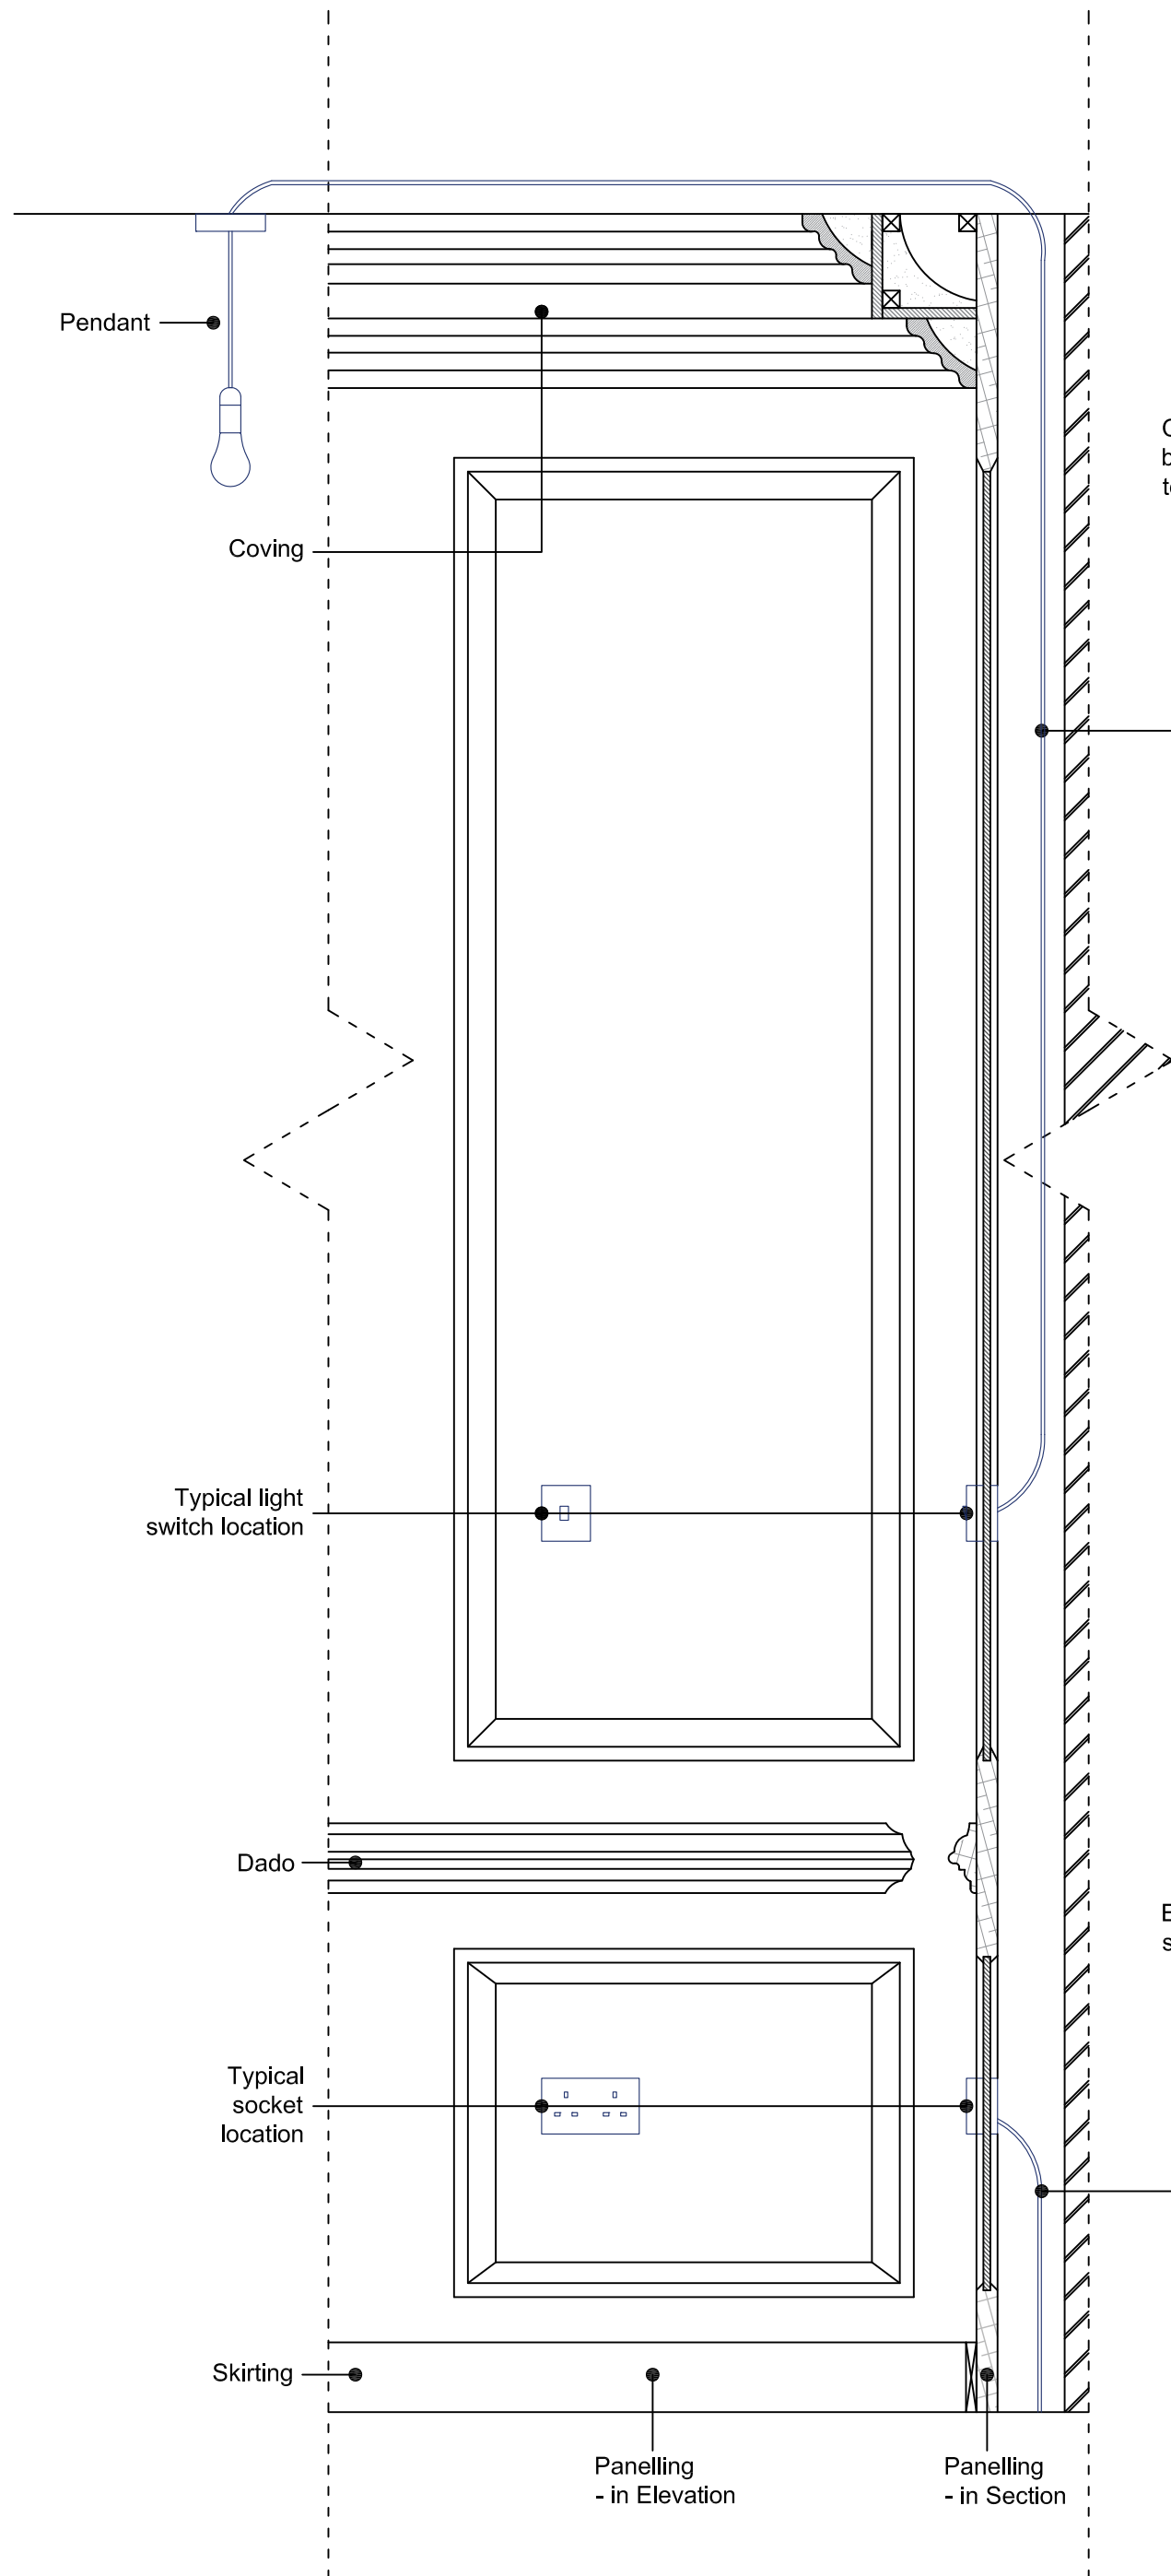

Cables for lighting assumed to pass behind timber panelling, into ceiling void to feed pendant light fittings.

Existing cables fed behind panelling to sockets, fed from floor void below.

CONTRACTORS TO VERIFY ALL DIMENSIONS ON SITE BEFORE COMMENCING ANY WORKS OR PREPARING SHOP DRAWINGS. ALL WORK MUST COMPLY WITH RELEVANT AUTHORITIES REQUIREMENTS. DIMENSIONS MUST NOT BE SCALED FROM THIS PRINT

LANDERS
AND ASSOCIATES

Architecture, Building Surveying, Interior Design, Building Defects and Project Co-ordination
 RAPIER HOUSE, 40-46 LAMBS CONDUIT STREET
 LONDON WC1N 3LJ
 TEL: 020 7831 6311 FAX: 020 7831 1826

Client The Governing Body of Rugby School
 c/o Farebrother

Project Flat1, 10 Rugby Street, London WC1N
 Electrical Re-Wire

Drawing Timber Panelling Detail
 Existing Electrical layout

| | | | |
|-----------|----------|-------|---------|
| Scale | Date | Drawn | Checked |
| 1:10 @ A3 | 08.01.18 | MN | RS |

Drawing No.
 17074/05

