


LEGEND	
	Electrical mains / meter
	Electrical distribution
	Gas meter
	1 gang / 2 gang switched socket outlet
	1 gang / 2 gang switched socket outlet above worktop level / high level.
	Unswitched fused connection unit
	Switched fused connection unit
	Telecom outlet
	TV co-axial point
	Mechanical extraction fan - ceiling / wall mounted
	Ceiling mounted smoke detector
	Shaver point / shaver point integral to light fitting
	Large pendant / chandelier.
	Pendant light fitting.
	Recessed low voltage spotlight
	Bulkhead light fitting.
	Track and spotlights.
	Light switch
	Intruder Alarm Keypad
	Telecom Box
	Heating thermostat / controls

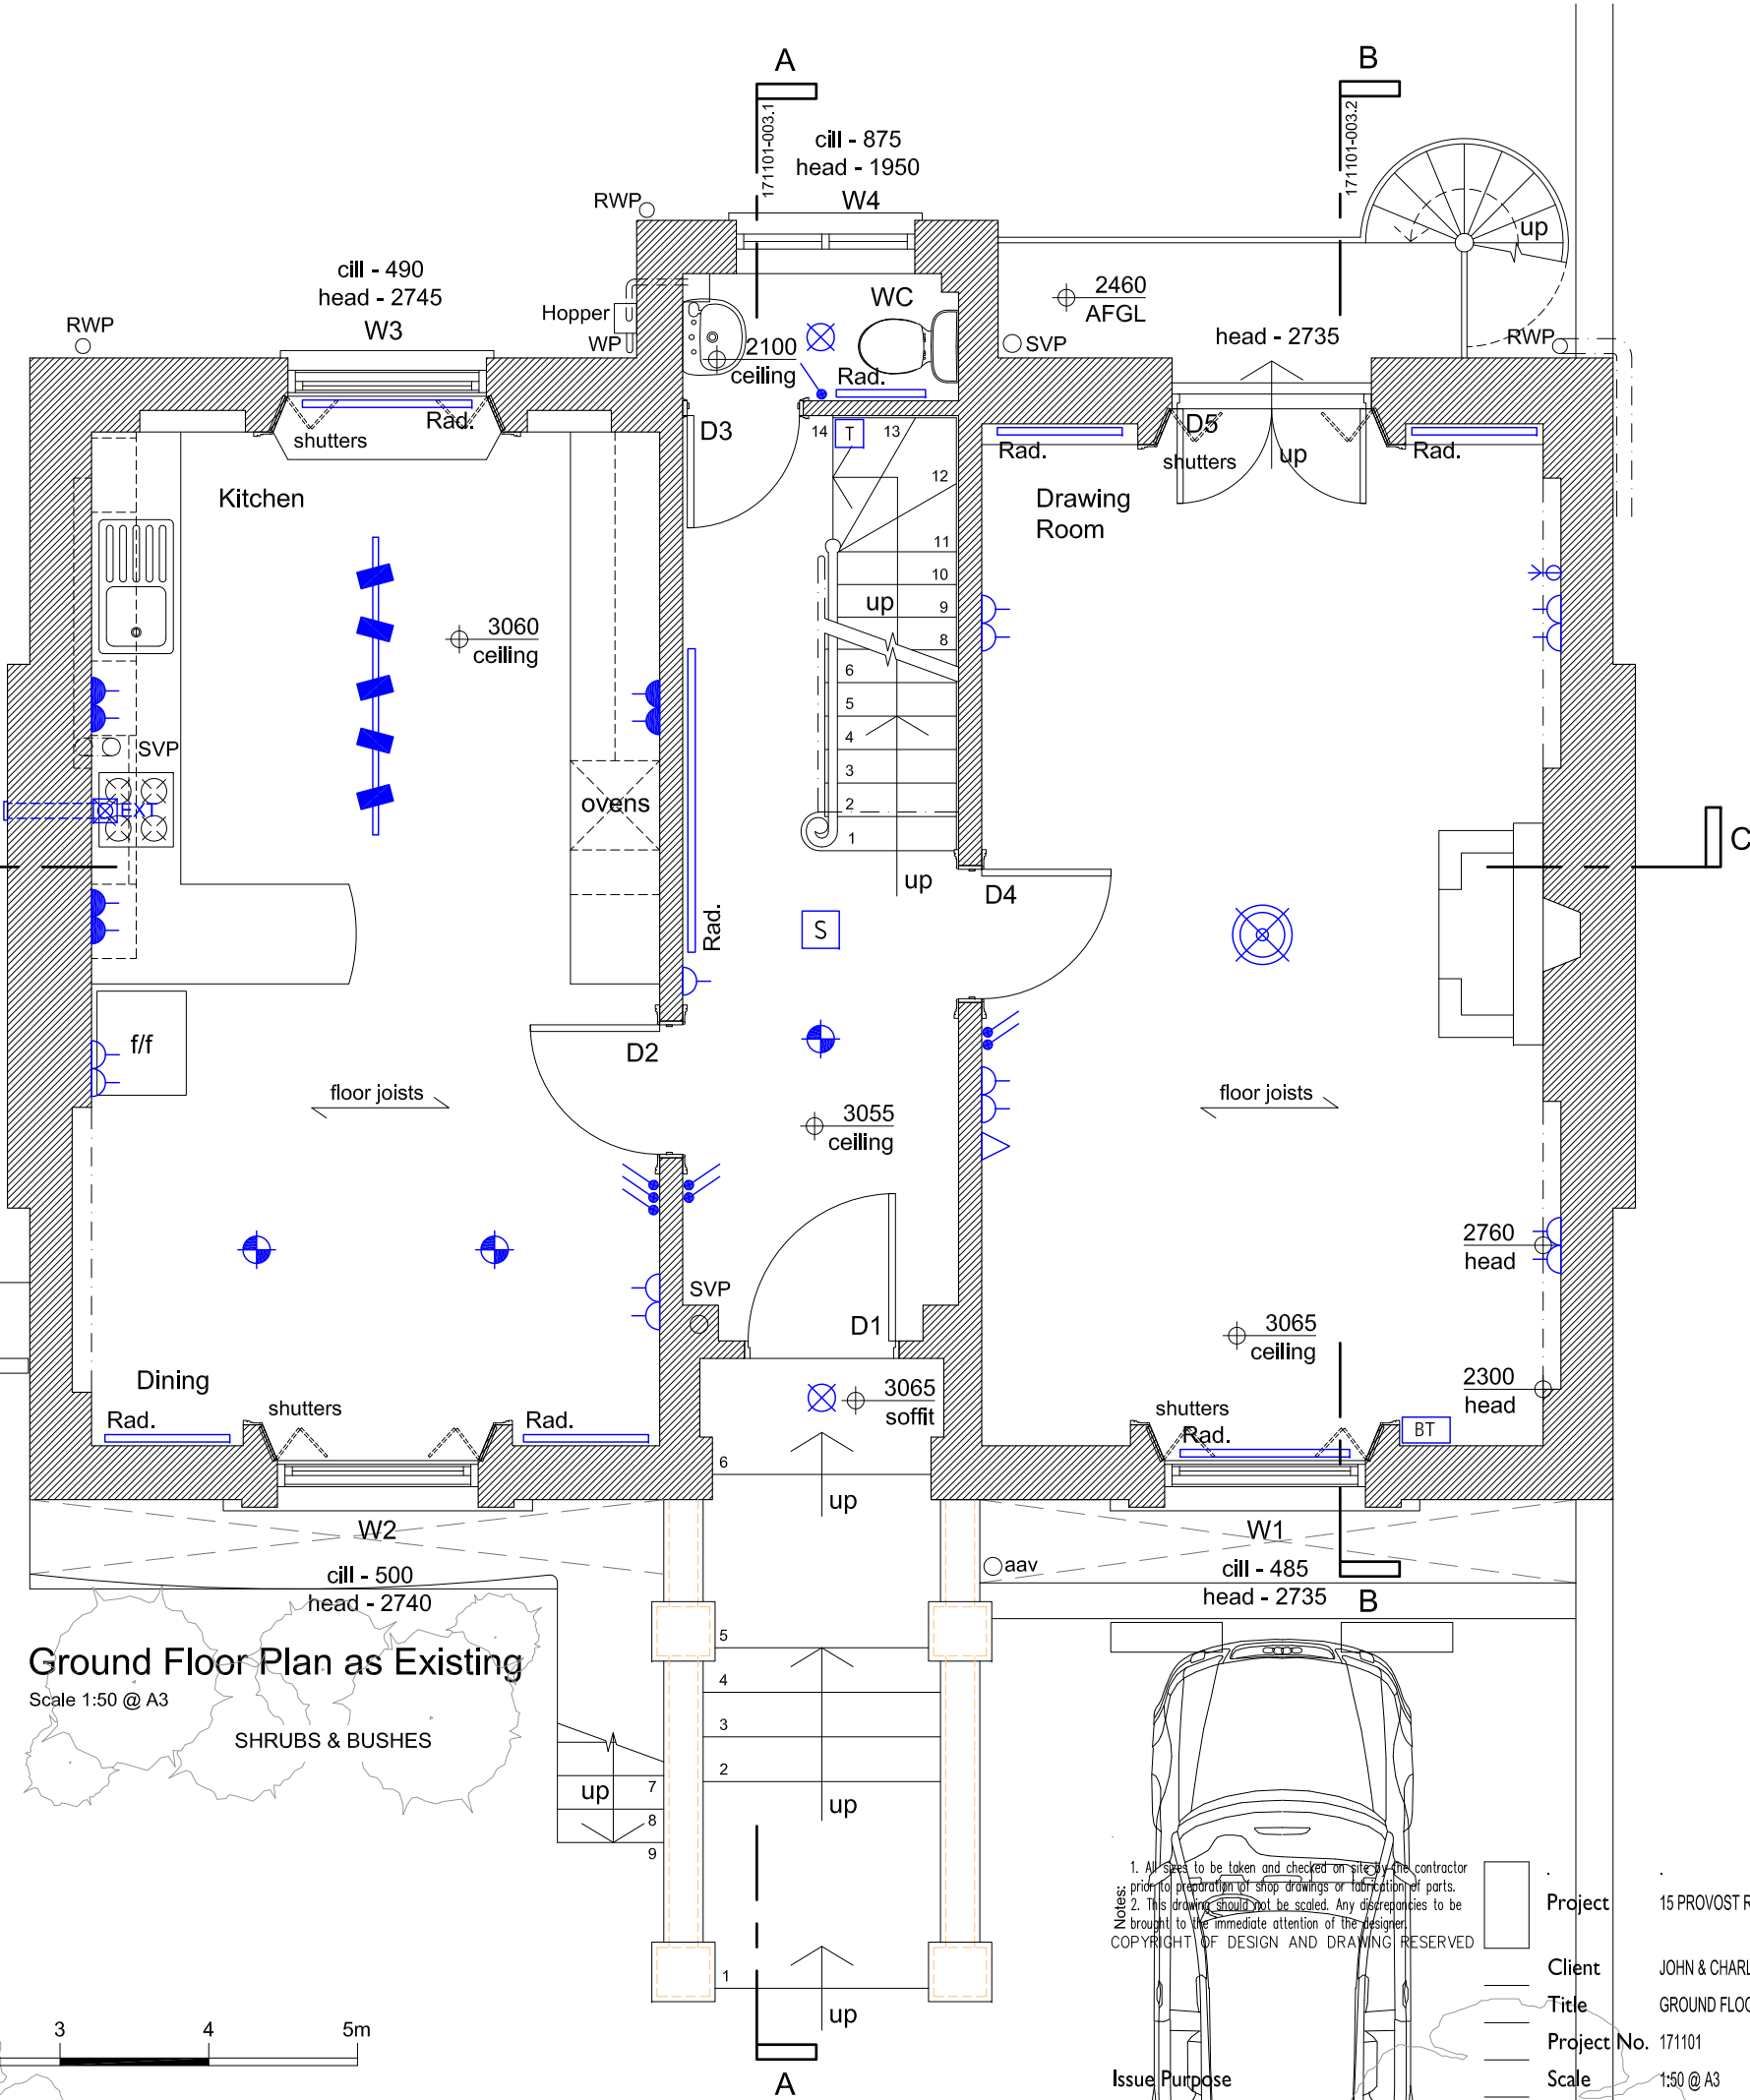

Ground Floor Plan as Existing
Scale 1:50 @ A3
SHRUBS & BUSHES

Notes:
1. All sites to be taken and checked on site by the contractor prior to preparation of shop drawings or fabrication of parts.
2. This drawing should not be scaled. Any discrepancies to be brought to the immediate attention of the designer.
COPYRIGHT OF DESIGN AND DRAWING RESERVED

Issue Purpose
PLANNING

Project 15 PROVOST RD, LONDON NW3 4ST
Client JOHN & CHARLOTTE VOHRYZEK-SAMUEL
Title GROUND FLOOR PLAN AS EXISTING
Project No. 171101
Scale 1:50 @ A3
Drawn CAD

Dwg. No. 171101-001.2
Date NOV 2017
Revision

absolute detail
t + f 01628 528492
m 07824 641414
e alison@absolutedetail.me
w absolutedetail.me

0 1 2 3 4 5m
Scale 1:50