




rear elevation

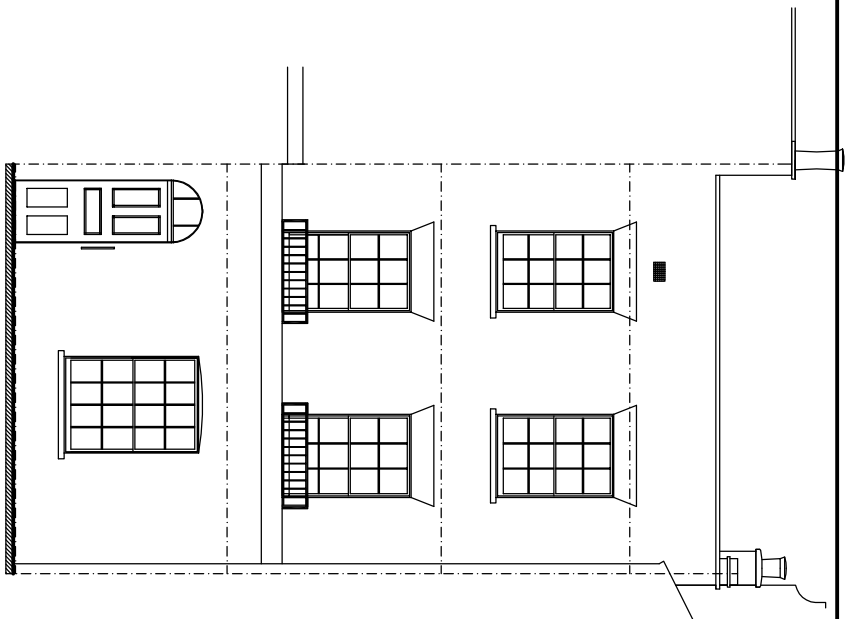


front elevation

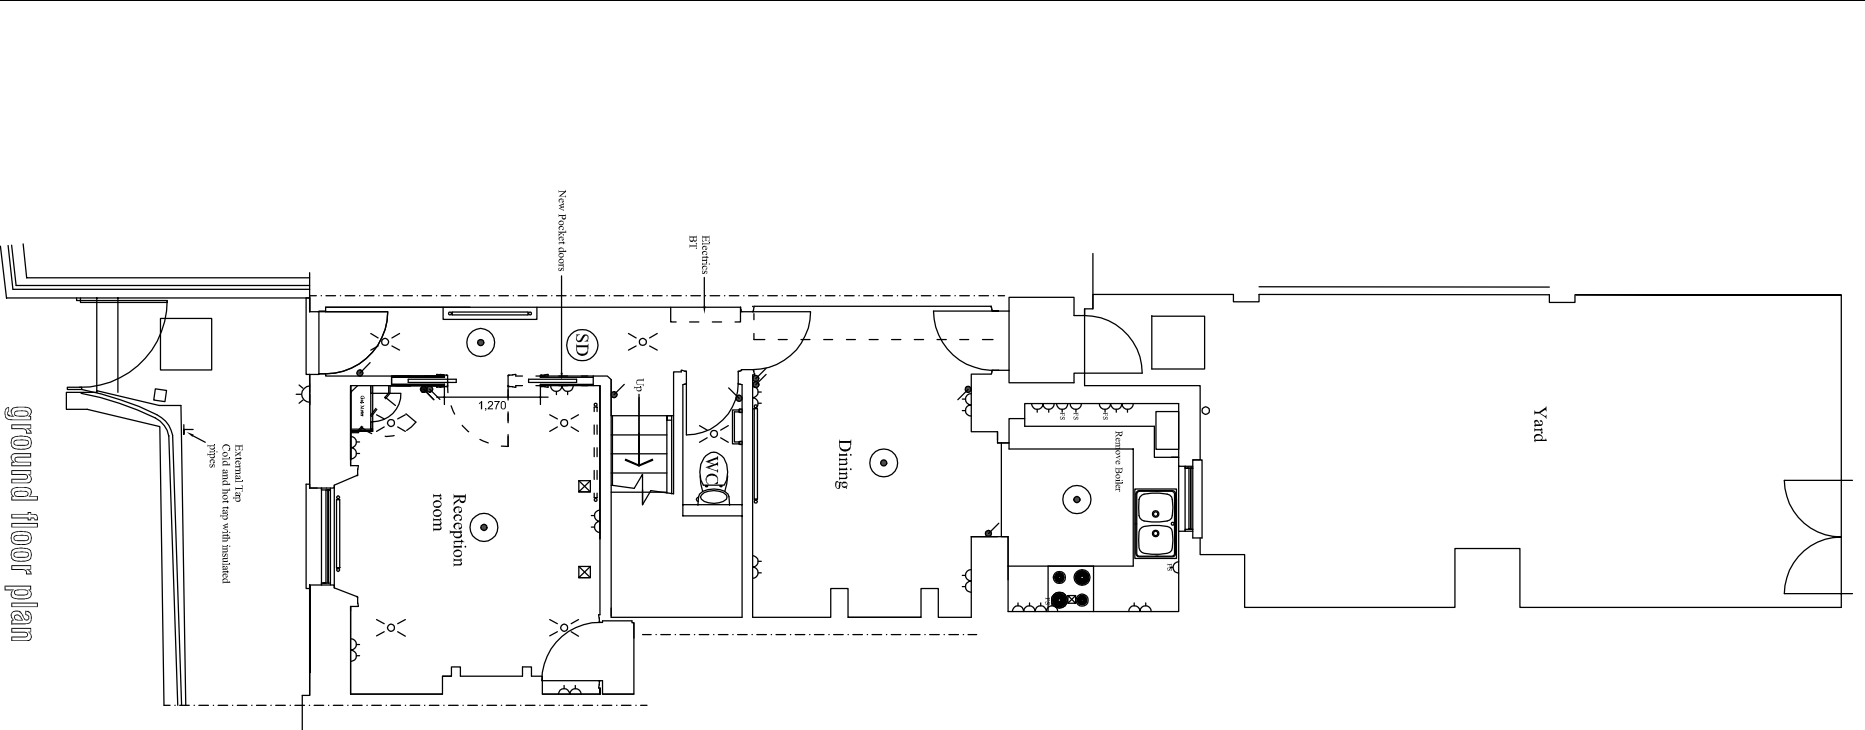

ground floor plan

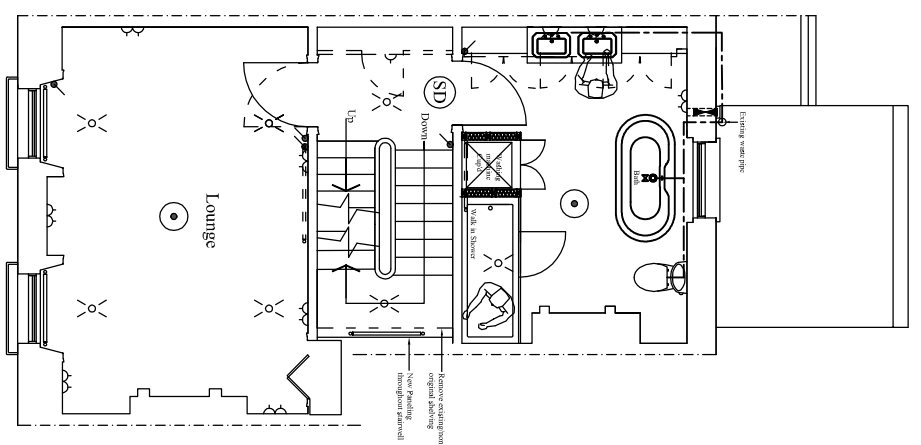


first floor plan

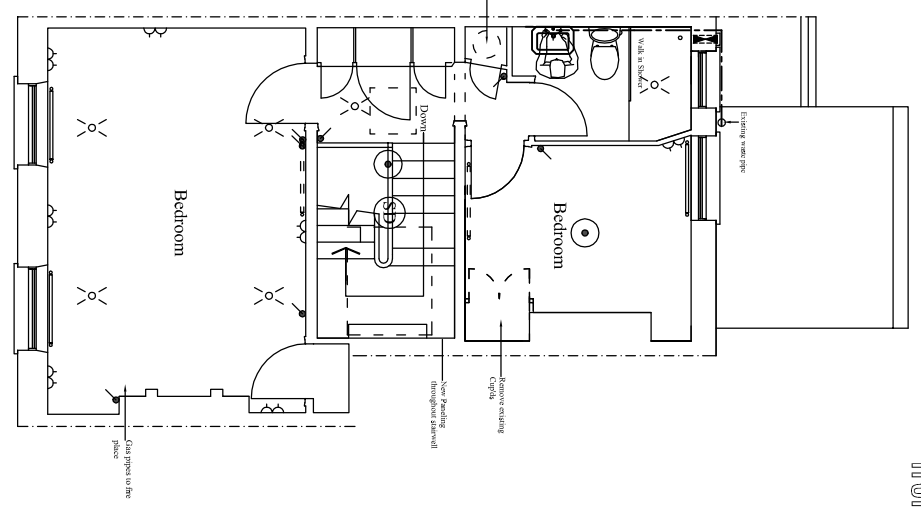

second floor plan

 Scale 1:100@ A3 & 1:50@A1



KEY	
	Double switched socket outlet
	5 amp socket
	Fixed Spur
	Shaver socket
	Single switched socket
	Switch
	Double switch
	Radiators
	Internal Wall Light/Outdoor light
	Recess downlights
	Feature lighting
	Gas point
	TV point
	Heated towel rail
	Heat detector
	Smoke detector
	Emergency lighting
	Extract fan (extractor fan)

project	
5 Holly Place, London NW3	
date	
December 2017	scale
1:100 @ A3 & 1:50 @ A1	
client PROPOSED INTERNAL ALTERATIONS, NEW ELECTRICS AND PLUMBING, INCLUDING FITTINGS	
STEVEN GRAY ARCHITECTURAL & SURVEYING SERVICES 361 Ladbroke Grove, London W10 6DU Tel: 020 3371 0629 Email: steven@gray-designs.co.uk Web: www.gray-designs.co.uk	
drawing number	
2352/2d	