
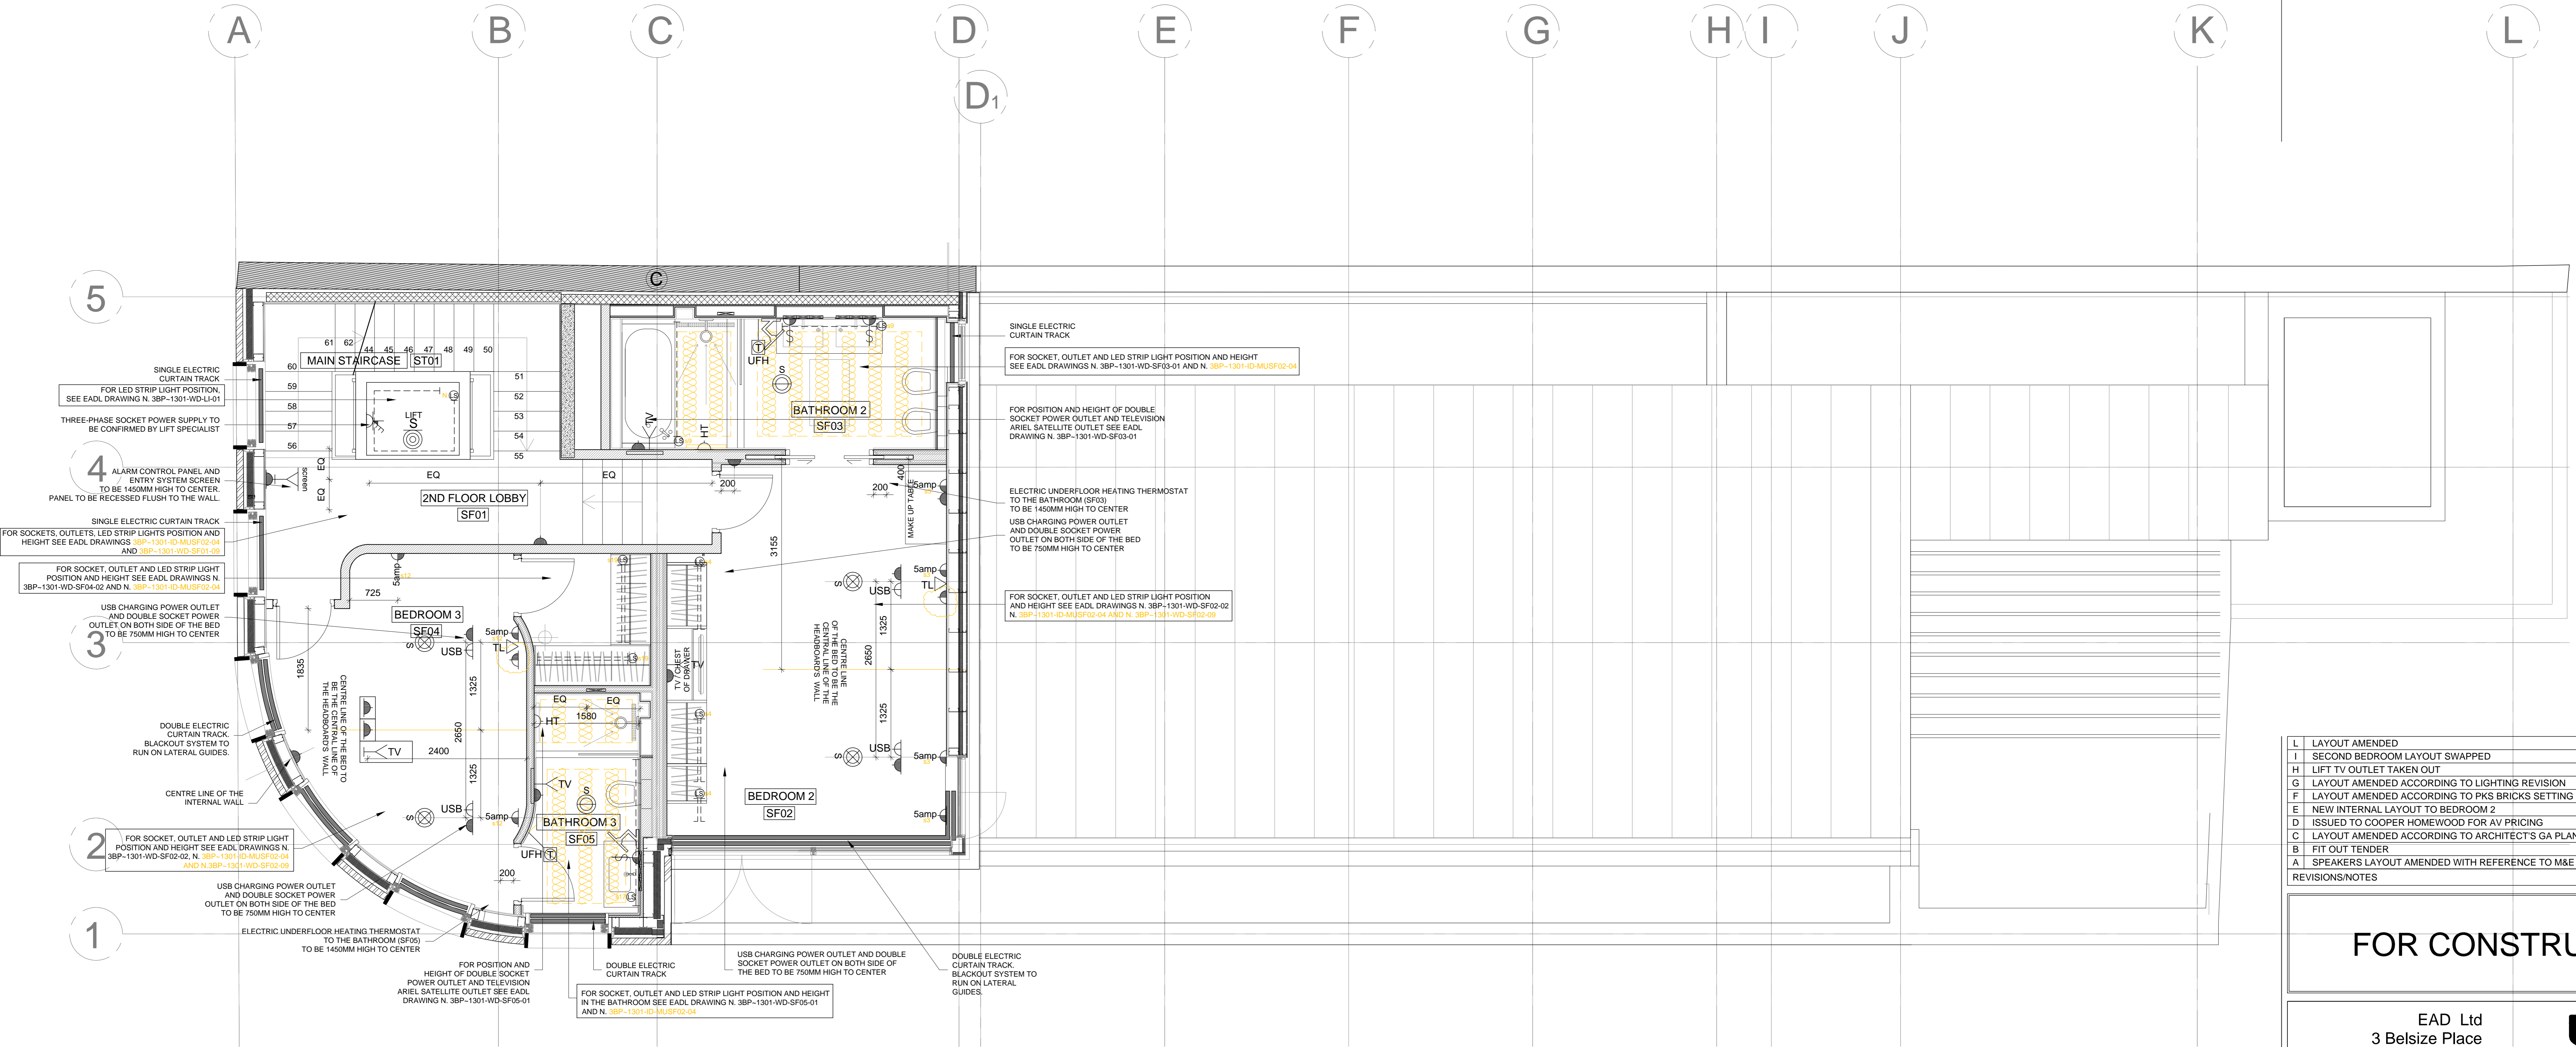


**ELECTRIC REGULATIONS TO BE CHECKED BY MAIN CONTRACTOR**  
**ELECTRIC REQUIREMENTS TO SPECIFIC EQUIPMENT TO BE SPECIFIED BY M&E ENGINEER AND SPECIALIST**

Contractors must verify all dimensions on site before any works are commenced.  
 This drawing remains the property of EZRA ATTIA DEVELOPMENTS LIMITED and may not be reproduced in any way without prior consent.  
 Toutes dimensions doivent être vérifiées par l'entrepreneur sur les lieux avant de commencer les travaux.  
 Ce dessin appartient uniquement à la compagnie EZRA ATTIA DEVELOPMENTS LIMITED dont la reproduction en est interdite sans autorisation.

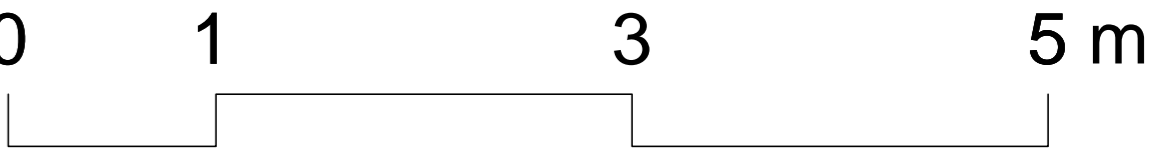

REVISIONS/NOTES	DATE
L LAYOUT AMENDED	10-06-16
I SECOND BEDROOM LAYOUT SWAPPED	27-04-16
H LIFT TV OUTLET TAKEN OUT	30-03-16
G LAYOUT AMENDED ACCORDING TO LIGHTING REVISION	29-08-15
F LAYOUT AMENDED ACCORDING TO PKS BRICKS SETTING OUT	21-05-15
E NEW INTERNAL LAYOUT TO BEDROOM 2	19-05-15
D ISSUED TO COOPER HOMEWOOD FOR AV PRICING	19-02-15
C LAYOUT AMENDED ACCORDING TO ARCHITECT'S GA PLAN	15-07-14
B FIT OUT TENDER	28-03-14
A SPEAKERS LAYOUT AMENDED WITH REFERENCE TO M&E SCHEME	28-03-14

**FOR CONSTRUCTION**

EAD Ltd  
 3 Belsize Place  
 London NW3 5AL  
 Tel: 44(0)20 7431 2627  
 Fax: 44(0)20 7794 0198  
 email: studio@eadl.co.uk  
 www.eadl.co.uk



Client  
**GCM**

Project  
**3BP~1301**

Area  
**SECOND FLOOR**

Description  
**ELECTRIC LAYOUT**

Scale	Drawn	Approved	Date	Project Number
1:50@A1	EC	-	01.14	-
Drawing Number	3BP~1301-ID-20-04	Revision	L	A B C D E F G H I - - -

CAD File No. -  
 X-REF File Name -

**1 SECOND FLOOR PLAN - ELECTRIC LAYOUT**  
 SCALE: 1:50 @ A1

**ALARM CONTROL PANEL AND ENTRY SYSTEM SCREEN LOCATION TO BE AGREED BY EADL AND CONFIRMED BY SPECIALIST**

KEY TO LOW LEVEL POWER		KEY TO ACOUSTIC SPEAKERS / EQUIPMENT SPECIFICATIONS, QUANTITY AND POSITION TO BE CONFIRMED BY SPECIALIST	
5amp POWER OUTLET. THE NUMBER IN RED INDICATES THE CIRCUIT	TELEPHONE OUTLET INTERNAL/EXTERNAL PHONE CALLS	ALARM SYSTEM CONTROL PANEL TO BE 1450MM HIGH TO CENTER	CEILING MOUNTED SPEAKER
SINGLE SOCKET POWER OUTLET	TELEVISION ARIEL SATELLITE OUTLET	UNDERFLOOR HEATING ON ELECTRIC SYSTEM	WATERPROOF CEILING MOUNTED SPEAKER
DOUBLE SOCKET POWER OUTLET	FLOOR MOUNTED TELEVISION ARIEL SATELLITE OUTLET	UNDERFLOOR HEATING THERMOSTAT TO BE 1450MM HIGH TO CENTER	LIFT SPEAKER BY SPECIALIST
FLOOR MOUNTED DOUBLE POWER OUTLET	SHAVER SOCKET	HEATED TOWEL RAIL ON DUAL SYSTEM	
HIGH LEVEL DOUBLE POWER SOCKET OUTLET 1500mm HIGH TO CENTRE A.F.F.L	MAKE UP MIRROR		
ENTRY SYSTEM SCREEN TO BE 1450MM HIGH TO CENTER. LOCATION AND HEIGHT TO BE CONFIRMED BY AV INTEGRATOR	USB CHARGING POWER OUTLET		
THREE-PHASE SOCKET POWER OUTLET	LOW VOLTAGE DEMISTER PAD TO BATHROOM MIRROR TO BE ON SEPARATE CIRCUIT		
WARDROBE STRIP LIGHT. THE NUMBER IN RED INDICATES THE CIRCUIT	ELECTRICAL CURTAIN TRACK		