
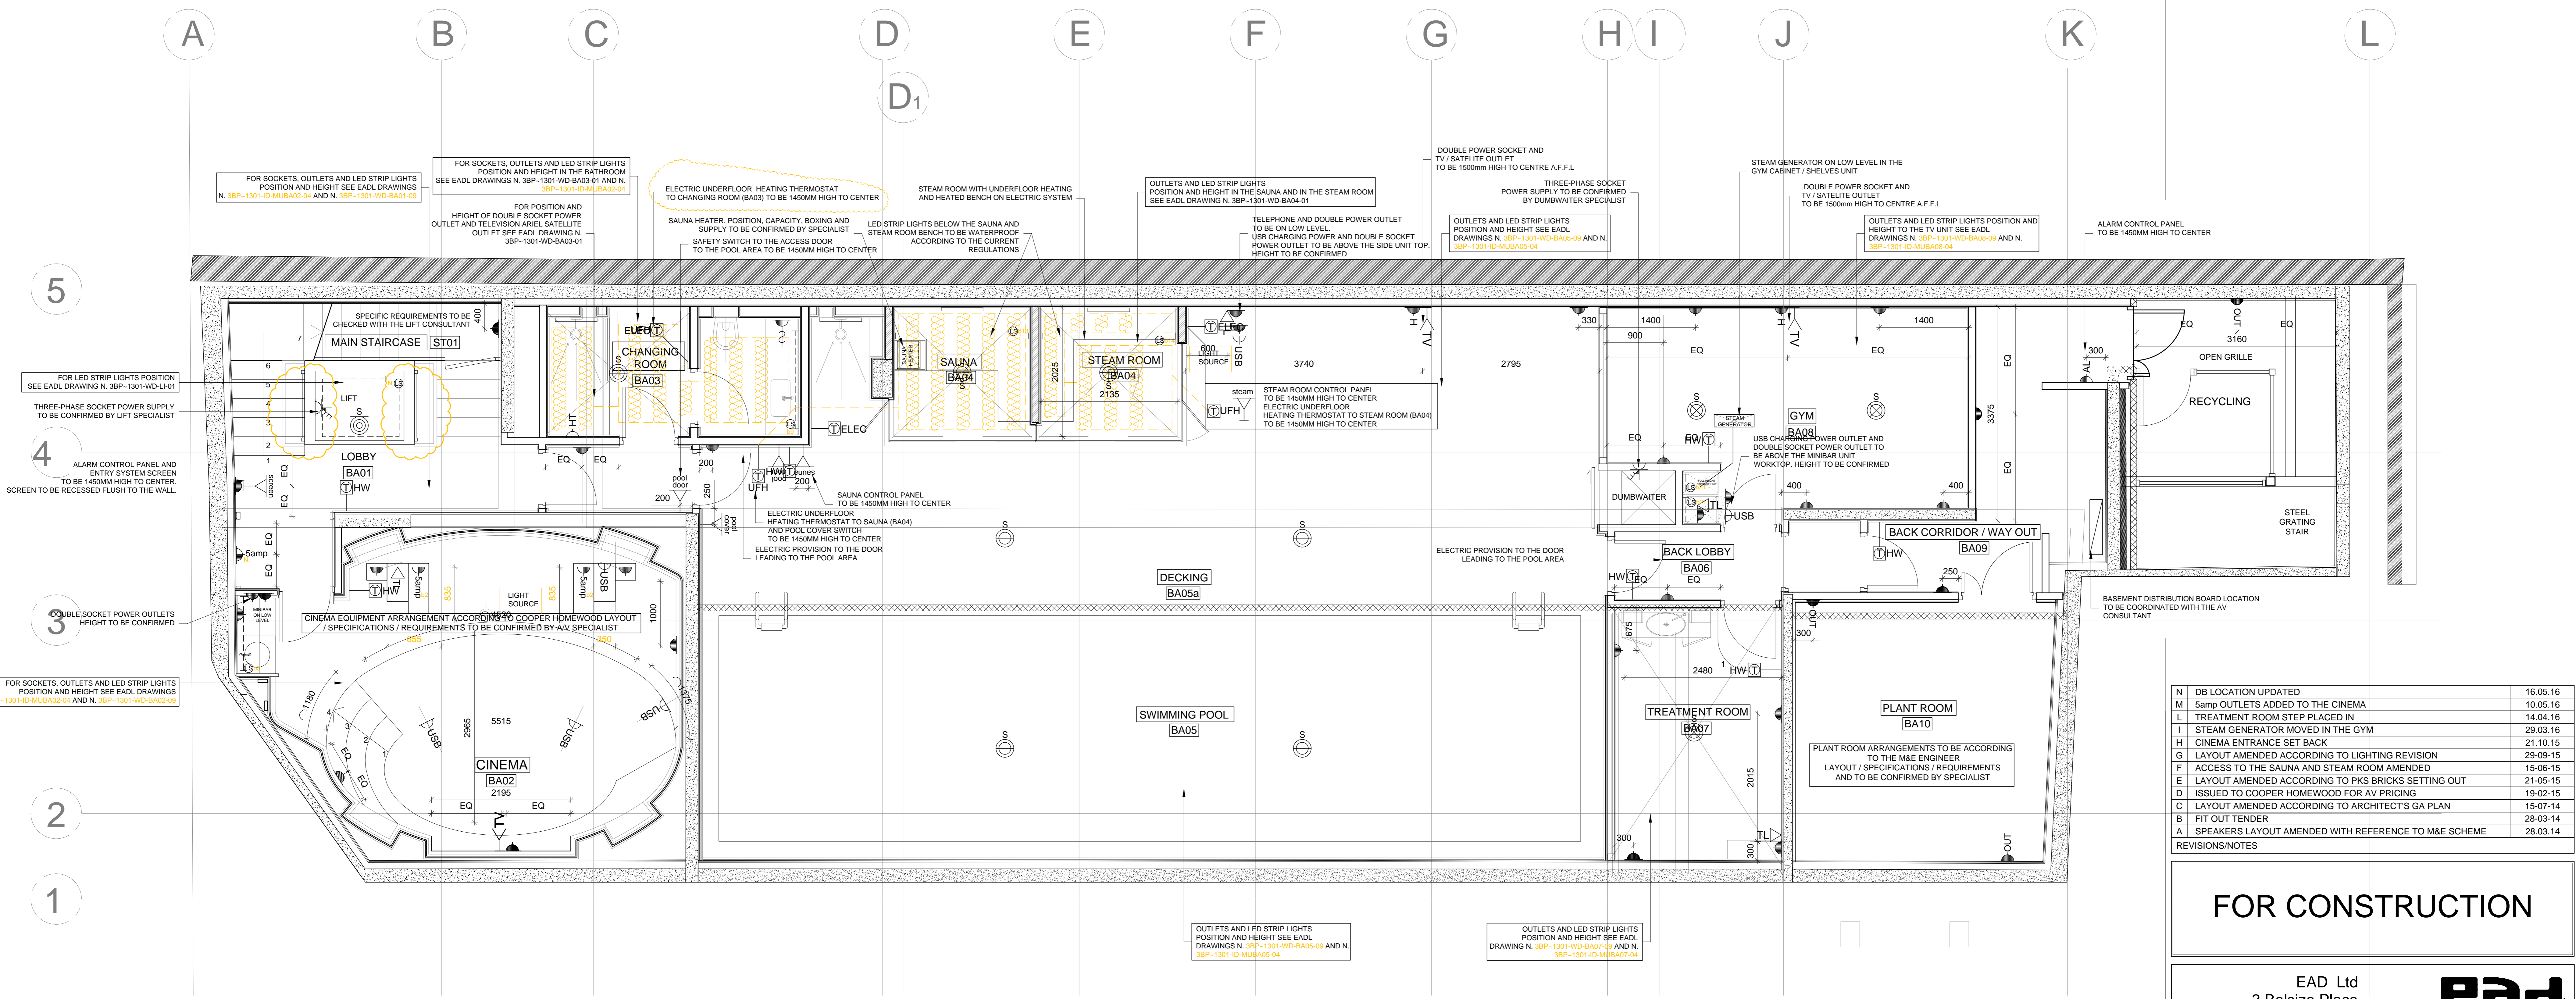


**ELECTRIC REGULATIONS TO BE CHECKED BY MAIN CONTRACTOR**  
**ELECTRIC REQUIREMENTS TO SPECIFIC EQUIPMENT TO BE SPECIFIED BY M&E ENGINEER AND SPECIALIST**

Contractors must verify all dimensions on site before any works are commenced.  
 This drawing remains the property of EZRA ATTIA DEVELOPMENTS LIMITED and may not be reproduced in any way without prior consent.  
 Toutes dimensions doivent être vérifiées par l'entrepreneur sur les lieux avant de commencer les travaux.  
 Ce dessin appartient uniquement à la compagnie EZRA ATTIA DEVELOPMENTS LIMITED dont la reproduction en est interdite sans autorisation.

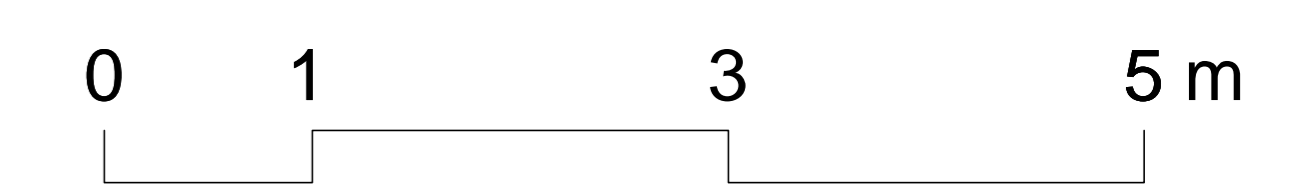

**1 BASEMENT FLOOR PLAN - ELECTRIC LAYOUT**  
 SCALE:1:50 @ A1

**ALARM CONTROL PANEL AND ENTRY SYSTEM SCREEN LOCATION TO BE AGREED BY EADL AND CONFIRMED BY SPECIALIST**

**KEY TO LOW LEVEL POWER**  
 ALL SOCKETS/OUTLETS BOTTOM EDGE TO BE 450MM FROM FINISH FLOOR LEVEL UNLESS STATED OTHERWISE.  
 ALL WALL MOUNTED PLATES TOP EDGE TO BE 1200MM FROM FINISH FLOOR LEVEL UNLESS STATED OTHERWISE.

5amp POWER OUTLET. THE NUMBER IN RED INDICATES THE CIRCUIT	THREE-PHASE SOCKET POWER OUTLET	ALARM SYSTEM CONTROL PANEL TO BE 1450MM HIGH TO CENTER	KEY TO ACOUSTIC SPEAKERS / EQUIPMENT SPECIFICATIONS, QUANTITY AND POSITION TO BE CONFIRMED BY SPECIALIST
DOUBLE SOCKET POWER OUTLET	TELEPHONE OUTLET INTERNAL/EXTERNAL PHONE CALLS	UNDERFLOOR HEATING ON ELECTRIC SYSTEM	CEILING MOUNTED SPEAKER
FLOOR MOUNTED DOUBLE POWER OUTLET	FLOOR MOUNTED TELEPHONE OUTLET INTERNAL/EXTERNAL PHONE CALLS	UNDERFLOOR HEATING THERMOSTAT TO BE 1450MM HIGH TO CENTER	WATERPROOF CEILING MOUNTED SPEAKER
HIGH LEVEL DOUBLE POWER SOCKET OUTLET 1500mm HIGH TO CENTRE A.F.F.L	TELEVISION ARIEL SATELLITE OUTLET	HEATED TOWEL RAIL ON DUAL SYSTEM	LIFT SPEAKER BY SPECIALIST
ENTRY SYSTEM SCREEN TO BE 1450MM HIGH TO CENTER. LOCATION AND HEIGHT TO BE CONFIRMED BY AV INTEGRATOR	SHAVER SOCKET	STEAM ROOM CONTROL PANEL POWER OUTLET TO BE 1450MM HIGH TO CENTER	
SAFETY SWITCH TO THE POOL DOOR TO BE 1450MM HIGH TO CENTER	MAKE UP MIRROR	SAUNA CONTROL PANEL POWER OUTLET TO BE 1450MM HIGH TO CENTER	
SAFETY SWITCH TO THE POOL COVER TO BE 1450MM HIGH TO CENTER	USB CHARGING POWER OUTLET	OUTDOOR DOUBLE SOCKET POWER OUTLET	
WARDROBE STRIP LIGHT. THE NUMBER IN RED INDICATES THE CIRCUIT	FLOOR MOUNTED USB CHARGING POWER OUTLET		
STRIP LIGHT. THE NUMBER IN RED INDICATES THE CIRCUIT	BASEMENT ELECTRICAL DISTRIBUTION BOARD		

N	DB LOCATION UPDATED	16.05.16
M	5amp OUTLETS ADDED TO THE CINEMA	10.05.16
L	TREATMENT ROOM STEP PLACED IN	14.04.16
I	STEAM GENERATOR MOVED IN THE GYM	29.03.16
H	CINEMA ENTRANCE SET BACK	21.10.15
G	LAYOUT AMENDED ACCORDING TO LIGHTING REVISION	29-09-15
F	ACCESS TO THE SAUNA AND STEAM ROOM AMENDED	15-06-15
E	LAYOUT AMENDED ACCORDING TO PKS BRICKS SETTING OUT	21-05-15
D	ISSUED TO COOPER HOMEWOOD FOR AV PRICING	19-02-15
C	LAYOUT AMENDED ACCORDING TO ARCHITECT'S GA PLAN	15-07-14
B	FIT OUT TENDER	28-03-14
A	SPEAKERS LAYOUT AMENDED WITH REFERENCE TO M&E SCHEME	28.03.14

**FOR CONSTRUCTION**

EAD Ltd  
 3 Belsize Place  
 London NW3 5AL  
 Tel: 44(0)20 7431 2627  
 Fax: 44(0)20 7794 0198  
 email: studio@eadl.co.uk  
 www.eadl.co.uk



Client  
**GCM**

Project  
**3BP-1301**

Area  
**BASEMENT**

Description  
**ELECTRIC LAYOUT**

Scale	1:50@A1	Drawn	EC	Approved	-	Date	01.14	Project Number	-
Drawing Number	3BP-1301-ID-01-04	Revision	N	A	B	C	D	E	F

CAD File No. -  
 X-REF File Name -