
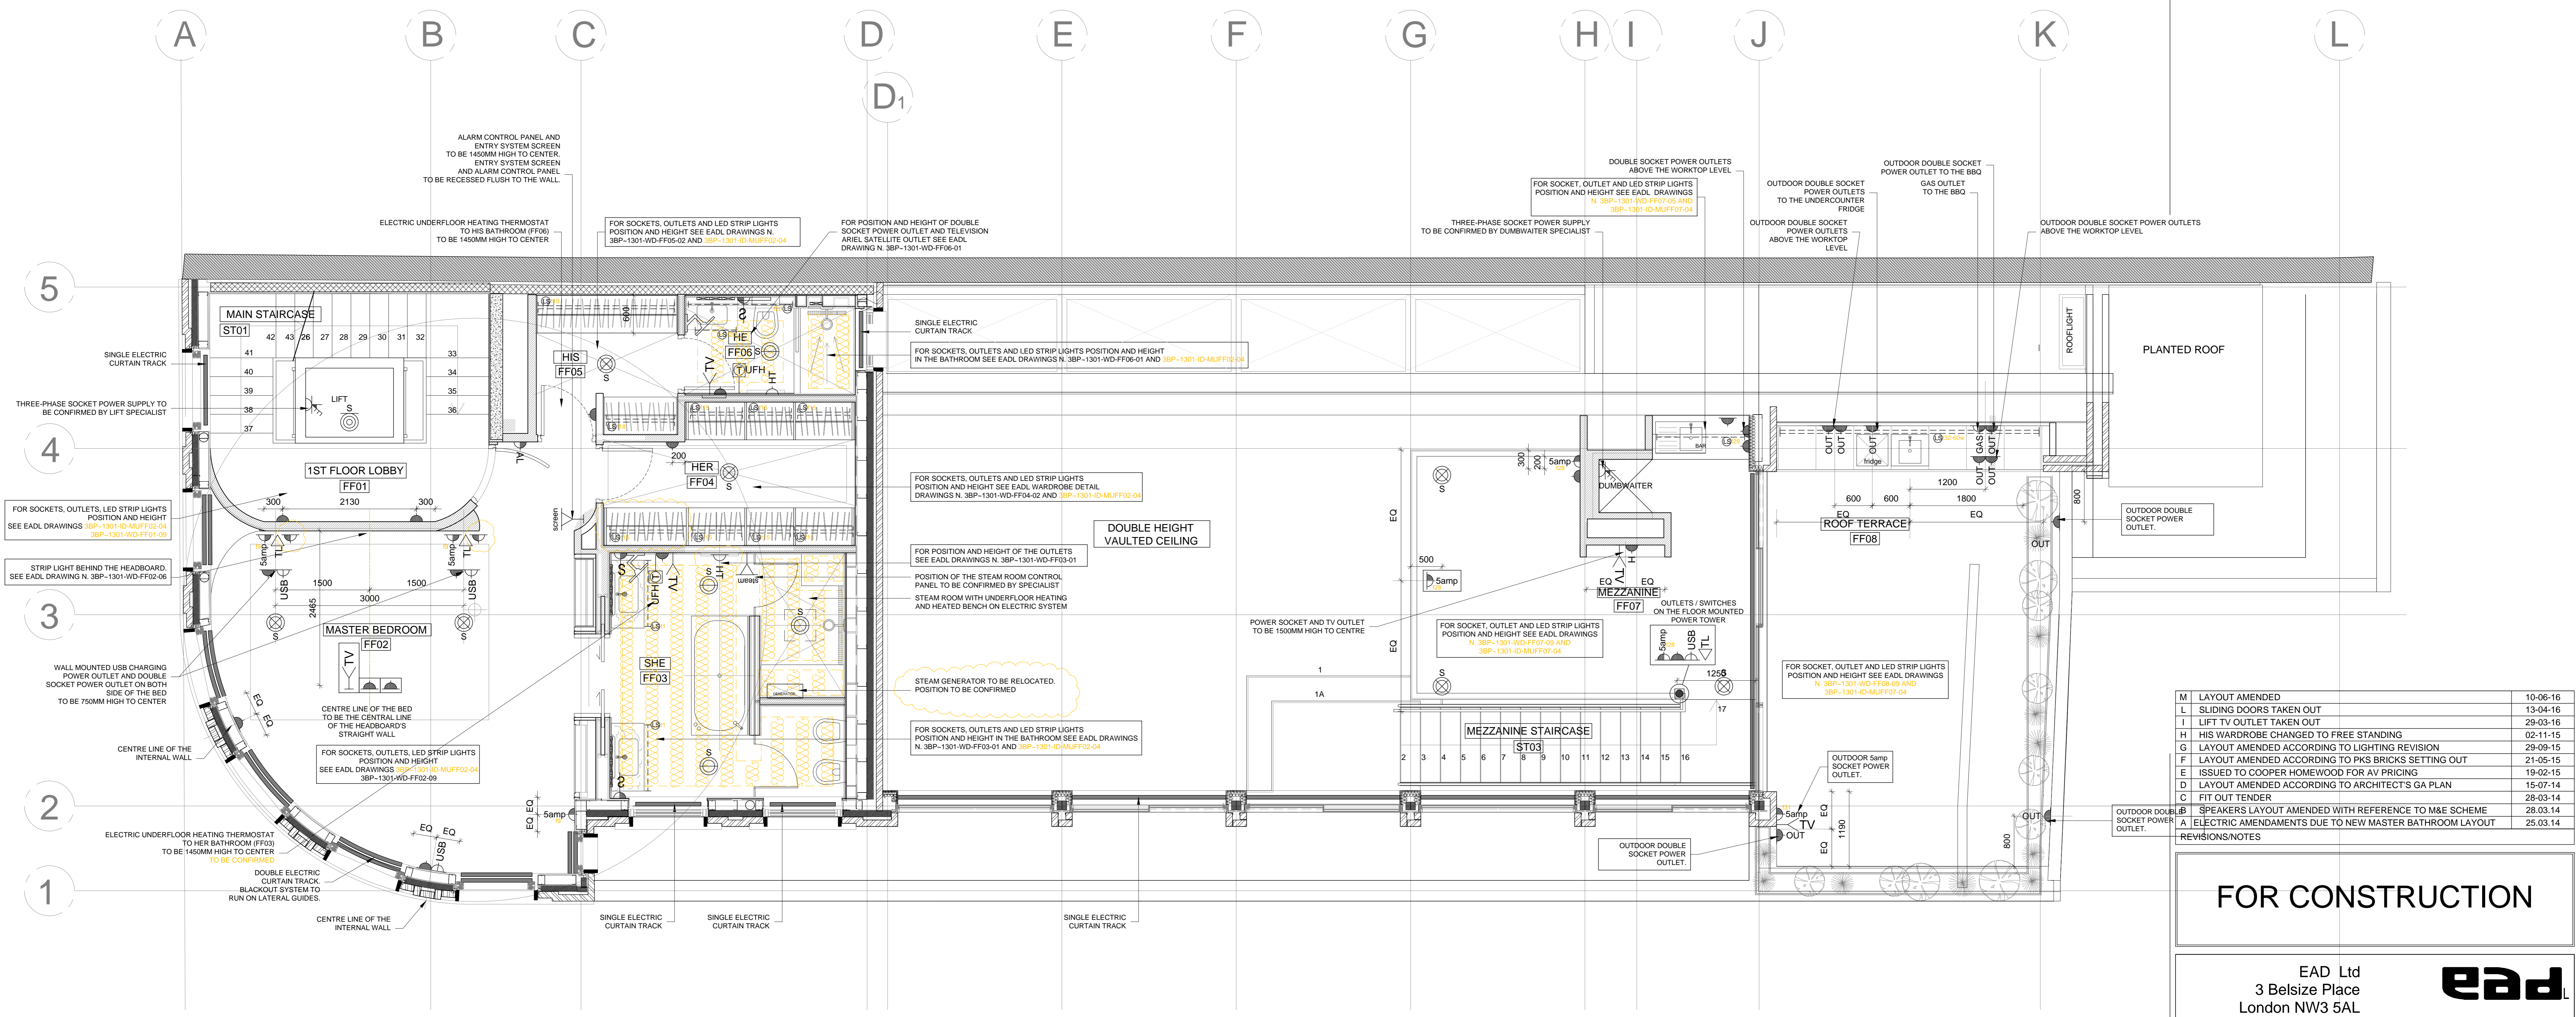


ELECTRIC REGULATIONS TO BE CHECKED BY MAIN CONTRACTOR
ELECTRIC REQUIREMENTS TO SPECIFIC EQUIPMENT TO BE SPECIFIED BY M&E ENGINEER AND SPECIALIST

Contractors must verify all dimensions on site before any works are commenced.
 This drawing remains the property of EZRA ATTIA DEVELOPMENTS LIMITED and may not be reproduced in any way without prior consent.
 Toutes dimensions doivent être vérifiées par l'entrepreneur sur les lieux avant de commencer les travaux.
 Ce dessin appartient uniquement à la compagnie EZRA ATTIA DEVELOPMENTS LIMITED dont la reproduction en est interdite sans autorisation.

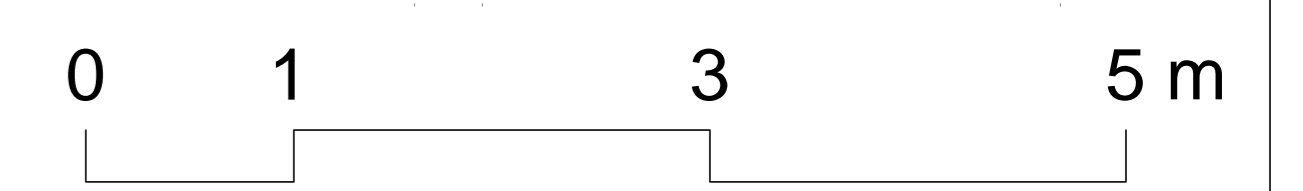

REVISIONS/NOTES	DATE
M LAYOUT AMENDED	10-06-16
L SLIDING DOORS TAKEN OUT	13-04-16
I LIFT TV OUTLET TAKEN OUT	29-03-16
H HIS WARDROBE CHANGED TO FREE STANDING	02-11-15
G LAYOUT AMENDED ACCORDING TO LIGHTING REVISION	29-09-15
F LAYOUT AMENDED ACCORDING TO PK'S BRICKS SETTING OUT	21-05-15
E ISSUED TO COOPER HOMEWOOD FOR AV PRICING	19-02-15
D LAYOUT AMENDED ACCORDING TO ARCHITECT'S GA PLAN	15-07-14
C FIT OUT TENDER	28-03-14
B SPEAKERS LAYOUT AMENDED WITH REFERENCE TO M&E SCHEME	28-03-14
A ELECTRIC AMENDMENTS DUE TO NEW MASTER BATHROOM LAYOUT	25-03-14

FOR CONSTRUCTION

EAD Ltd
 3 Belsize Place
 London NW3 5AL
 Tel: 44(0)20 7431 2627
 Fax: 44(0)20 7794 0198
 email: studio@eadl.co.uk
 www.eadl.co.uk



Client
GCM

Project
3BP-1301

Area
FIRST FLOOR

Description
ELECTRIC LAYOUT

Scale	Drawn	Approved	Date	Project Number
1:50@A1	MC	-	01.14	-
Drawing Number	Revision	Revision		
3BP-1301-ID-10-04	M	A	B	C
		D	E	F
		G	H	I
		J	K	L

CAD File No. —
 X-REF File Name —

1 FIRST FLOOR PLAN - ELECTRIC LAYOUT_
 SCALE:1:50 @ A1

ALARM CONTROL PANEL AND ENTRY SYSTEM SCREEN LOCATION TO BE AGREED BY EADL AND CONFIRMED BY SPECIALIST

KEY TO LOW LEVEL POWER
 ALL SOCKETS/OUTLETS BOTTOM EDGE TO BE 450MM FROM FINISH FLOOR LEVEL UNLESS STATED OTHERWISE.
 ALL WALL MOUNTED PLATES TOP EDGE TO BE 1200MM FROM FINISH FLOOR LEVEL UNLESS STATED OTHERWISE.

5amp POWER OUTLET. THE NUMBER IN RED INDICATES THE CIRCUIT	TELEPHONE OUTLET INTERNAL/EXTERNAL PHONE CALLS	ALARM SYSTEM CONTROL PANEL TO BE 1450MM HIGH TO CENTER
SINGLE SOCKET POWER OUTLET	TELEVISION ARIEL SATELLITE OUTLET	UNDERFLOOR HEATING ON ELECTRIC SYSTEM
DOUBLE SOCKET POWER OUTLET	FLOOR MOUNTED TELEVISION ARIEL SATELLITE OUTLET	UNDERFLOOR HEATING THERMOSTAT TO BE 1450MM HIGH TO CENTER
FLOOR MOUNTED DOUBLE POWER OUTLET	SHAVER SOCKET	FLOOR MOUNTED HEATED TOWEL RAIL ON AN ELECTRIC SYSTEM
HIGH LEVEL DOUBLE POWER SOCKET OUTLET 1500mm HIGH TO CENTRE A.F.F.L	MAKE UP MIRROR	STEAM ROOM CONTROL PANEL POWER OUTLET
ENTRY SYSTEM SCREEN TO BE 1450MM HIGH TO CENTER. LOCATION AND HEIGHT TO BE CONFIRMED BY AV INTEGRATOR	USB CHARGING POWER OUTLET	FLOOR MOUNTED POWER TOWER
THREE-PHASE SOCKET POWER OUTLET	LOW VOLTAGE DEMISTER PAD TO BATHROOM MIRROR TO BE ON SEPARATE CIRCUIT	OUTDOOR DOUBLE SOCKET POWER OUTLET
WARDROBE STRIP LIGHT. THE NUMBER IN RED INDICATES THE CIRCUIT	ELECTRICAL CURTAIN TRACK	GAS OUTLET
STRIP LIGHT. THE NUMBER IN RED INDICATES THE CIRCUIT		

KEY TO ACOUSTIC SPEAKERS / EQUIPMENT SPECIFICATIONS, QUANTITY AND POSITION TO BE CONFIRMED BY SPECIALIST

CEILING MOUNTED SPEAKER
WATERPROOF CEILING MOUNTED SPEAKER
LIFT SPEAKER BY SPECIALIST
OUTDOOR SPEAKER