


FOR THIS DRAWING WE CLAIM LEGAL PROTECTION REGARDING COPYRIGHTS, COMMERCIAL COMPETITION AND INDUSTRIAL GUARANTEE. THIS DRAWING IS ONLY TO BE USED FOR THE PURPOSE FOR WHICH IT IS SUPPLIED AND WITHOUT OUR CONSENT IT MUST NEITHER BE COPIED OR MADE ACCESSIBLE TO ANY THIRD PARTY.

REVISIONS

REV A - UPDATED TO ARCHITECTS LAYOUT

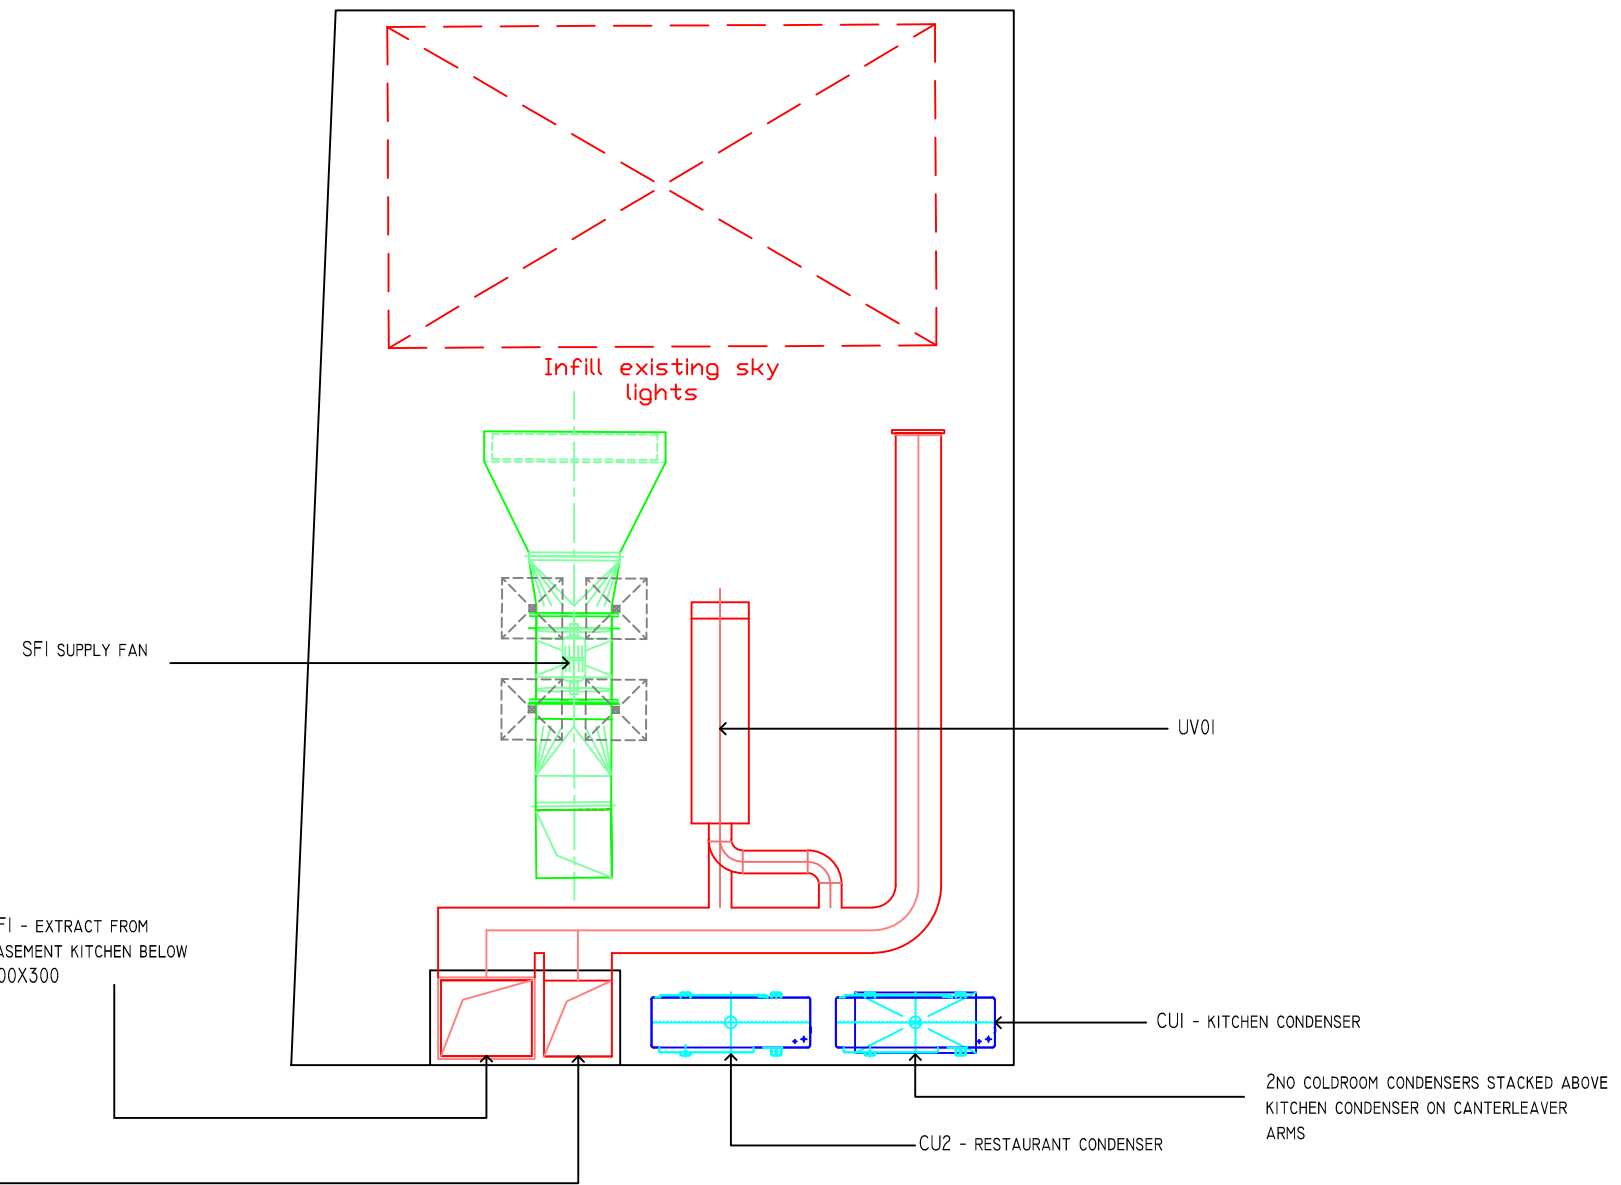

NOTE:
ALL PLANT TO BE MOUNTED ON CONDENSERS BLOCKS

PROPOSED ROOF PLAN



EQUIPMENT LIST

EF1 - BASEMENT KITCHEN EXTRACT FAN
 ELTA COMPACT POWER PLUS MODEL SPP500/4-3
 ELTA MOUNTING FEET - 2 X 060B-500
 ELTA FLEXIBLE CONNECTIONS C/W BANDING CLIPS - 2 X 050-0550-MAN
 ELTA MATCHING FLANGES - 2 X 061B-0500
 ELTA ANTI-VIBRATION MOUNTS - 4 X 52-52B
 ELTA INVERTER CONTROLLER
 SPP500/4-3 500MM LONG 69KG
 NOISE - 62dBA @3M

EF2 - GROUND FLOOR KITCHEN EXTRACT FAN
 ELTA COMPACT POWER PLUS MODEL SPP450/4-3
 ELTA MOUNTING FEET - 2 X 060B-450
 ELTA FLEXIBLE CONNECTIONS C/W BANDING CLIPS - 2 X 050-0550-MAN
 ELTA MATCHING FLANGES - 2 X 061B-0450
 ELTA ANTI-VIBRATION MOUNTS - 4 X 52-52B
 ELTA INVERTER CONTROLLER
 SPP450/4-3 500MM LONG 48KG
 NOISE - 58dBA @3M

SFI - KITCHEN SUPPLY FAN
 ELTA COMPACT POWER PLUS MODEL SPP450/4-3
 ELTA MOUNTING FEET - 2 X 060B-450
 ELTA FLEXIBLE CONNECTIONS C/W BANDING CLIPS - 2 X 050-0550-MAN
 ELTA MATCHING FLANGES - 2 X 061B-0450
 ELTA ANTI-VIBRATION MOUNTS - 4 X 52-52B
 ELTA INVERTER CONTROLLER
 SPP450/4-3 500MM LONG 48KG
 NOISE - 58dBA @3M

UV01 - UV0-1000 PURIFIED AIR ULTRA VIOLET UNIT (2NO STACKED)
 DIMS: 476WIDE X 1563DEEP X 350HIGH - 700HIGH TOTAL
 WEIGHT: 50KG EACH - 100KG TOTAL
 DUCT CONNECTION: Ø150
 AIRFLOW: 1500L/S (70% CAPACITY)
 ELEC SUPPLY: 240V, 1PH, 50HZ, 6AMP

CUI KITCHEN BASEMENT AND GROUND FLOOR
 MITSUBISHI PUHZ-140YHA
 950MMX330MM+30X1338MM
 131KG
 16 AMP 3PHASE
 4 CORE CABLE - INTERCONNECTING
 52 DBA

CU2 RESTAURANT
 MITSUBISHI PUHZ-IRP7IVKA
 950MMX330MM+30X943MM
 67KG
 16 AMP
 1PH & INTERCONNECTING CORE CABLE
 48 DBA

CR1- COLD ROOM CONDENSER
 ROOM 1 - 882X427X427 78KG 410BA

CR2- COLD ROOM CONDENSER
 ROOM 2 - 882X427X390 43KG 380BA

EF1 FAN VERTICAL
 COMPLETE WITH SILENCERS

EF2 FAN VERTICAL
 COMPLETE WITH SILENCERS

PROJECT: **KFC KINGS CROSS**

CLIENT: **BARACK HOLDINGS**

DRAWING: **HVAC GA**
Proposed Roof Arrangement
'Planning Only'

SCALE: 1:100@A3	DRAWN: D.McLEAN	DATE: 02.02.2018
---------------------------	--------------------	---------------------

JOB No: 80808	CHECKED:	DATE:
-------------------------	----------	-------

DRAWING No: **80808 / M / 001 REV A**