


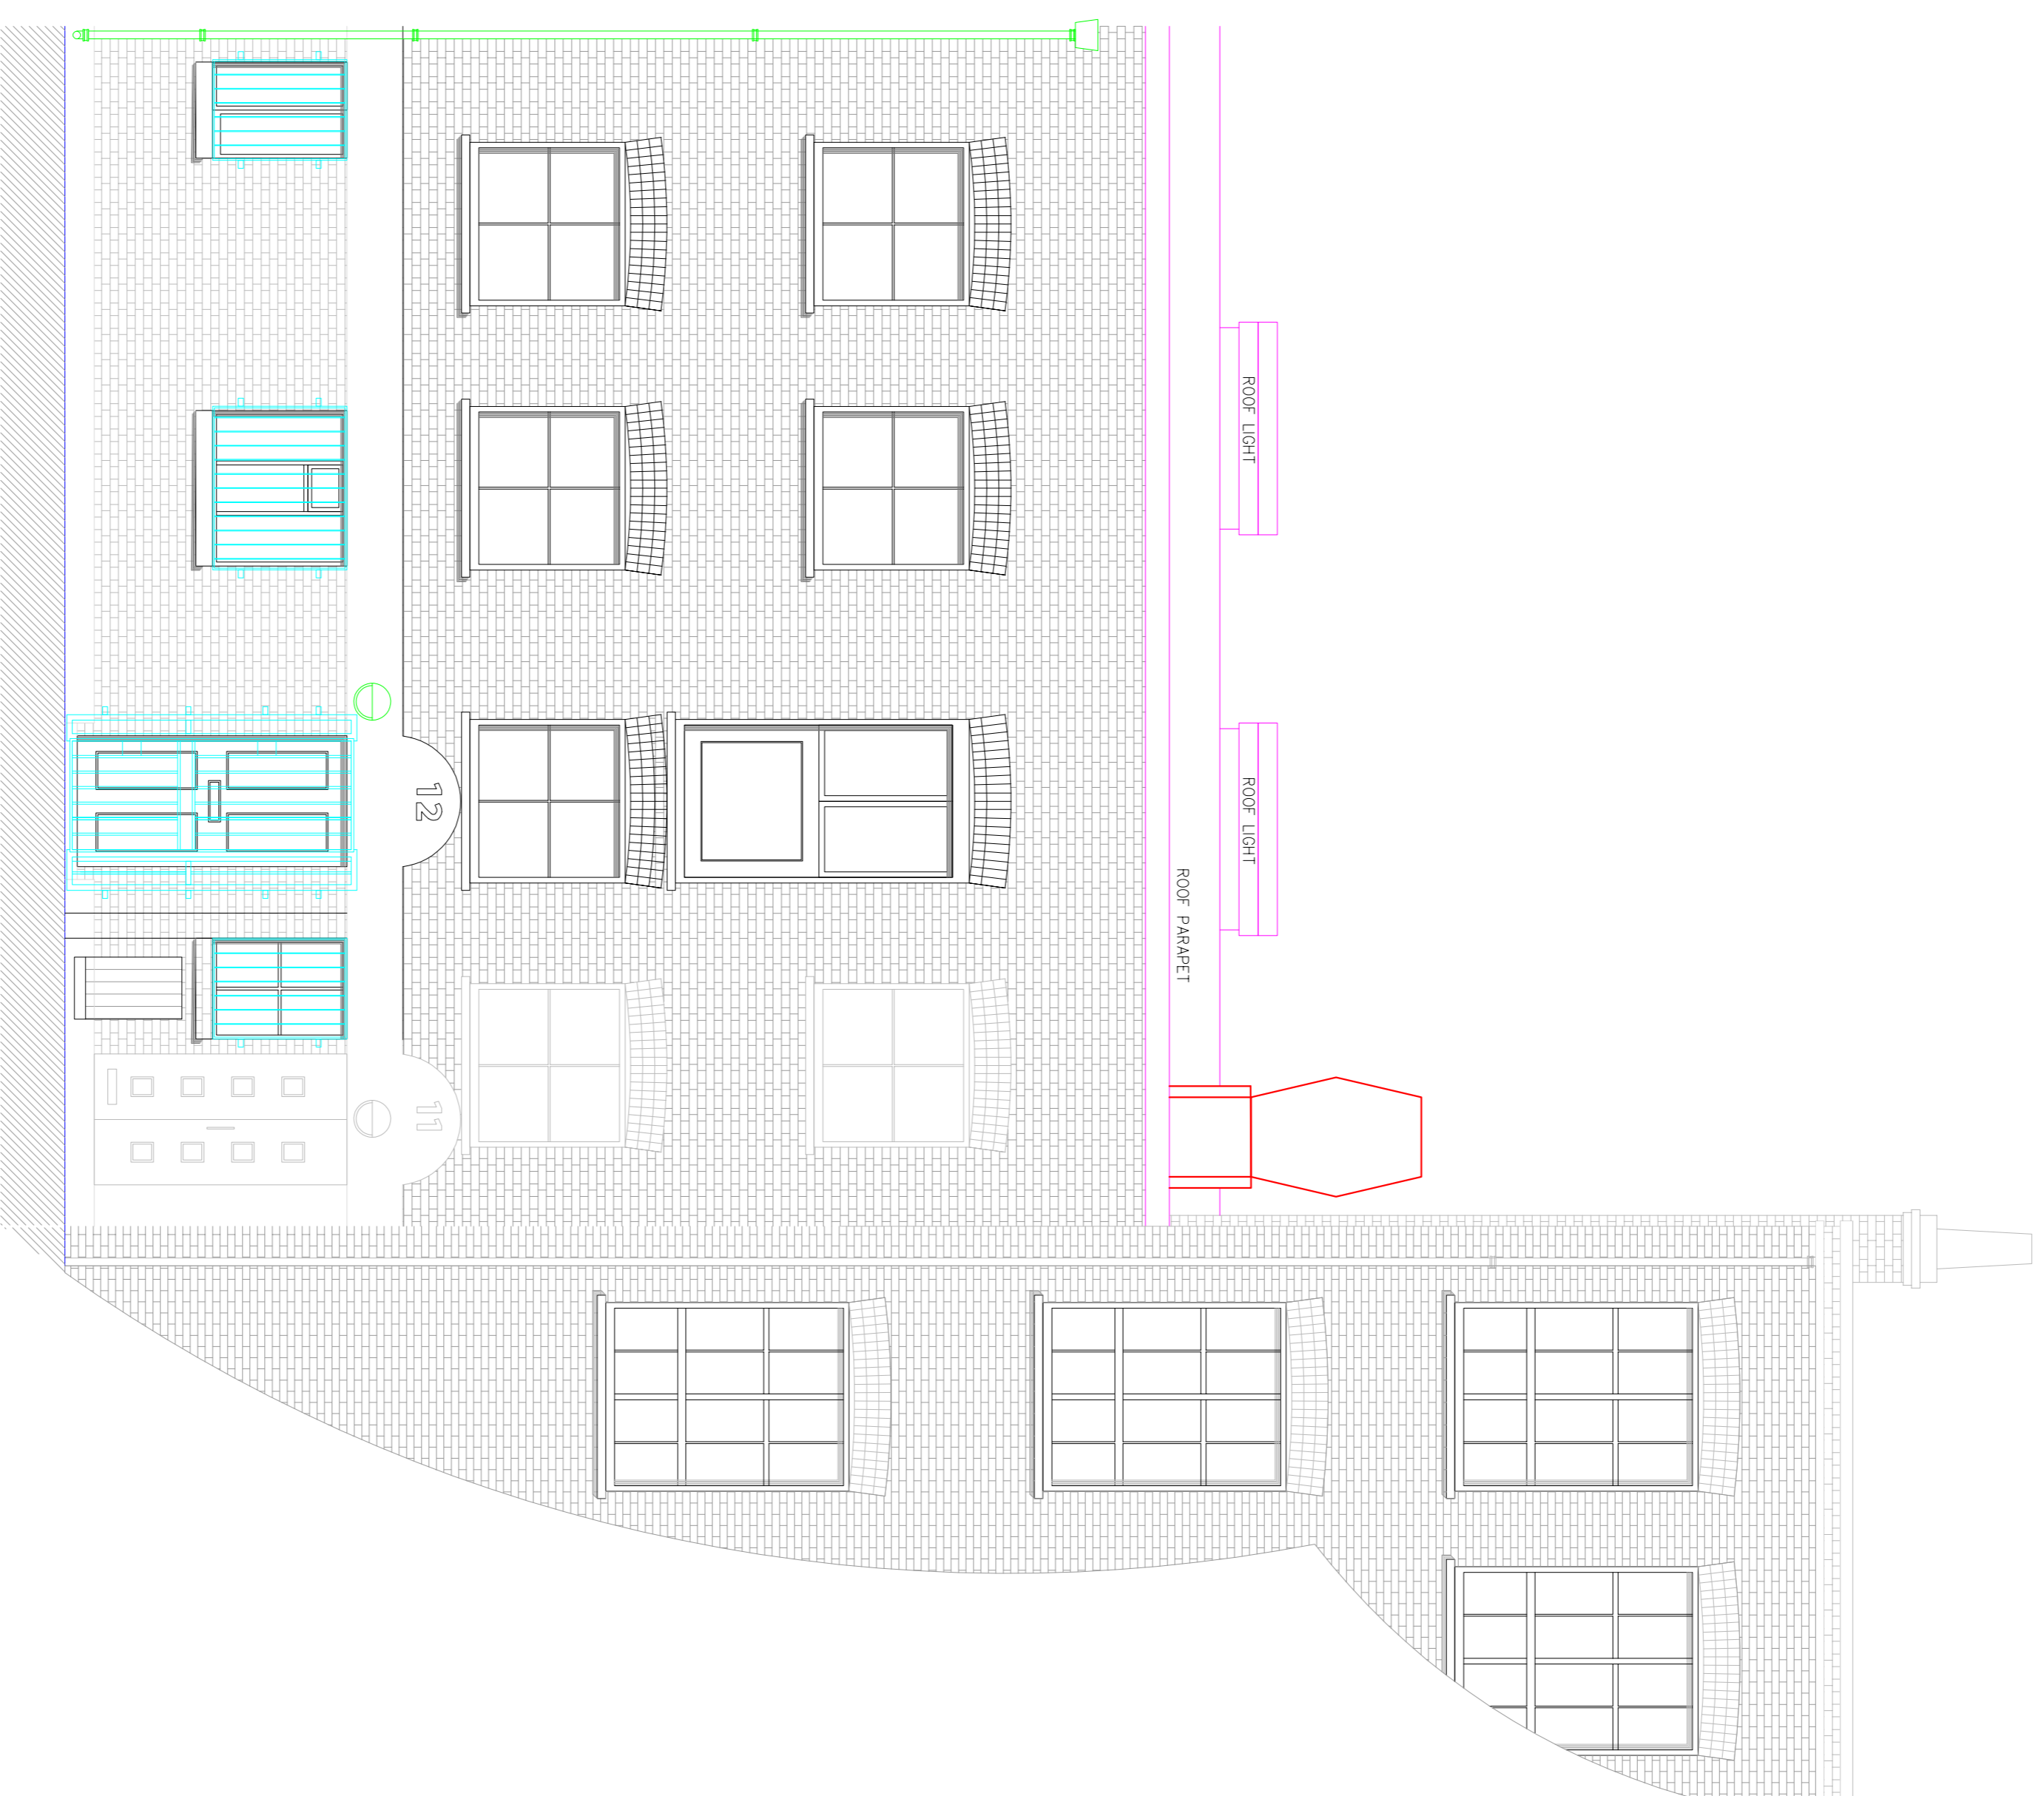

Indicative Screen
Acoustic consultant to advise



LEGEND:

	Supply Air Duct		Fire Damper		A/C Pipe Work
	Extract Air Duct		Volume Control Damper		Extract Air Valve
	Supply Air grille		Extract Air Valve		Supply Air Valve
	Extract Air grille		Supply Air Valve		Air Conditioning Unit
	A/C Cooling Coils		A/C		Air Freshening Unit
	A/C Heating Coils		AM		450 x 450 Access Hatch

NOTES:

THIS DRAWING MUST NOT BE SCALED. ALL SETTING OUT MUST BE CHECKED ON SITE. ALL DIMENSIONS MUST BE CHECKED ON SITE. THIS DRAWING MUST BE USED IN CONNECTION WITH THE SERVICES. NO DIMENSIONS ARE TO BE TAKEN FROM THIS DRAWING FOR ANY OTHER PURPOSE. COPYRIGHT © LEECH GROUP SERVICES, LEECH MECHANICAL SERVICES & ROOFING ELECTRICAL COMPANY

LEECH GROUP SERVICES
 Unit 17 Mapledean Works, Maldon Road,
 Latchingdon, Essex, CM3 6LG
 Tel: +44 (0)1621 742424,
 Email: help@leechgroupservices.co.uk
www.leechgroupservices.co.uk

Rev	Rev by	Description	Date
A	IT	Screen decreased in length	05/02/2018

PROJECT:
Pizza Express
Food Innovation centre
Charlotte Meus

TITLE:
Proposed Front Elevation
with and without screen

PROJECT NUMBER:	Q5907
DATE:	31/01/2017
DRAWN BY:	IT
CHECKED BY:	.
DRAWING NO:	Q5907/008 Rev A
SCALE:	1:50 @ A1 - 1:100 @ A3