




ground floor plan

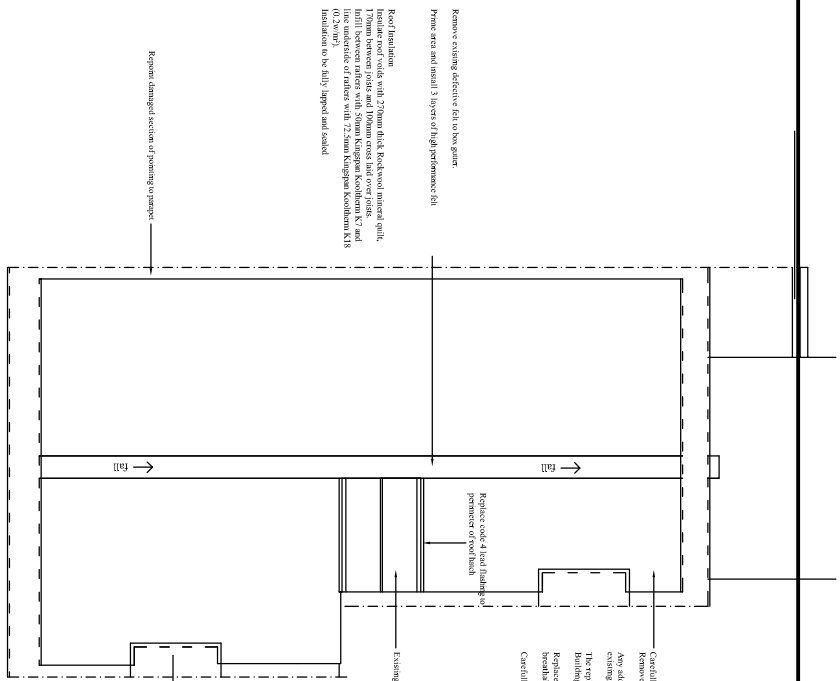


roof plan

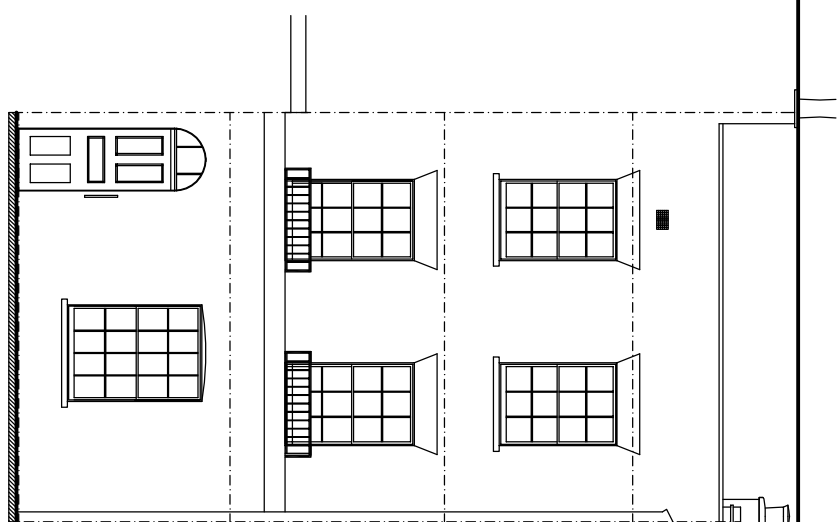


front elevation

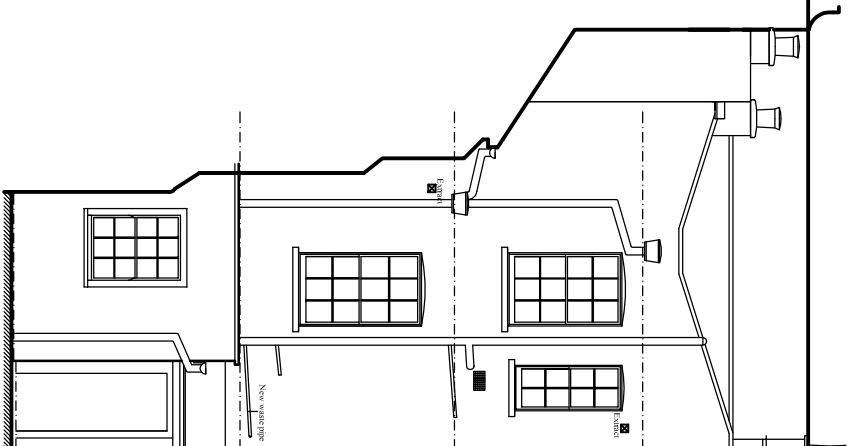

rear elevation

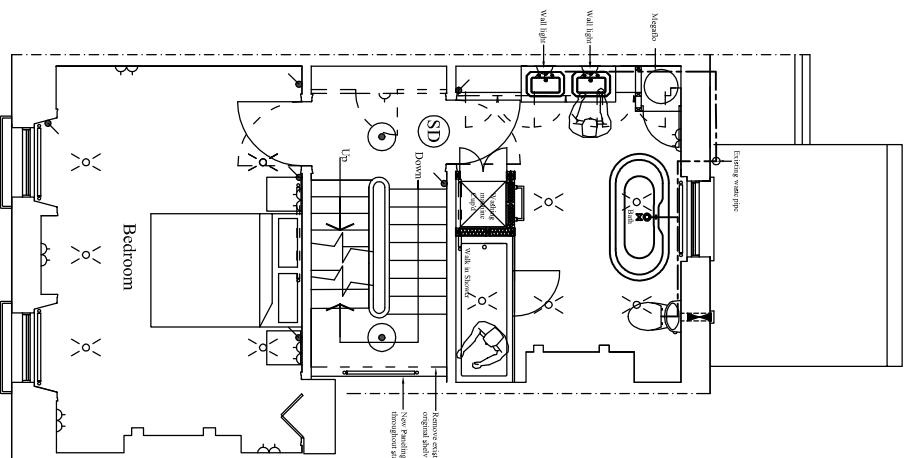


first floor plan

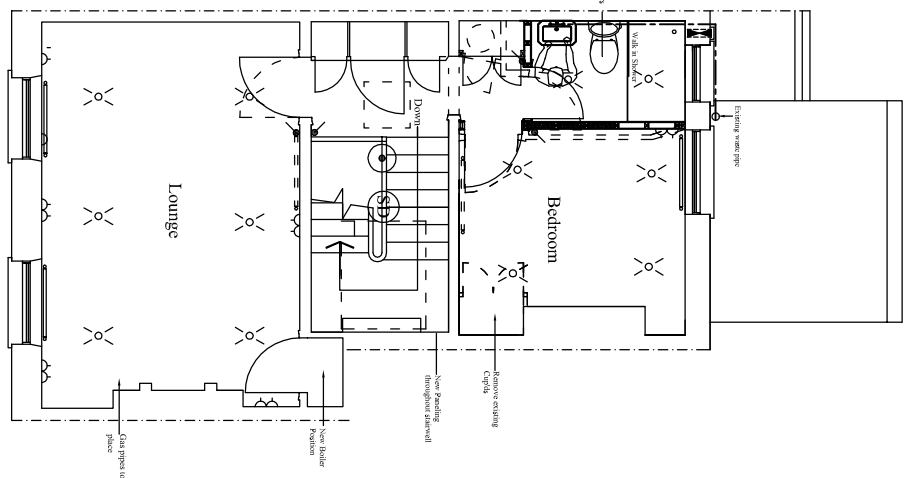

second floor plan

KEY	
	Double switched socket outlet
	5 amp socket
	Fixed spur
	Shaver socket
	Single switched socket
	Switch
	Double switch
	Radiators
	Internal Wall Light/Outdoor light
	Recess downlight
	Feature lighting
	Gas point
	TV point
	Hand towel rail
	Heat detector
	Smoke detector
	Emergency Lighting
	Extract fan (section/plan)

 Scale 1:100@ A3 & 1:50@A1



project	5 Holly Place, London NW3
date	December 2017
scale	1:100 @ A3 & 1:50 @A1
STEVEN GRAY ARCHITECTURAL & SURVEYING SERVICES 36 Ladbroke Crescent, Bayswater, London W2 2DU Tel: 020 3371 0629 Email: steven@sgay-architects.co.uk Web: www.gray-designs.co.uk	
drawing number	2352/2g