 



Legend - CCTV	
	Dome type CCTV Camera

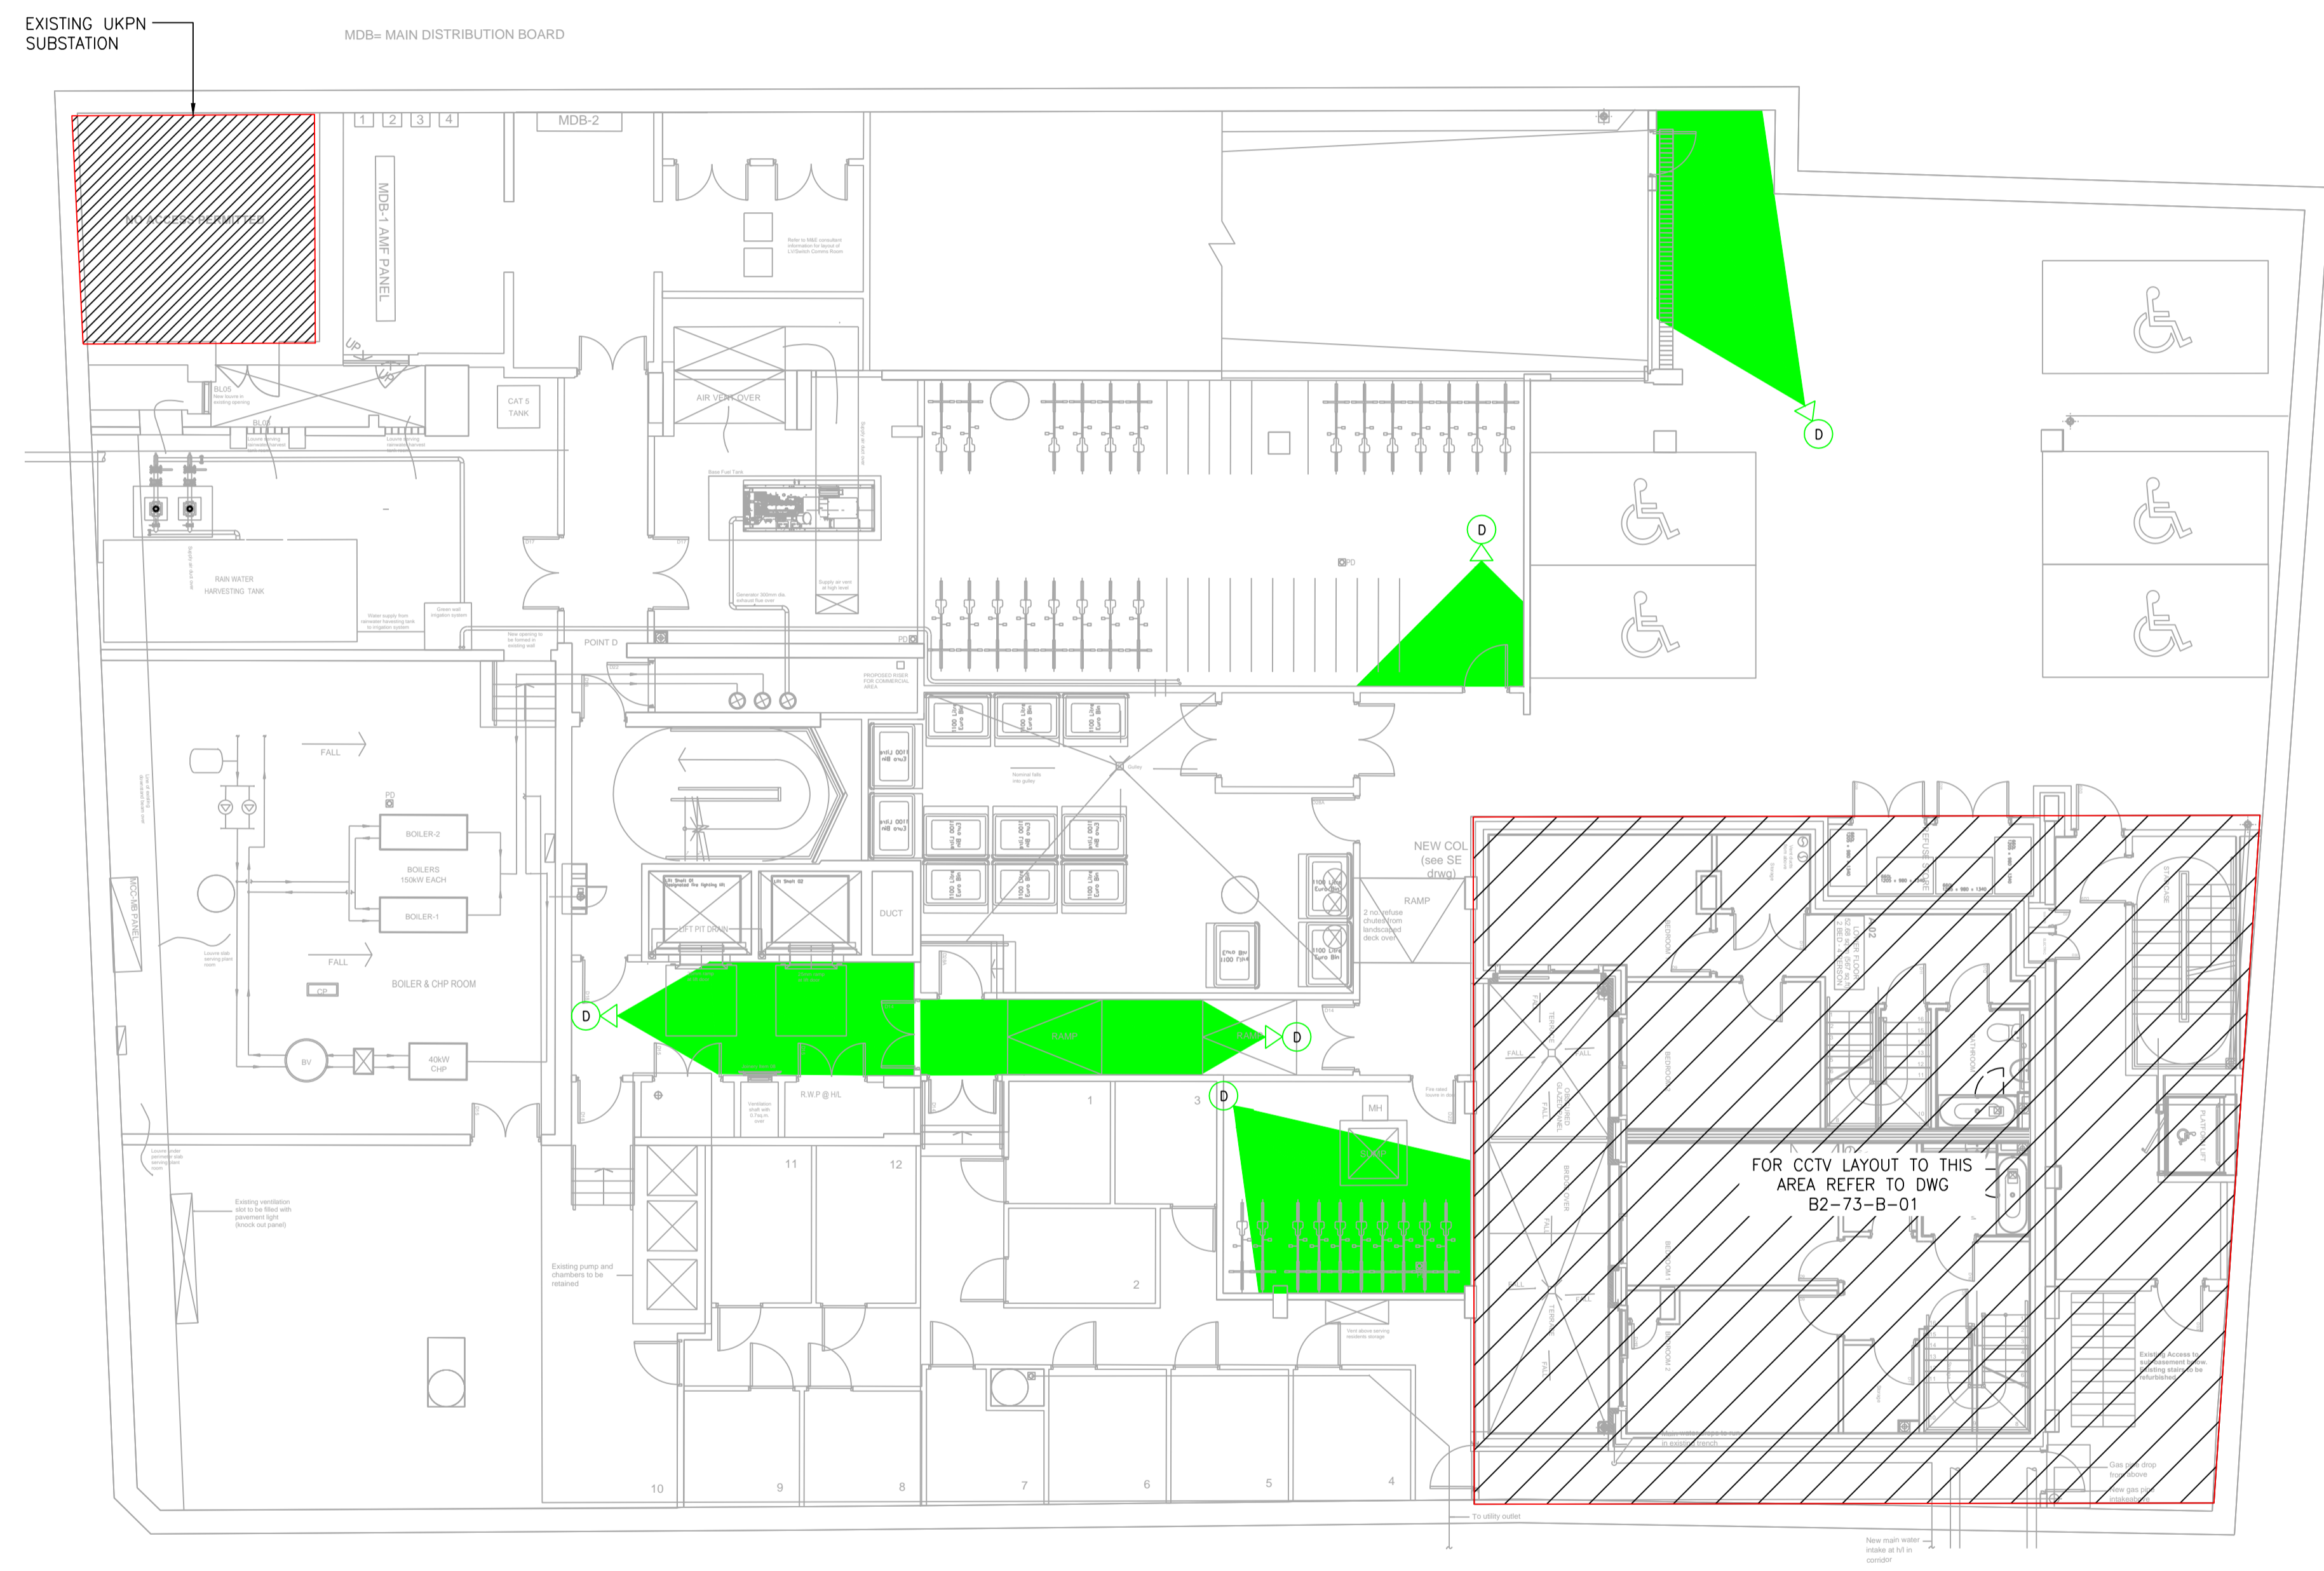

NOTES:
1. LOCATION OF CCTV CONTROL EQUIPMENT TO BE CONFIRMED

16/02/2018	FOR CONSTRUCTION	RP	MDM	INEO	MHL
DATE	REVISION HISTORY	DSG	PRP	CHK	APP

CLIENT EMPLOYER
LEGENDTRE CONSTRUCTION

KEY PLAN


PROJECT
PARKER TOWER LONDON

ORIGINATOR



ENGIE INEO
Kings Yard, Watlington Road
Queen Elizabeth Olympic Park
London E15 9QP
Tel: 0208 221 9880
Web: www.eneo.com
E-mail: information@eneo.com

CCTV LAYOUT TOWER BASEMENT

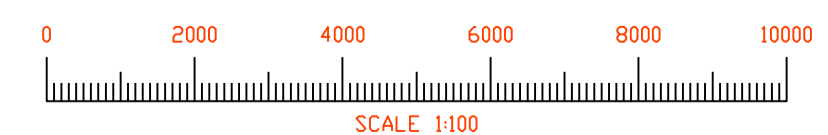

Designed by	Name	Signature	Date	1:100 @ A1	FOR CONSTRUCTION
Prepared by				SCALE & FORMAT	PROPOSED STATUS
Checked			02/09/2016	B1-72-B-01	FILE NAME
Approved			DATE OF 1ST ISSUE	B1-72-B-01	REV

B1-72-B-01
DRAWING NUMBER