 



Legend - CCTV	
	Dome type CCTV Camera

NOTES:  
1. LOCATION OF CCTV CONTROL EQUIPMENT TO BE CONFIRMED

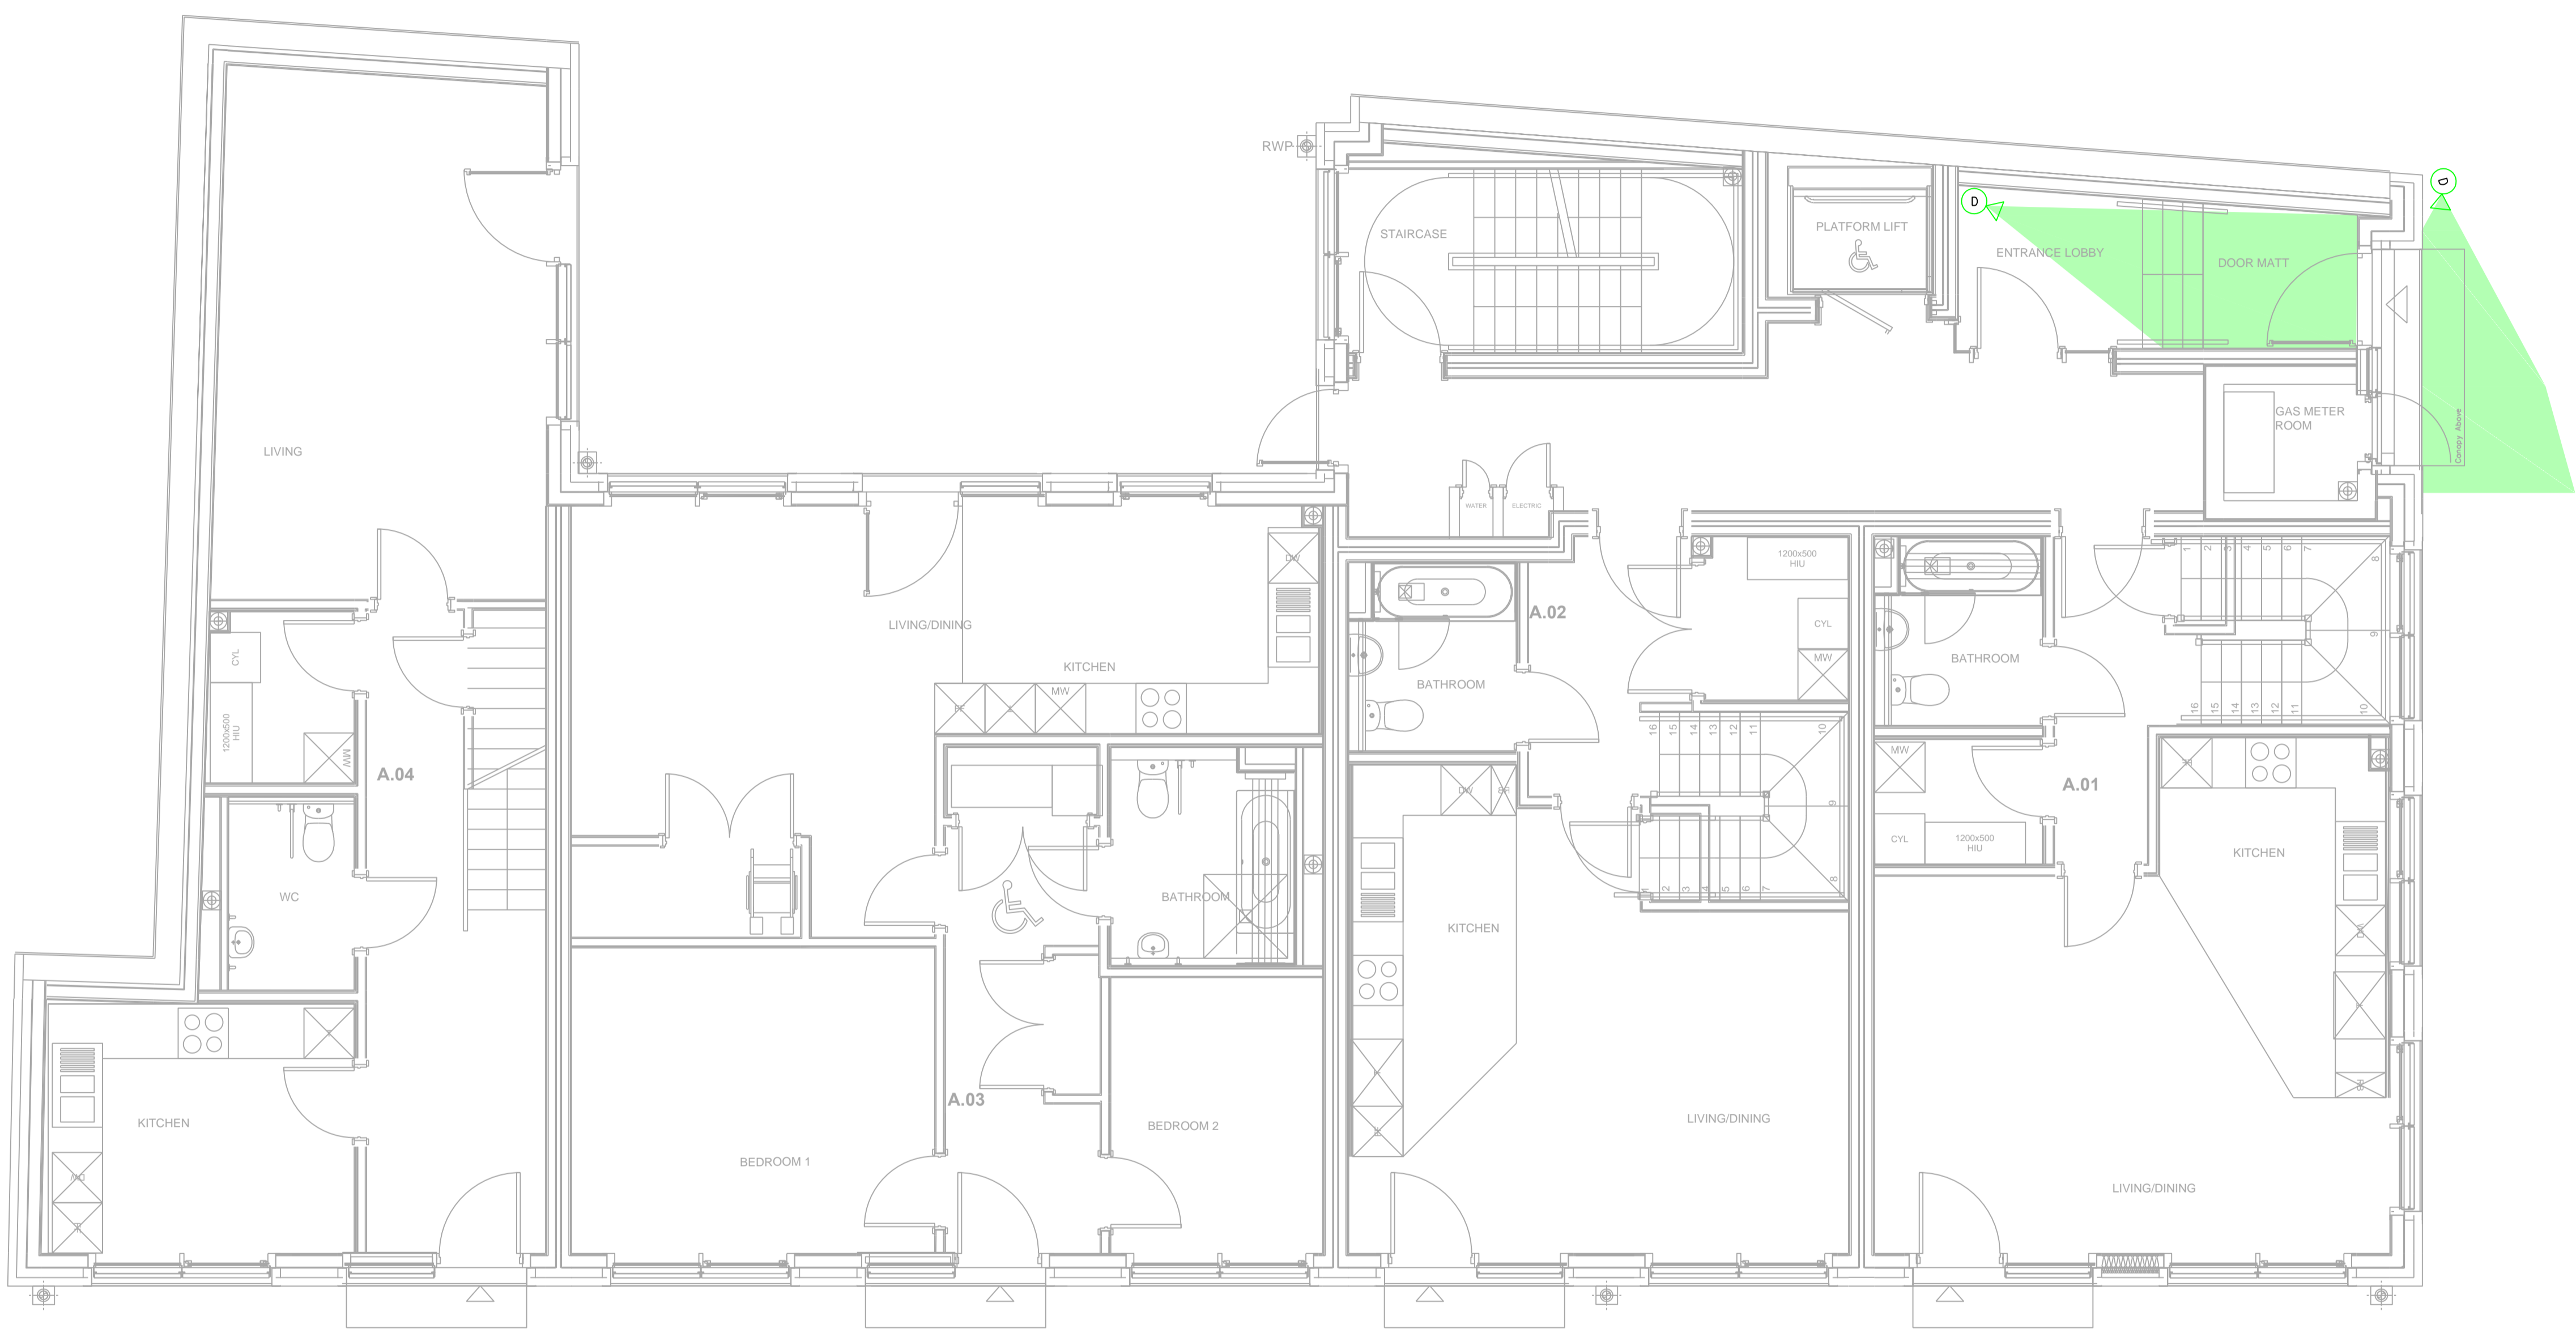

16/02/2016	FOR CONSTRUCTION	RP	MDM	INEO	MHL
DATE	REVISION HISTORY	DSG	PRP	CHK	APP

CLIENT EMPLOYER  
**LEGENDE CONSTRUCTION**

KEY PLAN


PROJECT  
**PARKER TOWER LONDON**

ORIGINATOR



ENGIE INEO  
Kings Yard, Watlington Road  
Queen Elizabeth Olympic Park  
London E15 2GP  
Tel: 0208 221 6600  
Web: www.engie.com  
E-mail: information@engie.com

**CCTV LAYOUT  
BLOCK A  
GROUND FLOOR**

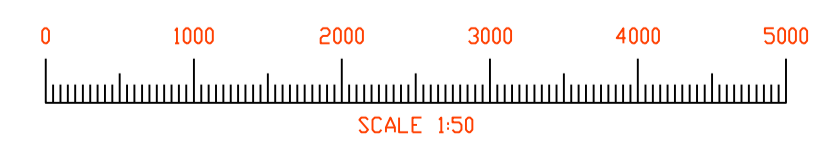

Checked by	Name	Signature	Date	1:50 @ A1	FOR CONSTRUCTION
Prepared by				SCALE & FORMAT	PROPOSED STATUS
Checked			02/09/2016	B2-72-G-01	
Approved				DATE OF ISSUE	FILE NAME

B2-72-G-01 C1  
DRAWING NUMBER REV