


FOR THIS DRAWING WE CLAIM LEGAL PROTECTION REGARDING COPYRIGHTS, COMMERCIAL COMPETITION AND INDUSTRIAL GUARANTEE. THIS DRAWING IS ONLY TO BE USED FOR THE PURPOSE FOR WHICH IT IS SUPPLIED AND WITHOUT OUR CONSENT IT MUST NEITHER BE COPIED OR MADE ACCESSIBLE TO ANY THIRD PARTY.

REVISIONS

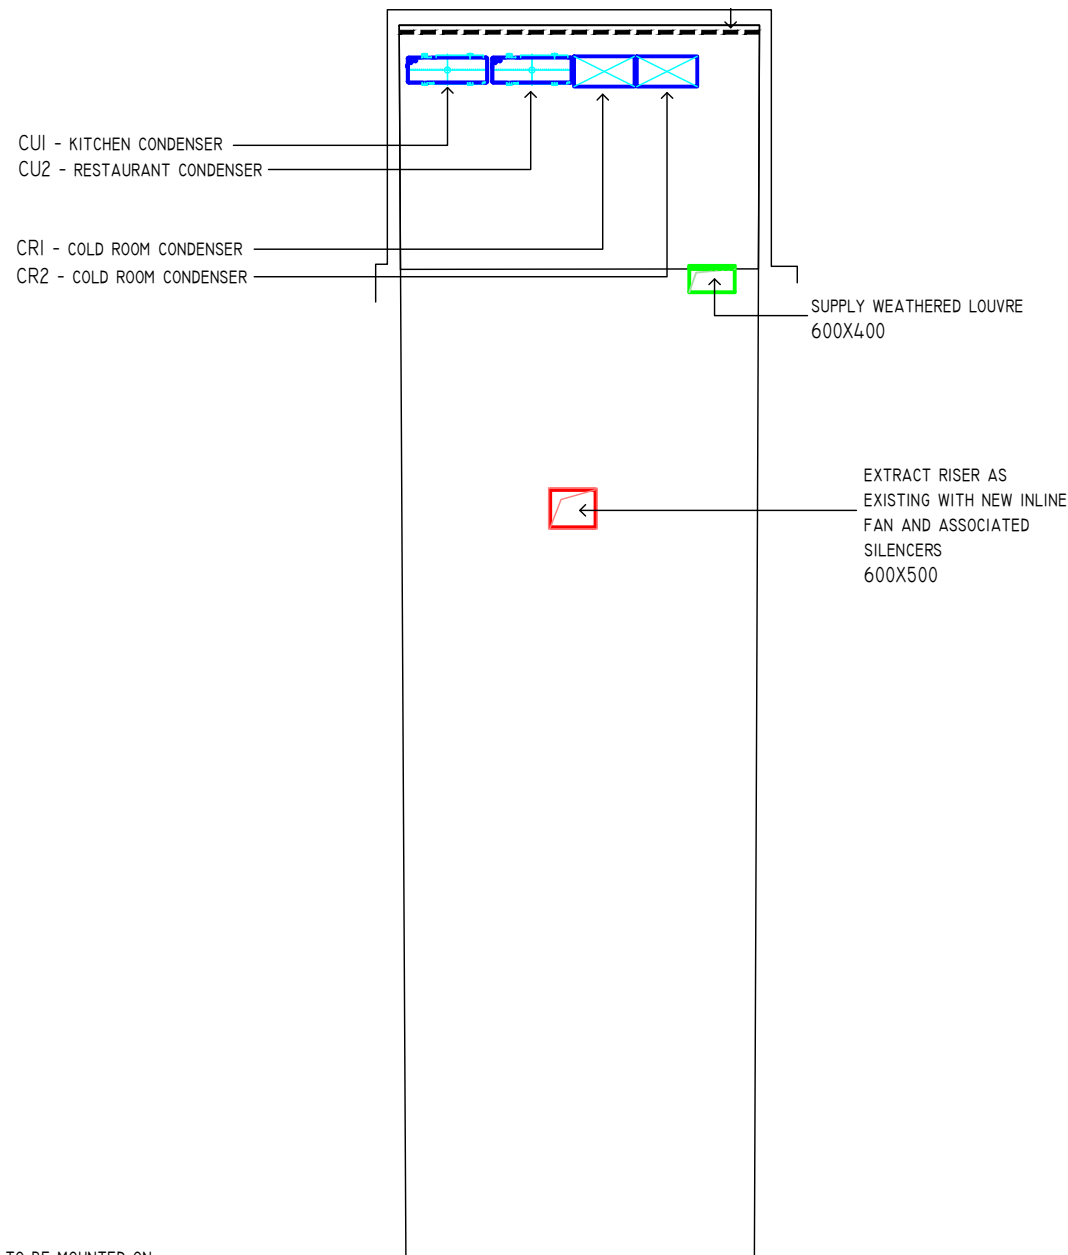

NOTE:  
 ALL PLANT TO BE MOUNTED ON ANTI VIBRATION CONDENSER BLOCKS

PROPOSED ROOF PLAN



REAR ELEVATIONS



EQUIPMENT LIST

CUI GROUND FLOOR/BASEMENT KITCHEN  
 MITSUBISHI PUHZ-140YHA  
 950MMx330MM+30x1338MM  
 131KG  
 16 AMP 3PHASE  
 4 CORE CABLE - INTERCONNECTING  
 52 DBA

CRI- COLD ROOM CONDENSER  
 ROOM 1 - 882X427X427 78KG 41DBA

CR2- COLD ROOM CONDENSER  
 ROOM 2 - 882X427X390 43KG 38DBA

CU2 GROUND FLOOR RESTAURANT  
 MITSUBISHI PUHZ-140YHA  
 950MMx330MM+30x943MM  
 67KG  
 16 AMP  
 4 CORE CABLE - INTERCONNECTING  
 48 DBA

PROJECT: KFC SOUTHAMPTON ROW

CLIENT: CASCADE

DRAWING: HVAC GA  
Proposed Roof Arrangement  
'Planning Only'

SCALE: 1:100@A3

DRAWN: D. McLean

DATE: 02.03.18

JOB No: 80809

CHECKED:

DATE:

DRAWING No: 80809 / M / 001 rev B