



THIRD FLOOR PLAN

EXISTING STRUCTURE

EXISTING

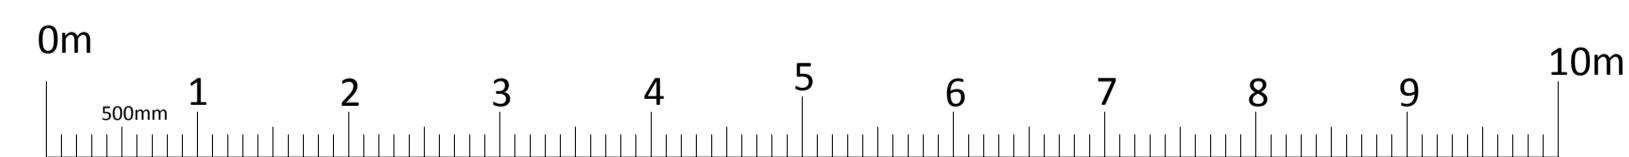

SCALE 1:50

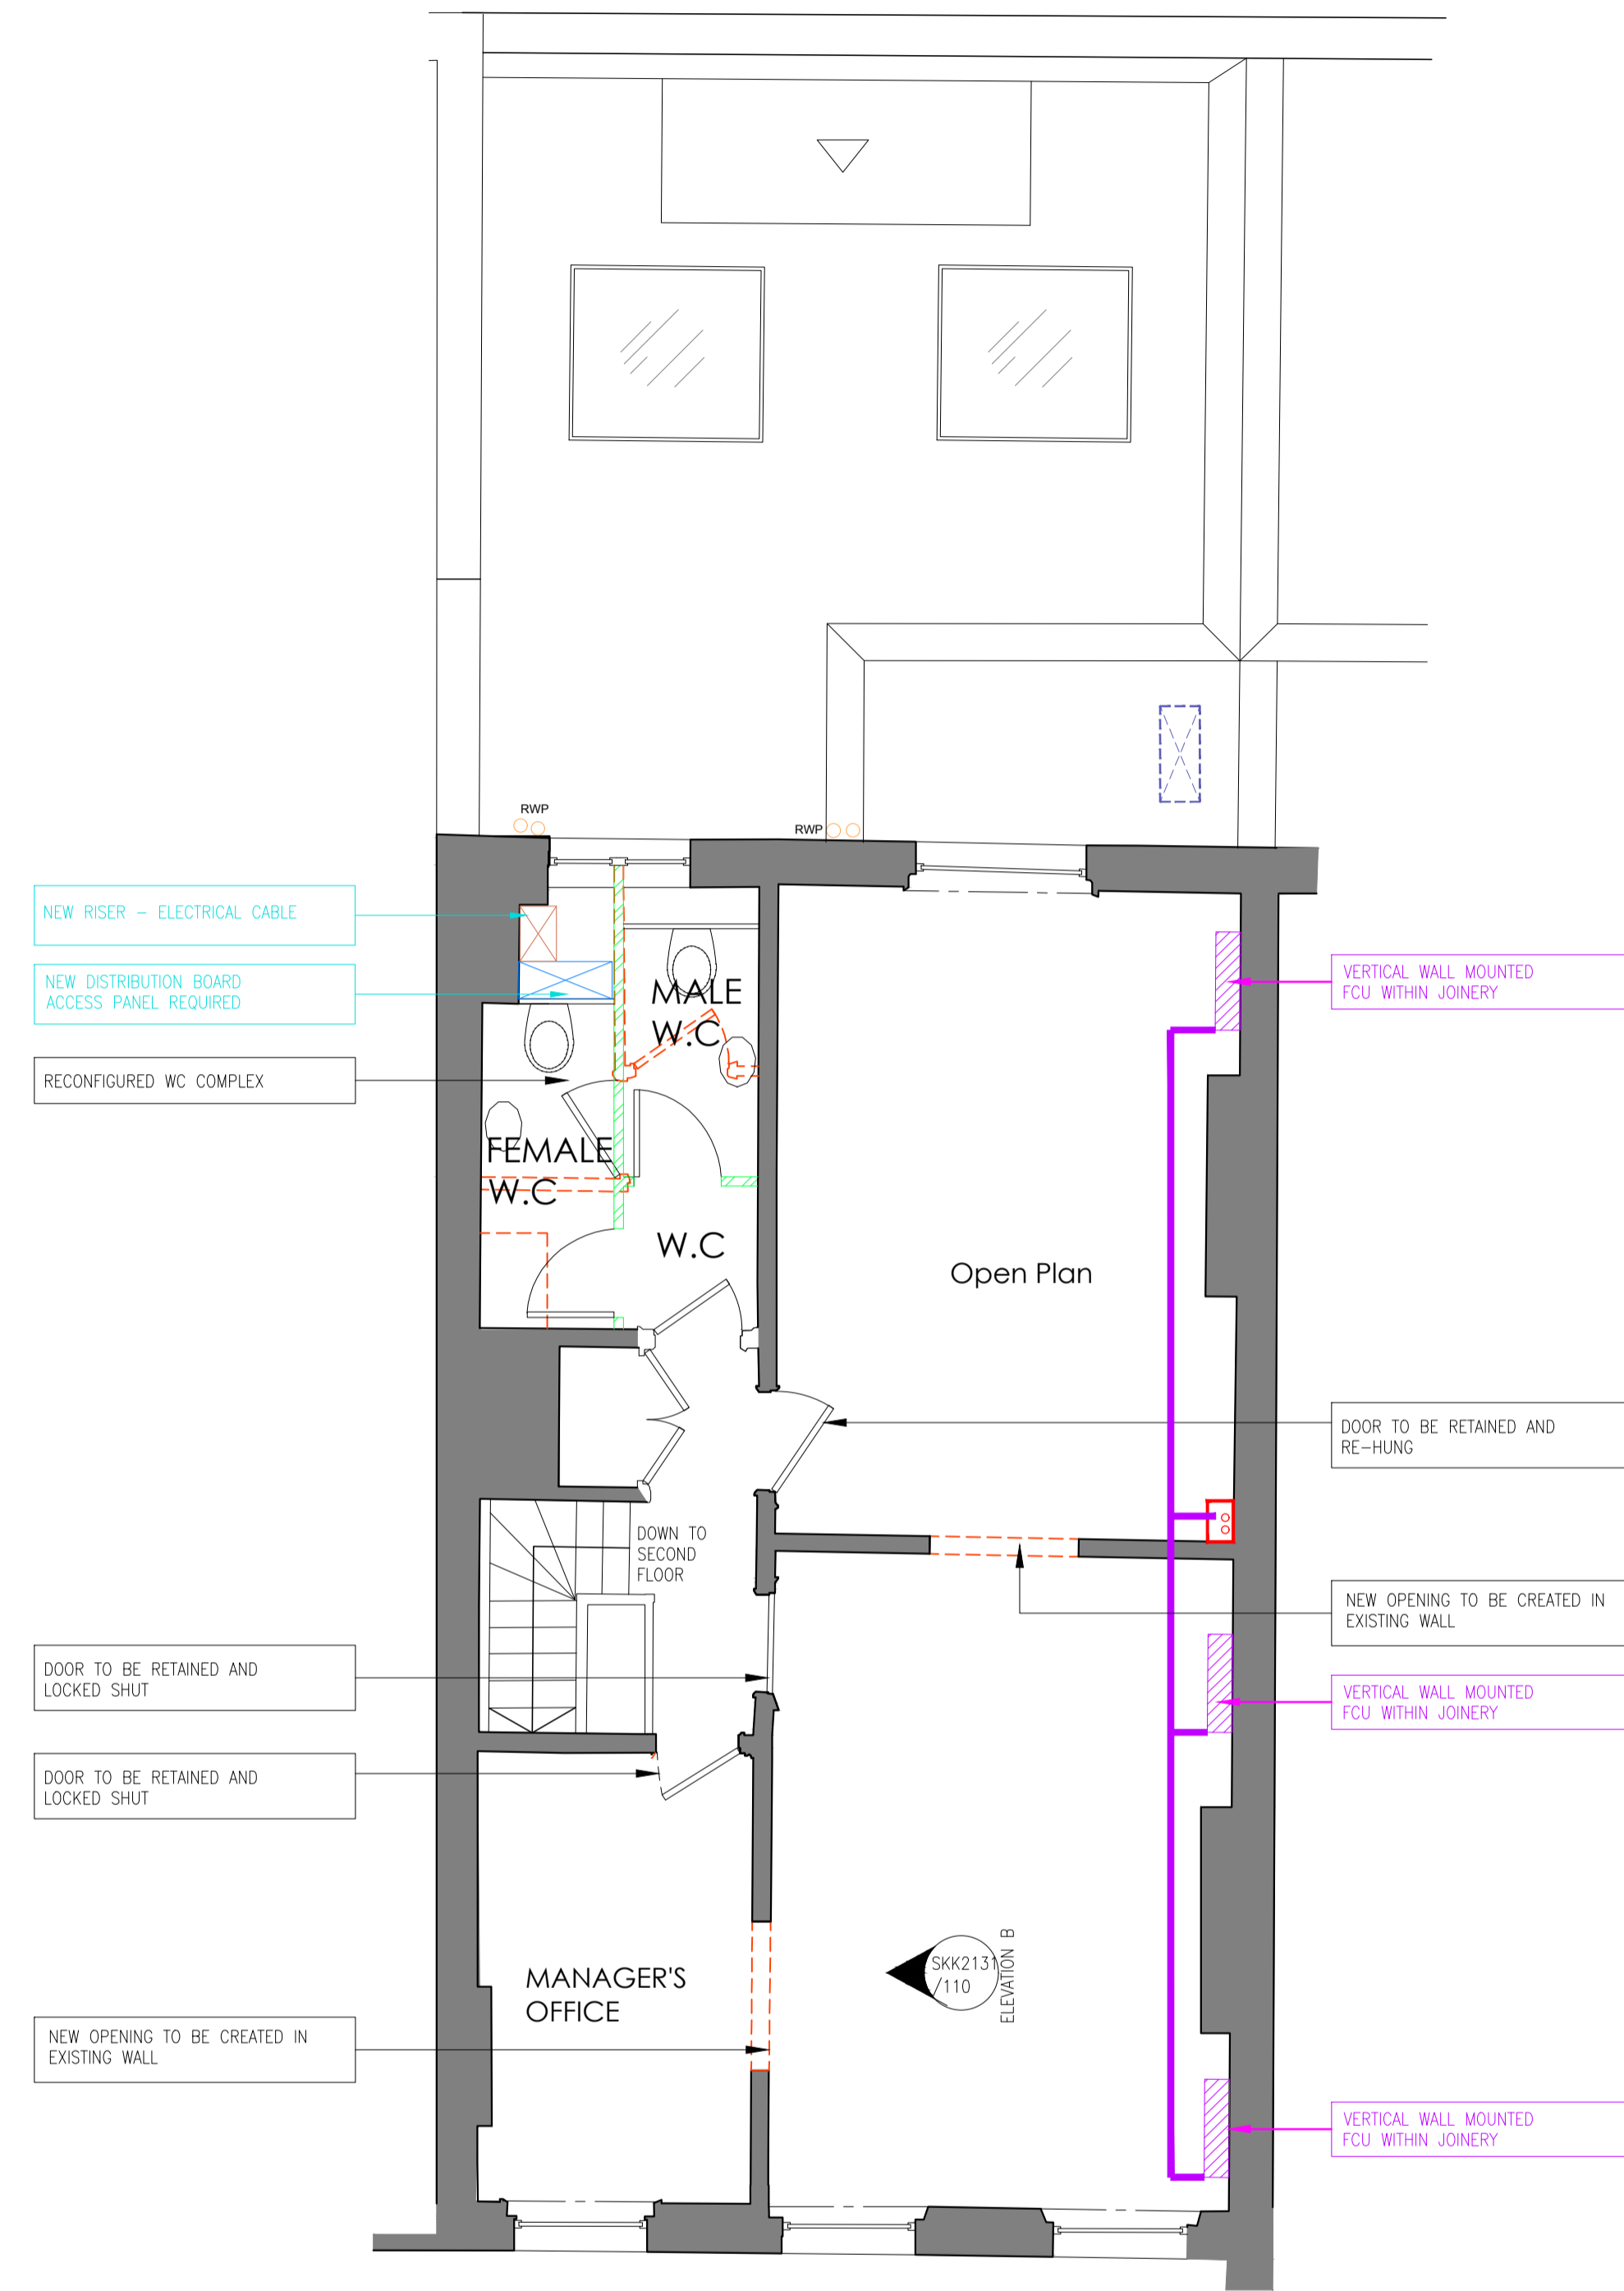

THIRD FLOOR PLAN

EXISTING STRUCTURE NEW PARTITION DEMOLITION

PROPOSED

LEGEND - MECHANICAL SERVICES

- NEW FAN COIL UNIT
- NEW PIPEWORK AT LOW LEVEL
- NEW PIPEWORK AT HIGH LEVEL

LEGEND - ELECTRICAL

- RISER FOR ELECTRICAL CABLES
- ELECTRICAL DISTRIBUTION BOARD

F	22/02/18	ISSUED FOR PLANNING	VP
D	06/11/17	ISSUED TO CAMDEN CITY COUNCIL	VP
C	25/01/17	ISSUED FOR PSD COMMENTS	VP
B	31/08/17	ISSUED TO CAMDEN CITY COUNCIL	VP
A	25/08/17	ISSUED FOR COMMENTS	VP

CLIENT PSG GLOBAL
 PROJECT 28 FITZROY SQUARE
 TITLE EXISTING & PROPOSED THIRD FLOOR PLANS

REVISION	DATE	DRAWN	CHECKED	SCALE
F	AUG '17	VP	APF	1:50 @ A1



INTERIOR, ARCHITECTURAL & RETAIL DESIGN

The Mill
 Stortford Road
 Hatfield Health
 CM22 7DL
 Tel: 01279 873010
 www.senken.com