


01 FIRST FLOOR PLAN SHOWING LOCATION OF NEW COOLING UNITS
 SCALE 1:20

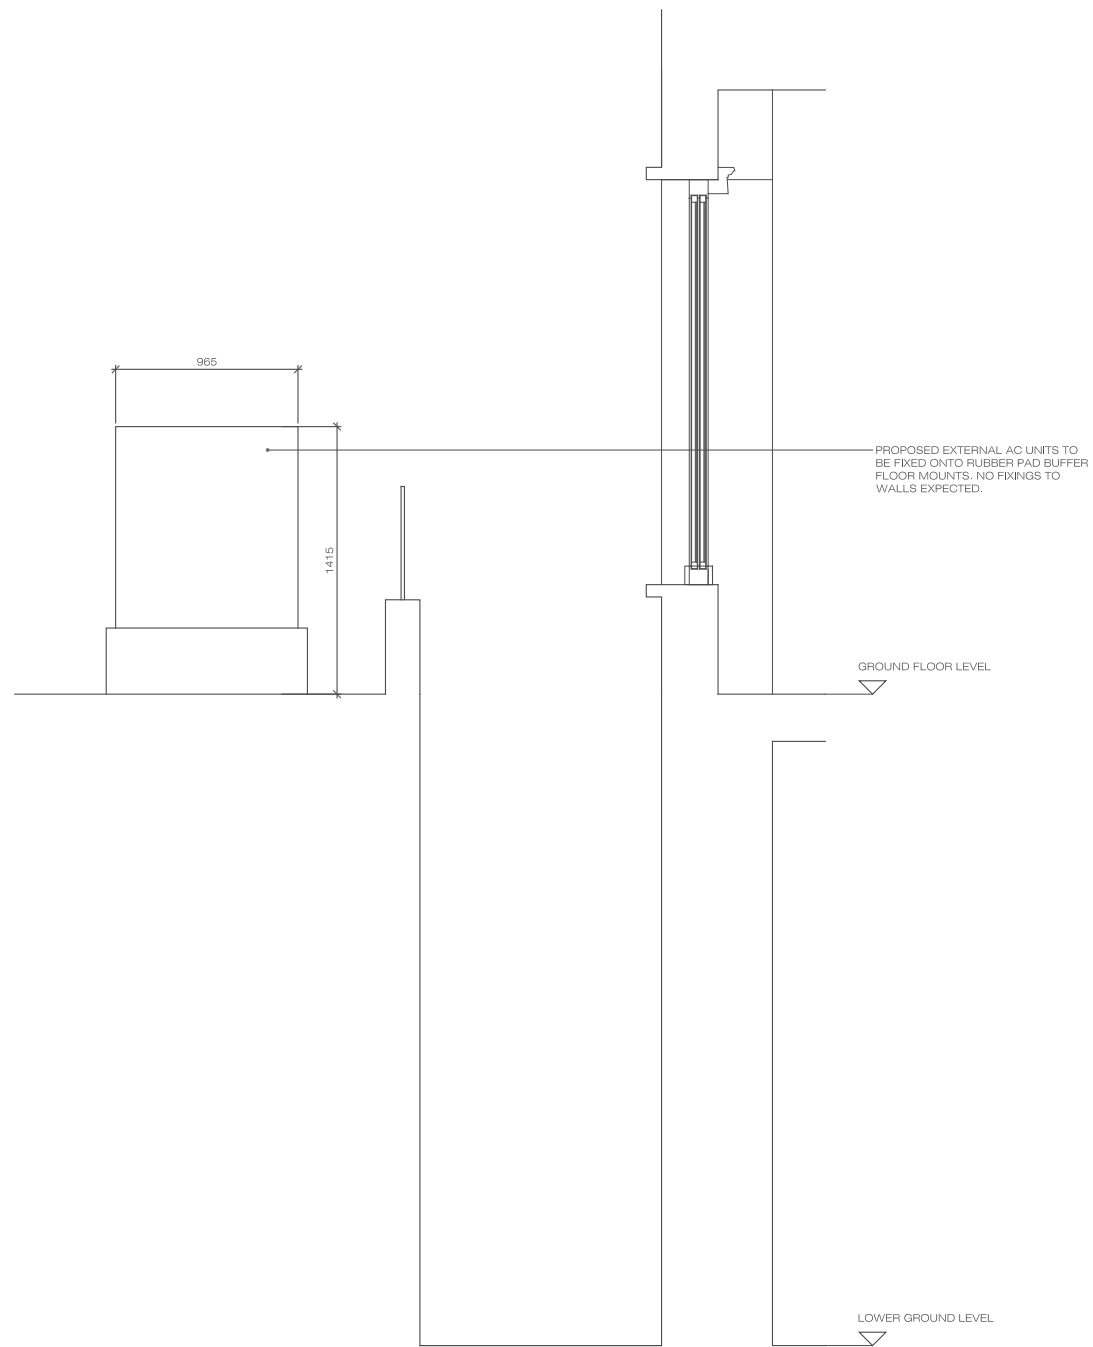

02 SECTION A-A THROUGH GROUND AND FIRST FLOOR SHOWING LOCATION OF NEW AC UNITS
 SCALE 1:20

	PROJECT TITLE: 14-15 Southampton Place					
	DRAWING TITLE: Proposed External AC Unit Location					
DWG STATUS: PLANNING						
DRAWN: MD	FILE: 648	DATE: 13.11.2017	REVISION: A			
CHECKED: TJM	JOB NO: 648	SCALE: 1:20@A1	DWG NO: 648_620			