



A North Elevation
Main House



B East Elevation
Main House



C South Elevation
Main House



D West Elevation
Main House

Notes

Positions shown on this drawing are indicative only and should be taken from designers layouts and elevations.

Copyright ©

This drawing and the copyright therein are the property of Ideaworks Ltd. This drawing must not be used, copied or otherwise duplicated without prior written permission of Ideaworks Ltd and no articles must be manufactured in accordance with this drawing or used other than permitted by Ideaworks Ltd.

Key to lighting symbols

Interior	Exterior
Round Pendant	Spike Light
Square Pendant	Underwater Light
Round downlight	Up-light
Square downlight	Surface mounted light
Twin square downlight	Wall light
Miniature downlight	Linear LED
Up-light	Lantern
Surface mounted light	Bollard
Wall light	Floor washer
Picture light	Lamp post
Tread light	Tread light
Local sump outlet	Provisional Feed
Local power outlet	Additional
Vertical linear LED	Section Tag 1 - Detail number 2 - Detail page
High Level linear LED	Callout Tag 1 - Detail number 2 - Detail page
Low level linear LED	Center line
Utility light	Lighting control panel
Reading light	Decorative light
Provisional Feed	
Local door contact	
Locally switched PIR	
Local light switch	
Elevations	
Up-light	
Surface mounted light	
Tread Light	
Decorative wall light	
Decorative pendant	

Revision History

Rev	Date	Description	By	Ch.
FI	07/12/2017	For Information	MS	FNP
A	12/04/2018	For Information	MS	OW



Ideaworks Limited
206 Great Portland Street
London W1W 5QJ


t +44 (0)20 3668 9870
e info@ideaworks.co.uk
w ideaworks.co.uk

Size	Scale (do not scale for print)
A1	1:100
Drawn / date	Signed / date
MS 07/12/2017	FNP 07/12/2017


Project
Athlone House

Description
Elevations - Main House
Lighting layout

DWG no.	Rev.	Pg.
4395-520	A	1/2

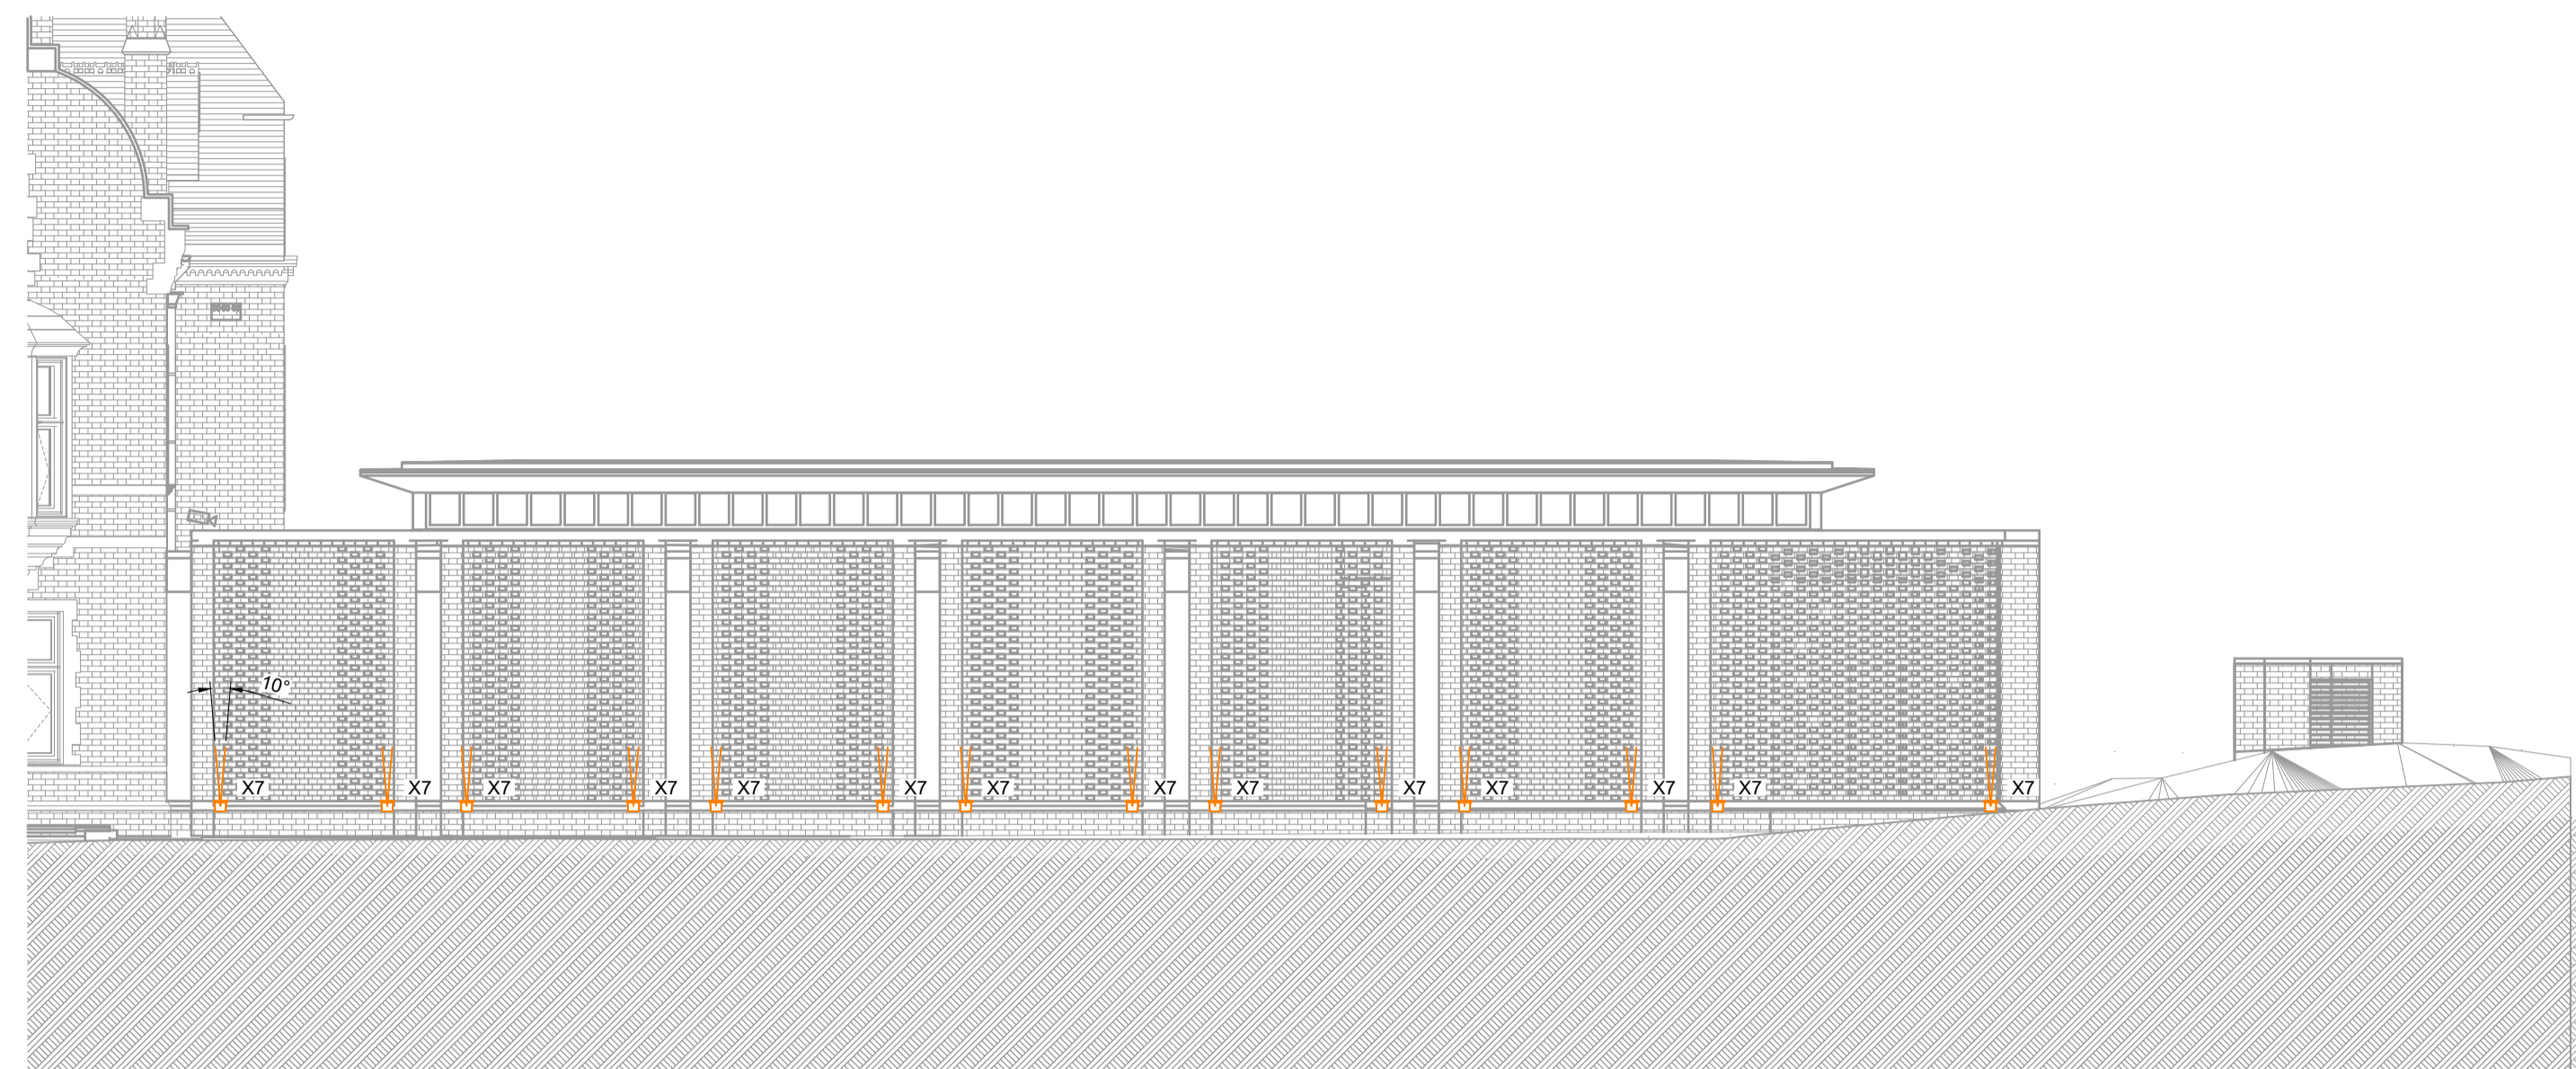

E East Elevation
New Wing

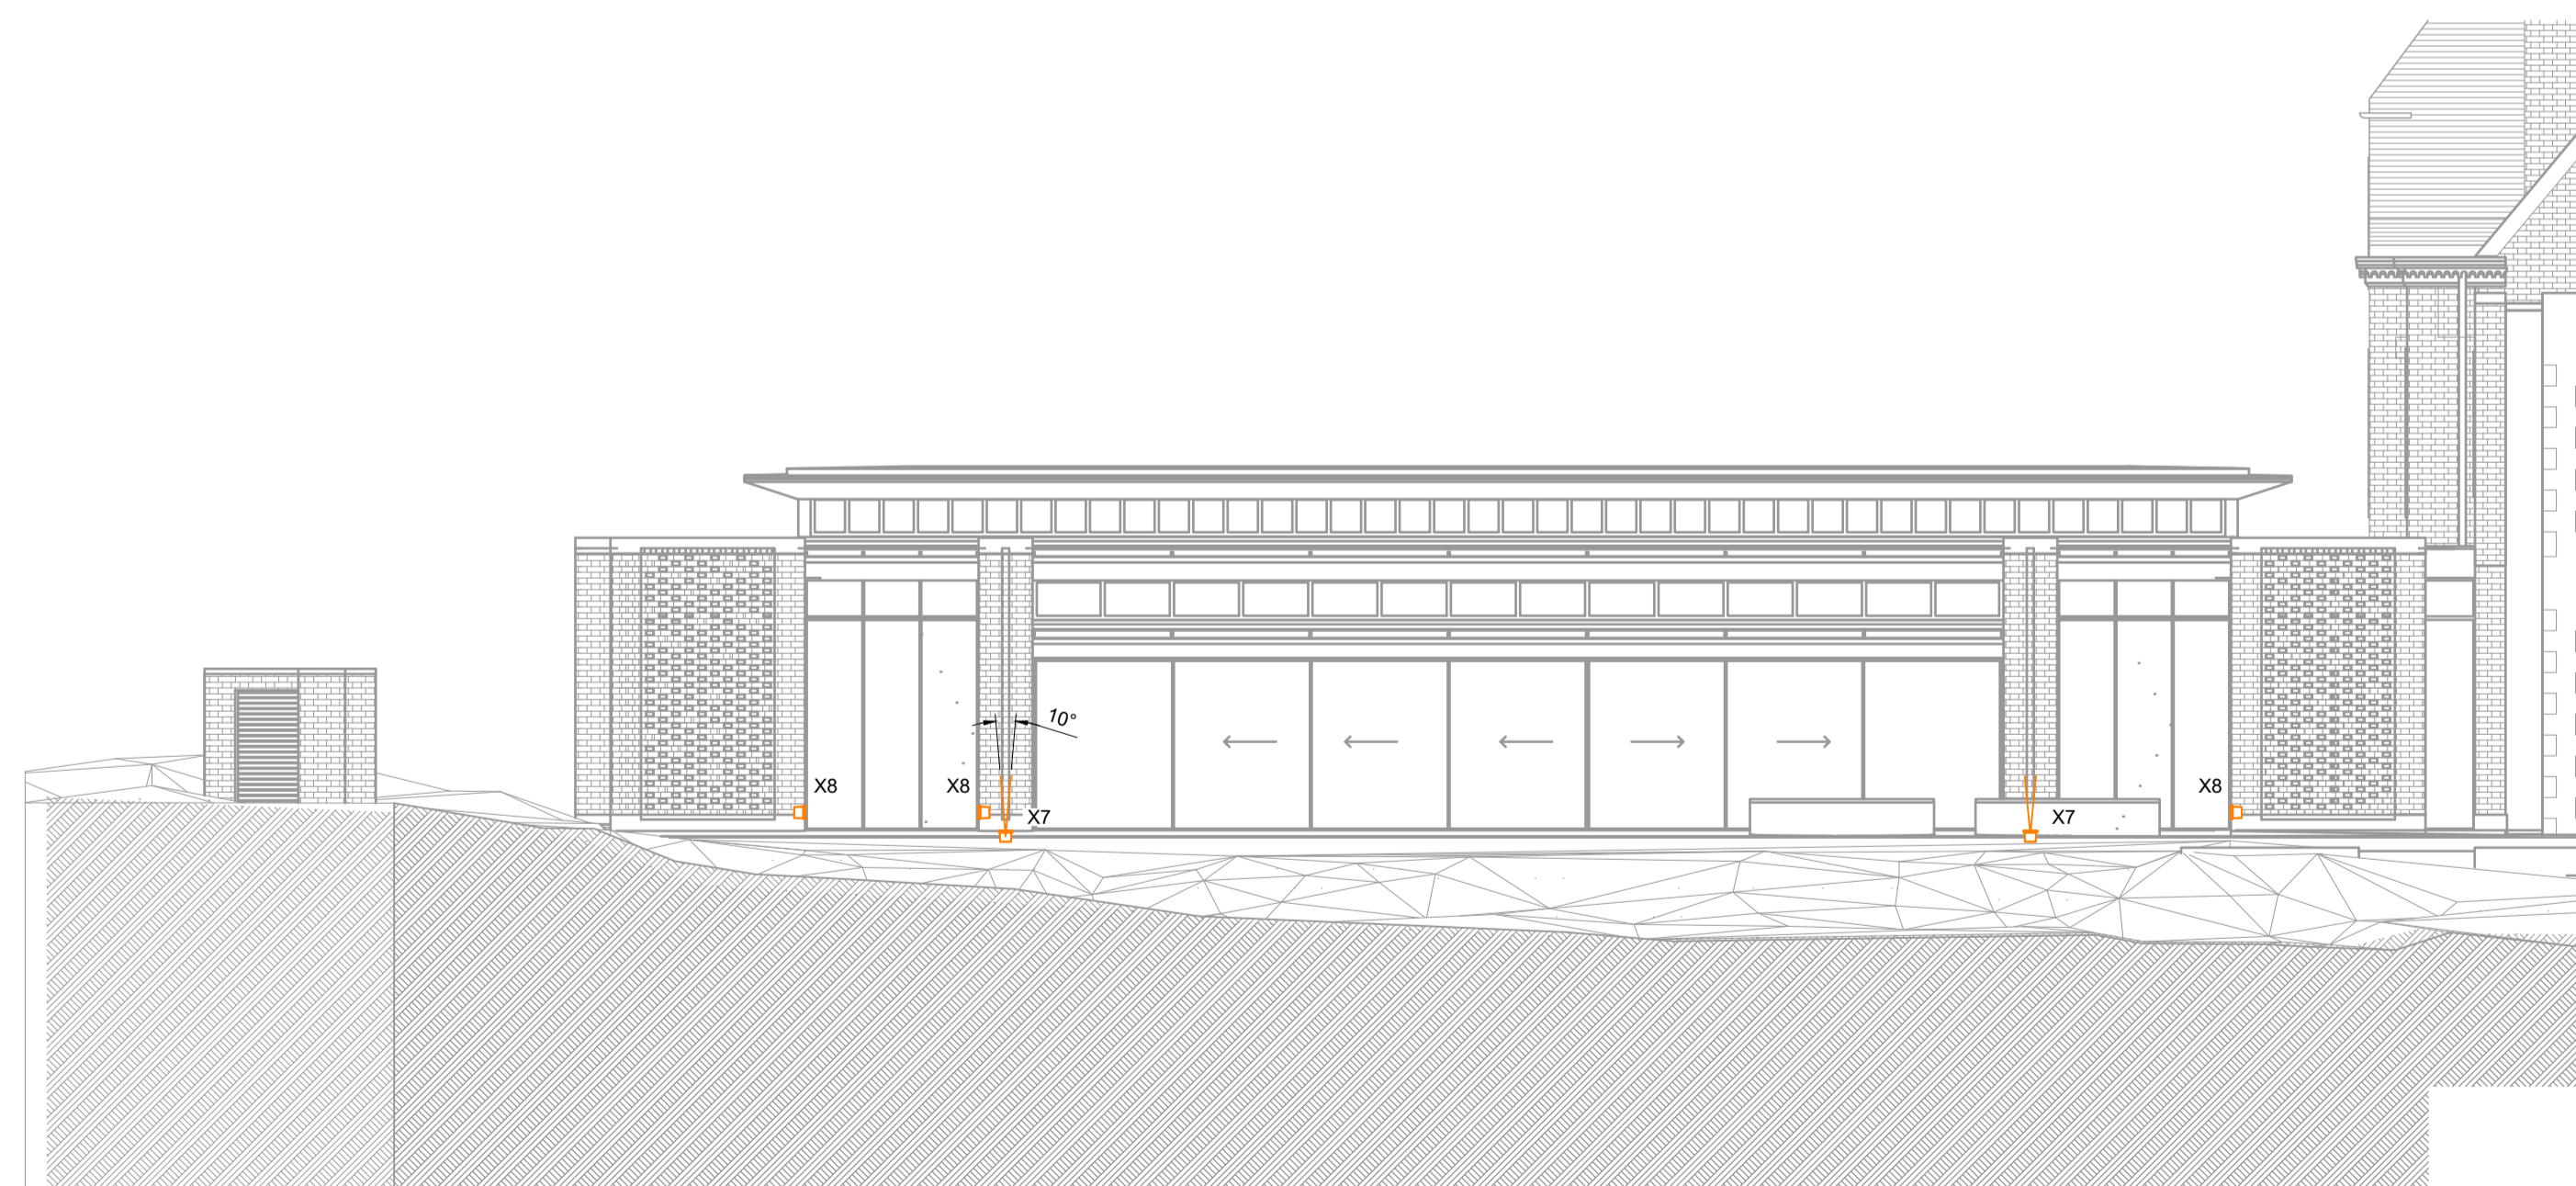

F West Elevation
New Wing

Notes

Positions shown on this drawing are indicative only and should be taken from designers layouts and elevations.

Copyright ©

This drawing and the copyright therein are the property of Ideaworks Ltd. This drawing must not be used, copied or otherwise duplicated without prior written permission of Ideaworks Ltd and no articles must be manufactured in accordance with this drawing or used other than permitted by Ideaworks Ltd.

Key to lighting symbols

Interior	Exterior
Round Pendant	Spike Light
Square Pendant	Underwater Light
Round downlight	Up-light
Square downlight	Surface mounted light
Twin square downlight	Wall light
Miniature downlight	Linear LED
Up-light	Lantern
Surface mounted light	Bollard
Wall light	Floor washer
Picture light	Lamp post
Tread light	Tread light
Local sump outlet	Provisional Feed
Local power outlet	Additional
Vertical linear LED	Section Tag 1 - Detail number 2 - Detail page
High Level linear LED	Callout Tag 1 - Detail number 2 - Detail page
Low level linear LED	Center line
Utility light	Lighting control panel
Reading light	Decorative light
Provisional Feed	
Local door contact	
Locally switched PIR	
Local light switch	
Elevations	
Up-light	
Surface mounted light	
Tread Light	
Decorative wall light	
Decorative pendant	

Revision History

Rev	Date	Description	By	Ch.
FI	07/12/2017	For Information	MS	FNP
A	12/04/2018	For Information	MS	OW



Ideaworks Limited
206 Great Portland Street
London W1W 5QJ

t +44 (0)20 3668 9870
e info@ideaworks.co.uk
w ideaworks.co.uk

Size: A1
Scale (do not scale for print): 1:100

Drawn / date: MS 07/12/2017
Signed / date: FNP 07/12/2017

Project: Athlone House

Description: Elevations - New Wing
Lighting layout

DWG no.: 4395-520
Rev.: A
Pg.: 2/2