

LONDON BOROUGH OF CAMDEN
TOWN AND COUNCIL BY LAMING ACTS
1960 3256
LAW APPROVED
ON BEHALF OF THE COUNCIL


Revisions	Suffix / Date / Drawn by	D	7/11/95	EH	DRGS REVISED IN ACCORDANCE WITH BH LAYOUTS DATED 23/10/95	F	21/10/96	JPA	PURCHASER REQUIREMENTS -- LOBBY ADDED BETWEEN GALLERY AND WC.
A	04/11/94 ABM				BERKELEY HOMES REV 4TH NOV BATHROOMS B9.9 REV ROOF LIGHT OVER GALLERY AREA ADDED				
B	06/08/95 JD	E	9/11/95	EH	DRGS REVISED TO BH COMMENTS 8/11/95 DOOR DIMS AMENDED HATCHING AMENDED WC AMENDED SPIRAL STAIR AMENDED				
C	17/10/95 INDEQ				INFORMATION ADDED FOR FIT OUT CONTRACT DRAINAGE REVISED				

KEY TO SYMBOLS:-

	NEW BRICKWORK see drawing for thickness		NEW CAVITY WALL see DRG A&D2701 for reveal detail	SVP - S&L VENT PIPE	STAIRS NOTE: SETTING OUT DIMENSIONS ARE FINISHED SIZES
	NEW BLOCKWORK see drawing for thickness		NEW METAL STUD PARTITION see drawing for thickness	SS - STUB STACK	FHD - FULL HEIGHT DUCT
	215 PARTY BLOCK WALL		EXISTING WALL	LLD - LOW LEVEL DUCT	RWP - RAINWATER PIPE

Job Name:
NEW END HOSPITAL
BLOCK B FITTING OUT CONTRACT
Drawing Title:
SECOND FLOOR MEZZ PLAN
SHEET 2

Job Reference:
BH.NEH
Drawing number / Revision suffix:
AL(3)210 F
Scale:
1:50
Date:
OCT 94
Drawn:
ABM
Checked:
John Thompson and Partners
77 Cowcross Street London EC1M 6BP 0171-2515135

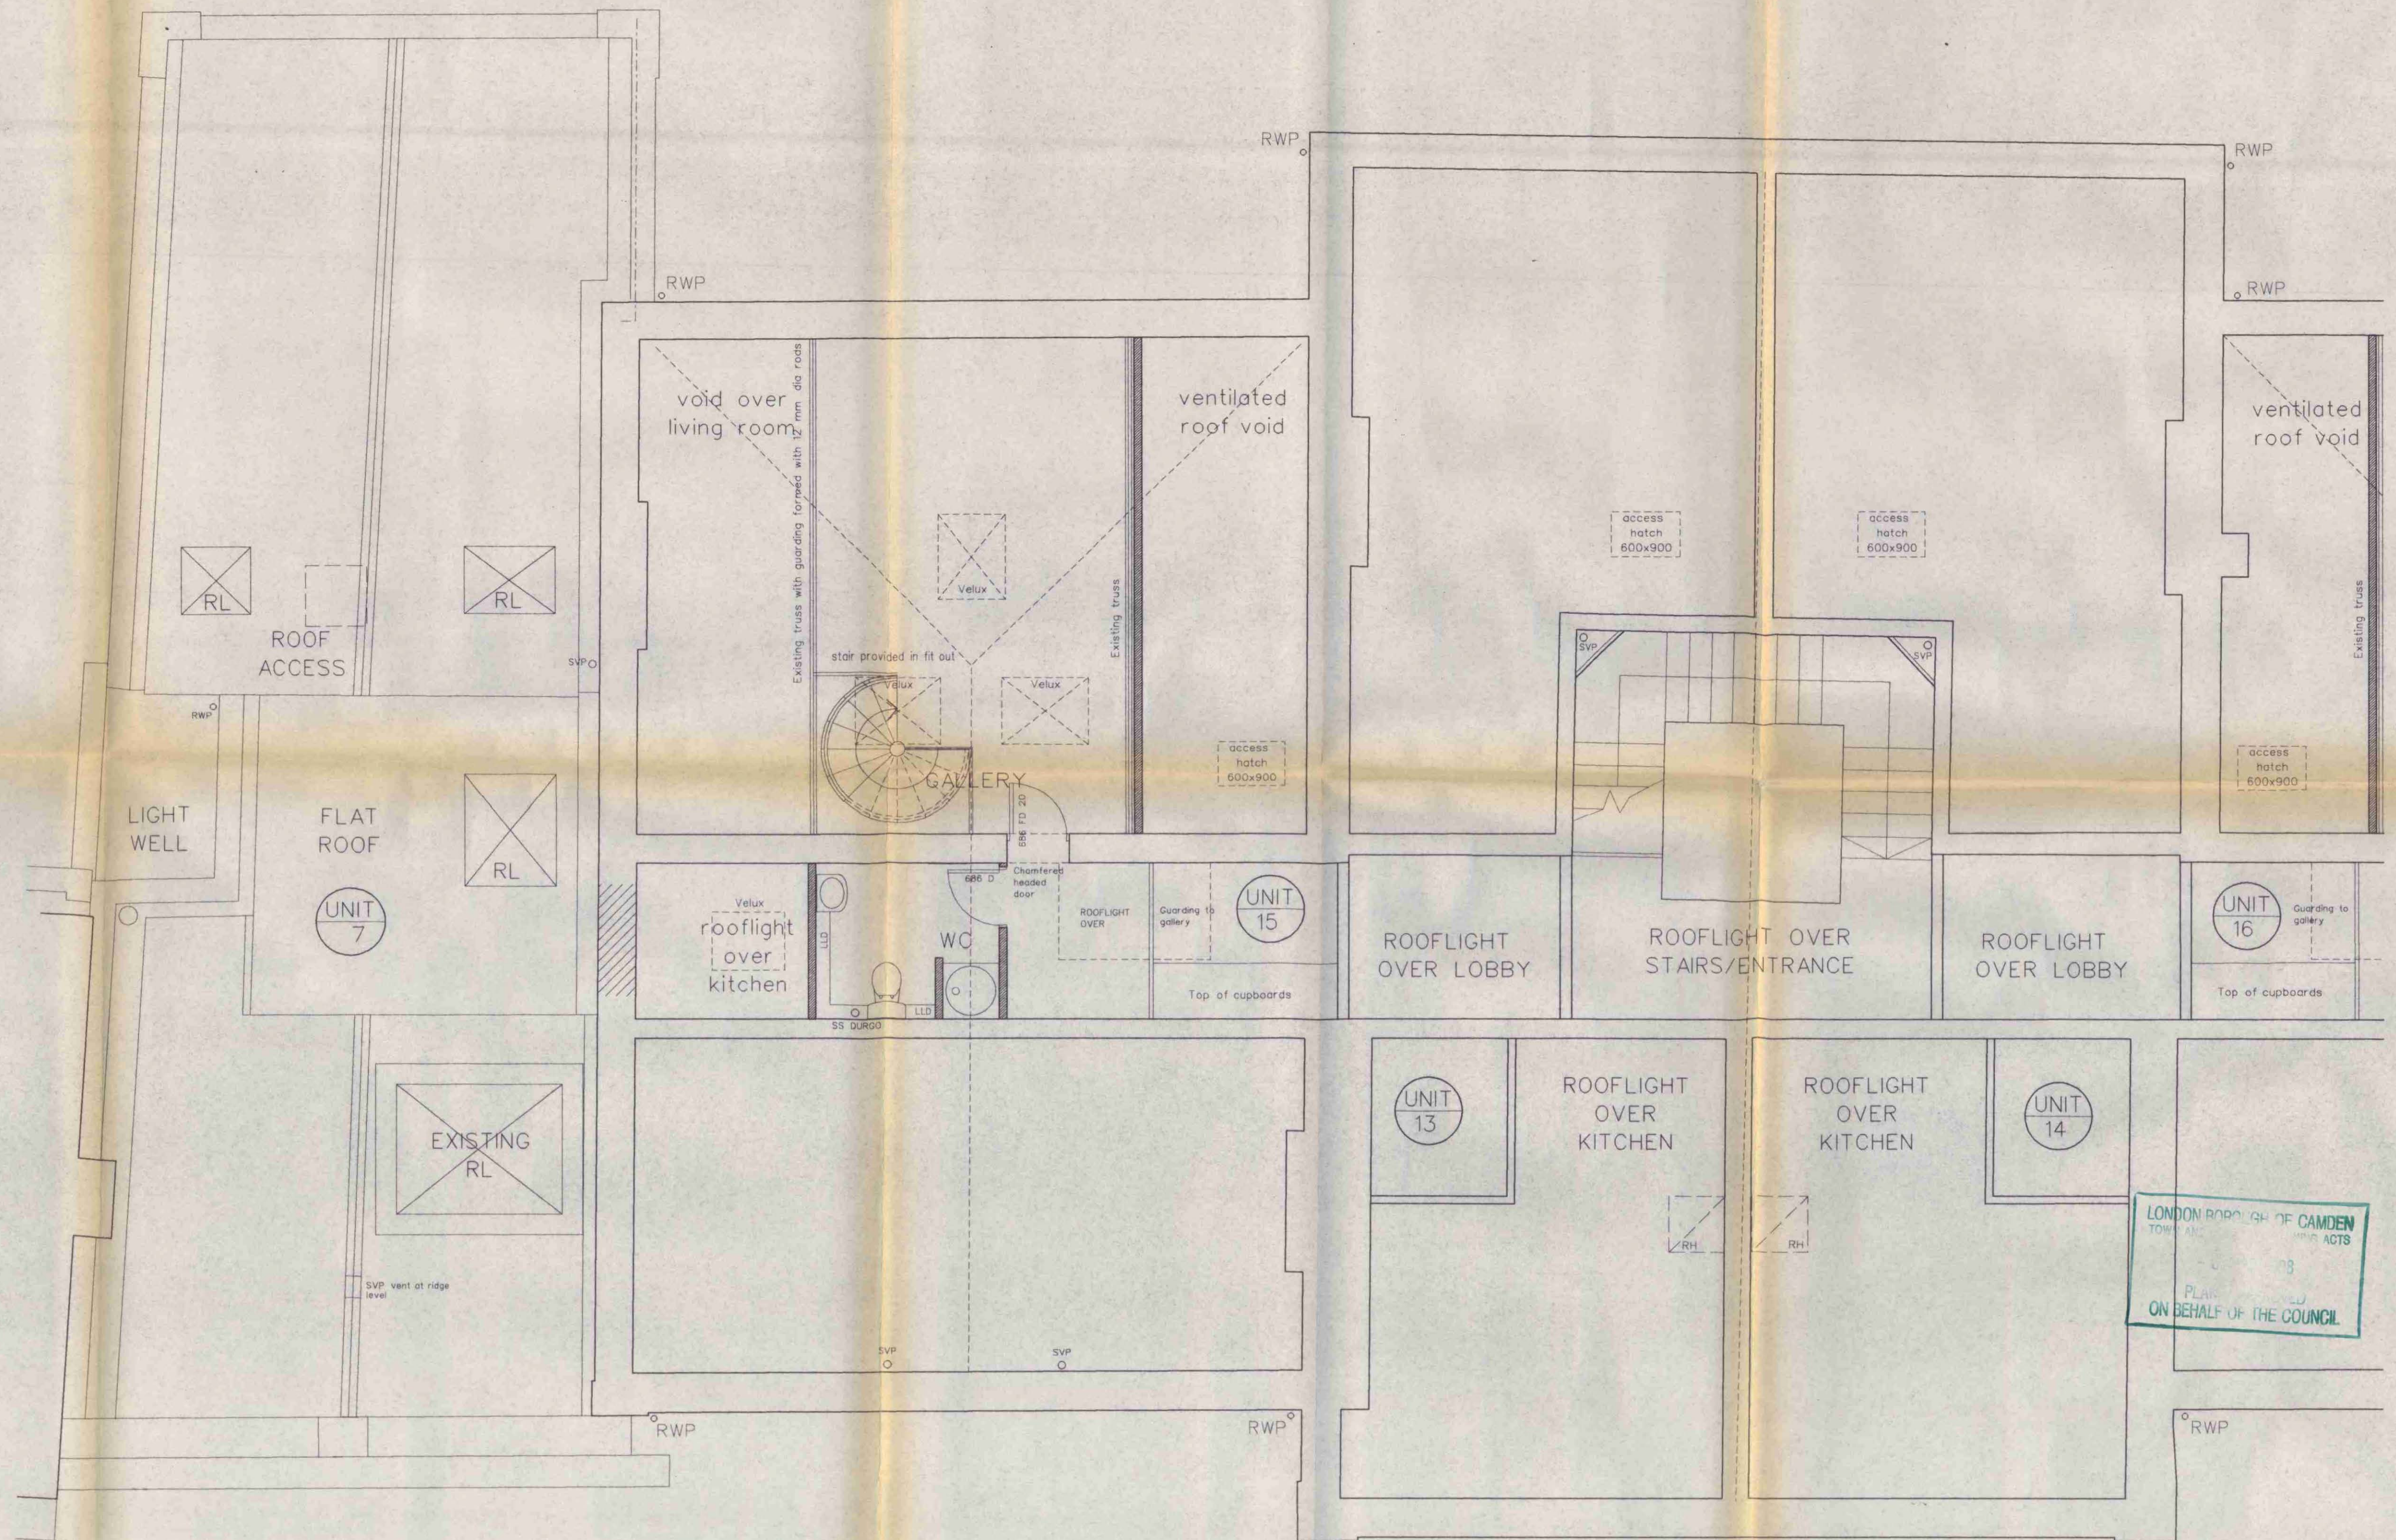

L9603256 1

Revisions		Date	Drawn by	Checked by	Description
A	04/11/94	ABM			BERKELEY NOMES REV 4th NOV BATHROOMS B3.9 REV ROOF LIGHT OVER GALLERY AREA ADDED
B	6/08/95	JD			INFORMATION ADDED FOR FIT OUT CONTRACT
C	17/10/95	NDEQ			DRAINAGE REVISED
D	7/11/95	EH			DRGS AMENDED IN LINE WITH BH LAYOUTS DATED 23/10/95
E	9/11/95	EH			DRGS AMENDED TO BH COMMENTS 8/11/95 DOOR DIMS AMENDED SVPS AMENDED WC AMENDED SPIRAL STAIRS AMENDED
F	21/10/96	JPA			PURCHASER REQUIREMENTS - LOBBY ADDED BETWEEN GALLERY AND WC.

KEY TO SYMBOLS:-

- NEW BRICKWORK see drawing for thickness
- NEW BLOCKWORK see drawing for thickness
- 2B PARTY BLOCK WALL
- NEW CAVITY WALL see DRG AA21701 for revised detail
- NEW METAL STUD PARTITION see drawing for thickness
- EXISTING WALL
- SVP - SOIL VENT PIPE
- SS - STAIR STACK
- FHD - FULL HEIGHT DUCT
- LLD - LOW LEVEL DUCT
- RWP - RAINWATER PIPE
- STAIRS NOTE: SETTING OUT DIMENSIONS ARE FINISHED SIZES

Job Name:
NEW END HOSPITAL
BLOCK B FITTING OUT CONTRACT

Drawing Title:
SECOND FLOOR MEZZ PLAN
SHEET 1

Job Reference:
BH.NEH

Code:
F

Drawing number / Revision suffix:
AL(3)209 F


Scale:
1:50

Date:
OCT 94

Drawn:
ABM

Checked:


John Thompson and Partners
77 Cowcross Street London EC1M 6BP 071-2515135

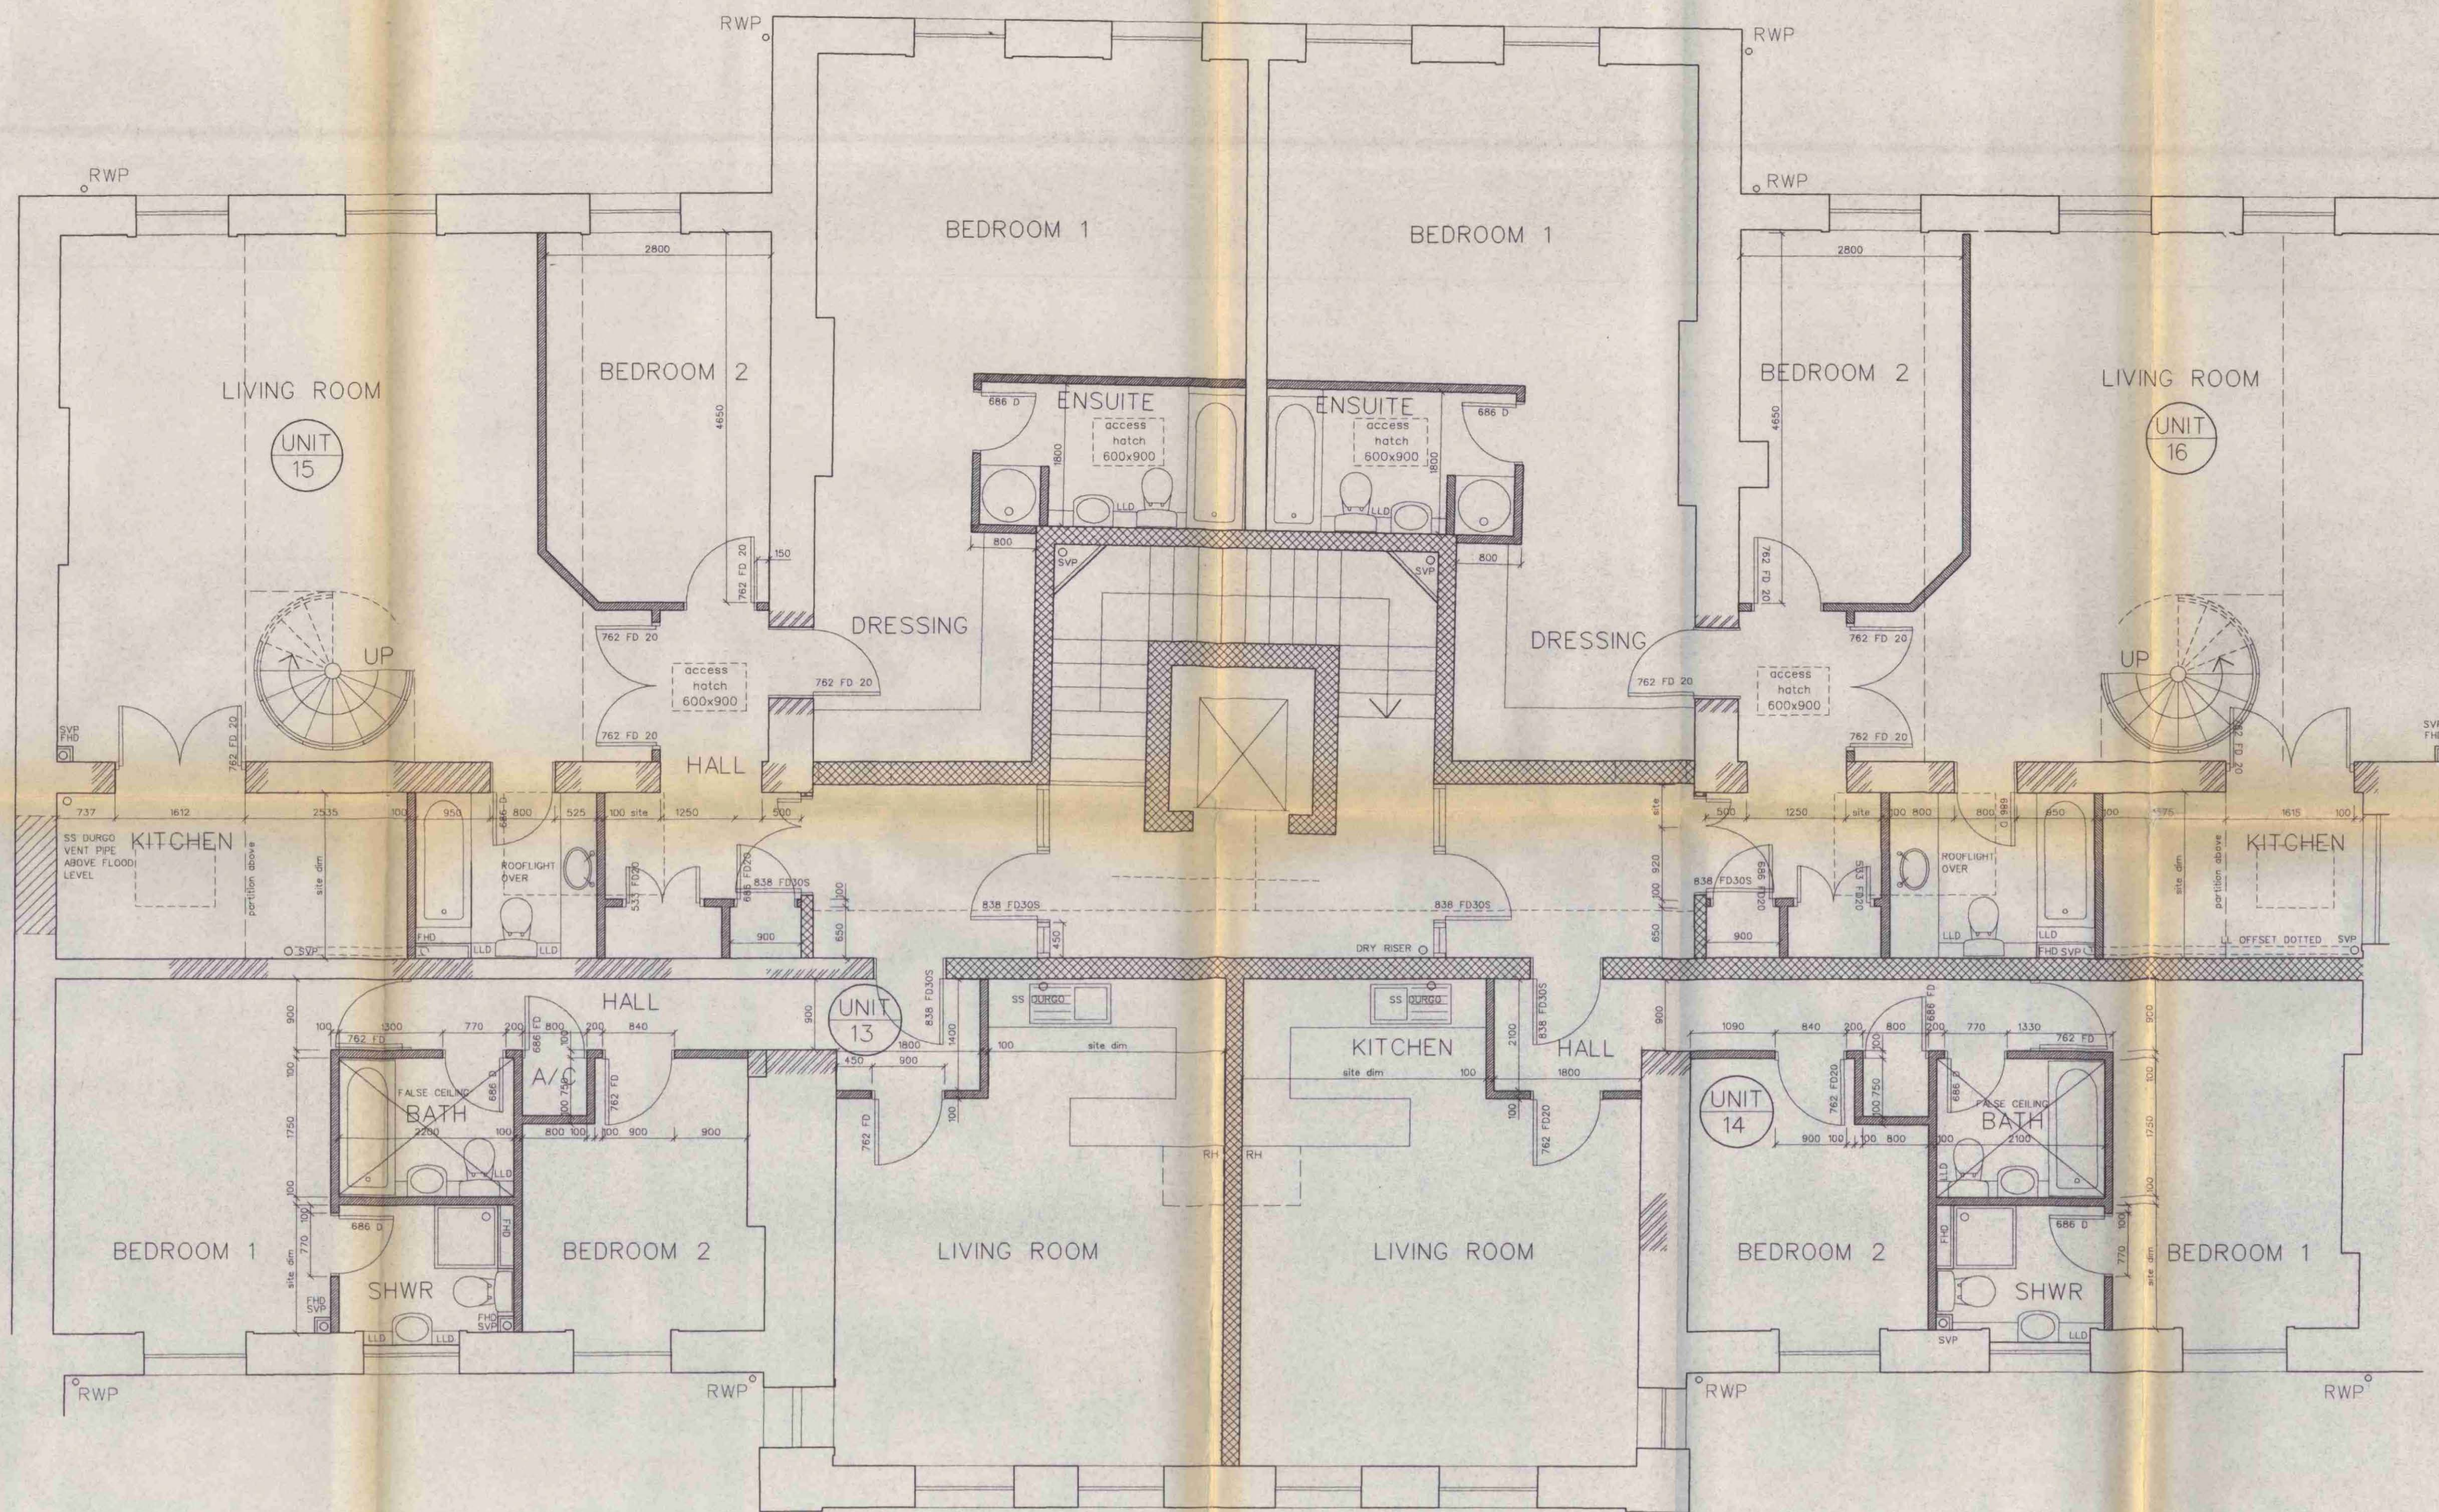

LONDON BOROUGH OF CAMDEN
TOWN AND COUNCIL
PLANNING ACTS
- 6 1998
PLANS APPROVED
ON BEHALF OF THE COUNCIL

L9603256 1


Revisions: A 04/11/94 ABM BERKELEY HOMES REV 4th NOV BATHROOMS B3.4/ B5.7 INTERNAL LAYOUT REVISED FOR FIT OUT B 04/08/95 EH PLOTS RENUMBERED BATHROOM LAYOUTS REVISED DRAINAGE REVISED C 17/10/95 NDEQ		D 7/11/95 EH DRAWINGS AMENDED IN LINE WITH BH LAYOUTS 23 OCT 95 E 9/11/95 EH DRAWINGS AMENDED TO BH COMMENTS OF 8/11/95 SVPS AMENDED DOOR REFS/DIMS AMENDED SHWR STUDWORK DELETED HATCHING AMENDED ROOM NAMES AMENDED MAIN STAIR AMENDED	F 21/10/96 JPA PURCHASERS REQUIREMENTS ADDED. THIS DRAWING AMALGAMATED WITH DRAWING 208	KEY TO SYMBOLS:- [Symbol] NEW BRICKWORK see drawing for thickness [Symbol] NEW BLOCKWORK see drawing for thickness [Symbol] 215 PARTY BLOCK WALL [Symbol] NEW CAVITY WALL see DRG AM2/7/01 for reveal detail [Symbol] NEW METAL STUD PARTITION see drawing for thickness [Symbol] EXISTING WALL SVP - SOL VENT PIPE SS - STUB STACK FHD - FULL HEIGHT DUCT LLD - LOW LEVEL DUCT RWP - RAINWATER PIPE STAIRS NOTE: SETTING OUT DIMENSIONS ARE FINISHED SIZES	Job Name: NEW END HOSPITAL BLOCK B FITTING OUT CONTRACT Drawing Title: SECOND FLOOR PLAN SHEET 1	Job Reference: BH.NEH Code: F Drawing number / Revision suffix: AL(3)207 F Scale: 1:50 Date: OCT 94 Drawn: ABM Checked: [Signature] John Thompson and Partners 77 Cowcross Street London EC1M 6BP 0171-2515155
--	--	---	---	--	---	--

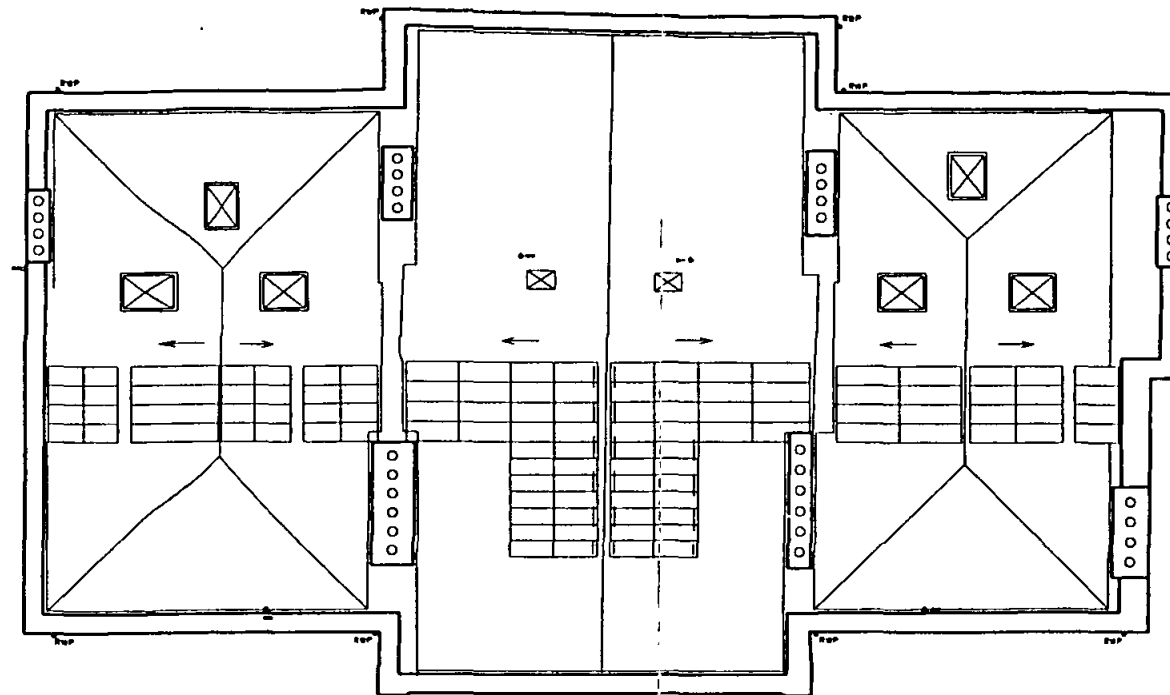

ROOF PLAN 2


19603256

LONDON BOROUGH OF CAMDEN
TOWN AND COUNTRY PLANNING ACTS
- 3 MAR 1998
PLANS APPROVED
ON BEHALF OF THE COUNCIL

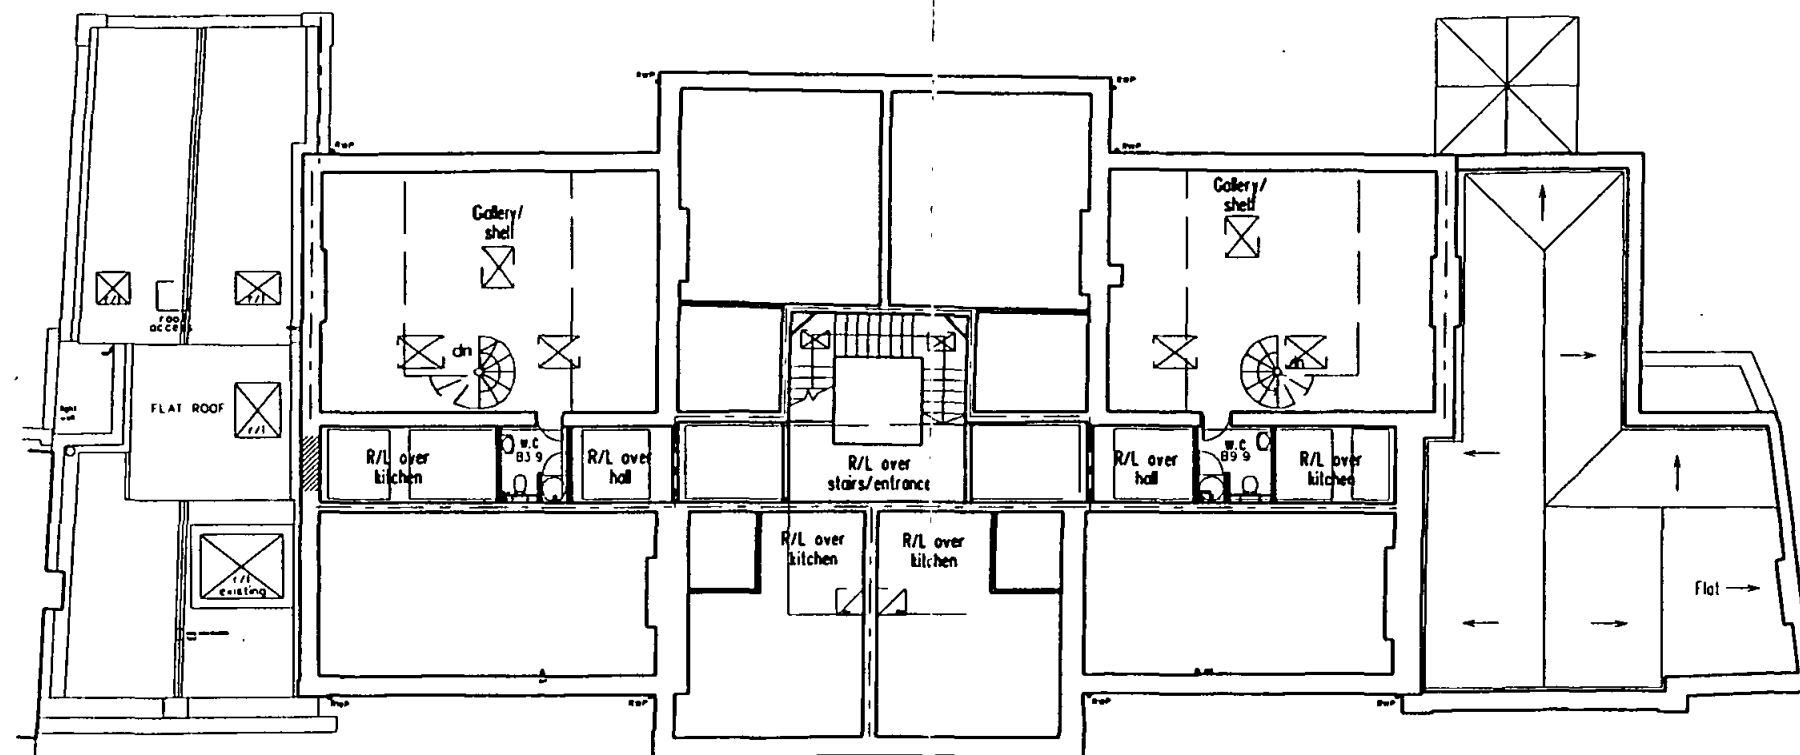


ROOF PLAN 1

Revisions: 1. 08/11/94 JHM ROOF LIGHTS ADDED AND ROOF DUTY LINE PLACED TO BLOCK B 2. 11/01/94 JHM ROOF LIGHTS INDICATED ON ROOF PLAN 1		Job Name: NEW END HOSPITAL BLOCK B		Job Reference: BH.NEH		Code: D	
		Drawing Title: ROOF PLAN 1-2		Drawing number / Revision suffix: AL (0) 28 B		Scale: 1:200 Date: Mar 94	
				Hunt Thompson Associates 73 Parkway, London SW11 7P		Checked: 07-10-93	

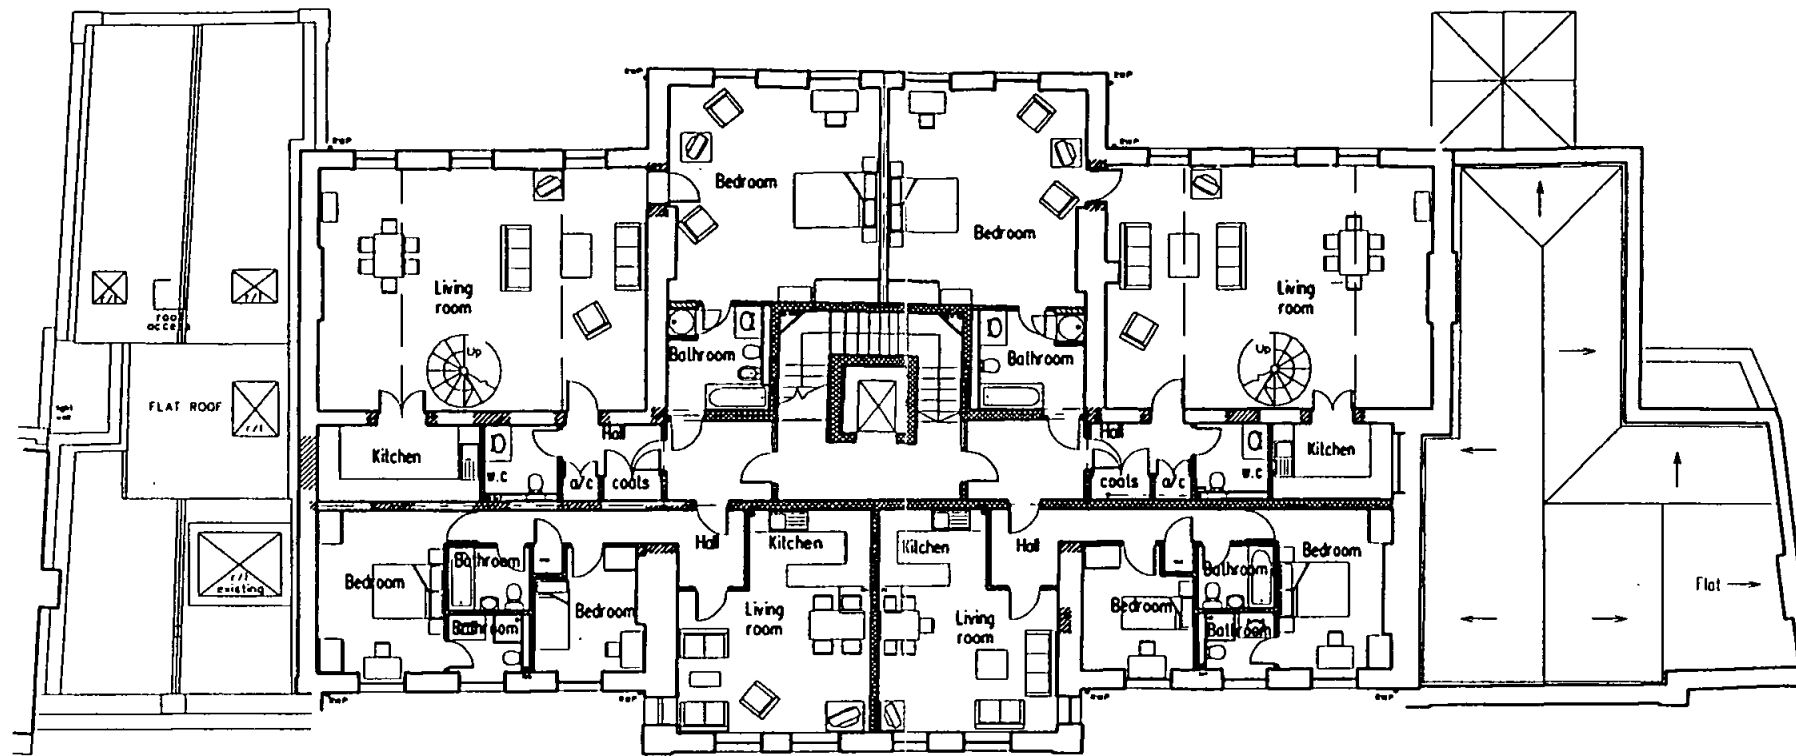

SECOND FLOOR

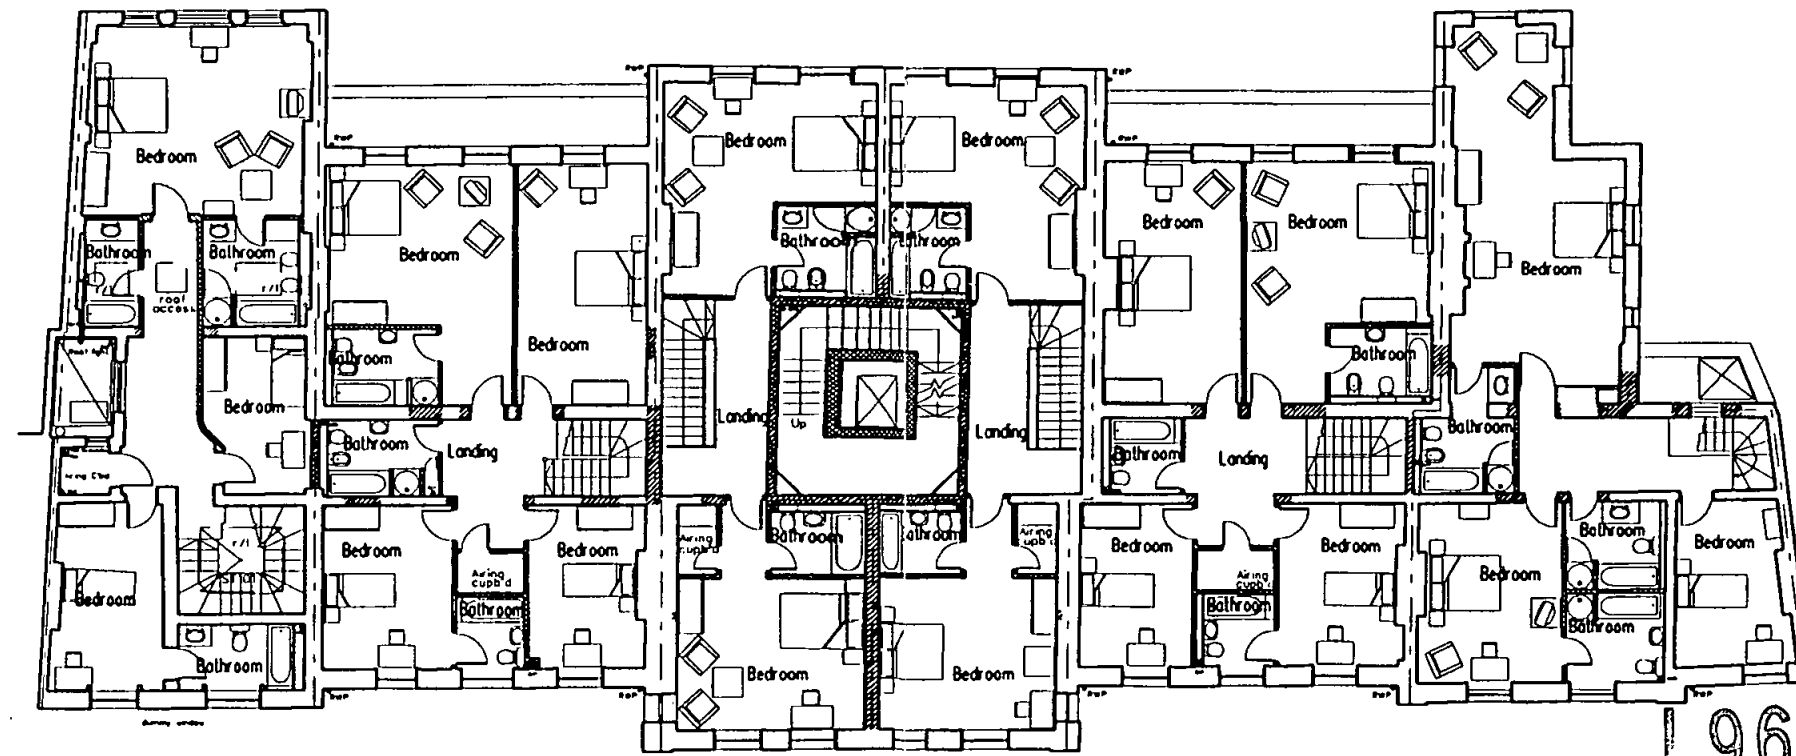


FIRST FLOOR

LONDON BOROUGH OF CAMDEN
TOWN AND COUNCIL PLANNING ACTS
- 6 MAR 1998
PLANS APPROVED
ON BEHALF OF THE COUNCIL

19603256

Revisions: A. 08/7/94 AM B. 18/9/94 AM C. 18/9/94 AM		1ST FLOOR TO FIRST FLOOR, EXISTING STAIRS REMOVED BATHROOMS AND BEDROOMS REVISED STAIRS IN HALLS REVISED FIRST FLOOR BATHROOM LAYOUTS REVISED		Job Name NEW END HOSPITAL BLOCK B		Job Reference BH.NEH		Code D	
				Drawing Title FIRST & SECOND FLOOR PLAN		Drawing number / Revision suffix AL (O) 27 C		Scale / Date / Draw / Checked 1:200 Mar 94	
				Hurl Thompson Associates 78 Parkway, London SW17 7PP		071 485 8555			

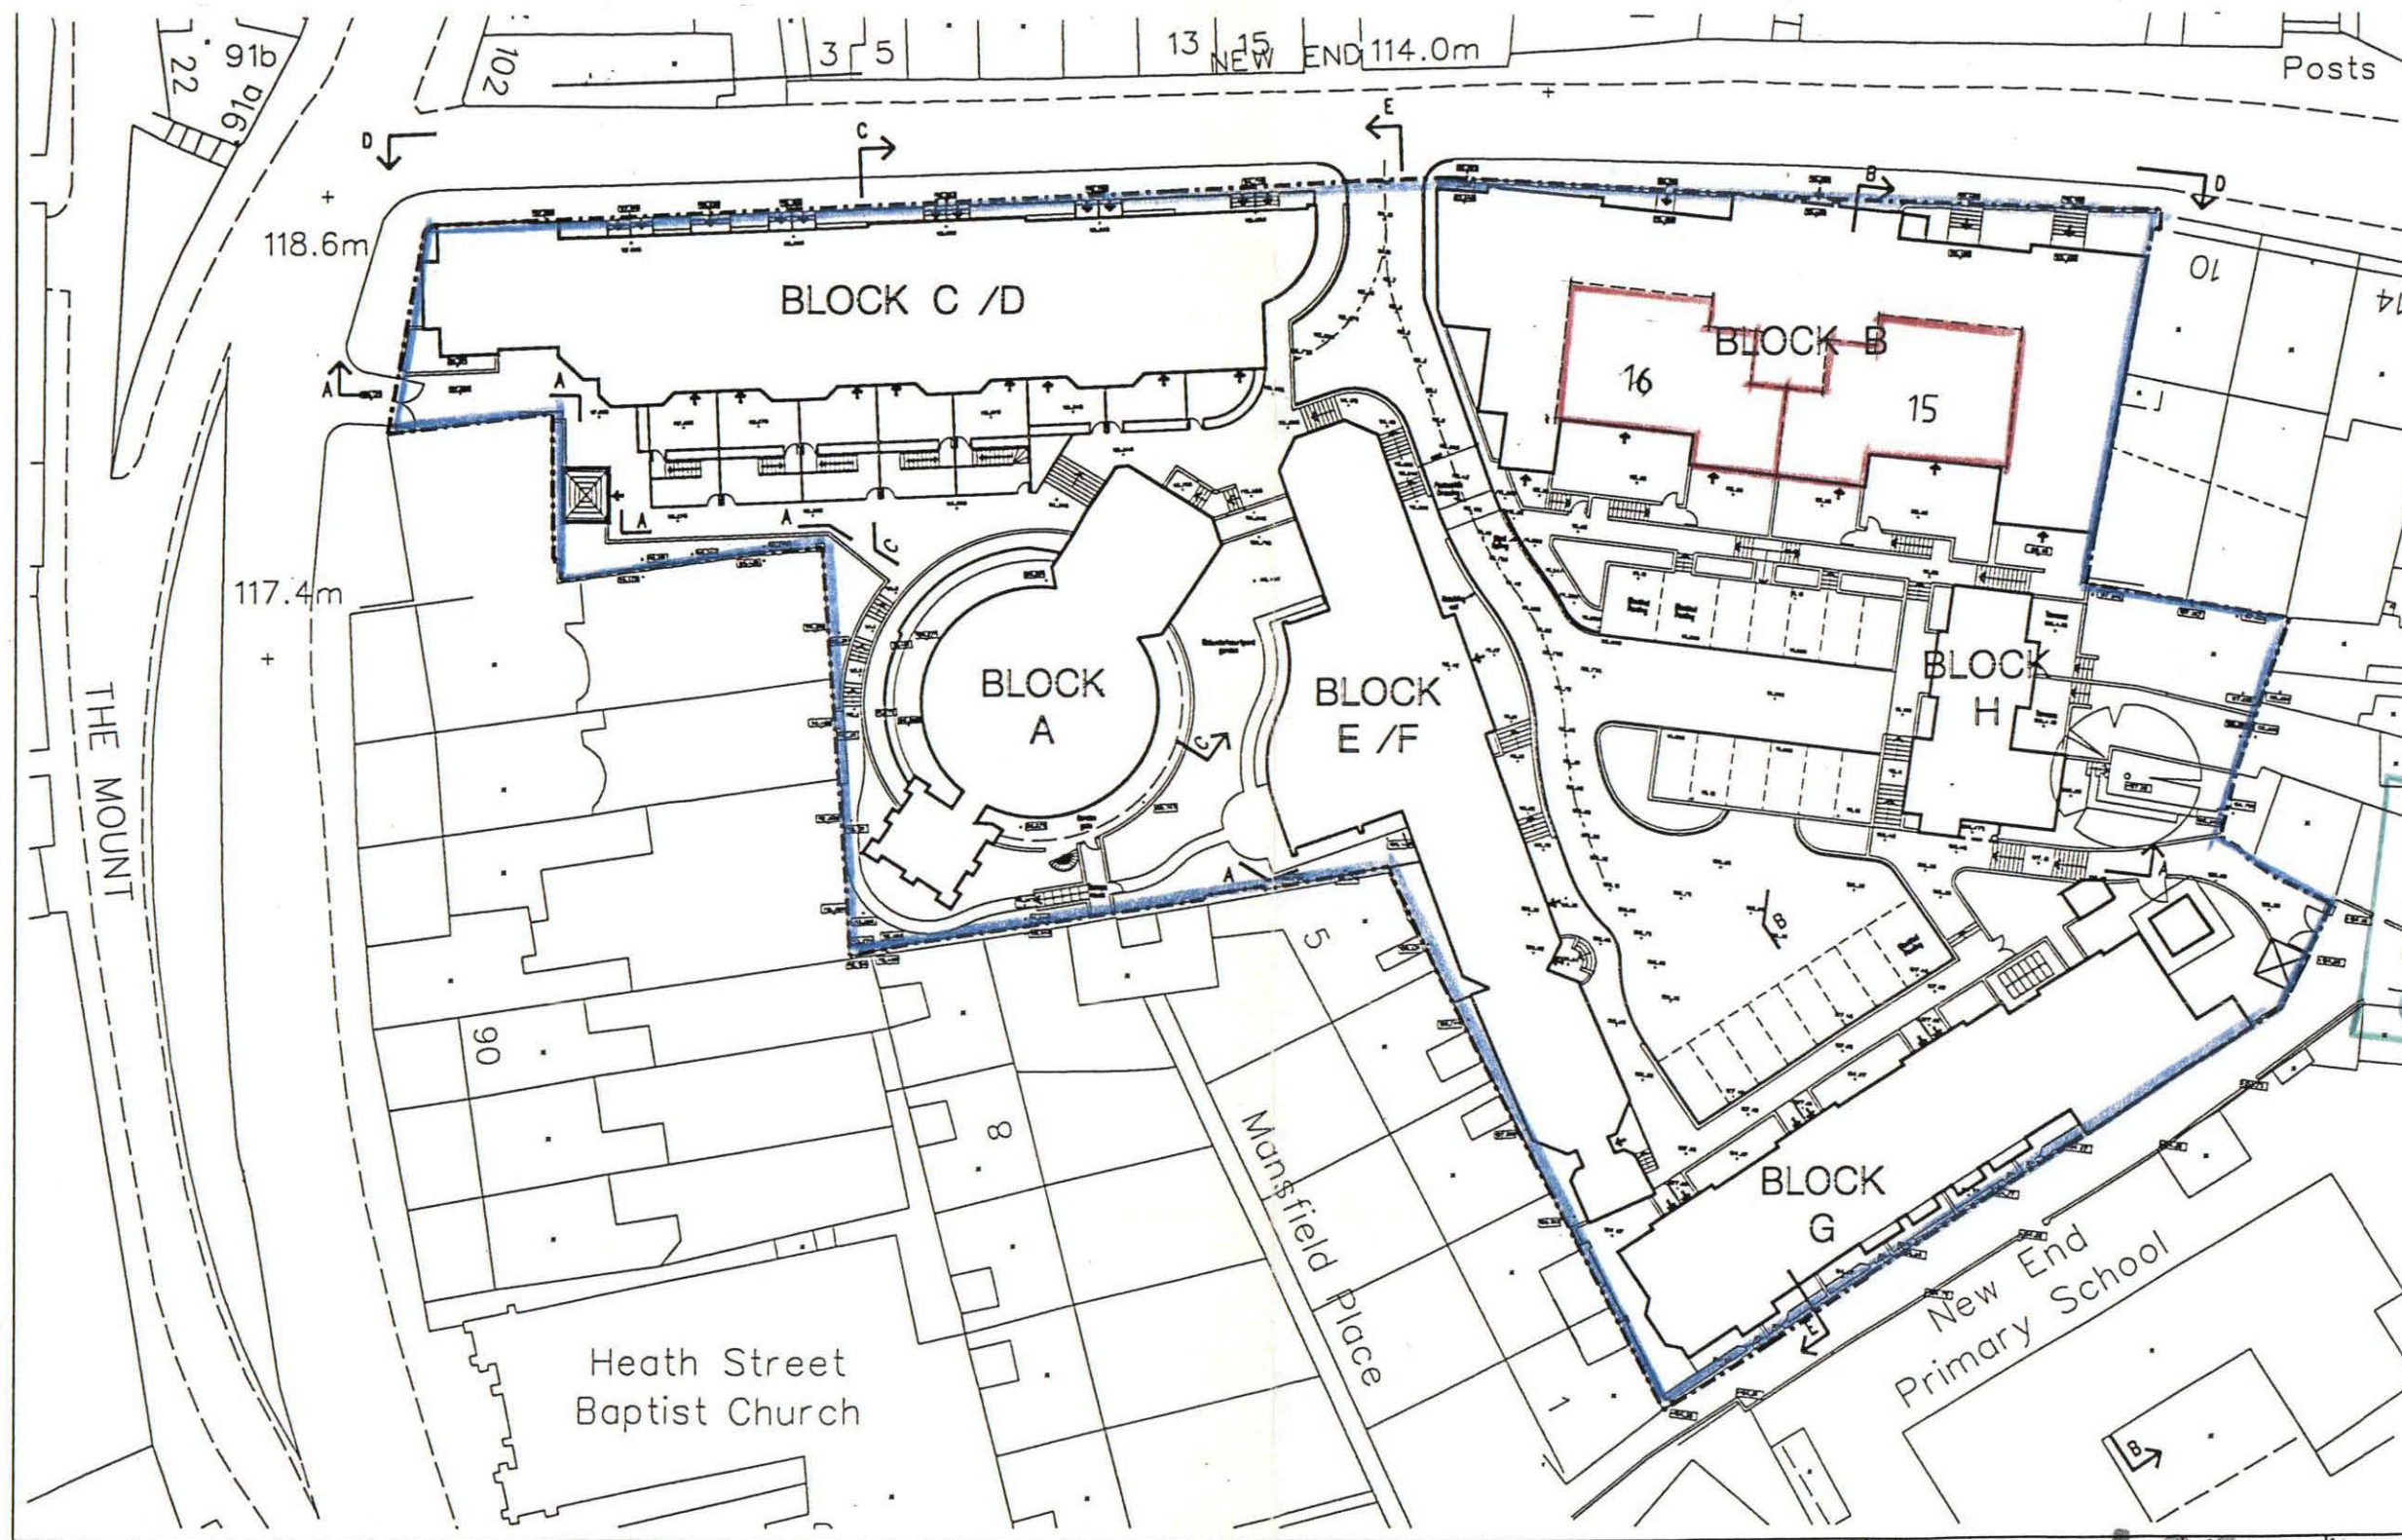

L9603256

77 COWCROSS STREET LONDON EC1M 6BP Tel 0171 251 5135 Fax 0171 251 5136		JT
JOHN THOMPSON & PARTNERS		
Project NEW END HOSPITAL	Job Ref. NEN.	Drawn
Drawing Title LOCATION PLAN.	Scale 1:500	Date JUL 96
	Drawing no. AL(2) 14.	Rev