
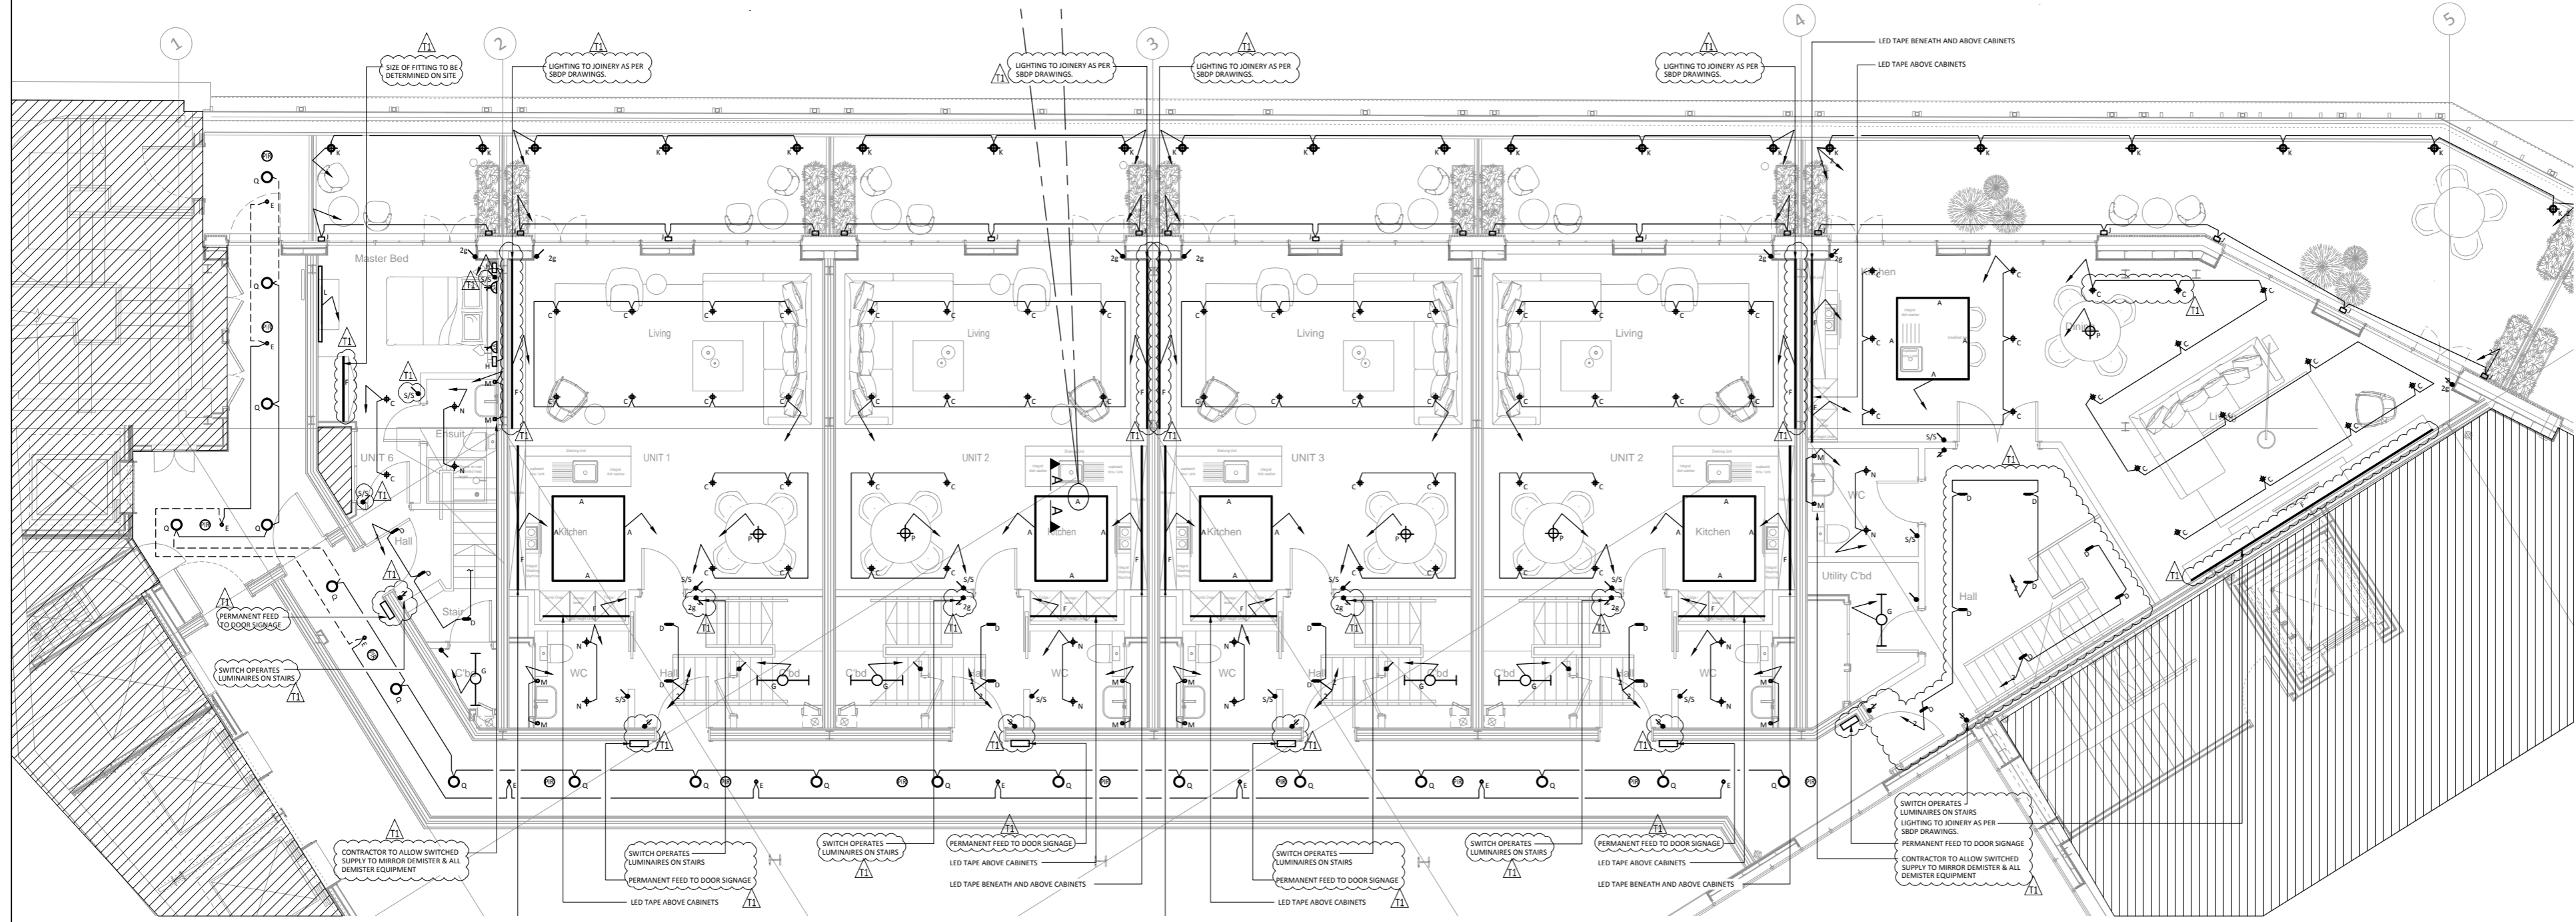


- LEGEND:-**
- A TYPE A - KITCHEN
 - B TYPE B - WARDROBE
 - C TYPE C - LIVING & DINING
 - D TYPE D - CIRCULATION / STAIR FITTING
 - E TYPE E - EMERGENCY LIGHT
 - F TYPE F - UNDER & ABOVE KITCHEN CABINETS
 - G TYPE G - SURFACE MOUNTED FITTING TBA
 - H TYPE H - BEDROOM WALL LIGHT
 - I TYPE I - BATHROOM WALL LIGHT TBA
 - J TYPE J - EXTERNAL WALL LIGHT
 - K TYPE K - EXTERNAL RECESSED
 - L TYPE L - BEDROOM LIGHTING
 - M TYPE M - BATHROOM MIRROR LIGHTS
 - N TYPE N - BATHROOM
 - O TYPE O - NOT USED
 - P TYPE P - PENDANT
 - Q TYPE Q - CORRIDOR
 - ONE WAY SWITCH
 - TWO WAY SWITCH
 - DIMMER SWITCH
 - INTERMEDIATE SWITCH
 - FAN ISOLATOR SWITCH
 - PULL CORD
 - PRESENCE-CONTROL-PIR.
 - SHAVER SOCKET
 - 5 AMP SOCKET
 - SMOKE DETECTOR
 - HEAT DETECTOR
 - SMOKE DETECTOR WITH SOUNDER BASE
 - FAI FIRE ALARM INTERFACE
 - 'xg' DENOTES NUMBER OF GANG SWITCH
 - 'E' DENOTES EMERGENCY
 - 'K' DENOTES KEY SWITCH
 - 'EX' DENOTES EXISTING

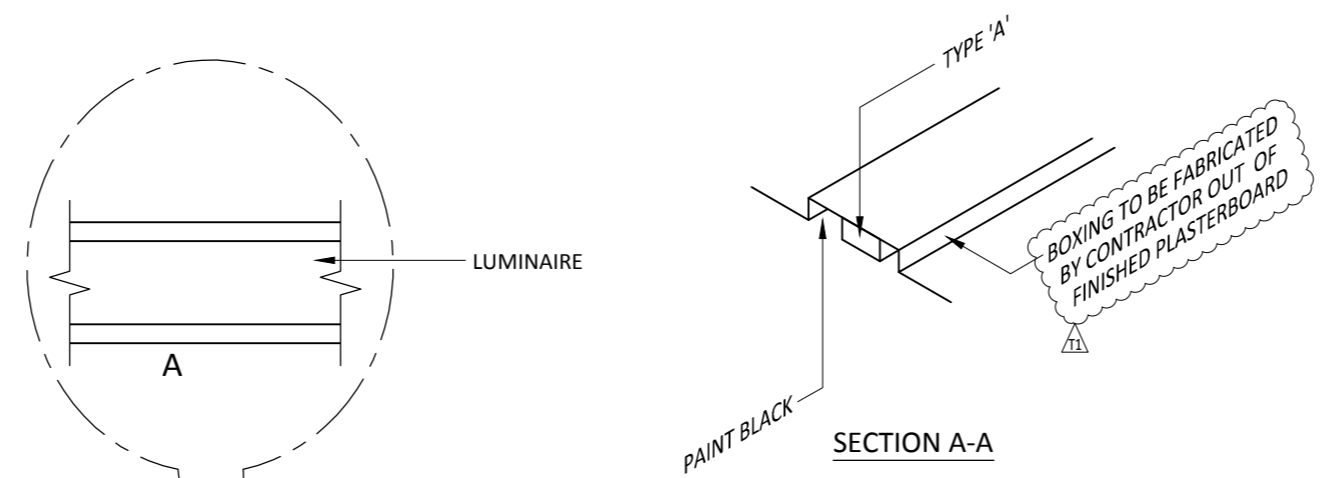

- NOTES:-**
1. THIS DRAWING MUST NOT BE USED FOR CONSTRUCTION OR INSTALLATION PURPOSES UNLESS EXPRESSLY STATED.
 2. DO NOT SCALE OFF THIS DRAWING. ALWAYS WORK TO NOTED DIMENSIONS.
 3. ALL DIMENSIONS MUST BE VERIFIED ON SITE BEFORE COMPLETING SHOP DRAWINGS OR SETTING OUT ON SITE.
 4. THIS DRAWING IS TO BE READ IN CONJUNCTION WITH THE TECHNICAL SPECIFICATION AND ASSOCIATED EQUIPMENT SCHEDULES AS PREPARED BY GPDE.
 5. THIS DRAWING IS TO BE READ IN CONJUNCTION WITH ALL ARCHITECTURAL AND STRUCTURAL ENGINEER'S DRAWINGS AND ASSOCIATED GPDE DRAWINGS.
 6. NO WORKS TO HATCHED AREA.

REFERENCE DRAWINGS			
SL NO.	TITLE	DRAWING NO.	REV

T1	TENDER ADDENDUM	TK	CS	09.02.2018
T	TENDER	TK	CS	31.01.2018
P	PRELIMINARY	TK	CS	12.01.2018
REV	PURPOSE OF ISSUE	BY	APP	DATE

GreenPlanet
design engineers
t:020 33014469 w: www.gpde.co.uk

CLIENT
AERIUM FINANCE LIMITED

PROJECT
Herbal House

DRG. TITLE
LEVEL 5 LIGHTING LAYOUT

DRG. NO.	SCALE	REV.
E35017-LT-5-100	1:100@A2	T1

CONTRACTOR TO MAKE ALLOWANCE TO PROVIDE LIGHTING TO NICHE SHELVES WITHIN BATHROOM & EN-SUITES IN ACCORDANCE WITH SBDP INTERIOR DESIGN DRAWINGS.