
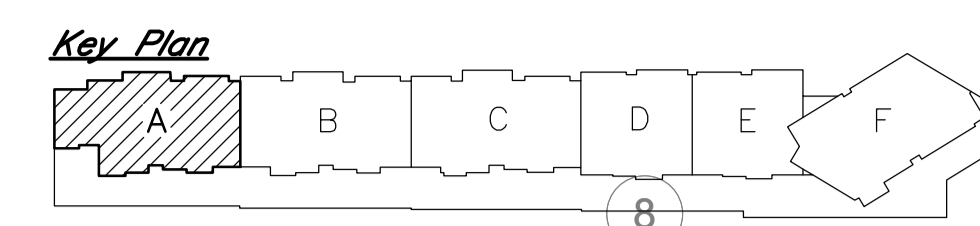


| | |
|--|------------------------|
| COMPANY OF ORIGIN | ARCHITECTS DRAWING No. |
| Pollard Thomas Edwards | 029_L(00)_A_100 |
| ORIGINAL FILE NAME | 029_L(00)_A_100_F |
| ORIGINAL DRAWING TITLE | REV. DATE RECEIVED |
| General Arrangement Plan Block A - Level 0 | F 14-06-17 |

| | |
|-------------------------------------|------------------------|
| COMPANY OF ORIGIN | ARCHITECTS DRAWING No. |
| Pollard Thomas Edwards | 029_L(00)_400 |
| ORIGINAL FILE NAME | 029_L(00)_400 |
| ORIGINAL DRAWING TITLE | REV. DATE RECEIVED |
| Unit Plans -Type A1 Level 0 Block A | A 31-01-17 |

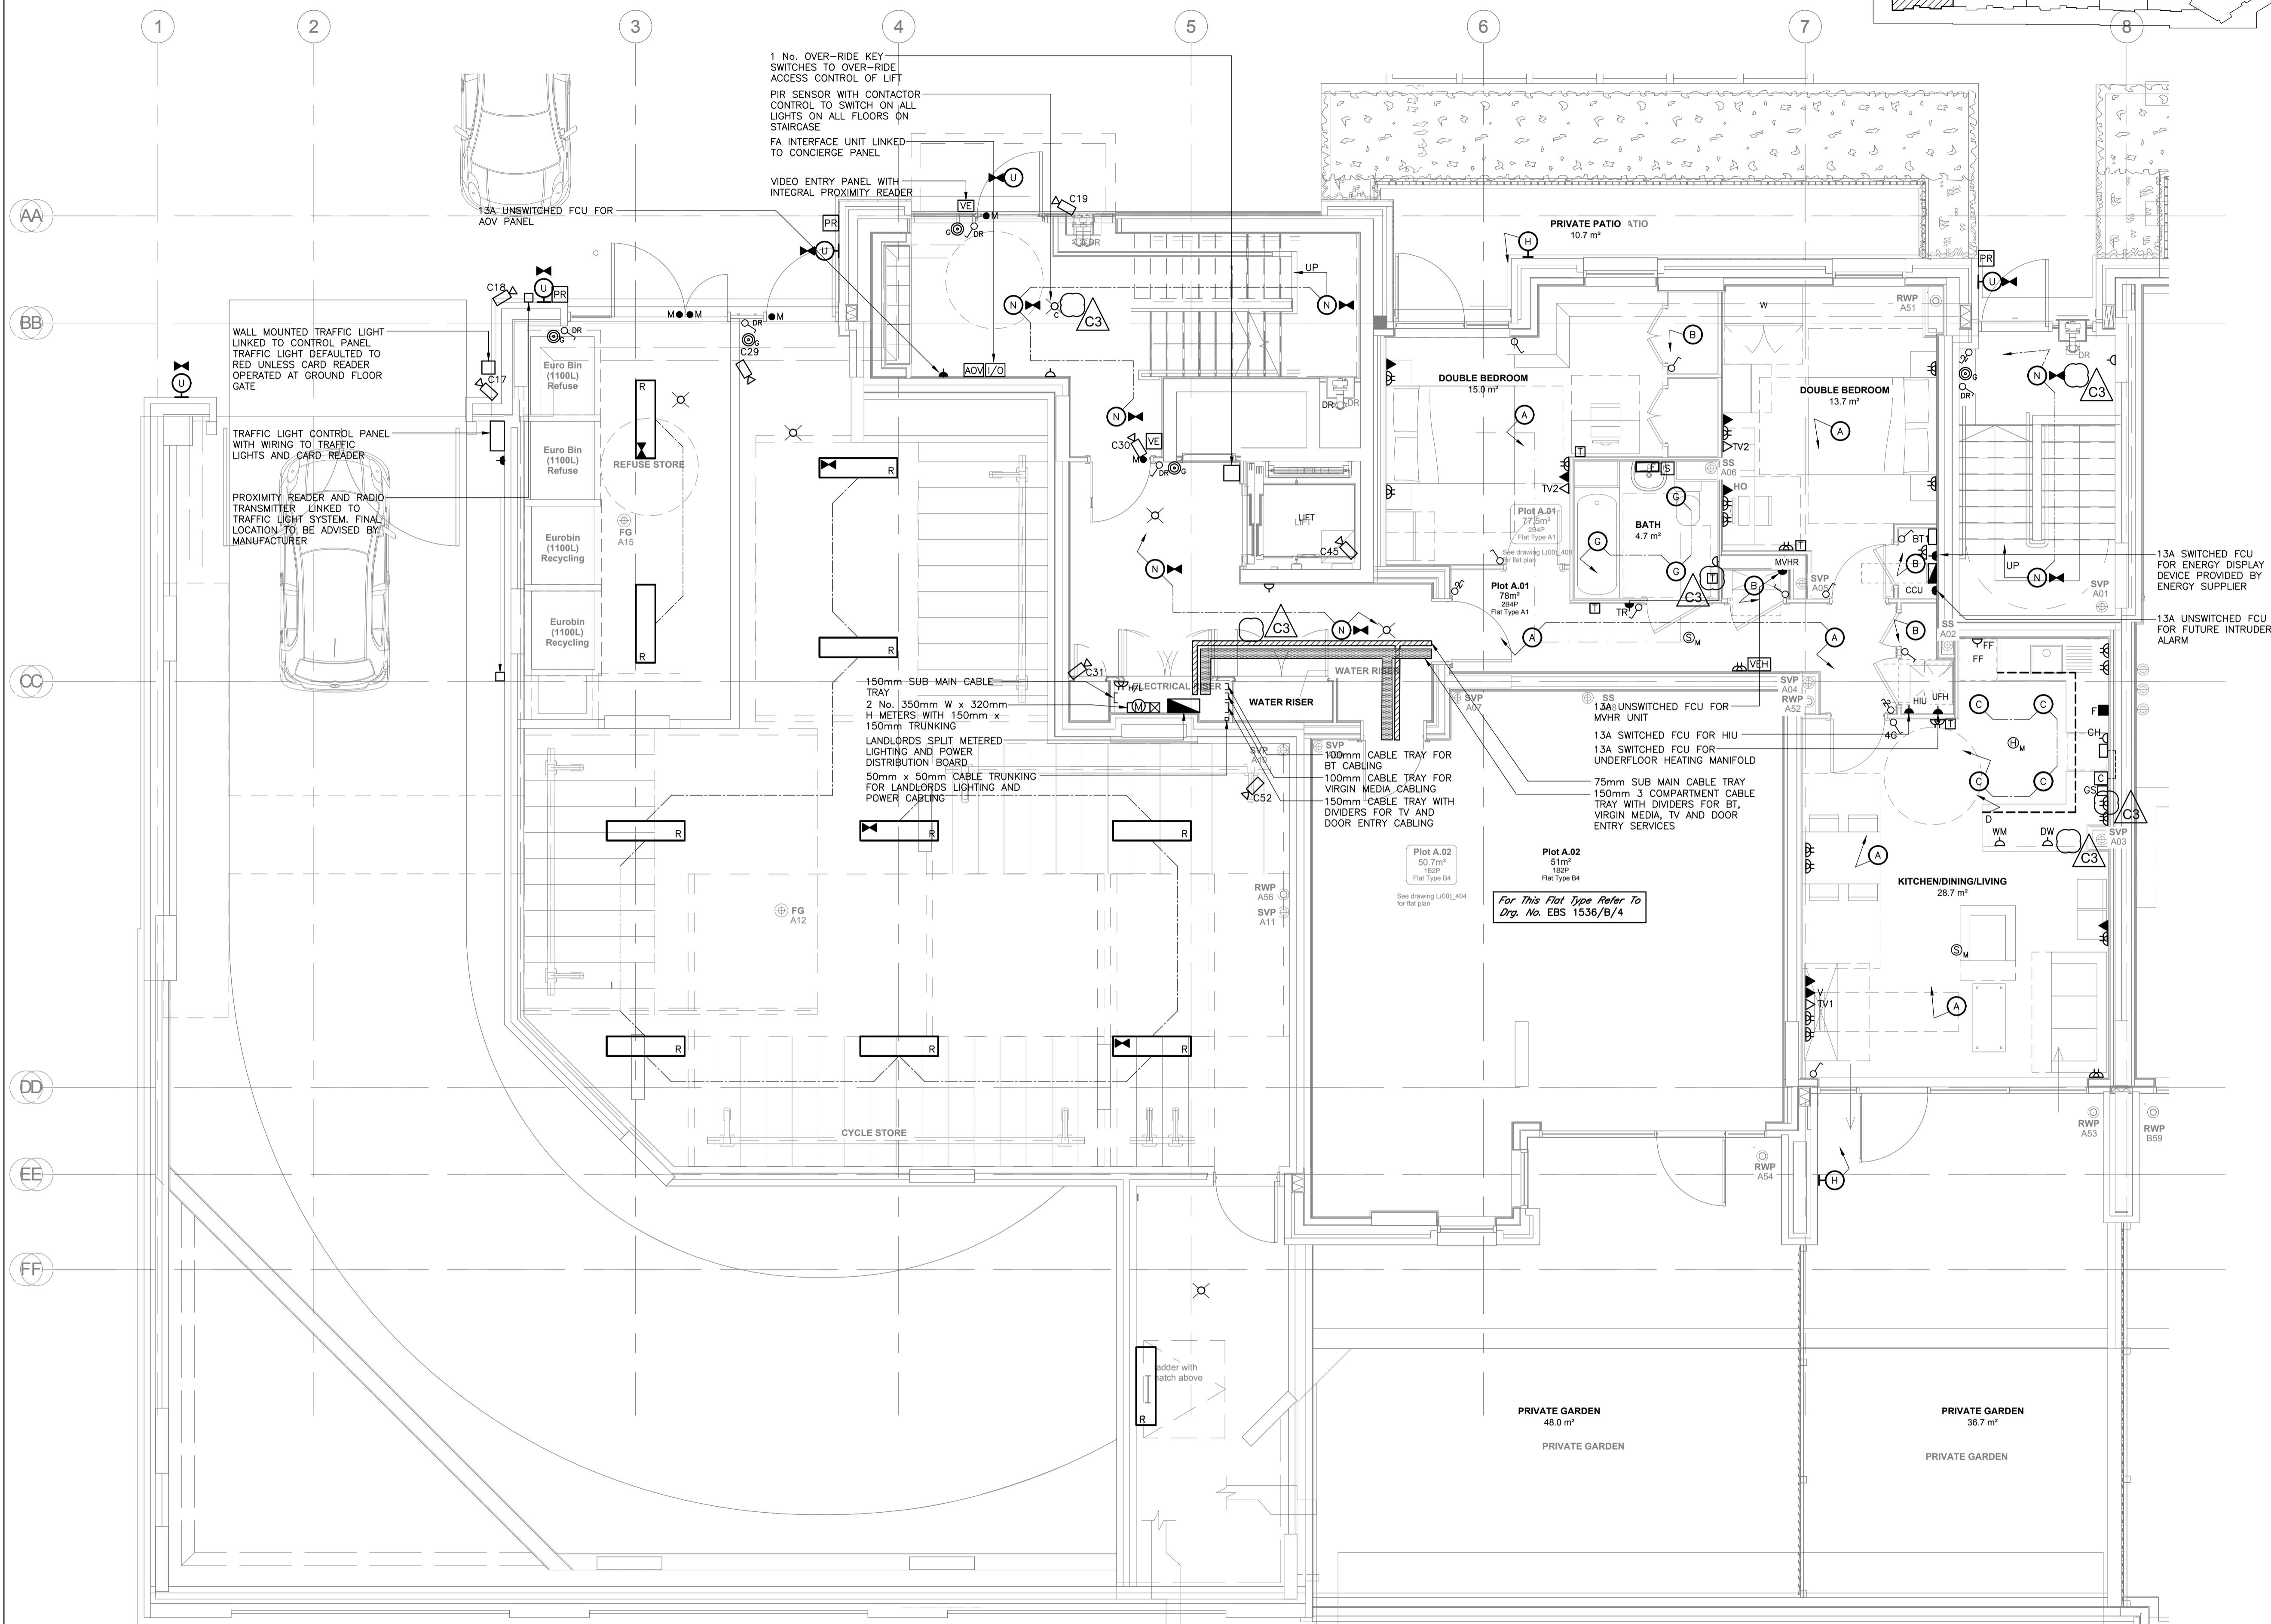

- NOTES**
1. ALL DIMENSIONS ARE IN MILLIMETRES UNLESS OTHERWISE INDICATED.
 2. THIS DRAWING SHALL BE READ IN CONJUNCTION WITH THE SPECIFICATION AND ALL OTHER DRAWINGS.

| | | | | |
|------|----------|--|-----|----|
| C3 | 03.10.17 | REVISED AS CLOUDED | PK | MD |
| C2 | 26.06.17 | REVISED TO SUIT LATEST ARCHITECTS LAYOUT | PK | MD |
| C1 | 31.03.17 | CONSTRUCTION ISSUE | LT | MD |
| Date | Revision | Dwn | Chk | |

Norman Bromley Partnership LLP
 consulting engineers
 Bridge House,
 97-101 High Street,
 Tonbridge,
 Kent. TN11 1DR

Tel. No. (01732) 773737 Fax No. (01732) 773353
 Email: mail@normanbromley.co.uk

Client
WATES LIVING SPACES

Project
ABBAY ROAD

Service
 Electrical Engineering

Title
**BLOCK A LEVEL 0
 GROUND FLOOR PLAN
 FLAT TYPE A1
 ELECTRICAL SERVICES LAYOUT**

| | | | |
|--------------|--------|-------|----------|
| Scale | Date | Drawn | Approved |
| 1:50@A1 | NOV'16 | WB | MD |
| DRAWING No. | REV. | | |
| EBS 1536-A/2 | C3 | | |

CONSTRUCTION