



COMPANY OF ORIGIN	ARCHITECTS DRAWING No.
Pollard Thomas Edwards	029_L(00)_403
ORIGINAL FILE NAME	029_L(00)_403
ORIGINAL DRAWING TITLE	REV. DATE RECEIVED
Unit Plans -Types B1 & B2 Level 0 Block B	B 31-01-17

Key Plan

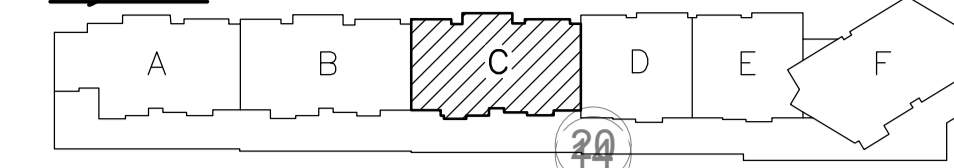

NOTES

- ALL DIMENSIONS ARE IN MILLIMETRES UNLESS OTHERWISE INDICATED.
- THIS DRAWING SHALL BE READ IN CONJUNCTION WITH THE SPECIFICATION AND ALL OTHER DRAWINGS.

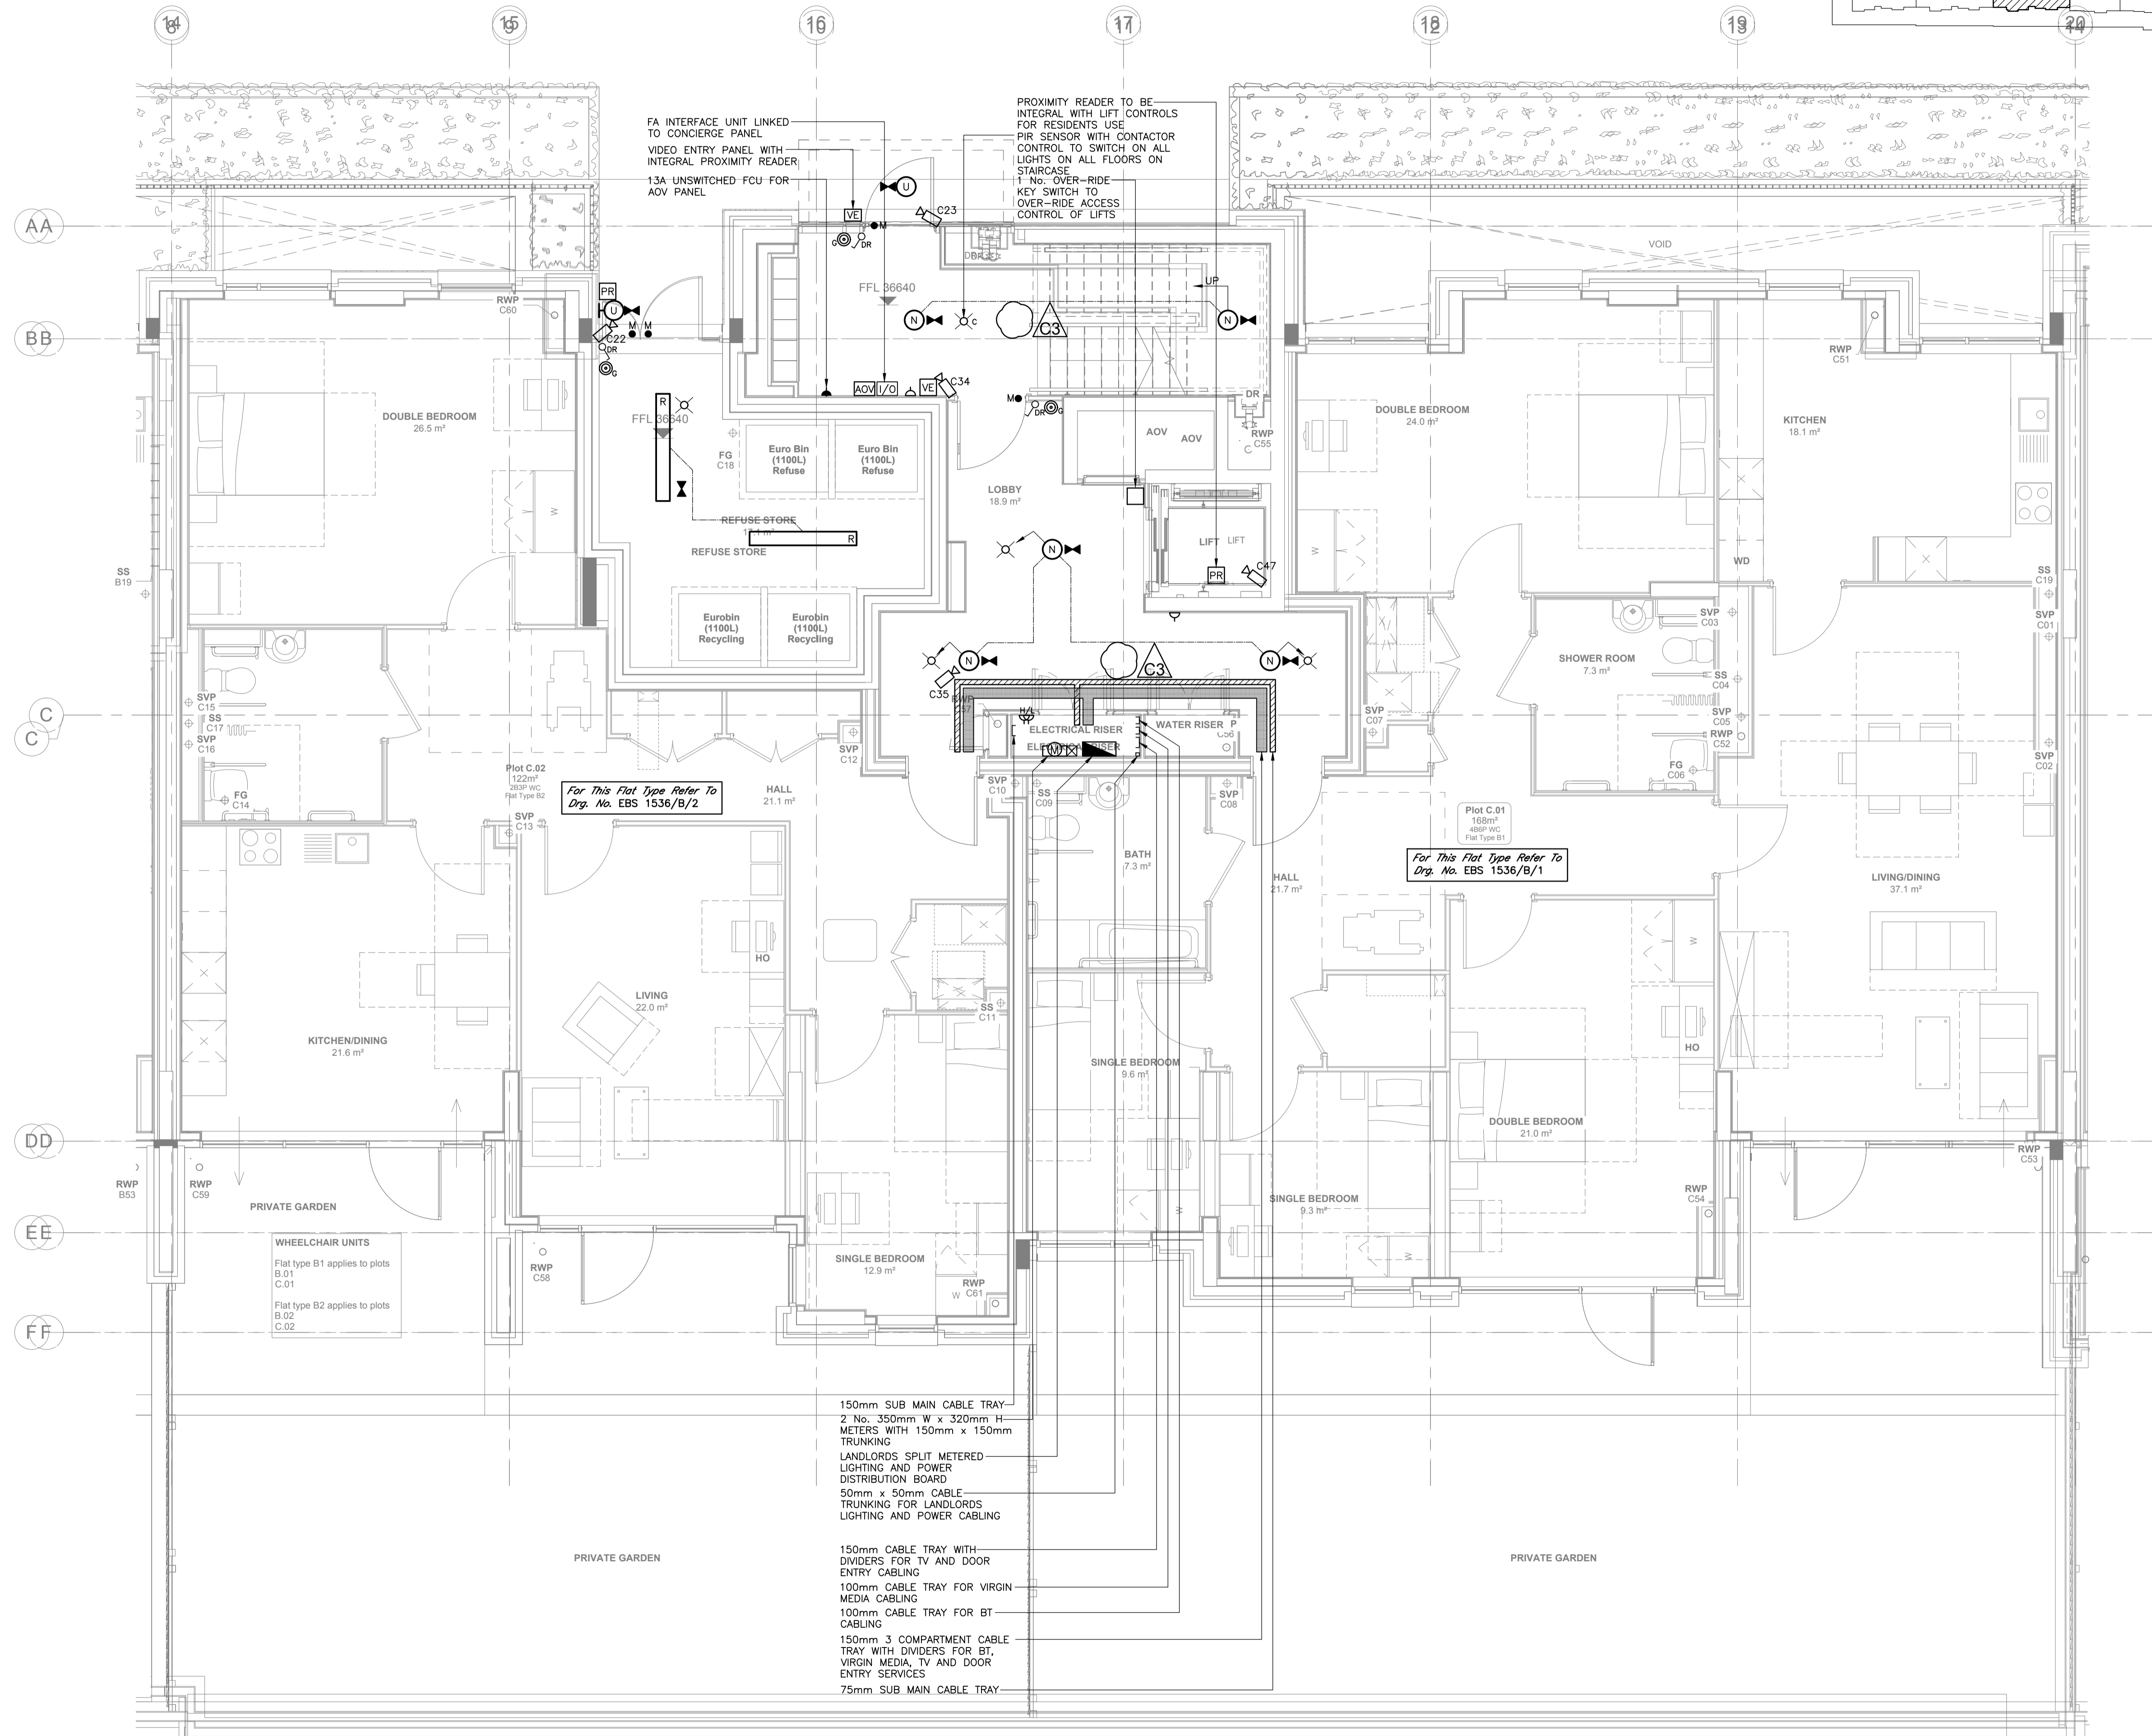

For This Flat Type Refer To
Drg. No. EBS 1536/B/2

For This Flat Type Refer To
Drg. No. EBS 1536/B/1

150mm SUB MAIN CABLE TRAY
2 No. 350mm W x 320mm H
METERS WITH 150mm x 150mm
TRUNKING
LANDLORDS SPLIT METERED
LIGHTING AND POWER
DISTRIBUTION BOARD
50mm x 50mm CABLE
TRUNKING FOR LANDLORDS
LIGHTING AND POWER CABLING

150mm CABLE TRAY WITH
DIVIDERS FOR TV AND DOOR
ENTRY CABLING
100mm CABLE TRAY FOR VIRGIN
MEDIA CABLING
100mm CABLE TRAY FOR BT
CABLING
150mm 3 COMPARTMENT CABLE
TRAY WITH DIVIDERS FOR BT,
VIRGIN MEDIA, TV AND DOOR
ENTRY SERVICES
75mm SUB MAIN CABLE TRAY

WHEELCHAIR UNITS
Flat type B1 applies to plots
B.01
C.01
Flat type B2 applies to plots
B.02
C.02

CONSTRUCTION

C3	03.10.17	REVISED AS CLOUDED	PK	MD
C2	14.06.17	REVISED AS CLOUDED	PK	MD
C1	31.03.17	CONSTRUCTION ISSUE	LT	MD
Date	Revision	Dwn	Chk	

Norman Bromley Partnership LLP
consulting engineers
Bridge House,
97-101 High Street,
Tonbridge,
Kent. TN9 1DR

Tel. No. (01732) 773737 Fax No. (01732) 773353
Email: mail@normanbromley.co.uk

Client	WATES LIVING SPACES		
Project	ABBEY ROAD		
Service	Electrical Engineering		
Title	BLOCK C LEVEL 0 GROUND FLOOR PLAN ELECTRICAL SERVICES LAYOUT		
Scale	Date	Drawn	Approved
1:50@A1	NOV/16	JP	MD
DRAWING No.	REV.		
EBS 1536-C/2	C3		