
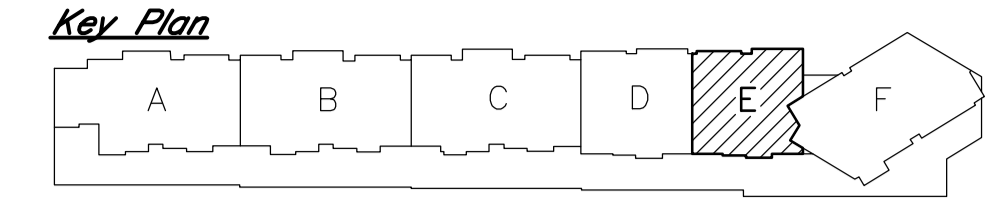


COMPANY OF ORIGIN	ARCHITECTS DRAWING No.
Pollard Thomas Edwards	029_L(00)_E_100_H
ORIGINAL FILE NAME	029_L(00)_E_100_H
ORIGINAL DRAWING TITLE	REV. DATE RECEIVED
General Arrangement Plan Block E - Level 0	H 14-06-17

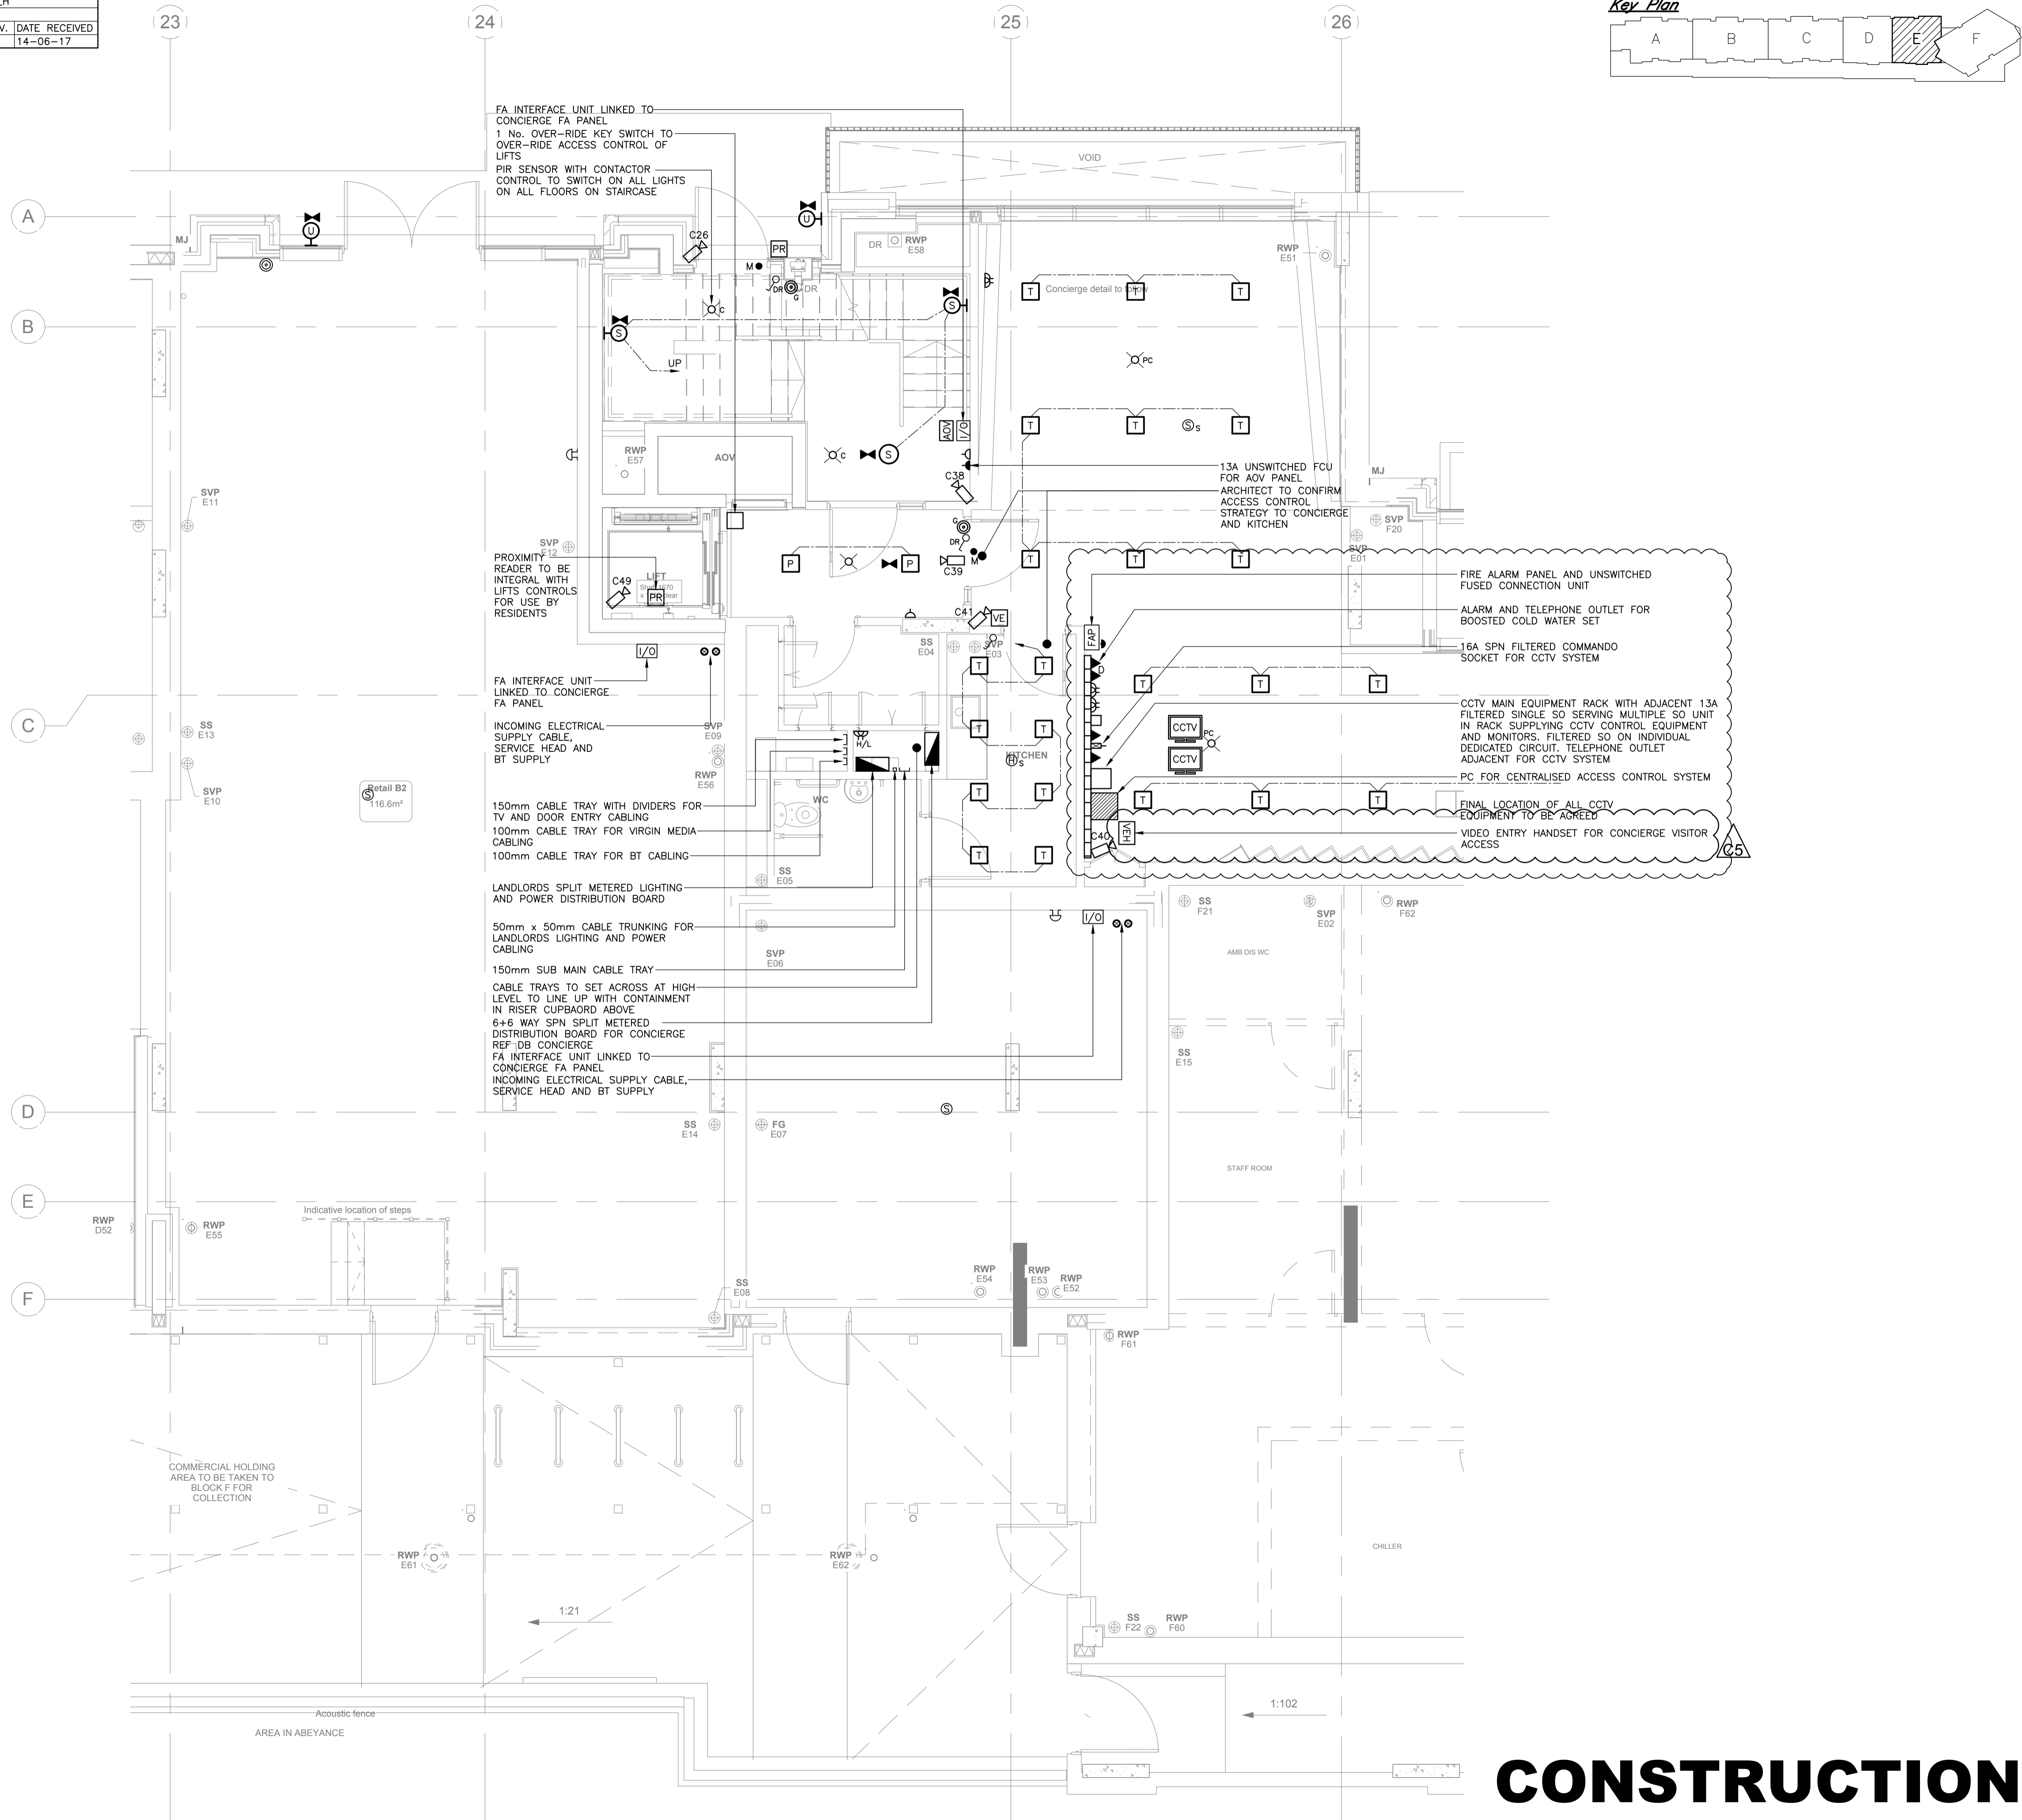

NOTES


- ALL DIMENSIONS ARE IN MILLIMETRES UNLESS OTHERWISE INDICATED.
- THIS DRAWING SHALL BE READ IN CONJUNCTION WITH THE SPECIFICATION AND ALL OTHER DRAWINGS.

C5	15.12.17	REVISED AS CLOUDED	PK	MD
C4	03.10.17	REVISED AS CLOUDED	PK	MD
C3	14.06.17	REVISED TO SUIT LATEST ARCHITECTS LAYOUT AND AS CLOUDED	PK	MD
C2	04.04.17	FIRE ALARM ADDED TO RETAIL UNIT	PK	MD
C1	31.03.17	CONSTRUCTION ISSUE	LT	MD

Date	Revision	Dwn	Chk
------	----------	-----	-----

Norman Bromley Partnership LLP
 consulting engineers
 Bridge House,
 97-101 High Street,
 Tonbridge,
 Kent. TN9 1DR

Tel. No. (01732) 773737 Fax No. (01732) 773353
 Email: mail@normanbromley.co.uk

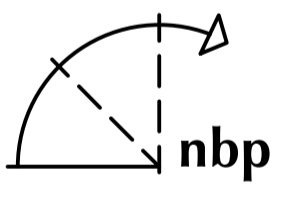

Client
WATES LIVING SPACES

Project
ABBEY ROAD

Service
 Electrical Engineering

Title
**BLOCK E LEVEL 0
 GROUND FLOOR PLAN
 ELECTRICAL SERVICES LAYOUT**

Scale	Date	Drawn	Approved
1:500/41	NOV/16	JP	MD
DRAWING No.	REV.		
EBS 1536-E/2	C5		

CONSTRUCTION