



2 PROPOSED LOCATIONS PLAN

1:100

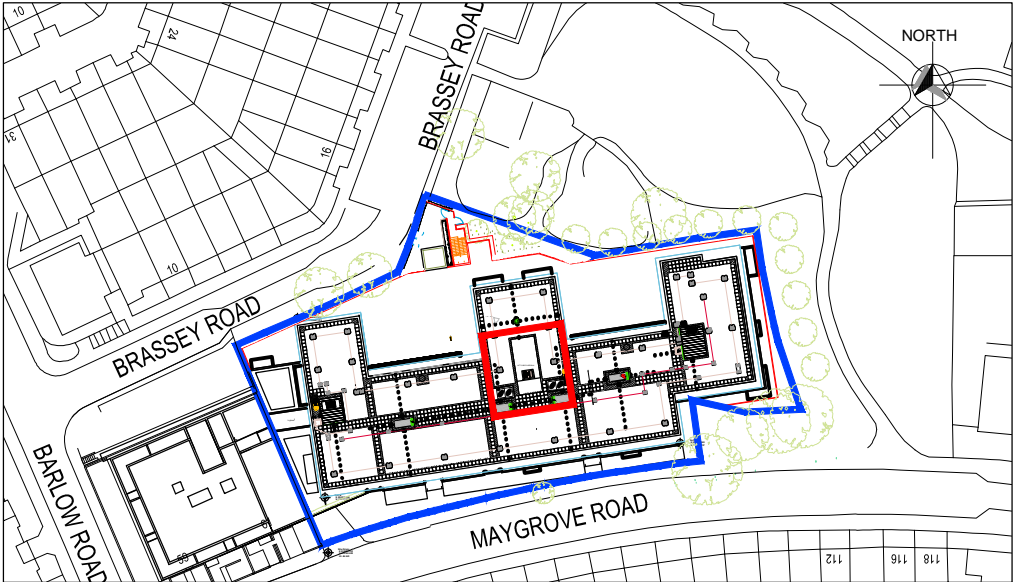

1 SITE LOCATION PLAN

1:1250

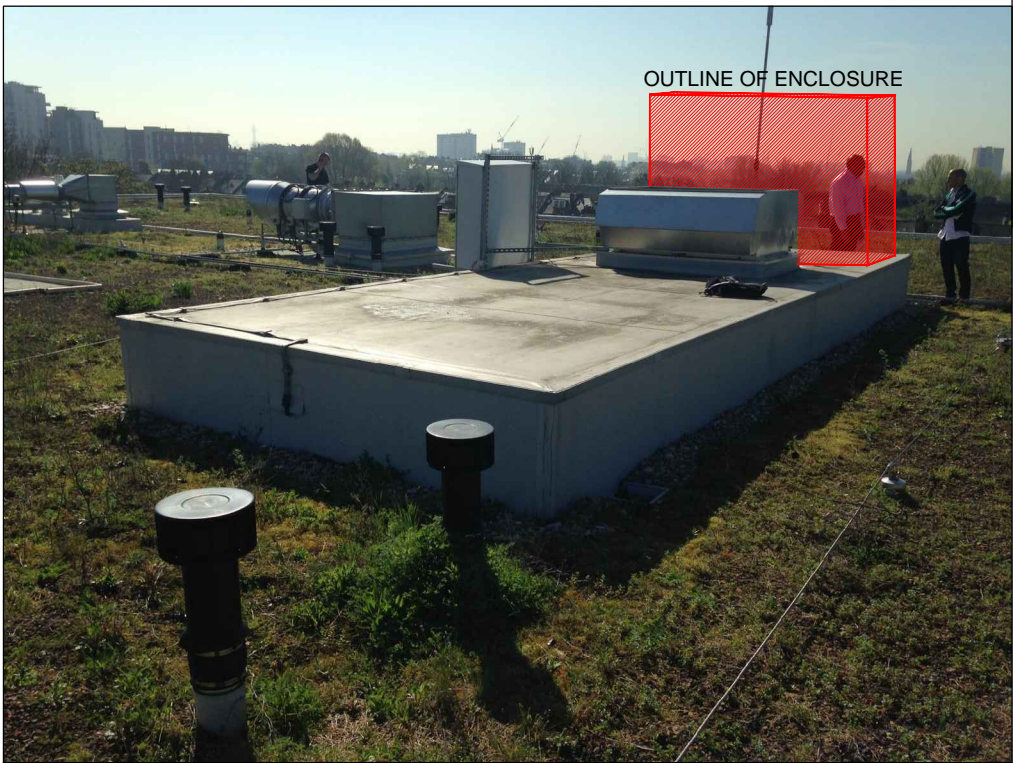

3 PROPOSED LOCATION OF GENERATOR ENCLOSURE

REVISION NOTES

P1	20.04.17	CT	PLANNING ISSUE
P2	09.05.17	CT	GENERATOR AND ENCLOSURE UPDATED
P3	14.05.17	CT	ENCLOSURE INFORMATION UPDATED



KDS ASSOCIATES LTD
DESIGN • ARCHITECTURE • MANAGEMENT • CONSULTANTS
101 The Quadrant, London E1 1BB
Tel: 020 7551 7551 Fax: 020 7551 7552
www.kdsassociates.co.uk

PLANNING

© KDS & Associates Ltd
No part of this drawing may be reproduced without written consent.
All contractors must visit site and be responsible for taking and checking all dimensions relating to this work.
Do not scale from this drawing.

PROJECT / DRAWING TITLE 65-67 MAYGROVE ROAD LONDON NW6 2EH		
DRAWING TITLE ROOF PLAN PROPOSED GENERATOR LOCATIONS		
DATE / DRAWN BY 20.04.17 CT	SCALE 1:100/1250 @ A3	
PROJECT NO 3620	DRAWING NO LO(03)203	REV P3