


Photovoltaic Panel Layout on Bloomsbury Theater Roof

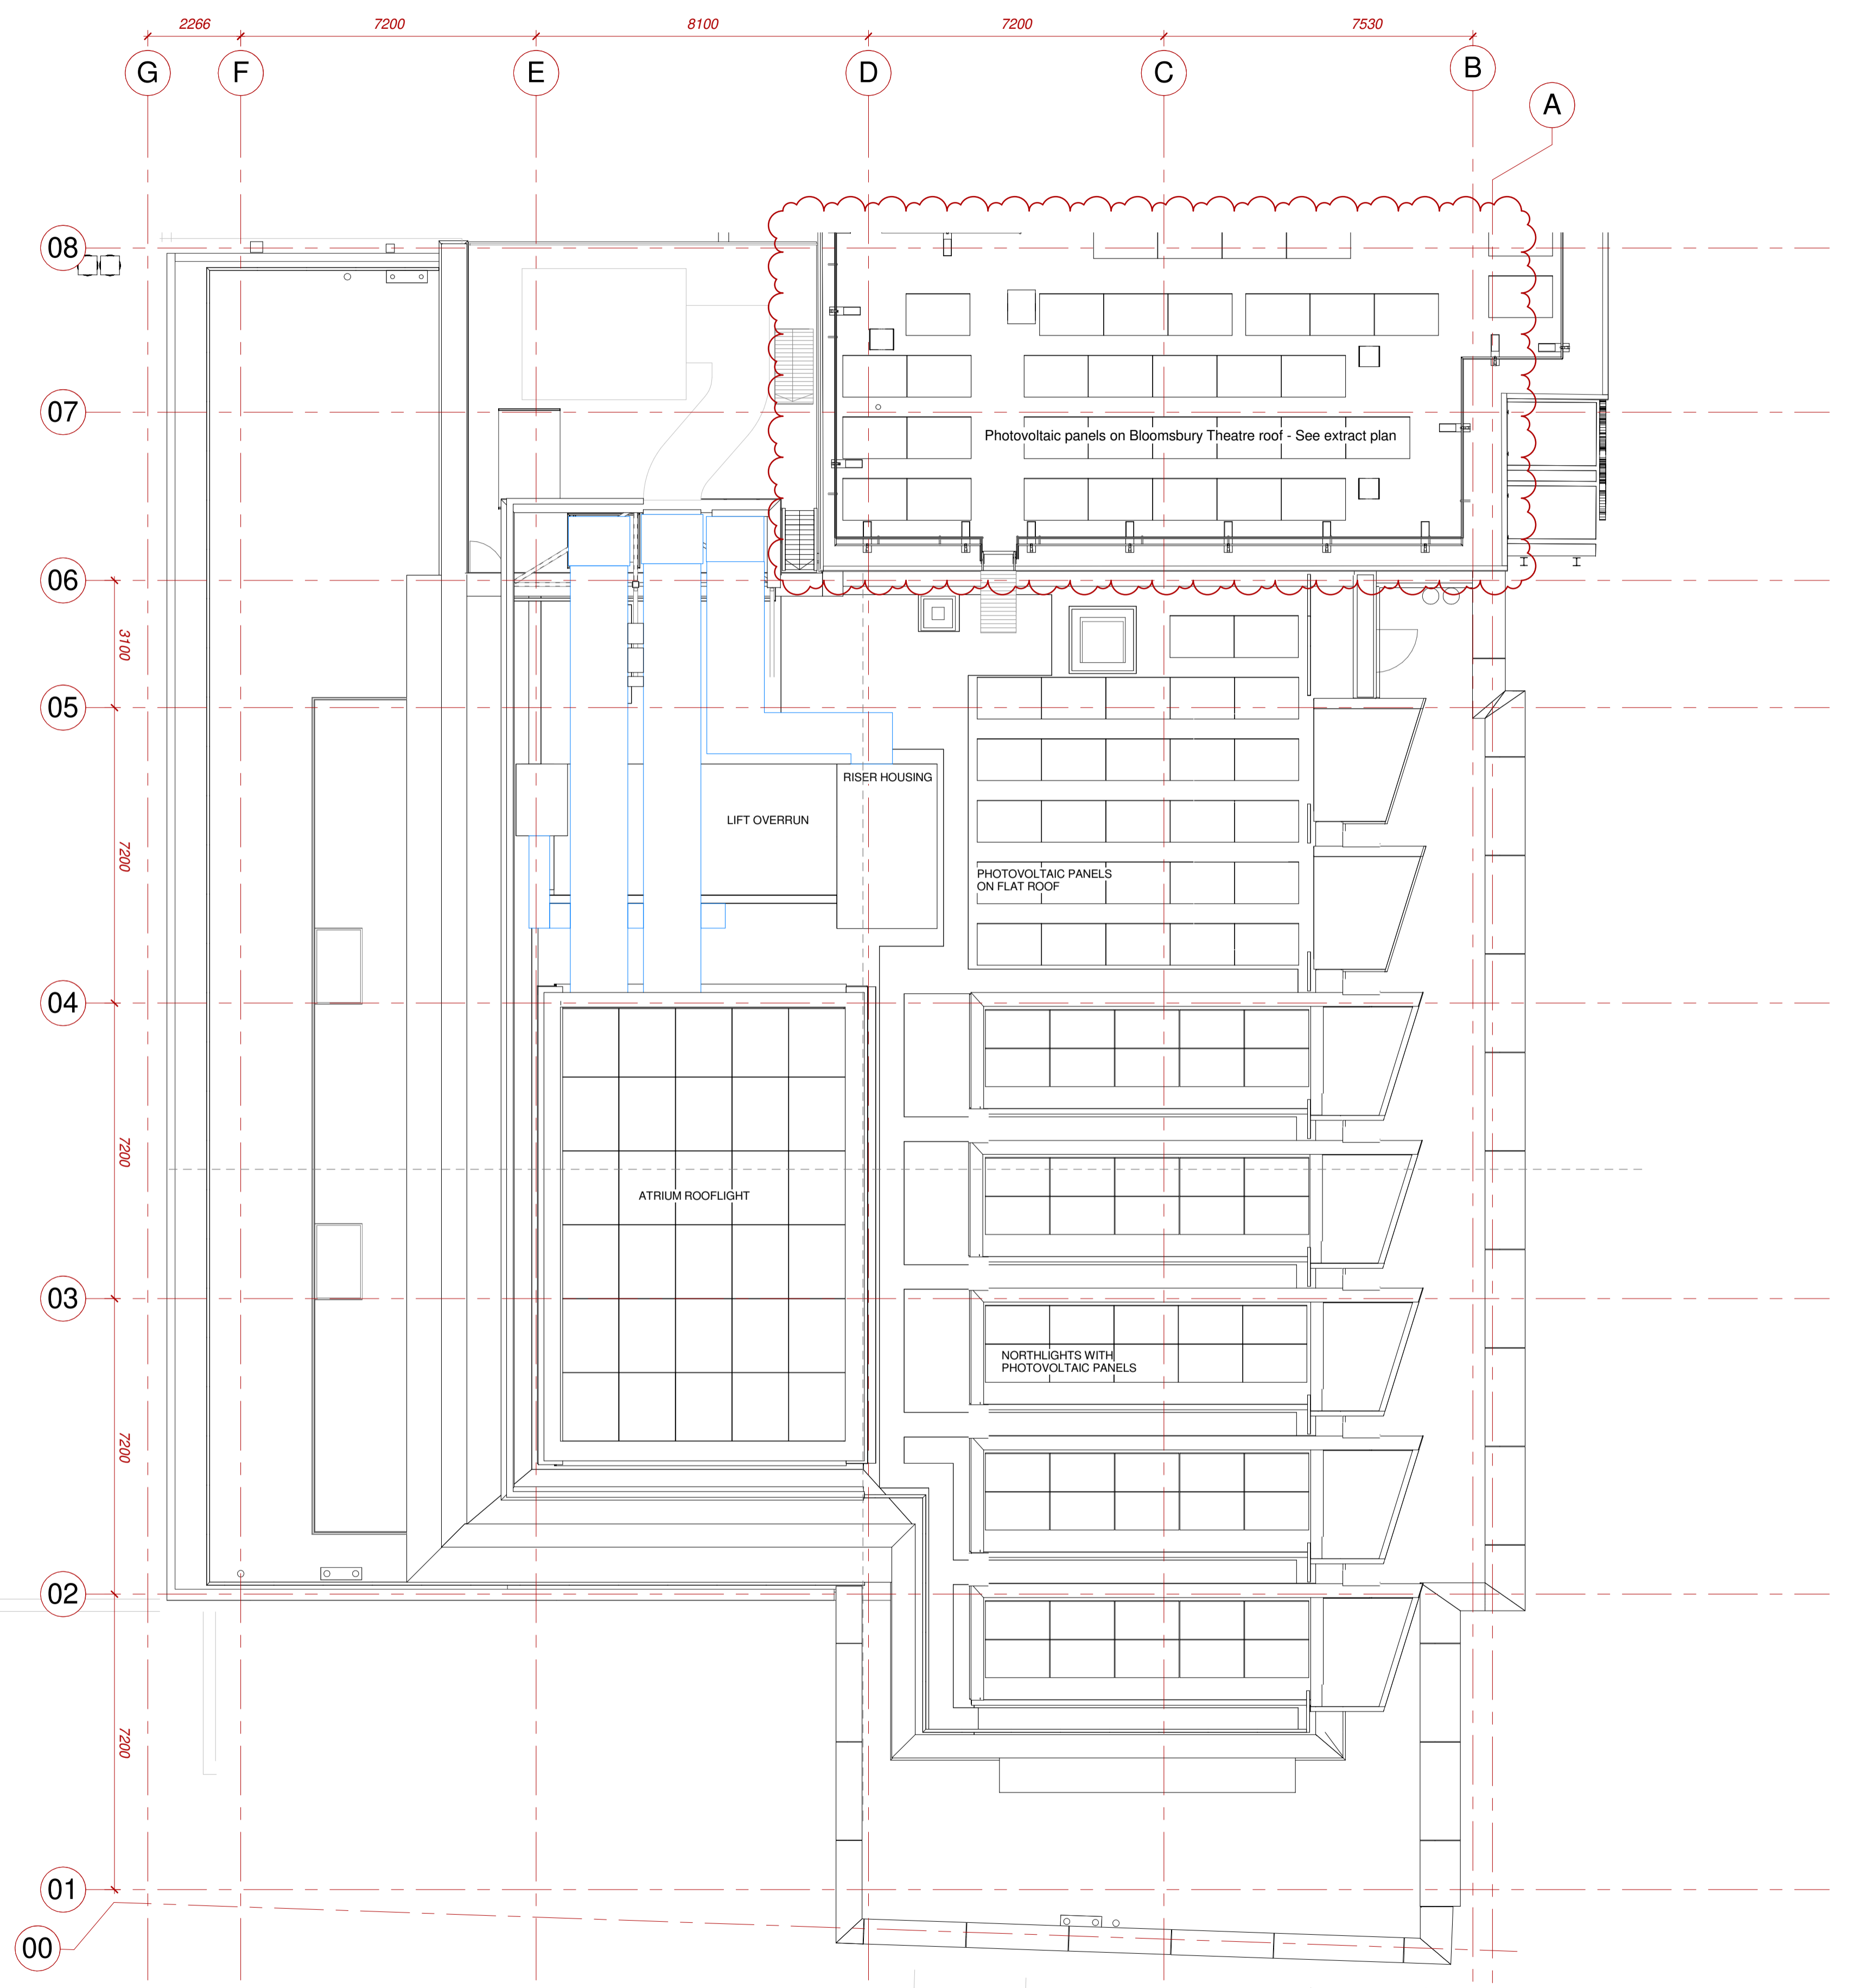

Rev	Date	Description
00	08/06/15	First issue planning application
P01	16/05/16	Planning update: General arrangement drawings updated to show minor amendments
P02	24/04/17	PV Layout revised: General arrangement drawings updated to reflect design development
P03	23/05/18	PV Layout on BT roof revised: General arrangement drawings updated to reflect design development

Nicholas Hare Architects 3 Baring Square London, N1 1JL Telephone: +44 (0)20 7619 1670 Fax: +44 (0)20 7619 1671 e-mail: 689@nicholas-hare.co.uk		project: UCL New Student Centre for: University College London title: Roof plan
status: For Planning <small>To be read in conjunction with all relevant information - do not scale</small>	scale: 1:100 size: A1 drawing number: 031-689-NHA-PL-015 rev: P03	(689)

