

 
 



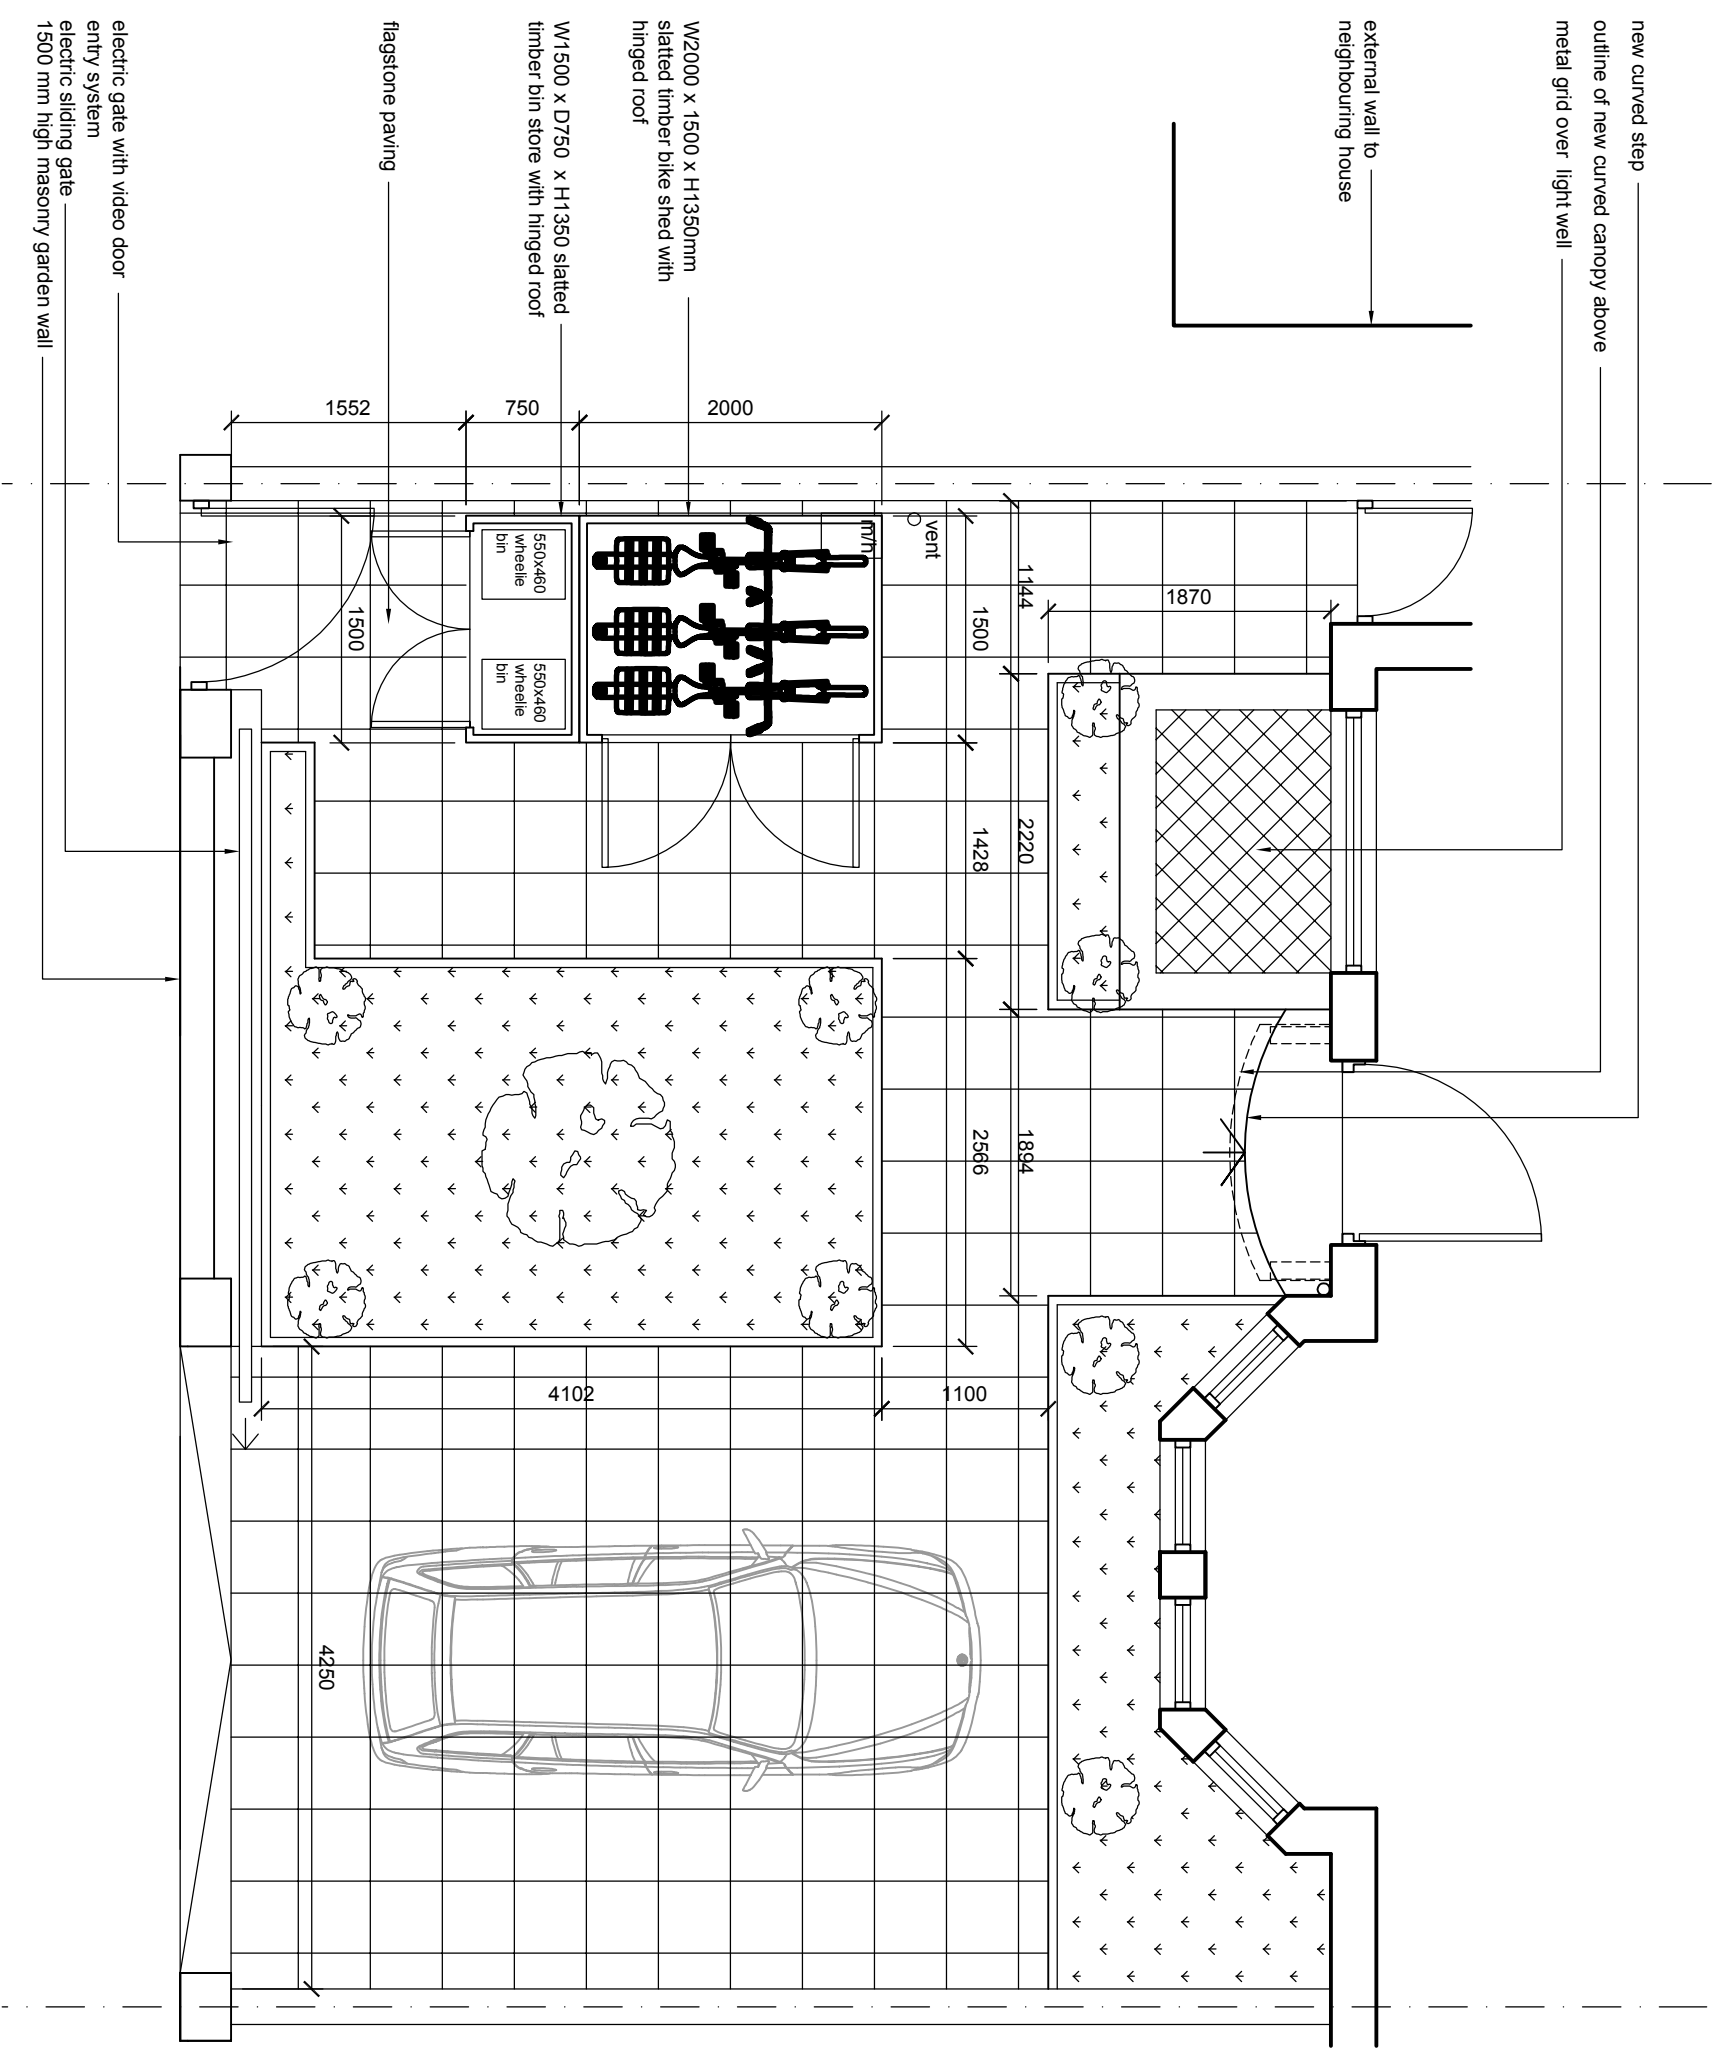
	New Construction
	Demolition
	CH Ceiling Height
	FL Floor Level
	SH Sill Height
	OH Opening Height
	SVP Soil Vent Pipe
	RWP Rain Water Pipe


 

 
 





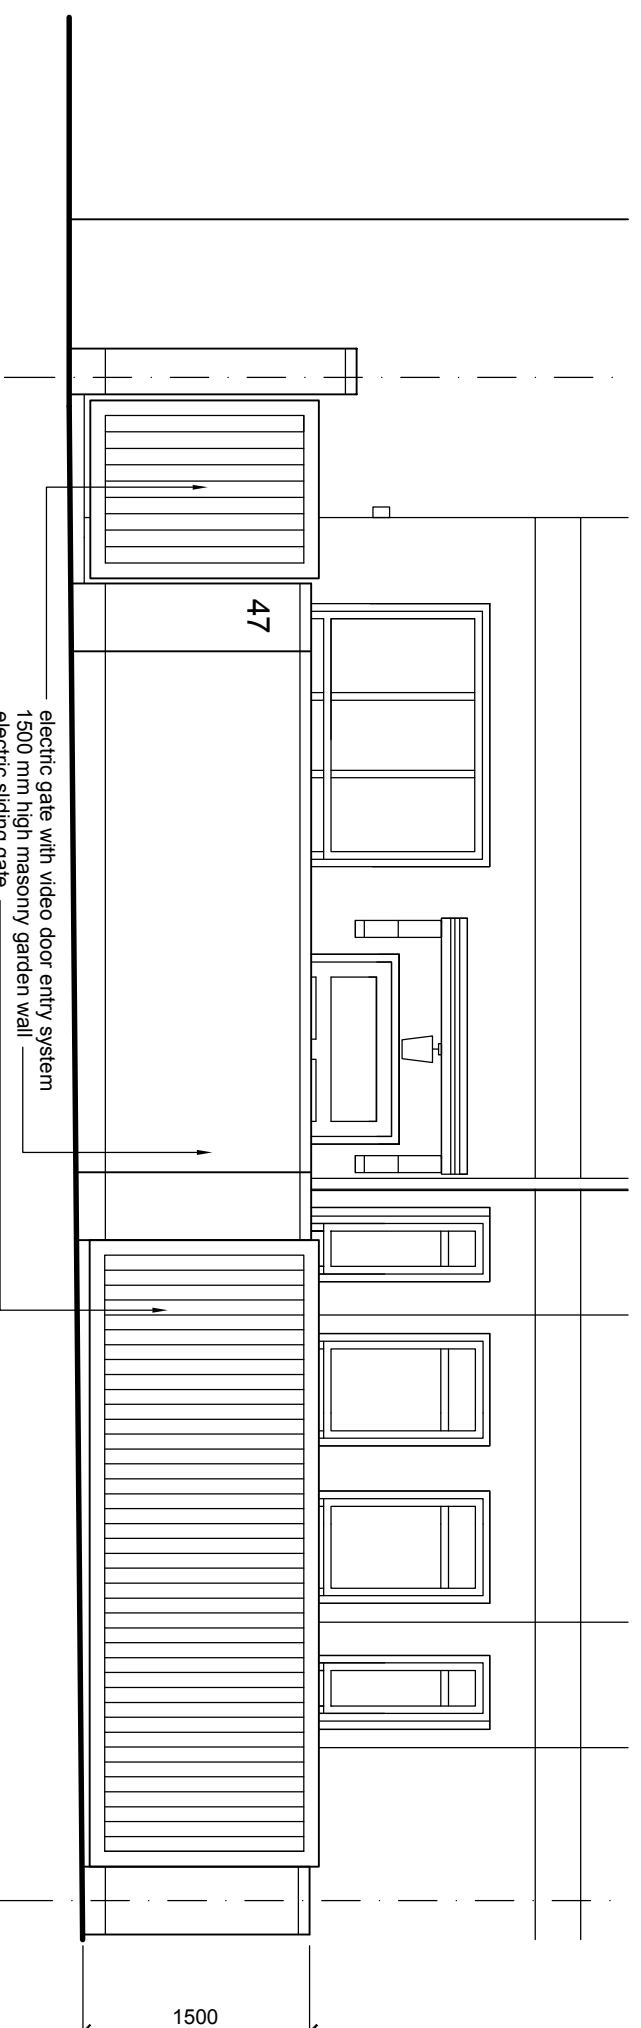
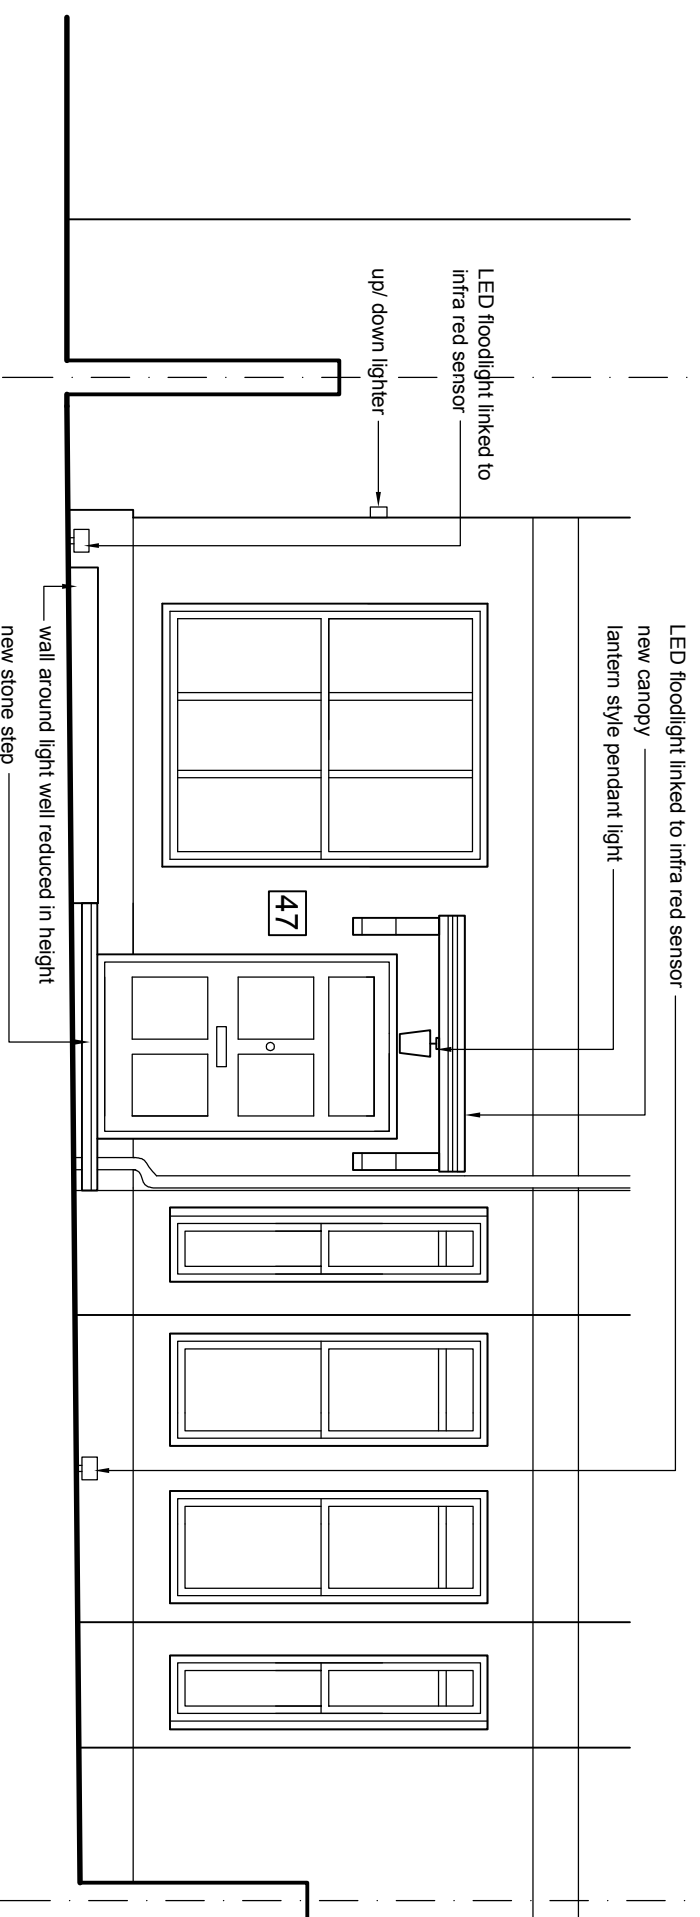
PROJECT: 47 FAIRHAZEL GARDENS, LONDON NW6 3QN
DRAWING TITLE:
Proposed Front Garden Plan
SCALE: 1:50@A3 DRAWING NUMBER: P-01C



Issued for comment 31.01.18
Revision A issued for comment 02.02.18
Revision A issued for comment 07.03.18
Revision B issued for comment 06.06.18
Revision C issued for PLANNING 07.06.18

studio seventi
ARCHITECTURE LTD
www.studioseventi.co.uk
176 Brookheowse Road
London SE6 3TP
m: 07985 507253
e: g.egbo@studioseventi.co.uk

	New Construction
	Demolition
	Ceiling Height
	Floor Level
	Sill Height
	Opening Height
	Soil Vent Pipe
	Rain Water Pipe






PROJECT: 47 FAIRHAZEL GARDENS, LONDON NW6 3QN
DRAWING TITLE:
Proposed Elevations
SCALE: 1:50@A3 DRAWING NUMBER: P-02D



Issued for comment 31.01.18
Revision A issued for comment 02.02.18
Revision B issued for comment 07.03.18
Revision C issued for comment 06.06.18
Revision D issued for comment 07.06.18

studio seventi
ARCHITECTURE LTD
www.studioseventi.co.uk
176 Brookehowse Road
London SE6 3TP
m: 07985 507253
e: g.egbo@studioseventi.co.uk

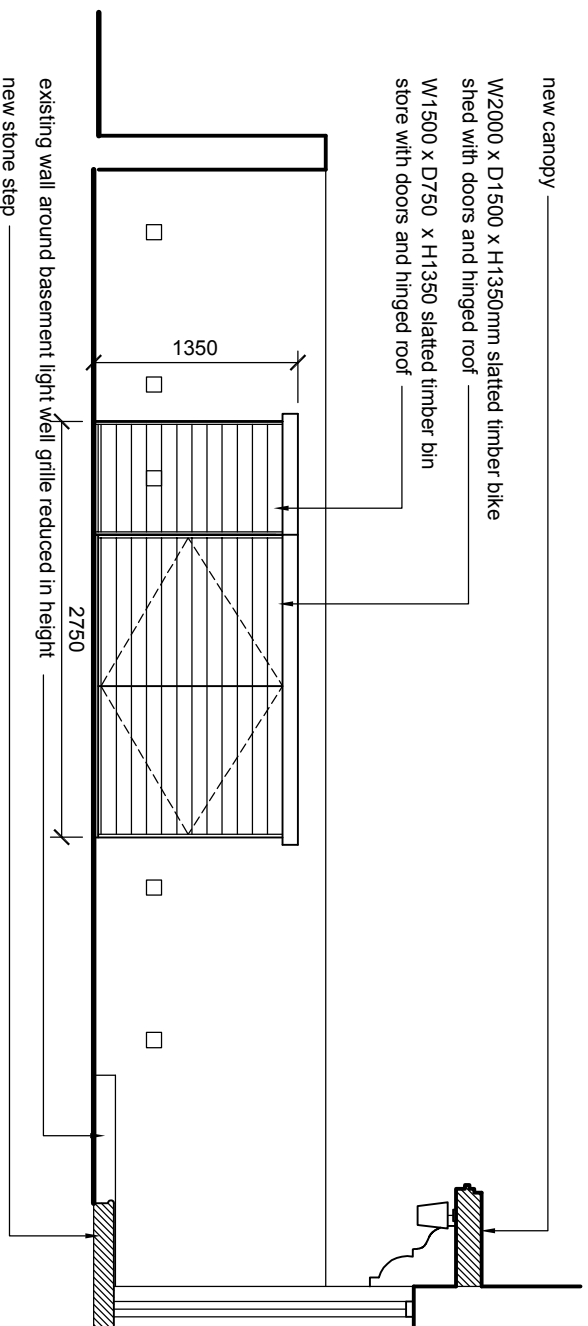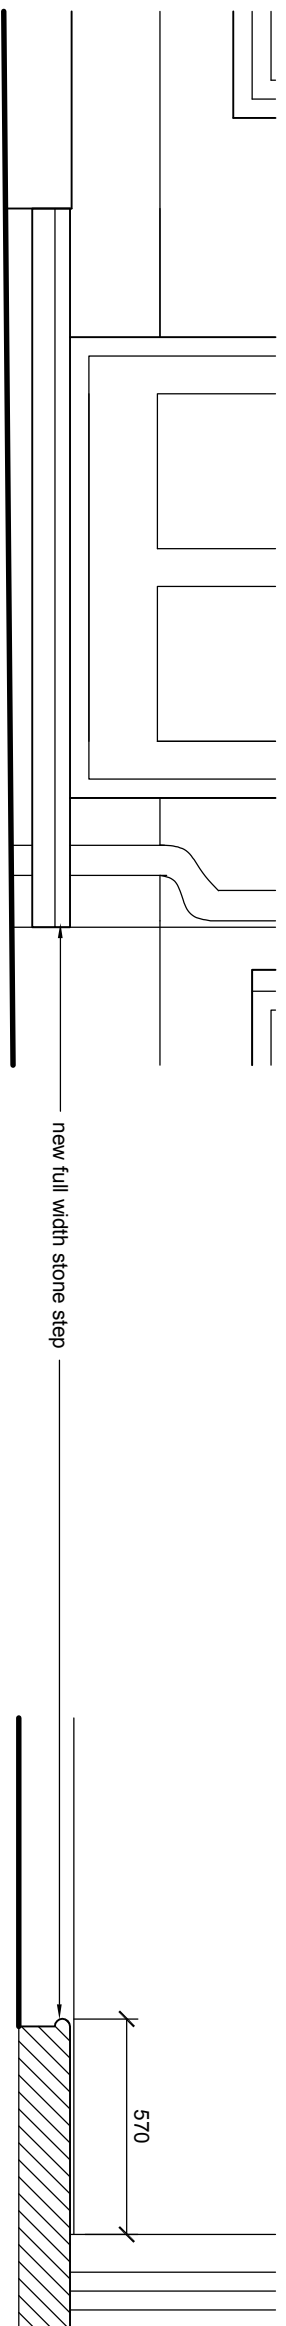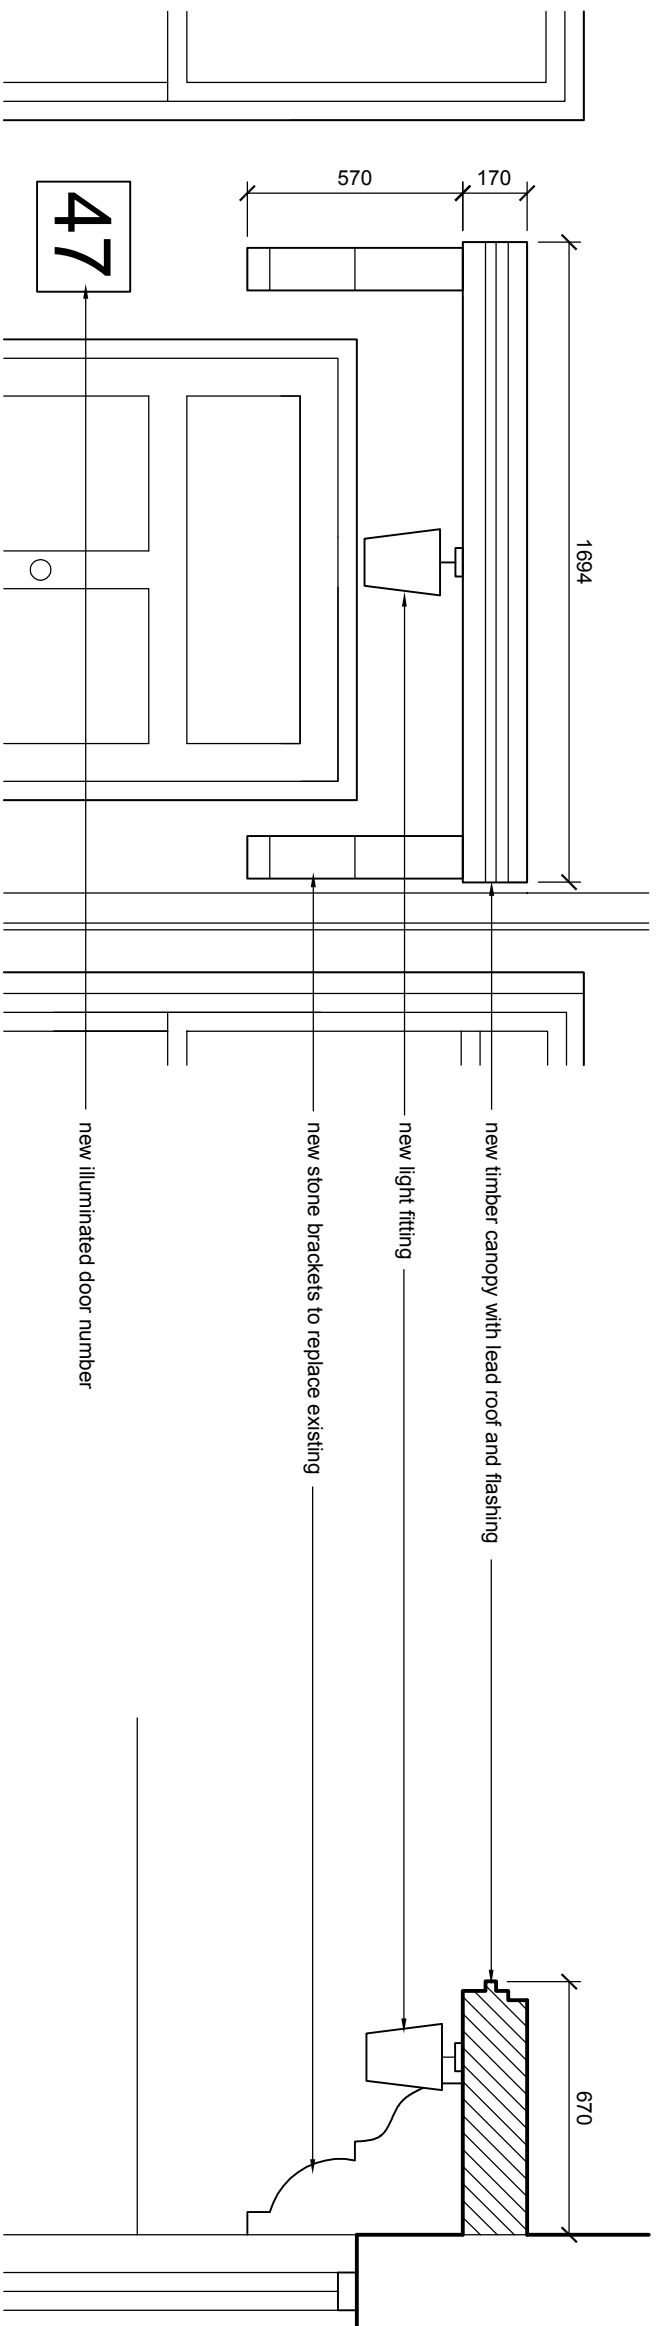

PROJECT: 47 FAIRHAZEL GARDENS, LONDON NW6 3QN
 DRAWING TITLE:

Canopy / front step and Bike / bin store

SCALE: 1:50 & 1:20 @A3 DRAWING NUMBER: P-03A

Issued for comment 31.01.18
 Revision A Issued for comment 02.02.18
 Revision B Issued for comment 07.03.18
 Revision C Issued for comment 06.06.18
 Revision D Issued for PLANNING 07.06.18

studio seventi


A R C H I T E C T U R E L T D

www.studioseventi.co.uk

176 Brookhouse Road
 London SE6 3TP

m: 07985 507253

e: g.egbo@studioseventi.co.uk

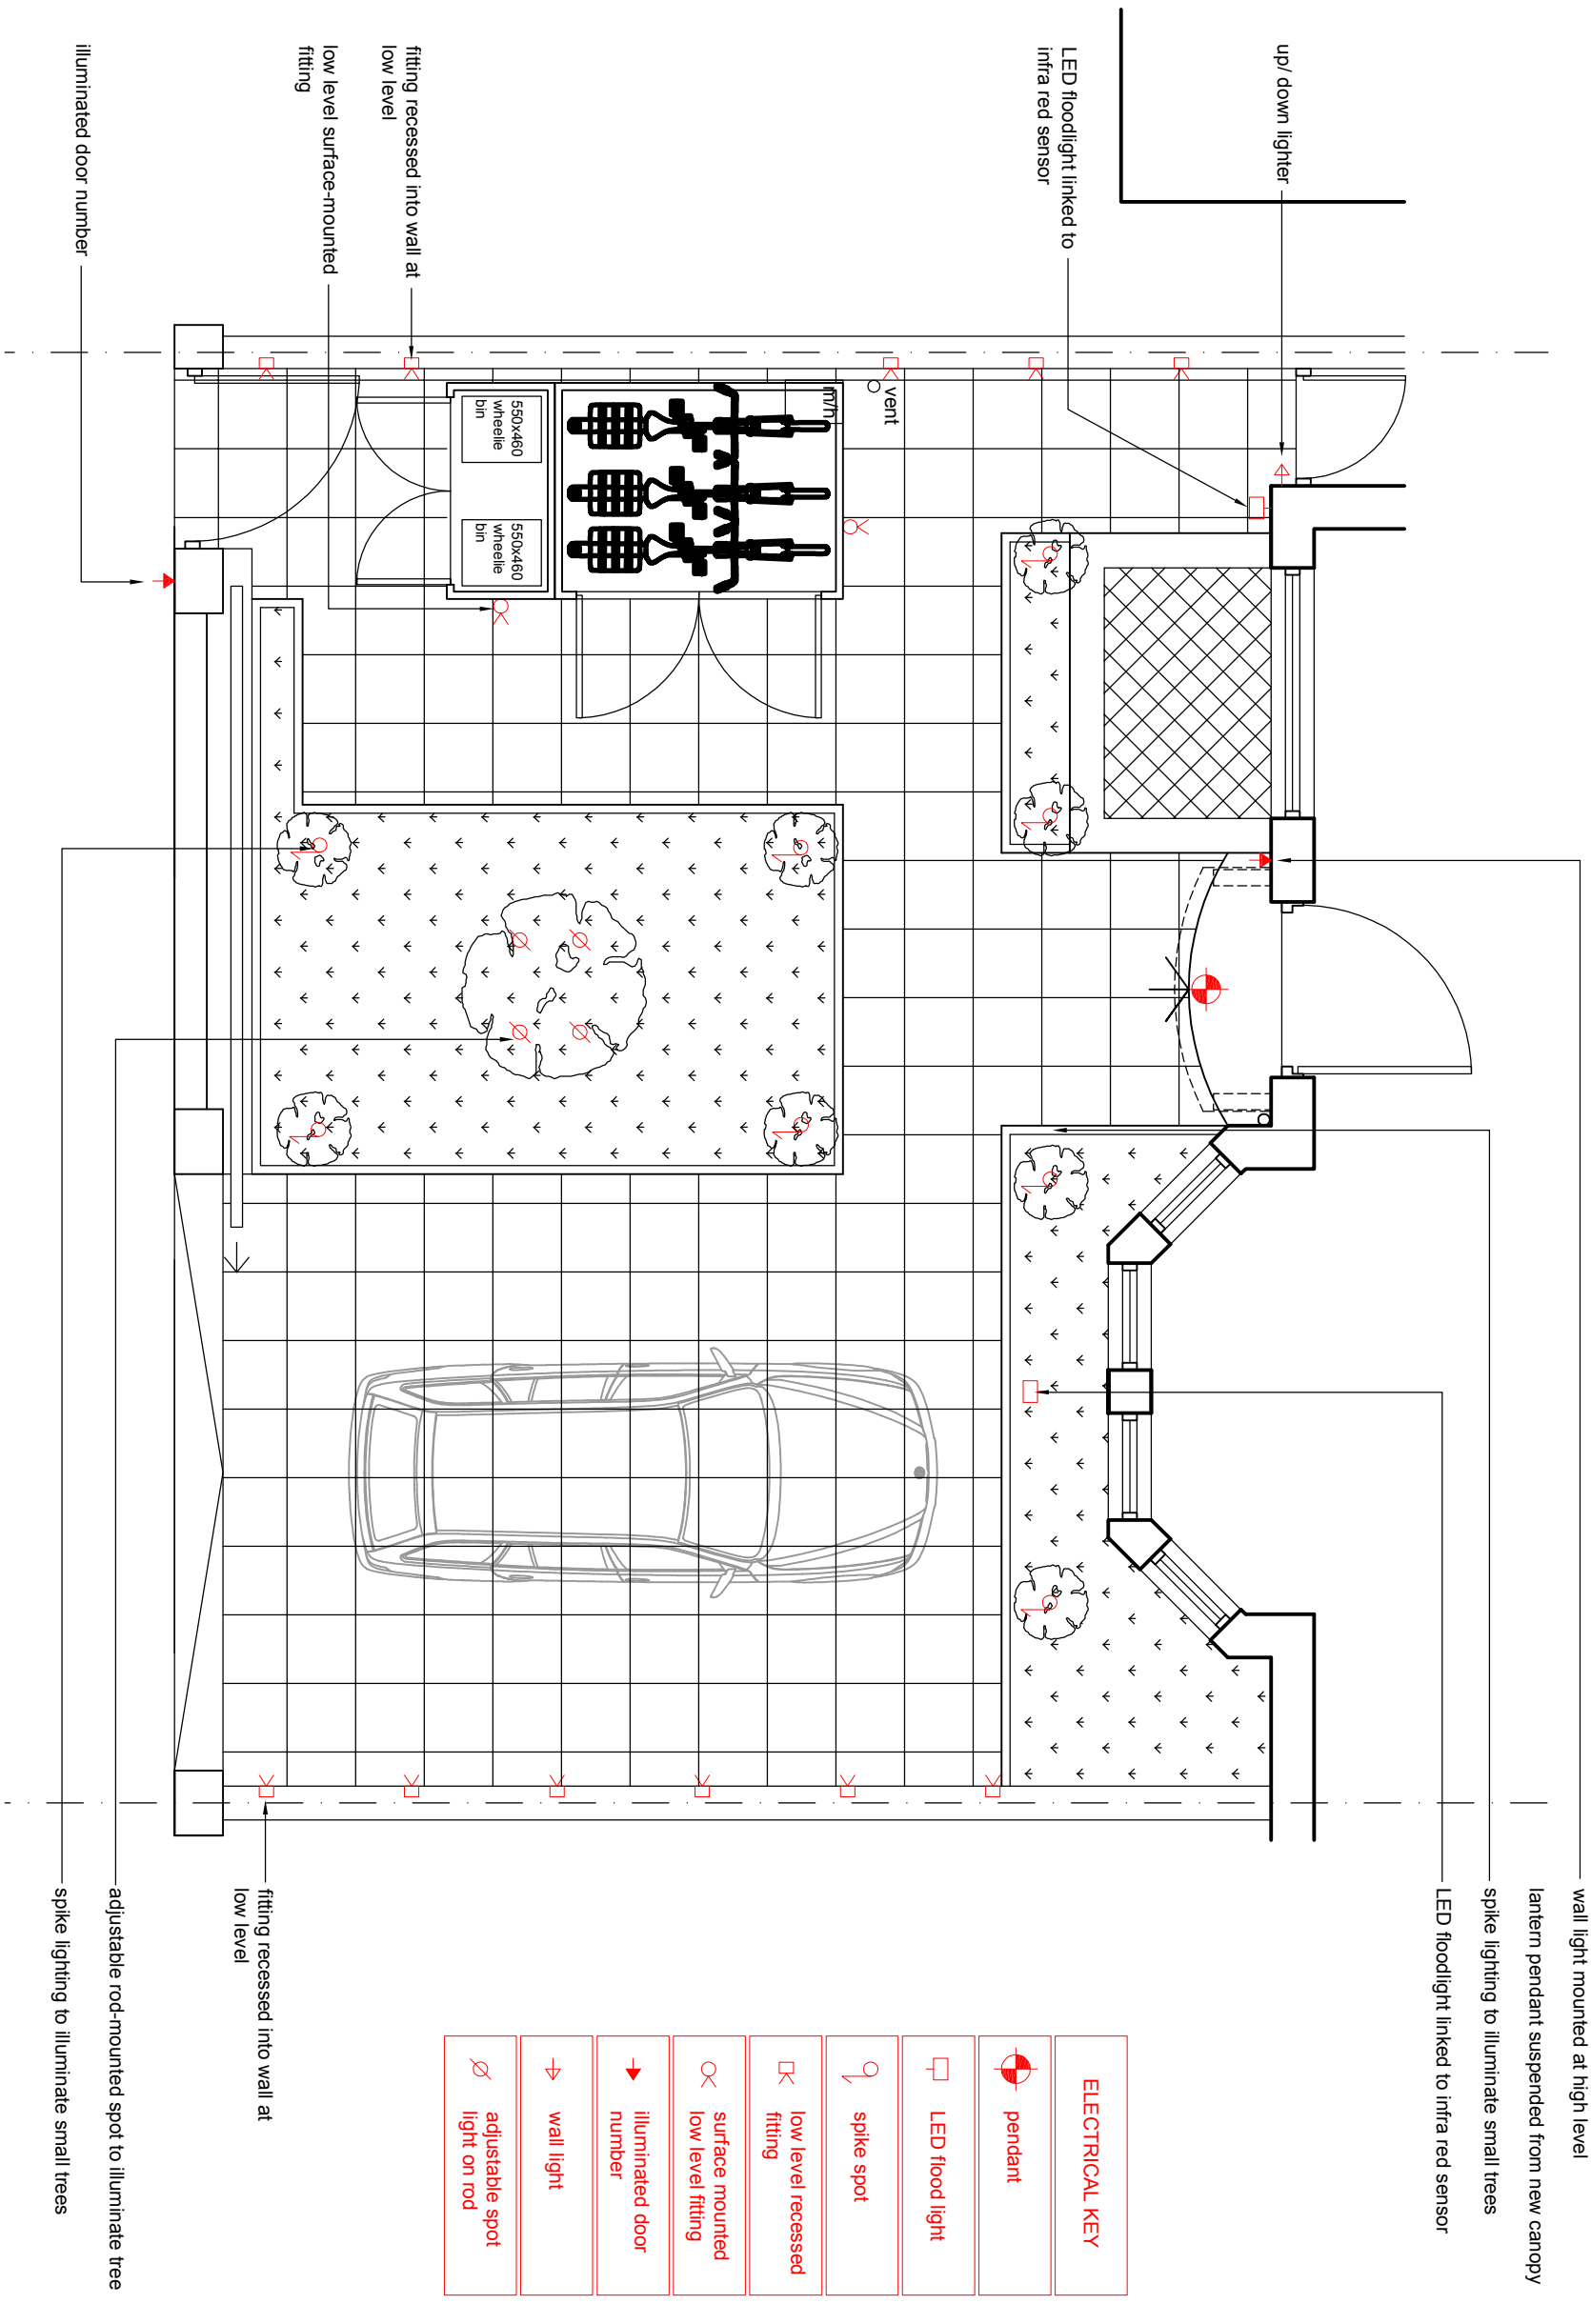

ELECTRICAL KEY	
	pendant
	LED flood light
	spike spot
	low level recessed fitting
	surface mounted low level fitting
	illuminated door number
	wall light
	adjustable spot light on rod

PROJECT: 47 FAIRHAZEL GARDENS, LONDON NW6 3QN
DRAWING TITLE:
Proposed Lighting Plan
SCALE: 1:50@A3 DRAWING NUMBER: P-04B



Issued for comment 07.03.18
Revision A issued for comment 06.06.18
Revision B issued for PLANNING 07.06.18

studio seventi
ARCHITECTURE LTD
www.studioseventi.co.uk
176 Brookehouse Road
London SE6 3TP
m: 07985 507253
e: g.egbo@studioseventi.co.uk