



CL	CEILING LIGHT
SA	SMOKE ALARM
FB	FUSE BOX
SS	SECURITY SYSTEM
C	CAMERA
SW	SWITCH
TH	THERMOSTAT
AL	ALARM
AR	AERIAL
BT	BRITISH TELECOM
IS	ISOLATOR SWITCH
V	VENT
WL	WALL LIGHT
RAD	RADIATOR
LS	LIGHT SWITCH
S	SINGLE SOCKET
DS	DOUBLE SOCKET
INT	INTERCOM
SP	SPEAKERS

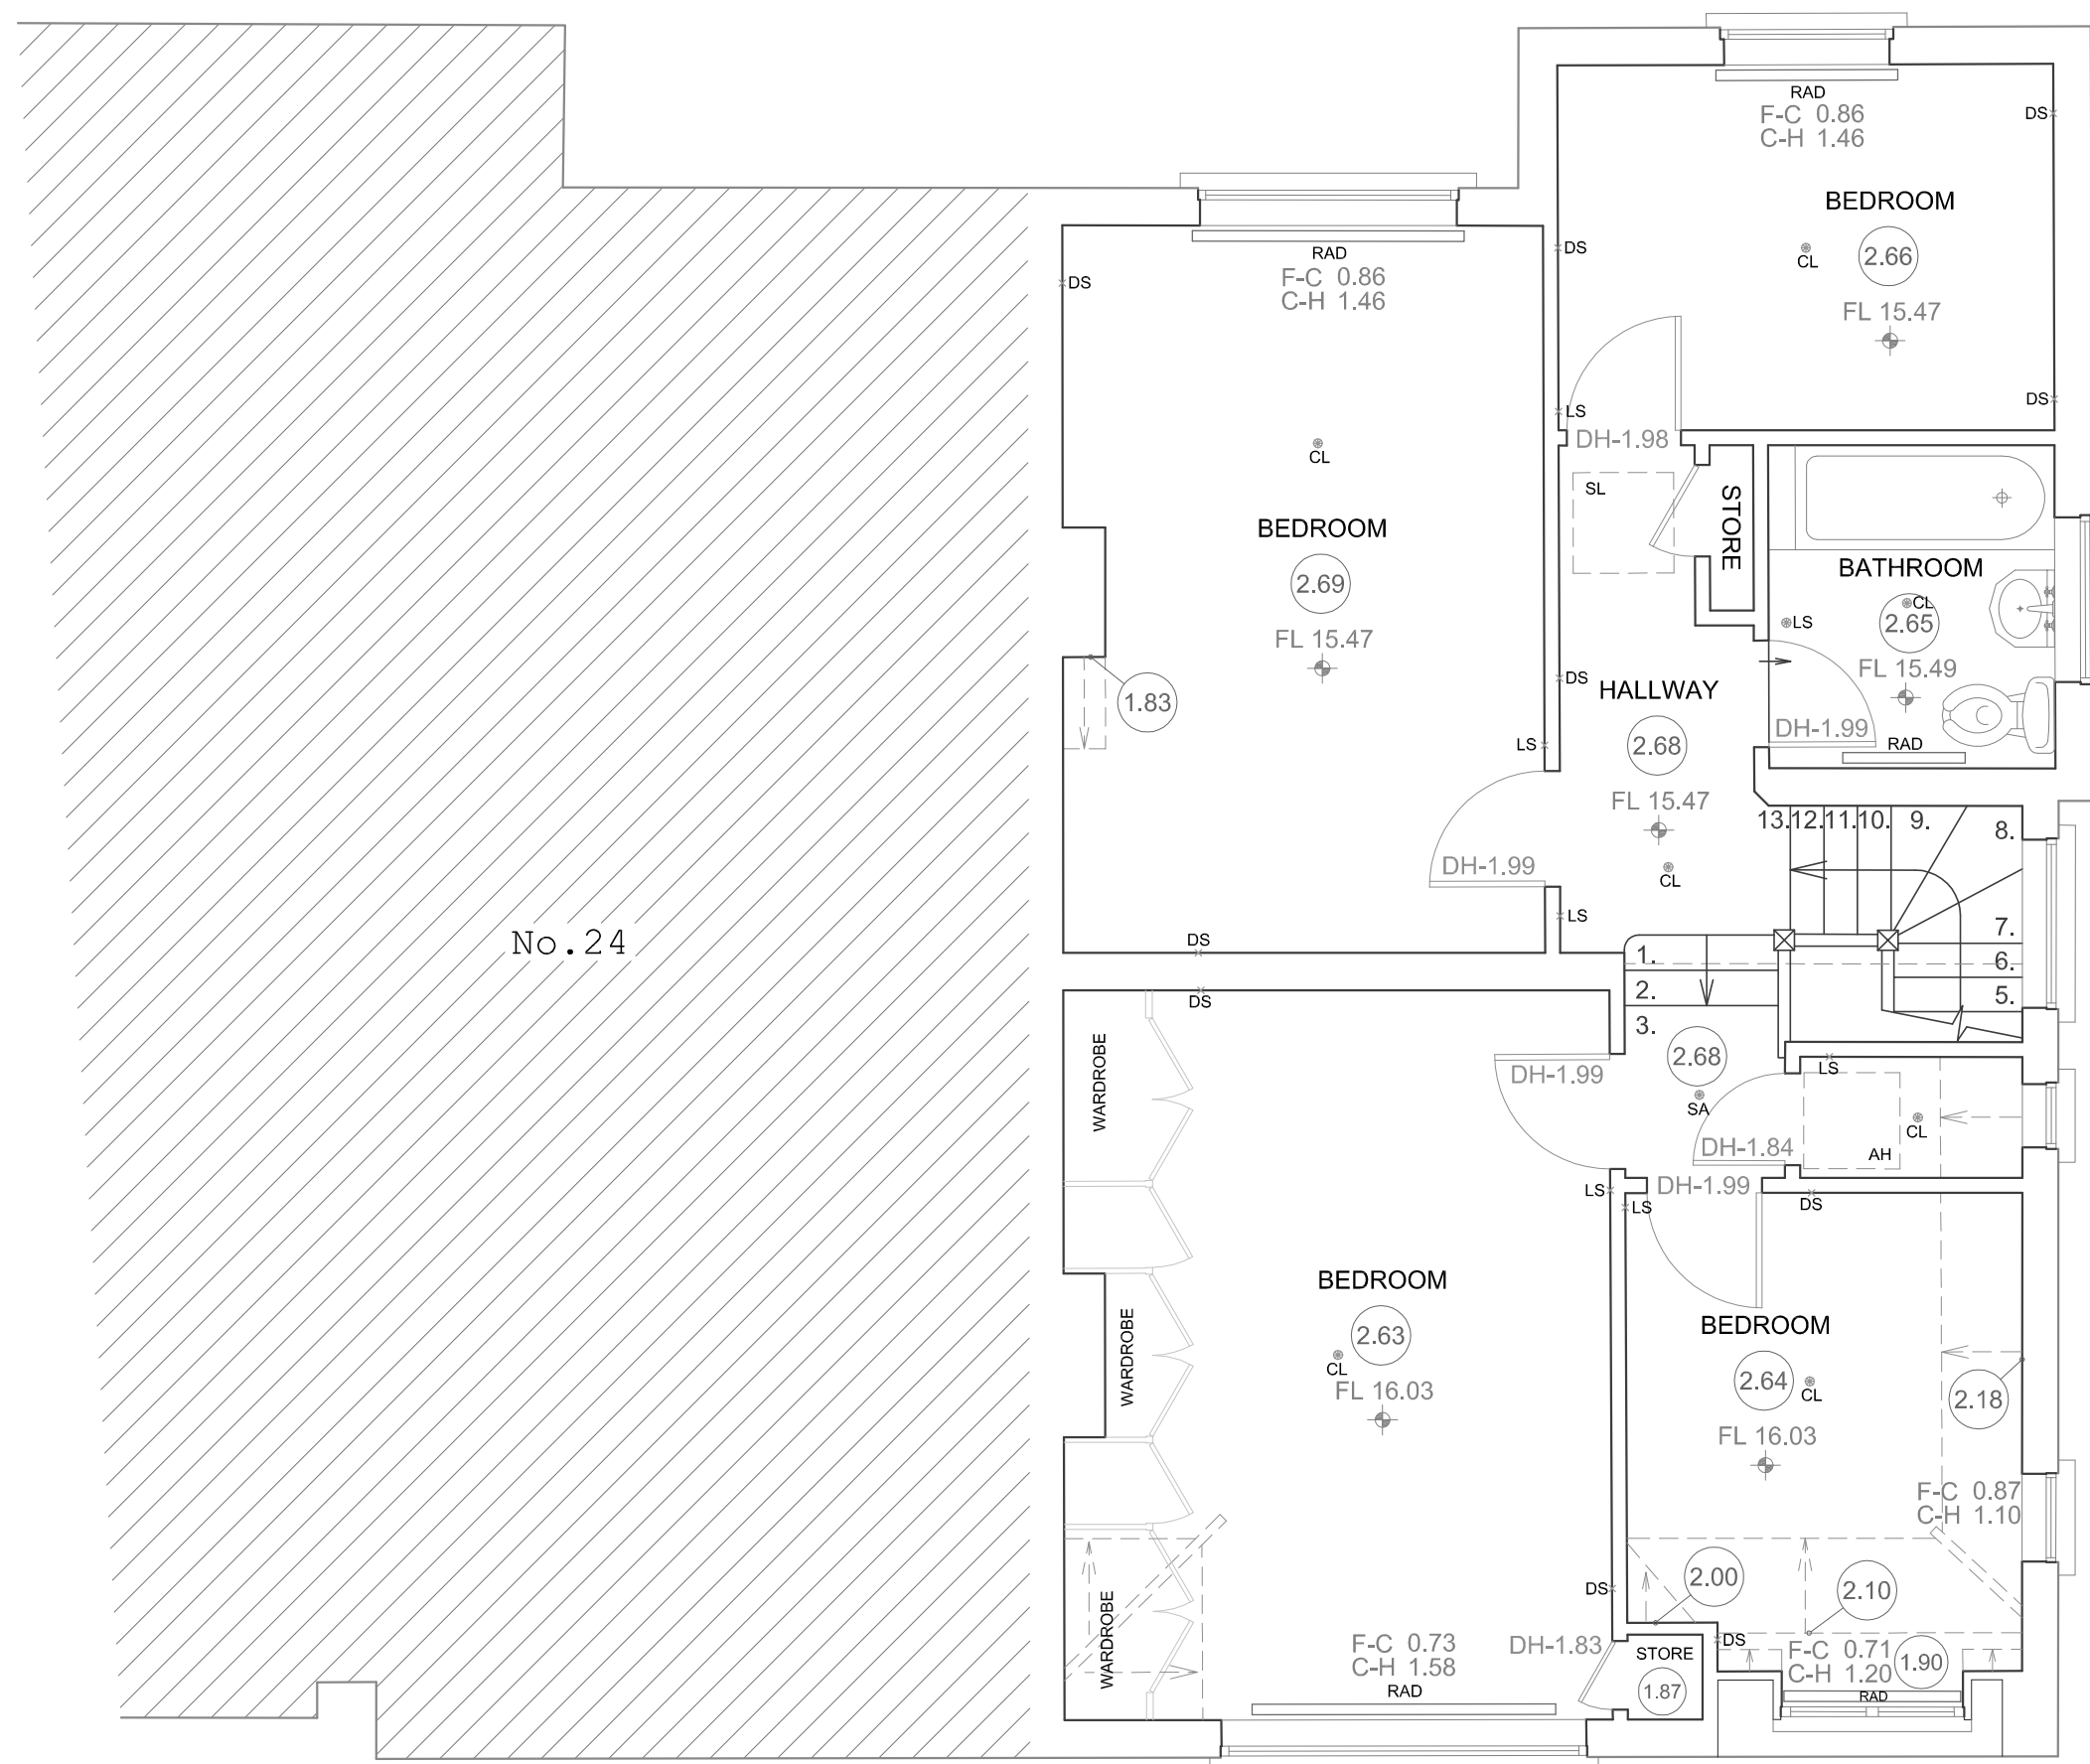

FIT MARK B

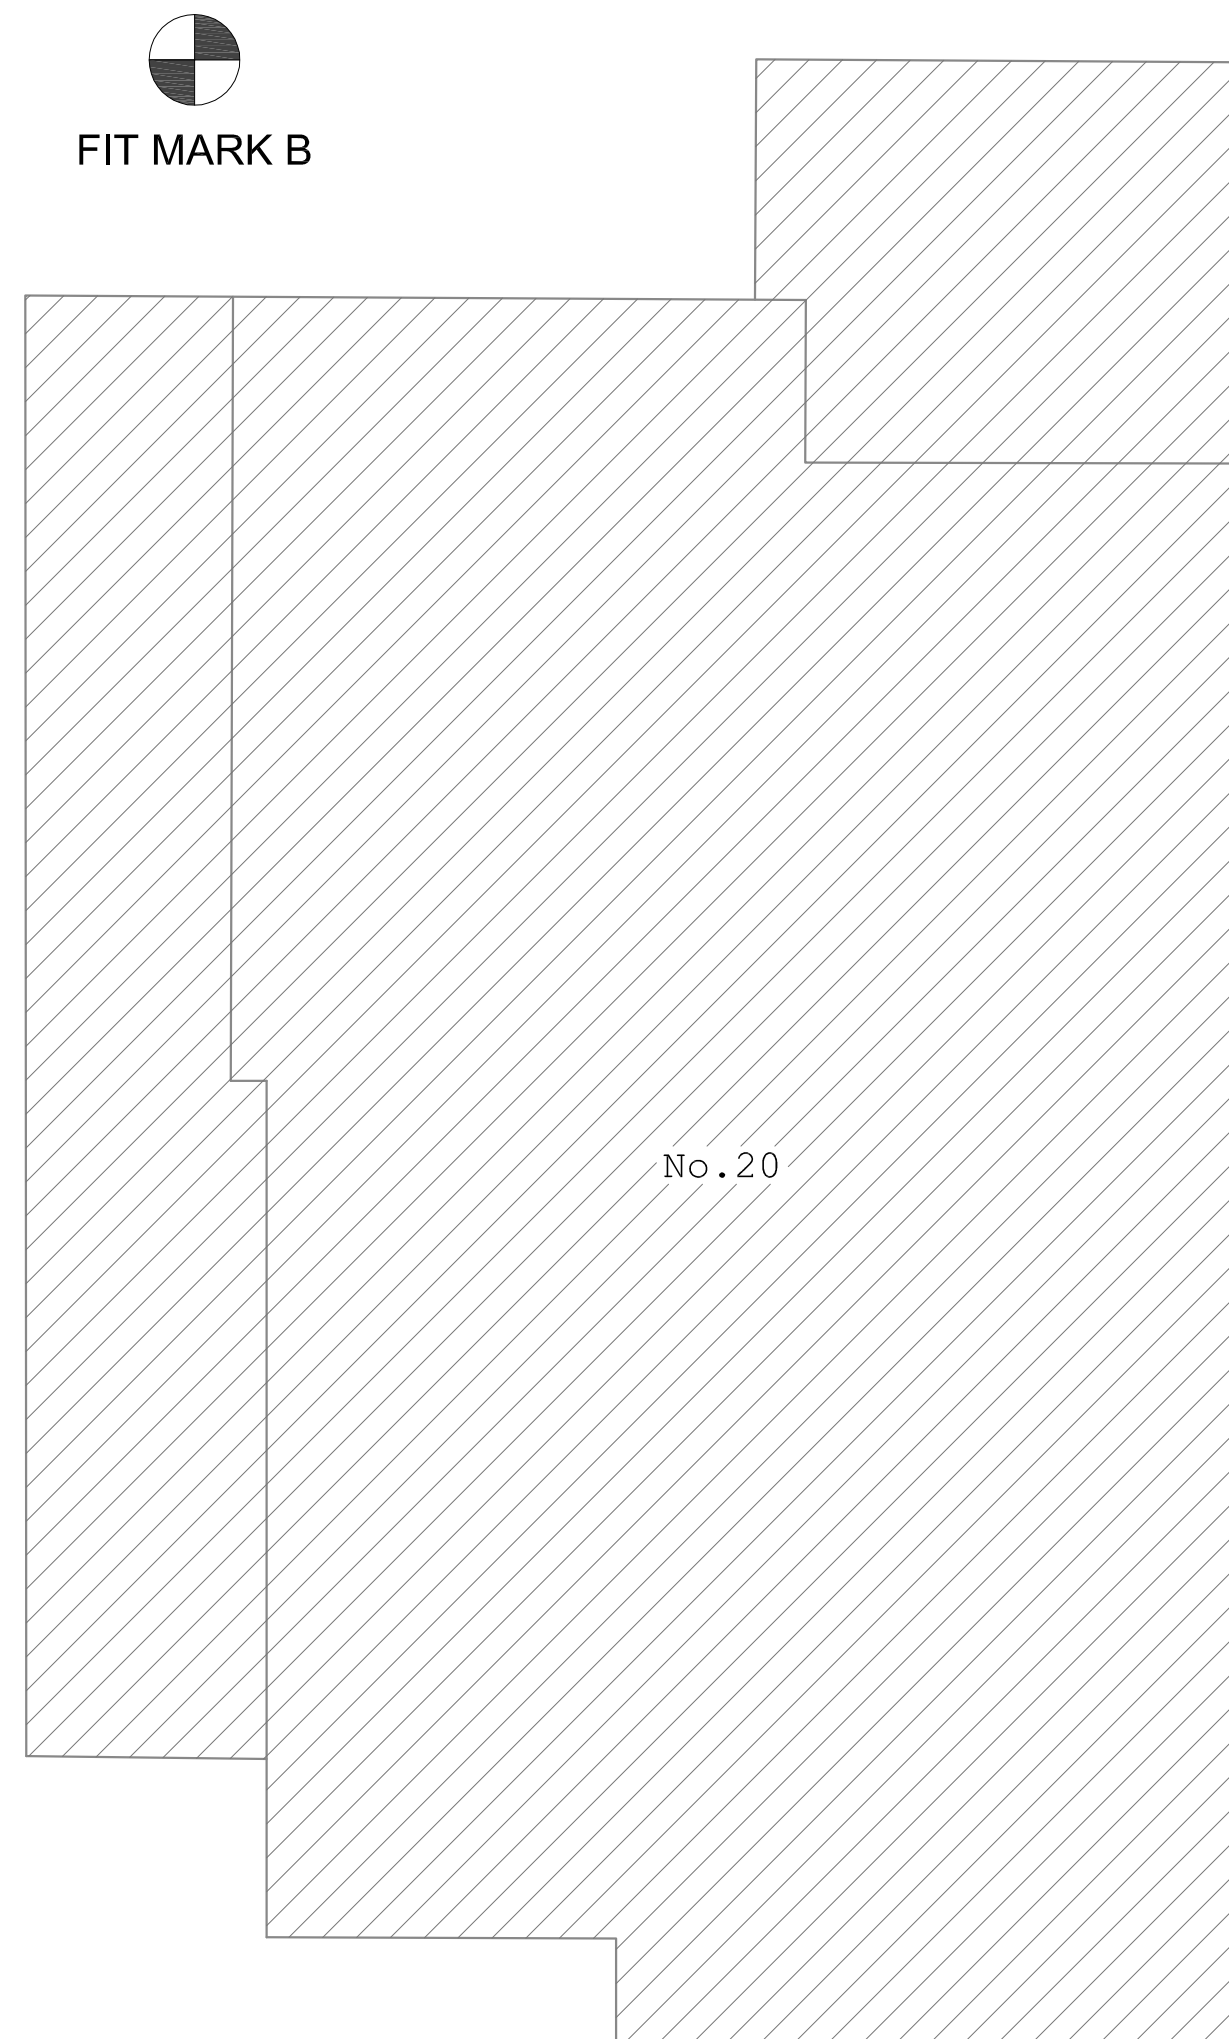

METRO PLANS SURVEYS	
MEASURED BUILDING SURVEY	
LEGEND	
F = 0.00	FLOOR TO GILL HEIGHT
G = 0.00	GULLY TO GILL HEIGHT
CE	FLOOR TO CEILING HEIGHT
PL 21.80	FLOOR LEVEL
SP	SPRINK HEIGHT
ST	SINGLE STEP HEIGHT
AC	ACCESS HATCH
AHL	ARCH HEAD LEVEL
BLR	BOLLER
BOL	BOLLARD
BSL	BSL BENCHMARK
BSM	BEAM SOFFIT LEVEL
BSH	BEAM SOFFIT HEIGHT
CB	CABINET
CV	CABLE TRAY
CBD	CURBPOD
CCTV	CCTV CAMERA
CH	CEILING HATCH
CH	COUNTER
CH	CEILING HATCH
CH	CEILING LIGHT
CV	CEILING VENT
CH	DOOR HEIGHT
EAVE.00	EAVE LEVEL
EM	ELECTRIC METER
EP	ELECTRICAL POLE
FC	FALSE CEILING
FP	FIRE PLACE
FB	FUSE BOARD
FA	FIRE ALARM
FI	FIRE INDICATOR
FE	FIRE EXTINGUISHER
GM	GAS METER
GA	GATE POST
GV	GAS VALVE
GY	GULLY
IC	INSPECTION CHAMBER
KI	STORM WATER INLET
LP	LAMP
LI	MANHOLE
CH	COVER
HL	INLET LEVEL
OH	OVER HEAD CABLE
OHG	OVERHEAD
P	POLE
PAR.00	PARAPET LEVEL
PT	POST & TELECOM
PS	POWER SUPPLY
RAD	RADIATOR
RE	RODDING EYE
RS	ROAD SIGN
RW	RAIN WATER PIPE
RIDGE.00	RIDGE LEVEL
SLV	SHELVING
SL	SILL LEVEL
SV	STOP VALVE
SOP	SOIL WATER PIPE
SS	SUSPENDED CEILING
SW	SWITCH
TOP.00	TOP OF FENCE
TOP.00	TOP OF WALL
TE	TELEPHONE POLE
WH	WATER HEATER
WM	WATER MAIN
WT	WATER TANK
VV	WATER VALVE
WL	WALL LAMP
WS	WORK SURFACE
BS	SURVEY STATION
1045	
 TREE DECIDUOUS - crown height (m)	 TREE CONIFEROUS - trunk spread height (m)
 BUSH	
ELECTRICAL LAYOUT	
	SINGLE SOCKET
	DOUBLE SOCKET
	TELECOM
	TV
	ALARM
	LIGHTING
	UP LIGHT
	SINGLE SWITCH
	DOUBLE SWITCH

All levels to arbitrary datum

-	-	-	-
-	-	-	-
-	-	-	-
-	-	-	-
-	FULL ISSUE	25/05/2016	DC

CLIENT	VICTORIA SILVER
PROJECT	No.20 MAKEPEACE AVENUE, N6 6QY
SURVEY TYPE	FLOOR PLAN

Drawn by	LZ	Scale	1:50 A1
Checked by	DC	Job No.	3768
Date	MAY 2016	Dwg No.	3768-04

NO.20 MAKEPEACE AVENUE, N6 6QY
FIRST FLOOR PLAN