
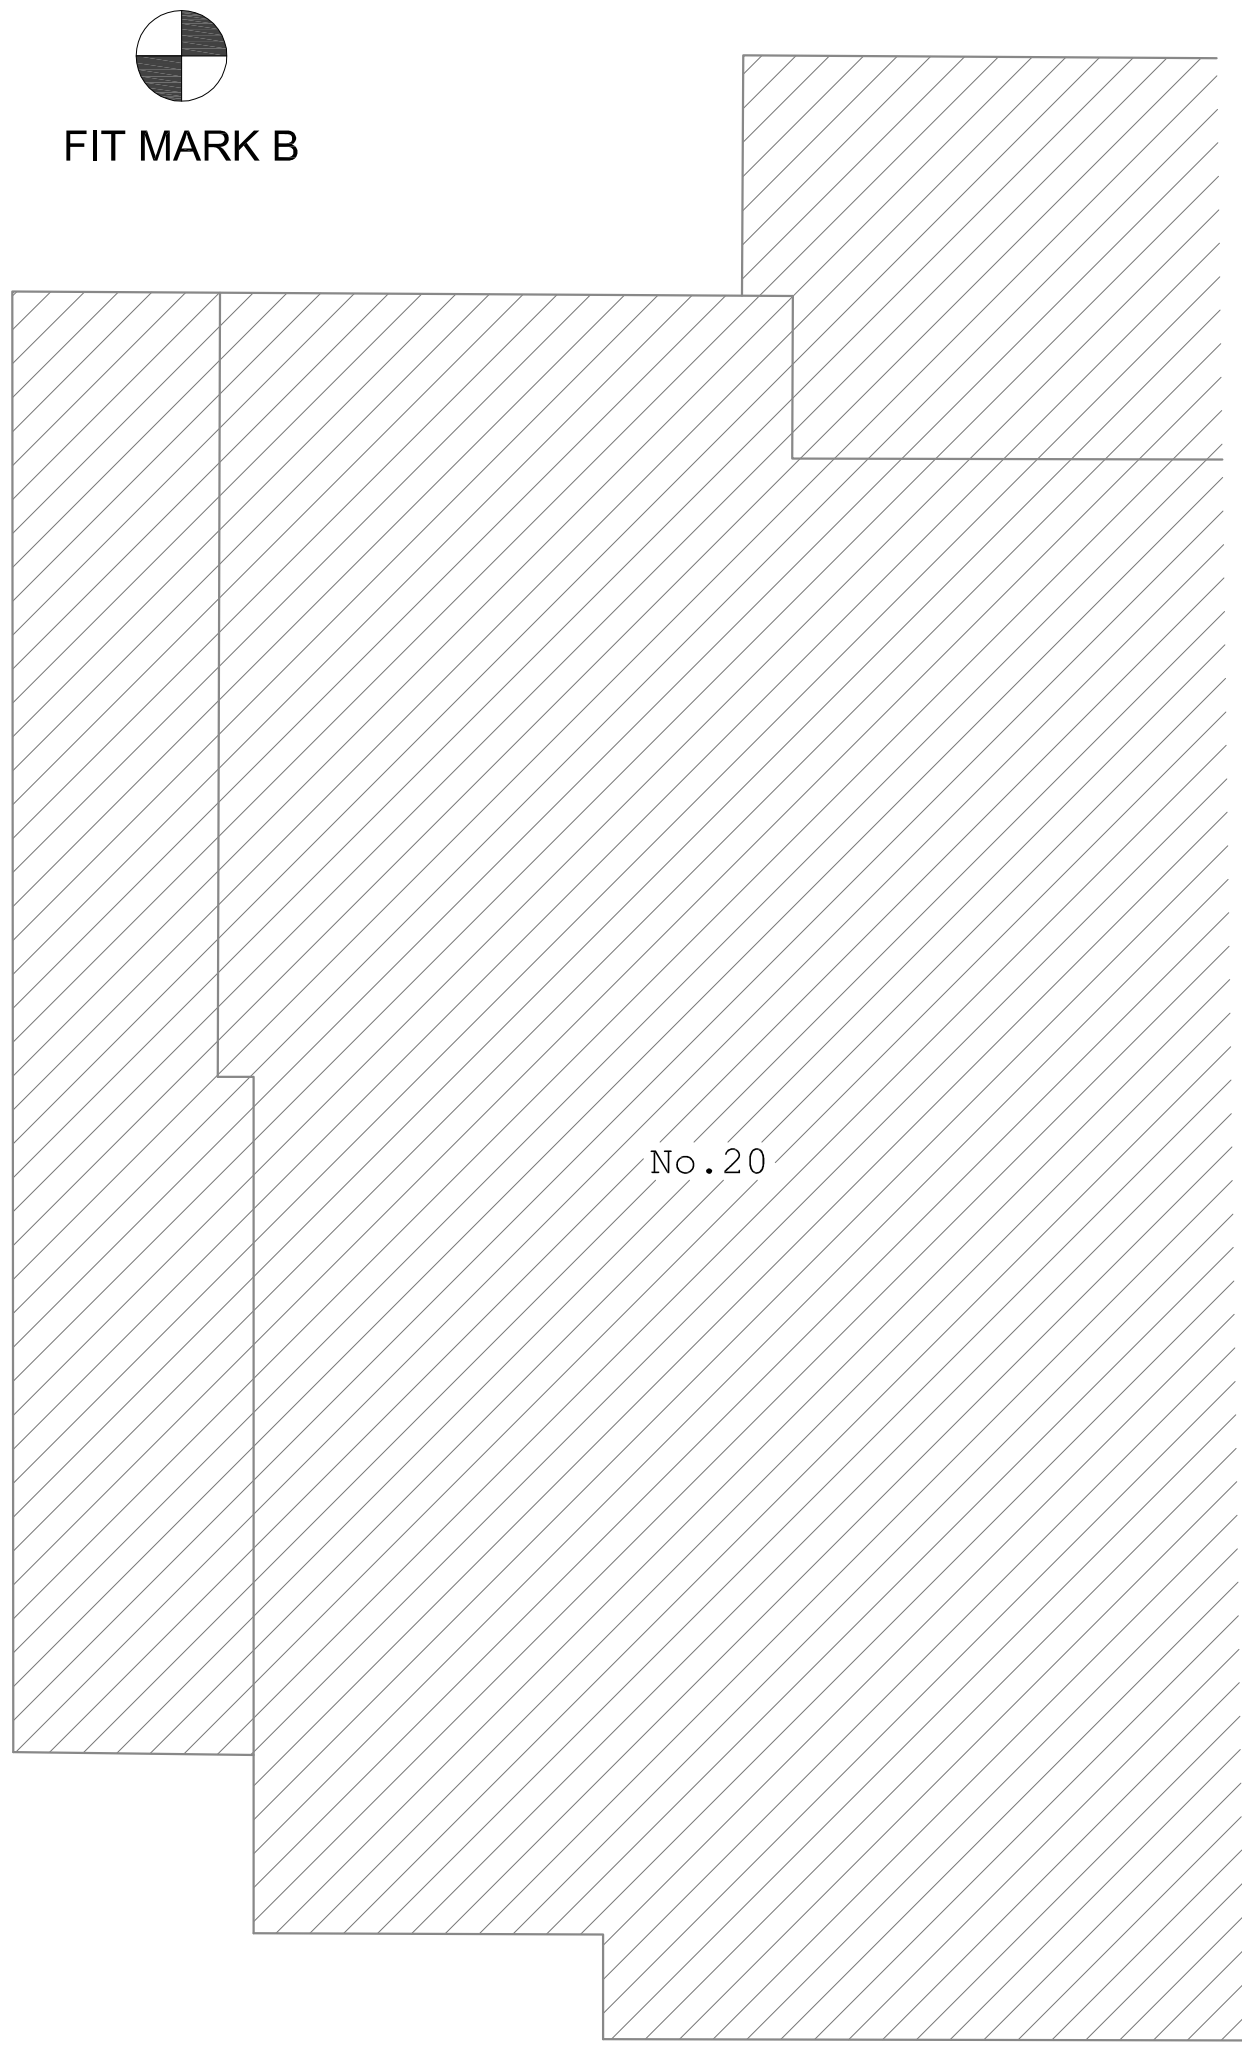


CL	CEILING LIGHT
SA	SMOKE ALARM
FB	FUSE BOX
SS	SECURITY SYSTEM
C	CAMERA
SW	SWITCH
TH	THERMOSTAT
AL	ALARM
AR	AERIAL
BT	BRITISH TELECOM
IS	ISOLATOR SWITCH
V	VENT
WL	WALL LIGHT
RAD	RADIATOR
LS	LIGHT SWITCH
S	SINGLE SOCKET
DS	DOUBLE SOCKET
INT	INTERCOM
SP	SPEAKERS

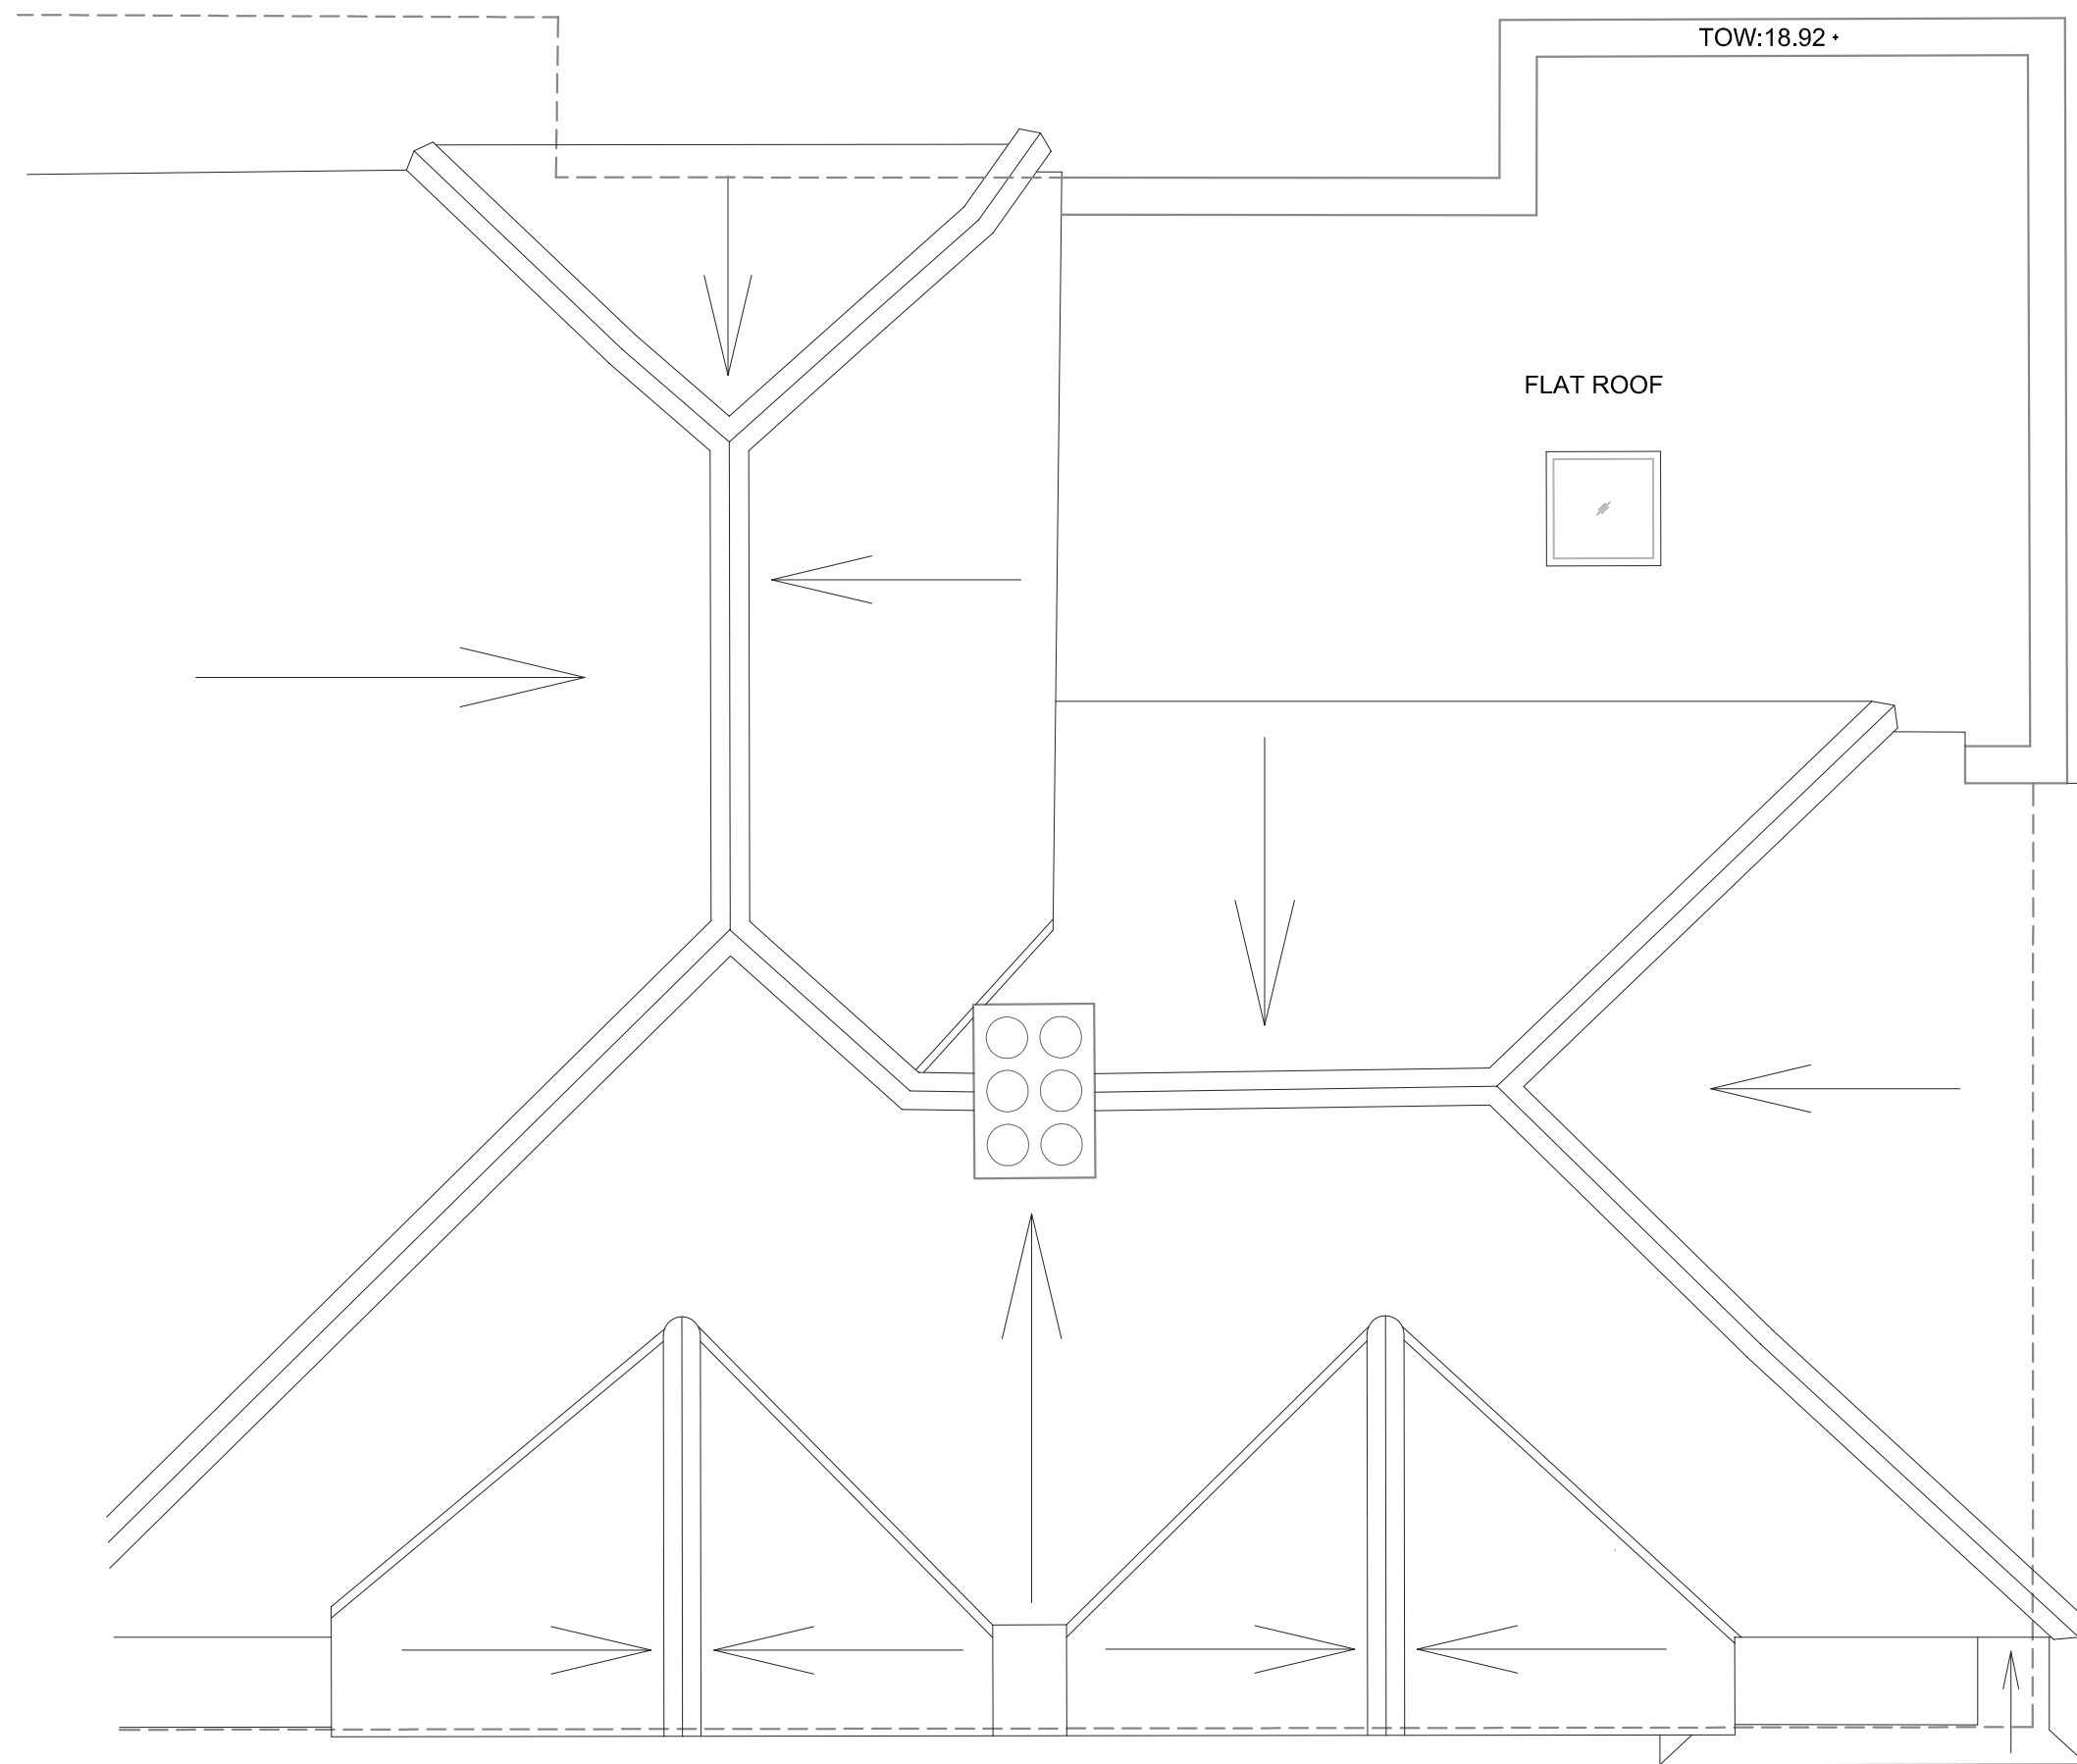

FIT MARK A

FIT MARK B

DO NOT SCALE FROM DRAWING
DO NOT RE-SCALE DRAWING
ALL DIMENSIONS TO BE CHECKED ON SITE

METRO PLANS SURVEYS	
MEASURED BUILDING SURVEY	
LEGEND	
F-C 0.00	FLOOR TO CILL HEIGHT
C-H 0.00	CILL TO HEAD HEIGHT
FD	FLOOR TO CEILING HEIGHT
FL 21.80	FLOOR LEVEL
0.00sp	SPRING HEIGHT
NS	SINGLE STEP HEIGHT
AH	ACCESS HATCH
AHL	ARCH HEAD LEVEL
BLR	BOLLER
BOL	BOLLARD
BM TK	BENCHMARK
BEL	BEAM SOFFIT LEVEL
BSH	BEAM SOFFIT HEIGHT
CAB	CABINET
CATV	CABLE TV
CBD	CUPBOARD
CCTV	CCTV CAMERA
CL	CEILING LEVEL
CNT	COUNTER
CH	CEILING HATCH
CL	CEILING LIGHT
CV	CEILING VENT
DH	DOOR HEIGHT
EAVE.00.00	EAVE LEVEL
EM	ELECTRIC METER
EP	ELECTRICAL POLE
FC	FALSE CEILING
FP	FIRE PLACE
FB	FUSE BOARD
FA	FIRE ALARM
FI	FIRE INDICATOR
FE	FIRE EXTINGUISHER
GM	GAS METER
GP	GATE POST
GV	GAS VALVE
GY	GULLY
IC	INSPECTION CHAMBER
IK	STORM WATER INLET
LP	LAMP POST
MH	MANHOLE
-CL	COVER LEVEL
-IL	INVERT LEVEL
OHC	OVER HEAD CABLE
OHG	OVERHANG
P	POLE
PAR.00.00	PARAMET LEVEL
P&T	POST & TELECOM
PS	POWER SUPPLY
RAD	RADIATOR
RE	RODDING EYE
RS	ROAD SIGN
RWP	RAIN WATER PIPE
RIDGE.00.00	RIDGE LEVEL
SUV	SHELVING
SL	SKYLIGHT
SV	STOP VALVE
SVP	SOIL VENT PIPE
SUS	SUSPENDED CEILING
SW	SWITCH
TOP.00.00	TOP OF FENCE
ToW.00.00	TOP OF WALL
TR	TELEPHONE POLE
WH	WATER HEATER
WM	WATER MAIN
WT	WATER TANK
WV	WATER VALVE
WL	WALL LAMP
WS	WORK SURFACE
BS	SURVEY STATION
TS	TELEPHONE STATION
TREE	TREE
BUSH	BUSH

NOTES

All levels to arbitrary datum

-	-	-	-
-	-	-	-
-	-	-	-
-	-	-	-
-	-	-	-
-	FULL ISSUE	25/05/2016	DC

METRO PLANS
207-211 THE VALE
ACTON
LONDON W3 7OS
TEL NO. + 44 (0) 20 8741 4699
FAX NO. + 44 (0) 20 8741 6442
EMAIL: info@metroplans.com
WEB: www.metroplans.com

LAND & MEASURED BUILDING SURVEYS

CLIENT
VICTORIA SILVER

PROJECT
No.20 MAKEPEACE AVENUE, N6 6QY

SURVEY TYPE
ROOF PLAN

Drawn by	TZ	Scale	1:50 A1
Checked by	DC	Job No.	3768
Date	MAY 2016	Dwg No.	3768-06

No.20 MAKEPEACE AVENUE, N6 6QY
ROOF PLAN