


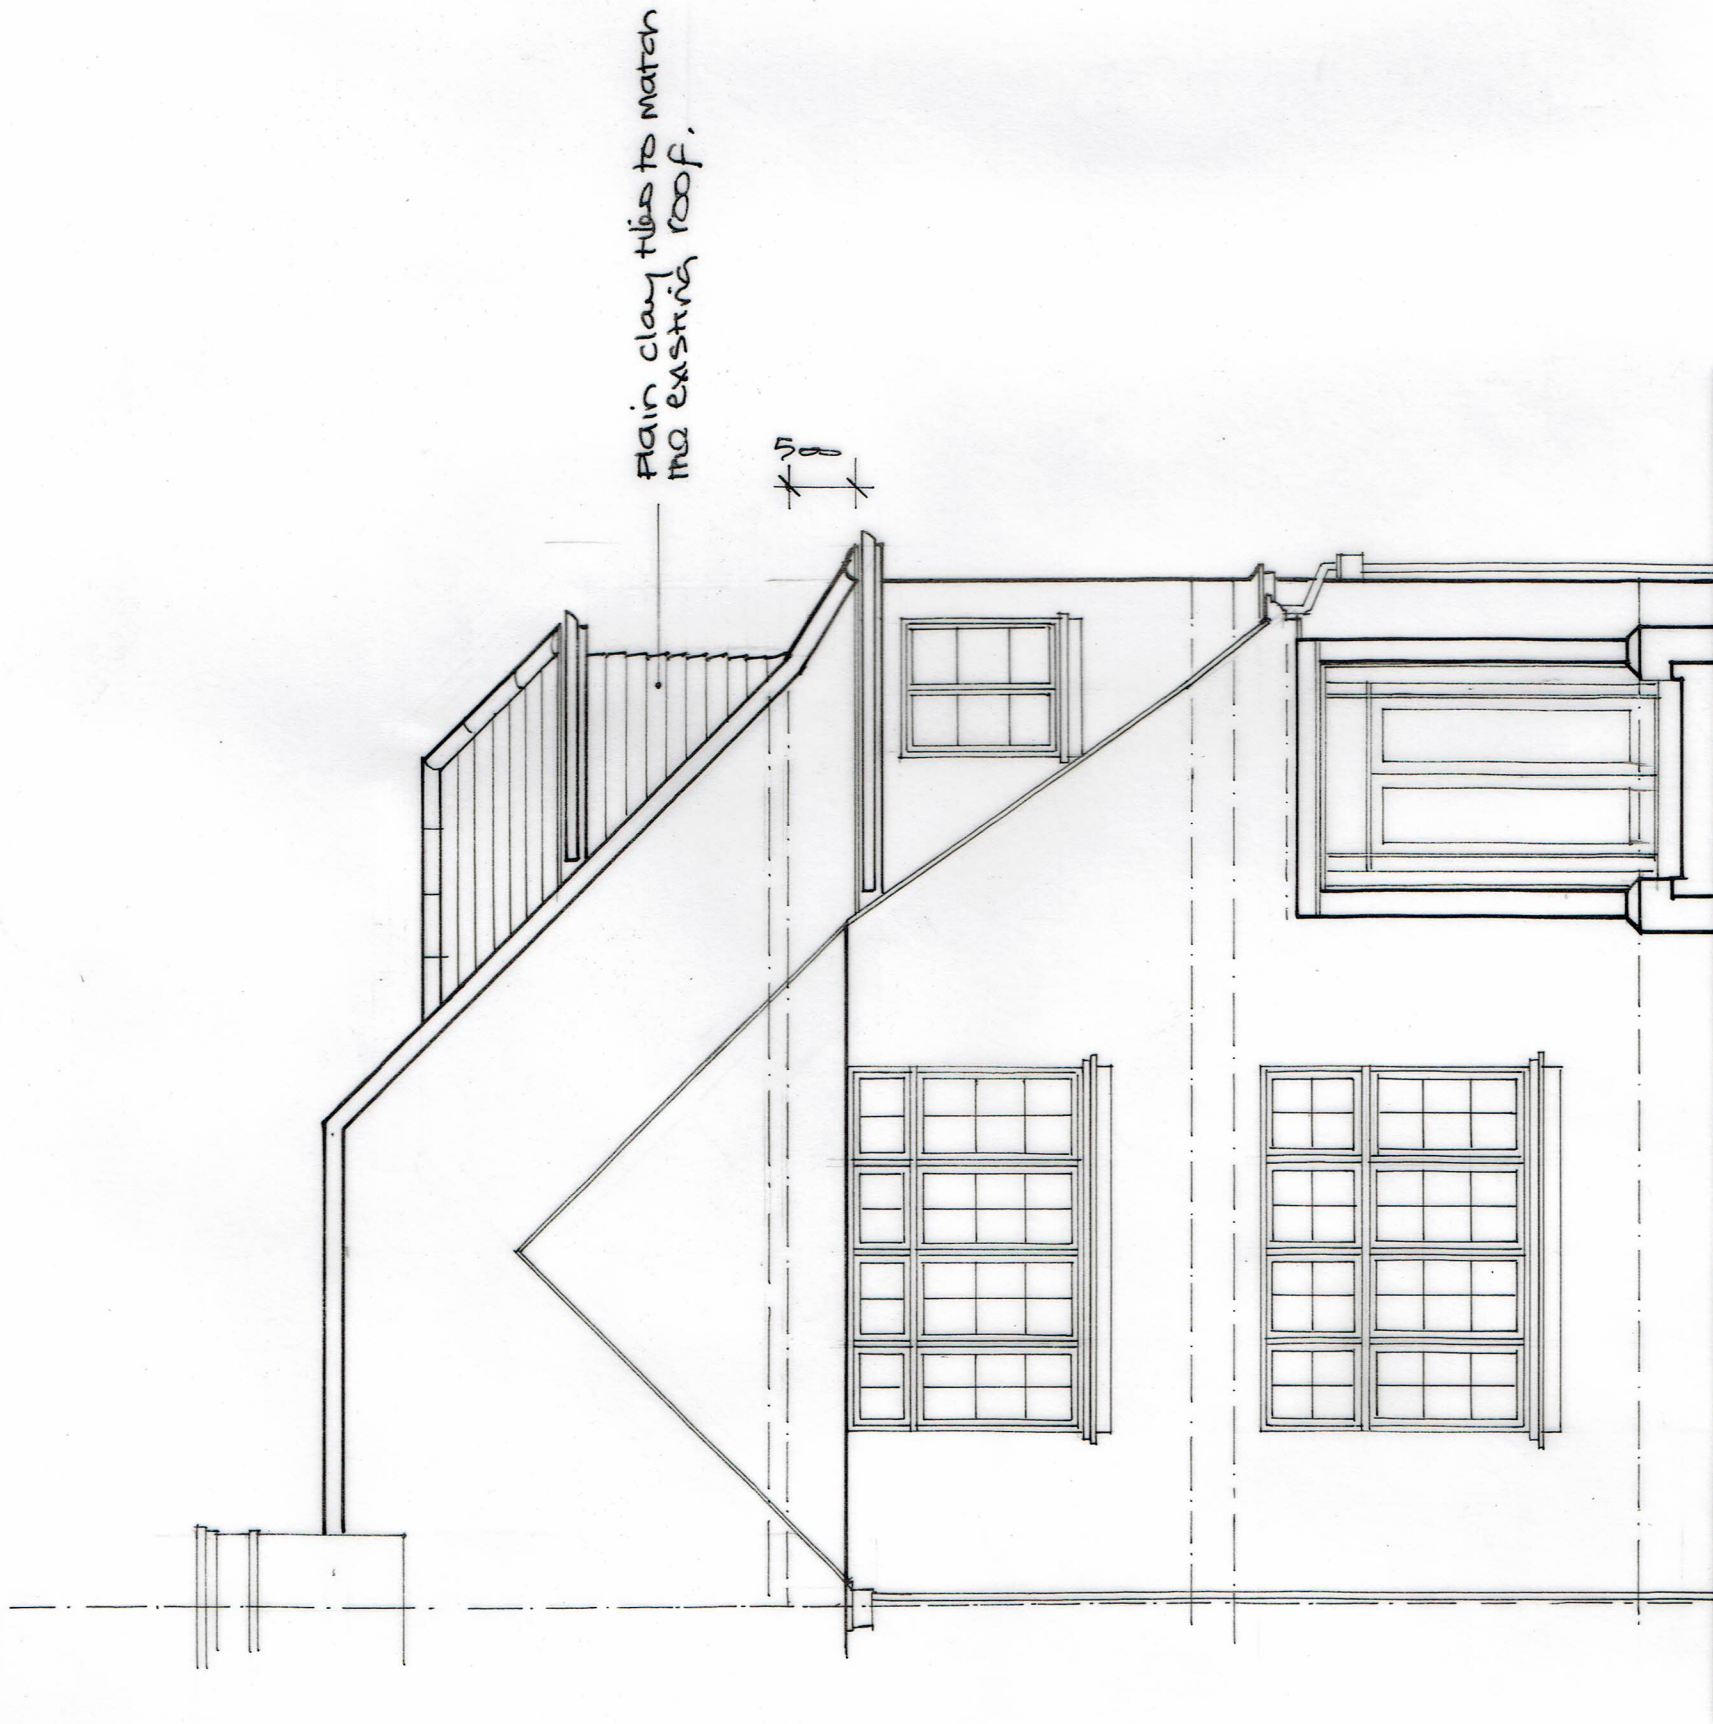

14.06.13 REV A
Planners firm's comments

14 Makepeace Avenue
London
N6 6EJ

Scale 1:50 Date 01-04-2018

Drawing No-15 A

A3 Sheet

J
JASON READ PUGH
Chartered Architectural Technologist
(MCIT ACIOB)

77 MISWELL LANE, TRING,
HERTFORDSHIRE
HP23 4DR
TEL: 01492 891625
MOBILE: 07866 744224
EMAIL: JASON.PUGH@INDOSWEB.COM



Chartered Institute of
Architectural Technologists

FRONT ELEVATION AS PROPOSED 1:50

