


NOTE:
ENSURE NO STRIP OUT, DEMOLITION OR BUILDING WORKS ARE UNDERTAKEN WITHOUT THE REQUIRED LISTED BUILDING AND PLANNING CONSENTS FROM THE LOCAL AUTHORITY.
IT IS AN OFFENCE TO CARRY OUT WORKS THAT REQUIRE LISTED BUILDING CONSENT WITHOUT SUCH CONSENT BEING OBTAINED.

- DRAWINGS TO BE READ IN CONJUNCTION WITH:
- ARCHITECTURAL SCHEDULES AND SPECIFICATIONS.
 - STRUCTURAL DRAWINGS AND SPECIFICATIONS.
 - M&E DRAWINGS AND SPECIFICATIONS.
 - ACOUSTIC REPORTS.
 - FIRE STRATEGY.
 - HERITAGE REPORT.
 - SPECIALIST FACADE REPORT.
 - IT/AV SPECIALIST DRAWINGS AND SPECIFICATIONS.
 - LIFT SPECIALIST DRAWINGS AND SPECIFICATIONS.

THE MAIN CONTRACTOR IS TO SURVEY TEST ACOUSTIC, FIRE AND THERMAL PROPERTIES OF EXISTING WALLS TO DETERMINE INTERNAL LINING REQUIREMENTS.

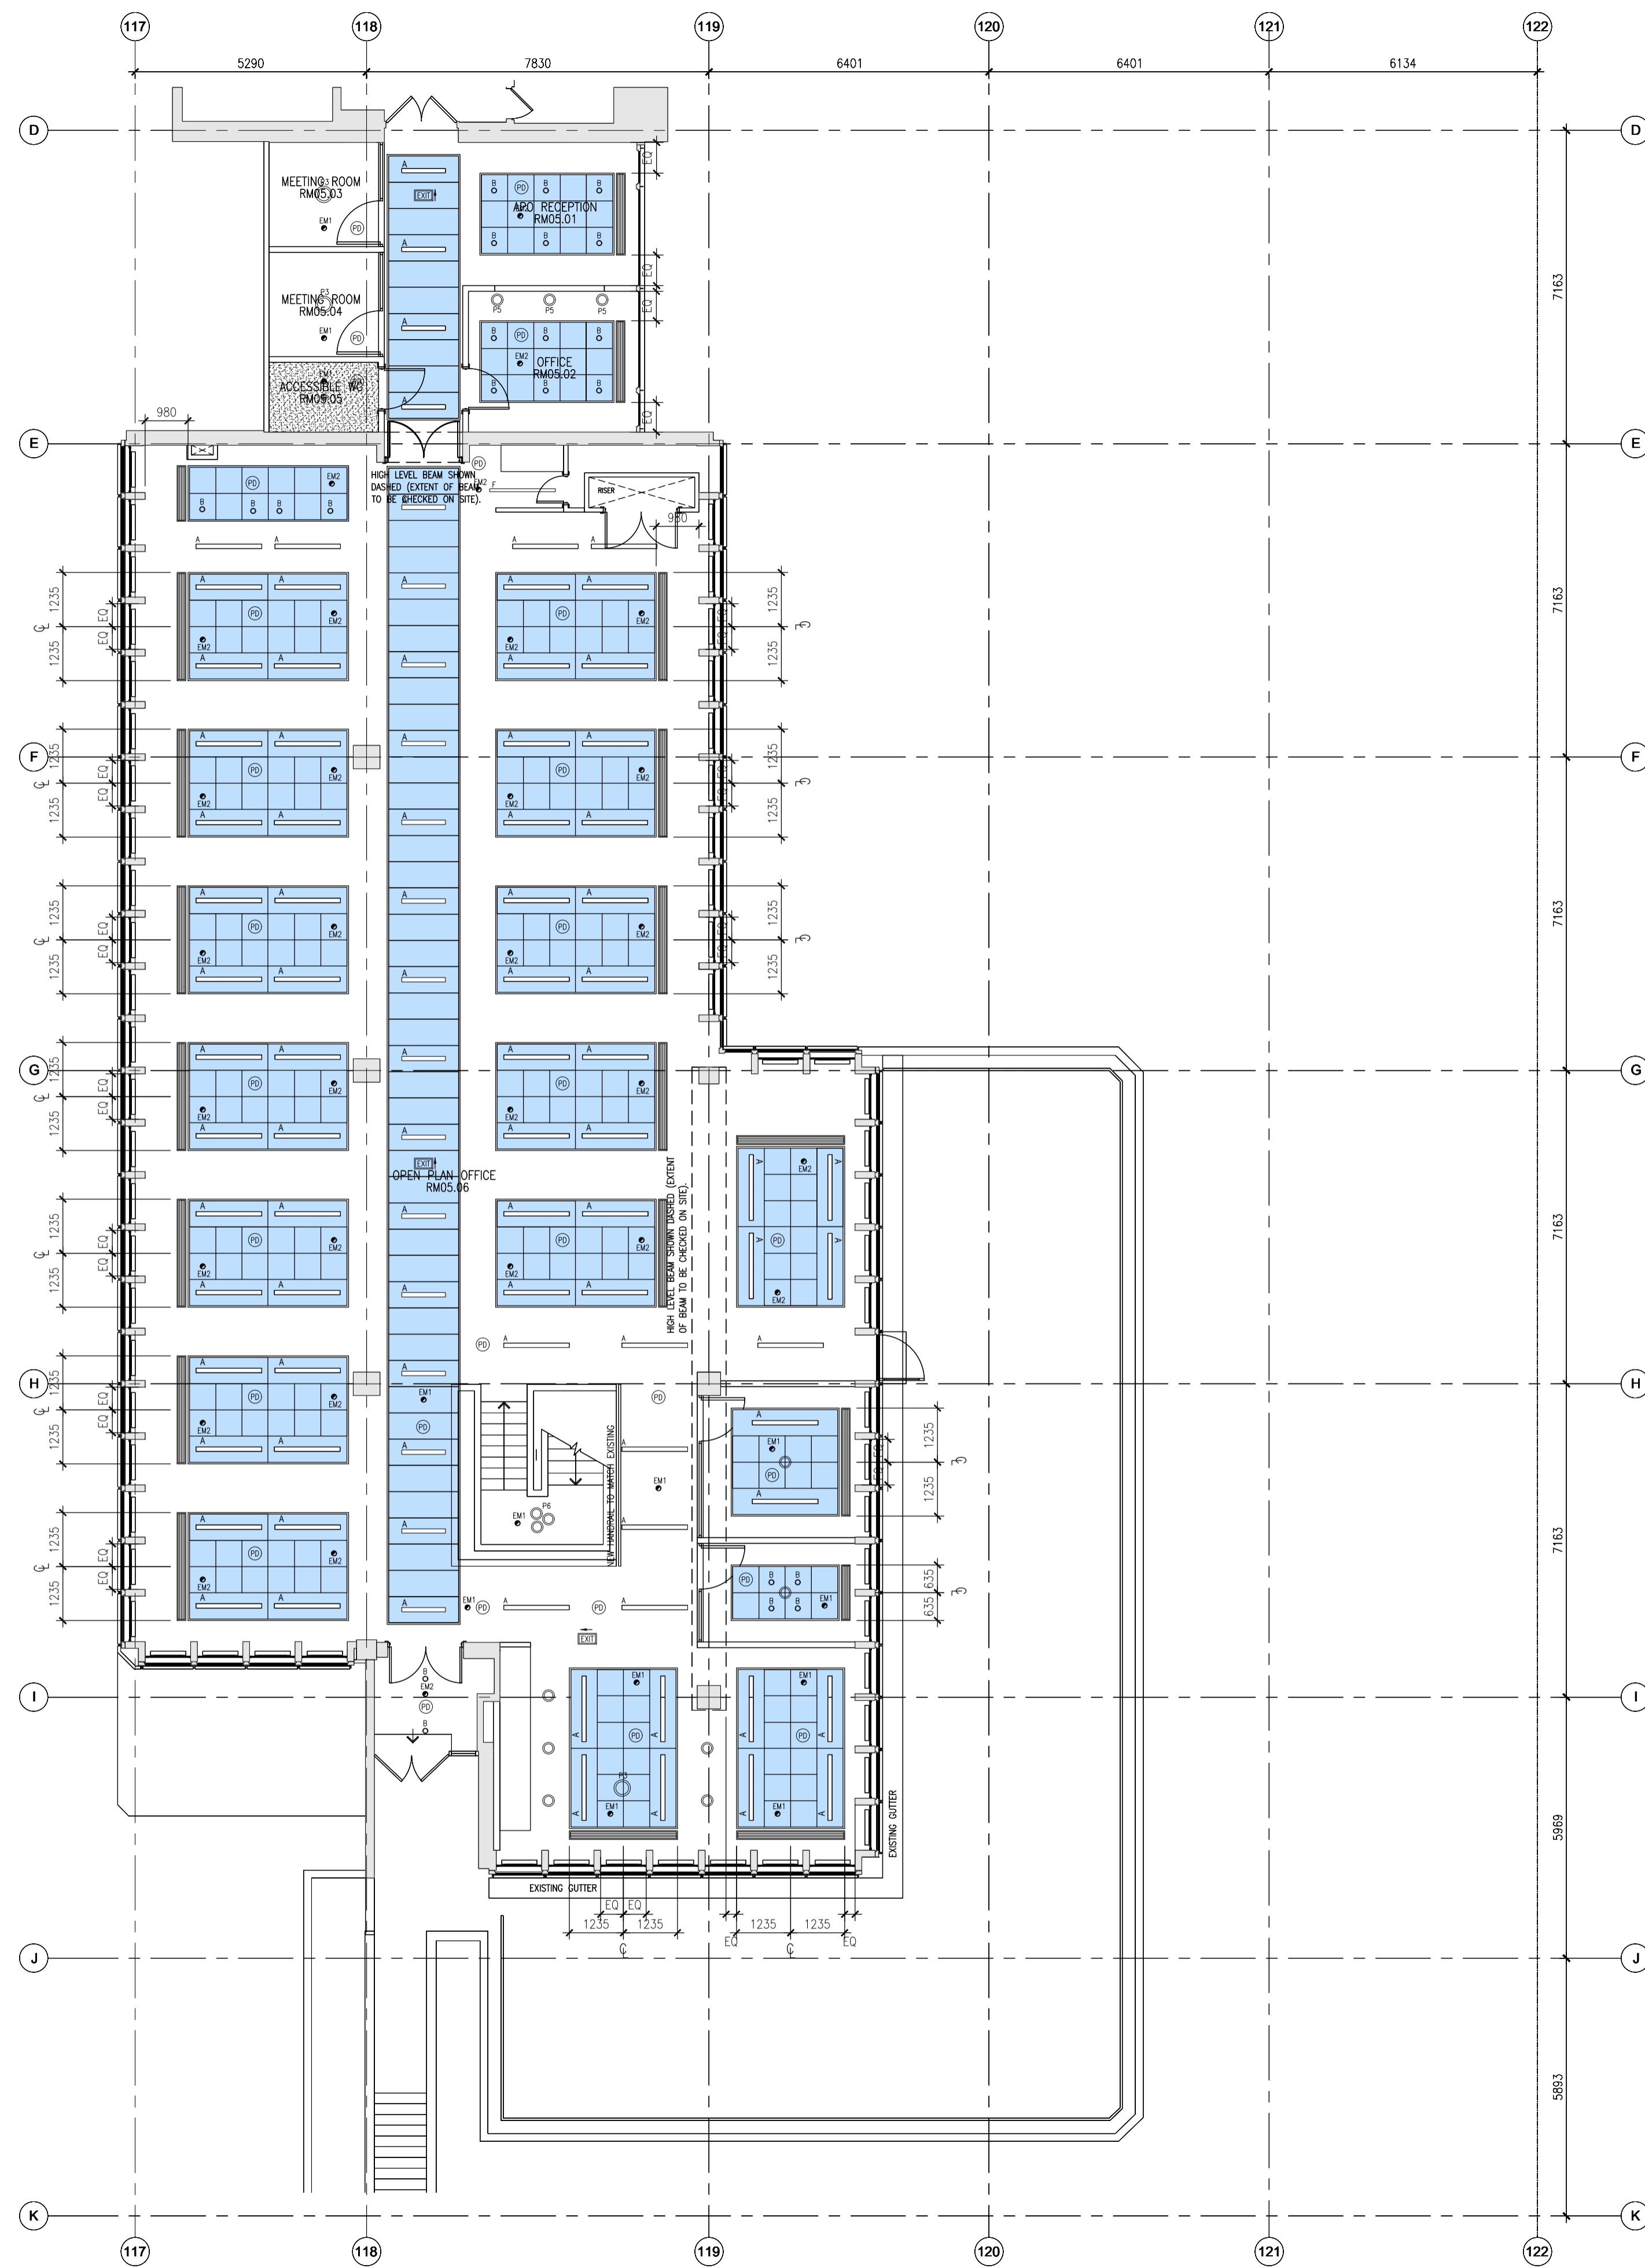

GENERAL NOTES
THIS DRAWING IS THE COPYRIGHT OF MACE DESIGN. DO NOT SCALE THIS DRAWING. ALL DIMENSIONS TO BE CHECKED ON SITE BEFORE ANY WORKS PROCEED.
THE CONTRACTOR IS TO PROVIDE FULL SIZE SETTING OUT DRAWINGS BASED ON THE INFORMATION CONTAINED IN THIS DRAWING FOR THE DESIGNERS APPROVAL PRIOR TO COMMENCING MANUFACTURE.
THIS DRAWING IS ISSUED ON THE CONDITION THAT IT IS NOT REPRODUCED, RETAINED OR DISCLOSED TO ANY UNAUTHORIZED PERSON EITHER WHOLLY OR IN PART WITHOUT THE WRITTEN CONSENT OF MACE DESIGN.
THIS DRAWING SHOULD BE READ IN CONJUNCTION WITH ALL RELATED DRAWINGS AND SPECIFICATIONS. ALL WORK IS TO BE CARRIED OUT IN ACCORDANCE WITH THE APPROPRIATE BUILDING REGULATIONS AND CODE OF PRACTICE WHERE SUCH EXIST AND GENERALLY TO CONFORM WITH GOOD BUILDING PRACTICE.

- RCP LEGEND:
- | SYMBOL | DESCRIPTION |
|---------------------------|--|
| [Grey box] | AREAS OUTSIDE OF SCOPE. |
| [White box] | EXPOSED SOFFIT. PAINTED FINISH. |
| [Patterned box] | CLG-01 PLASTERBOARD SUSPENDED CEILING. |
| [Blue box] | CLG-02 ECOPHON FOCUS DS RAFT CEILING. |
| [Green box] | CLG-03 SAS METAL CEILING TILES. |
| [Yellow box] | CLG-04 ACOUSTIC RAFT. |
| [Red hatched box] | BULKHEAD/LOWELED SOFFIT. HEIGHT TBC ON SITE. |
| [Cross-hatched box] | AREAS OF LIFE SAFETY WORKS. |
| [Line symbol] | LED SLOTLIGHT OR PENDANT. |
| [Circle symbol] | RECESSED LED DOWNLIGHTER. |
| [Circle with dot symbol] | EMERGENCY LIGHT FITTING. |
| [Square with X symbol] | FIRE EXIT SIGNAGE. |
| [Square symbol] | SWIRL DIFFUSER. |
| [Line symbol] | LINEAR GRILLE. |
| [Circle with C1 symbol] | CEILING TYPE. |
| [Circle with 2600 symbol] | NOTIONAL CEILING HEIGHT AFFL. TBC ON SITE. |
| [Circle with C001 symbol] | CEILING FINISH. |
| [Circle with G symbol] | G TYPE LIGHT FITTING. |
| [Circle with PD symbol] | PRESENCE DETECTOR. |
| [Circle with S symbol] | FIRE ALARM SPEAKER. |
| [Circle with SD symbol] | FIRE ALARM SMOKE DETECTOR. |

NOTE:
FOR ALL CEILING FINISH REFERENCES REFER TO FINISHES SCHEDULE UCL-IOE-0100-000-XX-SH-A-40-0001 AND NBS SPECIFICATIONS.

ALL EXISTING EMERGENCY FITTINGS, SMOKE DETECTORS AND PIR'S SUBJECT TO MODIFICATION TO SUIT NEW LAYOUT.

CONTRACTOR TO CHECK LIGHT SETTING OUT ON SITE TO CONFIRM ANY FURTHER WALL CLASHES PRIOR TO CONSTRUCTION.

REFER TO M&E CONSULTANT'S DRAWINGS AND SCHEDULES FOR ALL M&E SYMBOLS & LIGHTING REFERENCES. ALL LEVELS SHOWN NOMINAL AND TO BE CHECKED AGAINST EXISTING LEVELS ON SITE.

REV	DATE	DESCRIPTION	BY
P01	23.05.2018	Issued for information. Stage 4. Rooms retained. APO Reception layout amended.	TP
-	04.05.2018	Issued for information. Stage 3 Update	RA



PROJECT
**UCL IOE PHASE 1B
20 BEDFORD WAY. WC1H 0AL**

CLIENT
UCL IOE

LOCATION
LEVEL 5 WING

DRAWING TITLE
REFLECTED CEILING PLAN

STATUS INFORMATION		SCALE
DRAWN BY	CHECKED BY	1:100 @ A1
TP	RA	DATE
		27.03.2018
DRAWING NUMBER		REVISION
UCL-IOE-0100-WA-05-DR-A-35-0001		P01

