


Lower Ground Floor Plan Scale 1:25 at A1

RUN BELOW GROUND BEFORE PASSING INTO THE PIPEWORK TRENCH

ELECTRICAL SERVICES RUNNING AT HIGH LEVEL WITHIN CEILING VOID

WATER SERVICES PASS INTO TRENCH WITHIN SUB-FLOOR SLAB

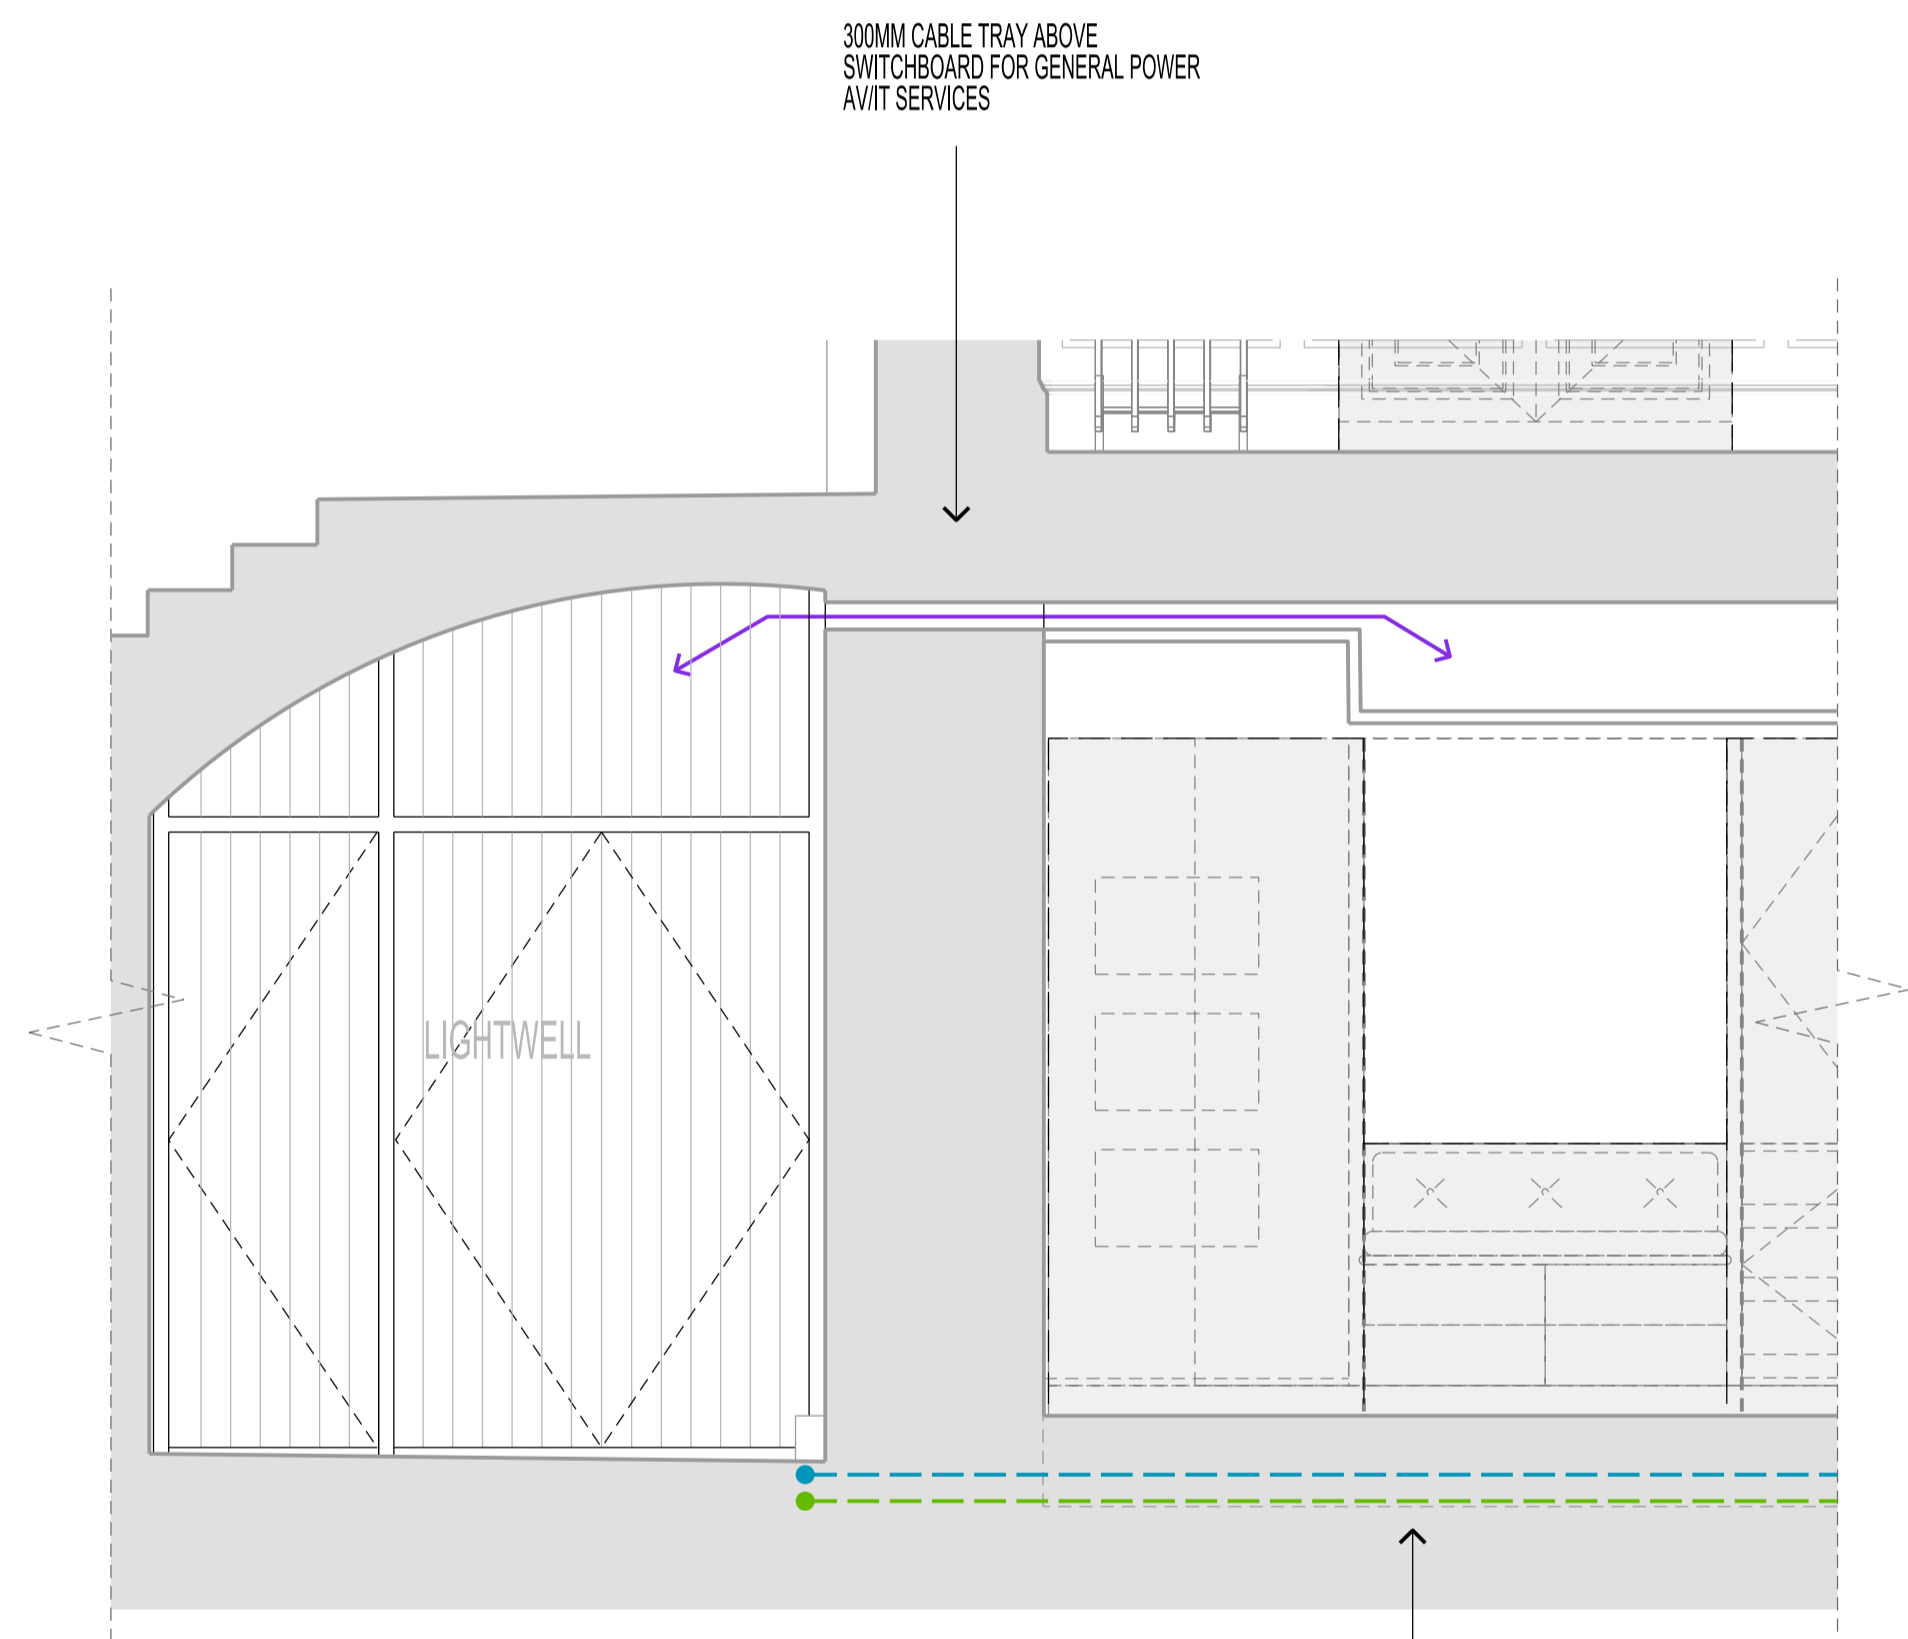

Section A_A Scale 1:25 at A1

WATER SERVICES PASS INTO TRENCH WITHIN SUB-FLOOR SLAB

KEY

- - - - - Cable tray power distribution
- - - - - Softened boosted cold water
- - - - - Potable boosted cold water
- Cable tray for general power, AV/IT services

BUILDING DESIGN PARTNERSHIP LTD SHALL HAVE NO RESPONSIBILITY FOR ANY USE MADE OF THIS DOCUMENT OTHER THAN FOR THAT WHICH IT WAS PREPARED AND ISSUED.

ALL DIMENSIONS SHOULD BE CHECKED ON SITE.

DO NOT SCALE FROM THIS DRAWING.

ANY DRAWING ERRORS OR DIVERGENCES SHOULD BE BROUGHT TO THE ATTENTION OF BUILDING DESIGN PARTNERSHIP LTD AT THE ADDRESS SHOWN.

REVISION / DESCRIPTION	DRAWN	CHECKED	DATE	REVISION / DESCRIPTION	DRAWN	CHECKED	DATE	REVISION / DESCRIPTION	DRAWN	CHECKED	DATE

A- LBC APPLICATION	GP	AC	25.04.2018
- LBC APPLICATION	GP	AC	20.04.2018

PROJECT TITLE	42 BEDFORD SQUARE
PROJECT NUMBER	P2005698
DRAWING TITLE	LOWER GROUND FLOOR PLANT SERVICES ENTRY POINT
DRAWING NO.	(15)AD104

16 Brewhouse Yard
Clerkenwell
London, EC1V 4LJ
United Kingdom

T +44 (0)20 7812 8000
F +44 (0)20 7812 8399
www.bdp.com

BDP.

PROJECT TITLE	42 BEDFORD SQUARE
PROJECT NUMBER	P2005698
DRAWING TITLE	LOWER GROUND FLOOR PLANT SERVICES ENTRY POINT
DRAWING NO.	(15)AD104
SCALE @ A1	1:25
DATE	04.2018
REVISION	A