


M&E equipment to be confirmed by specialist

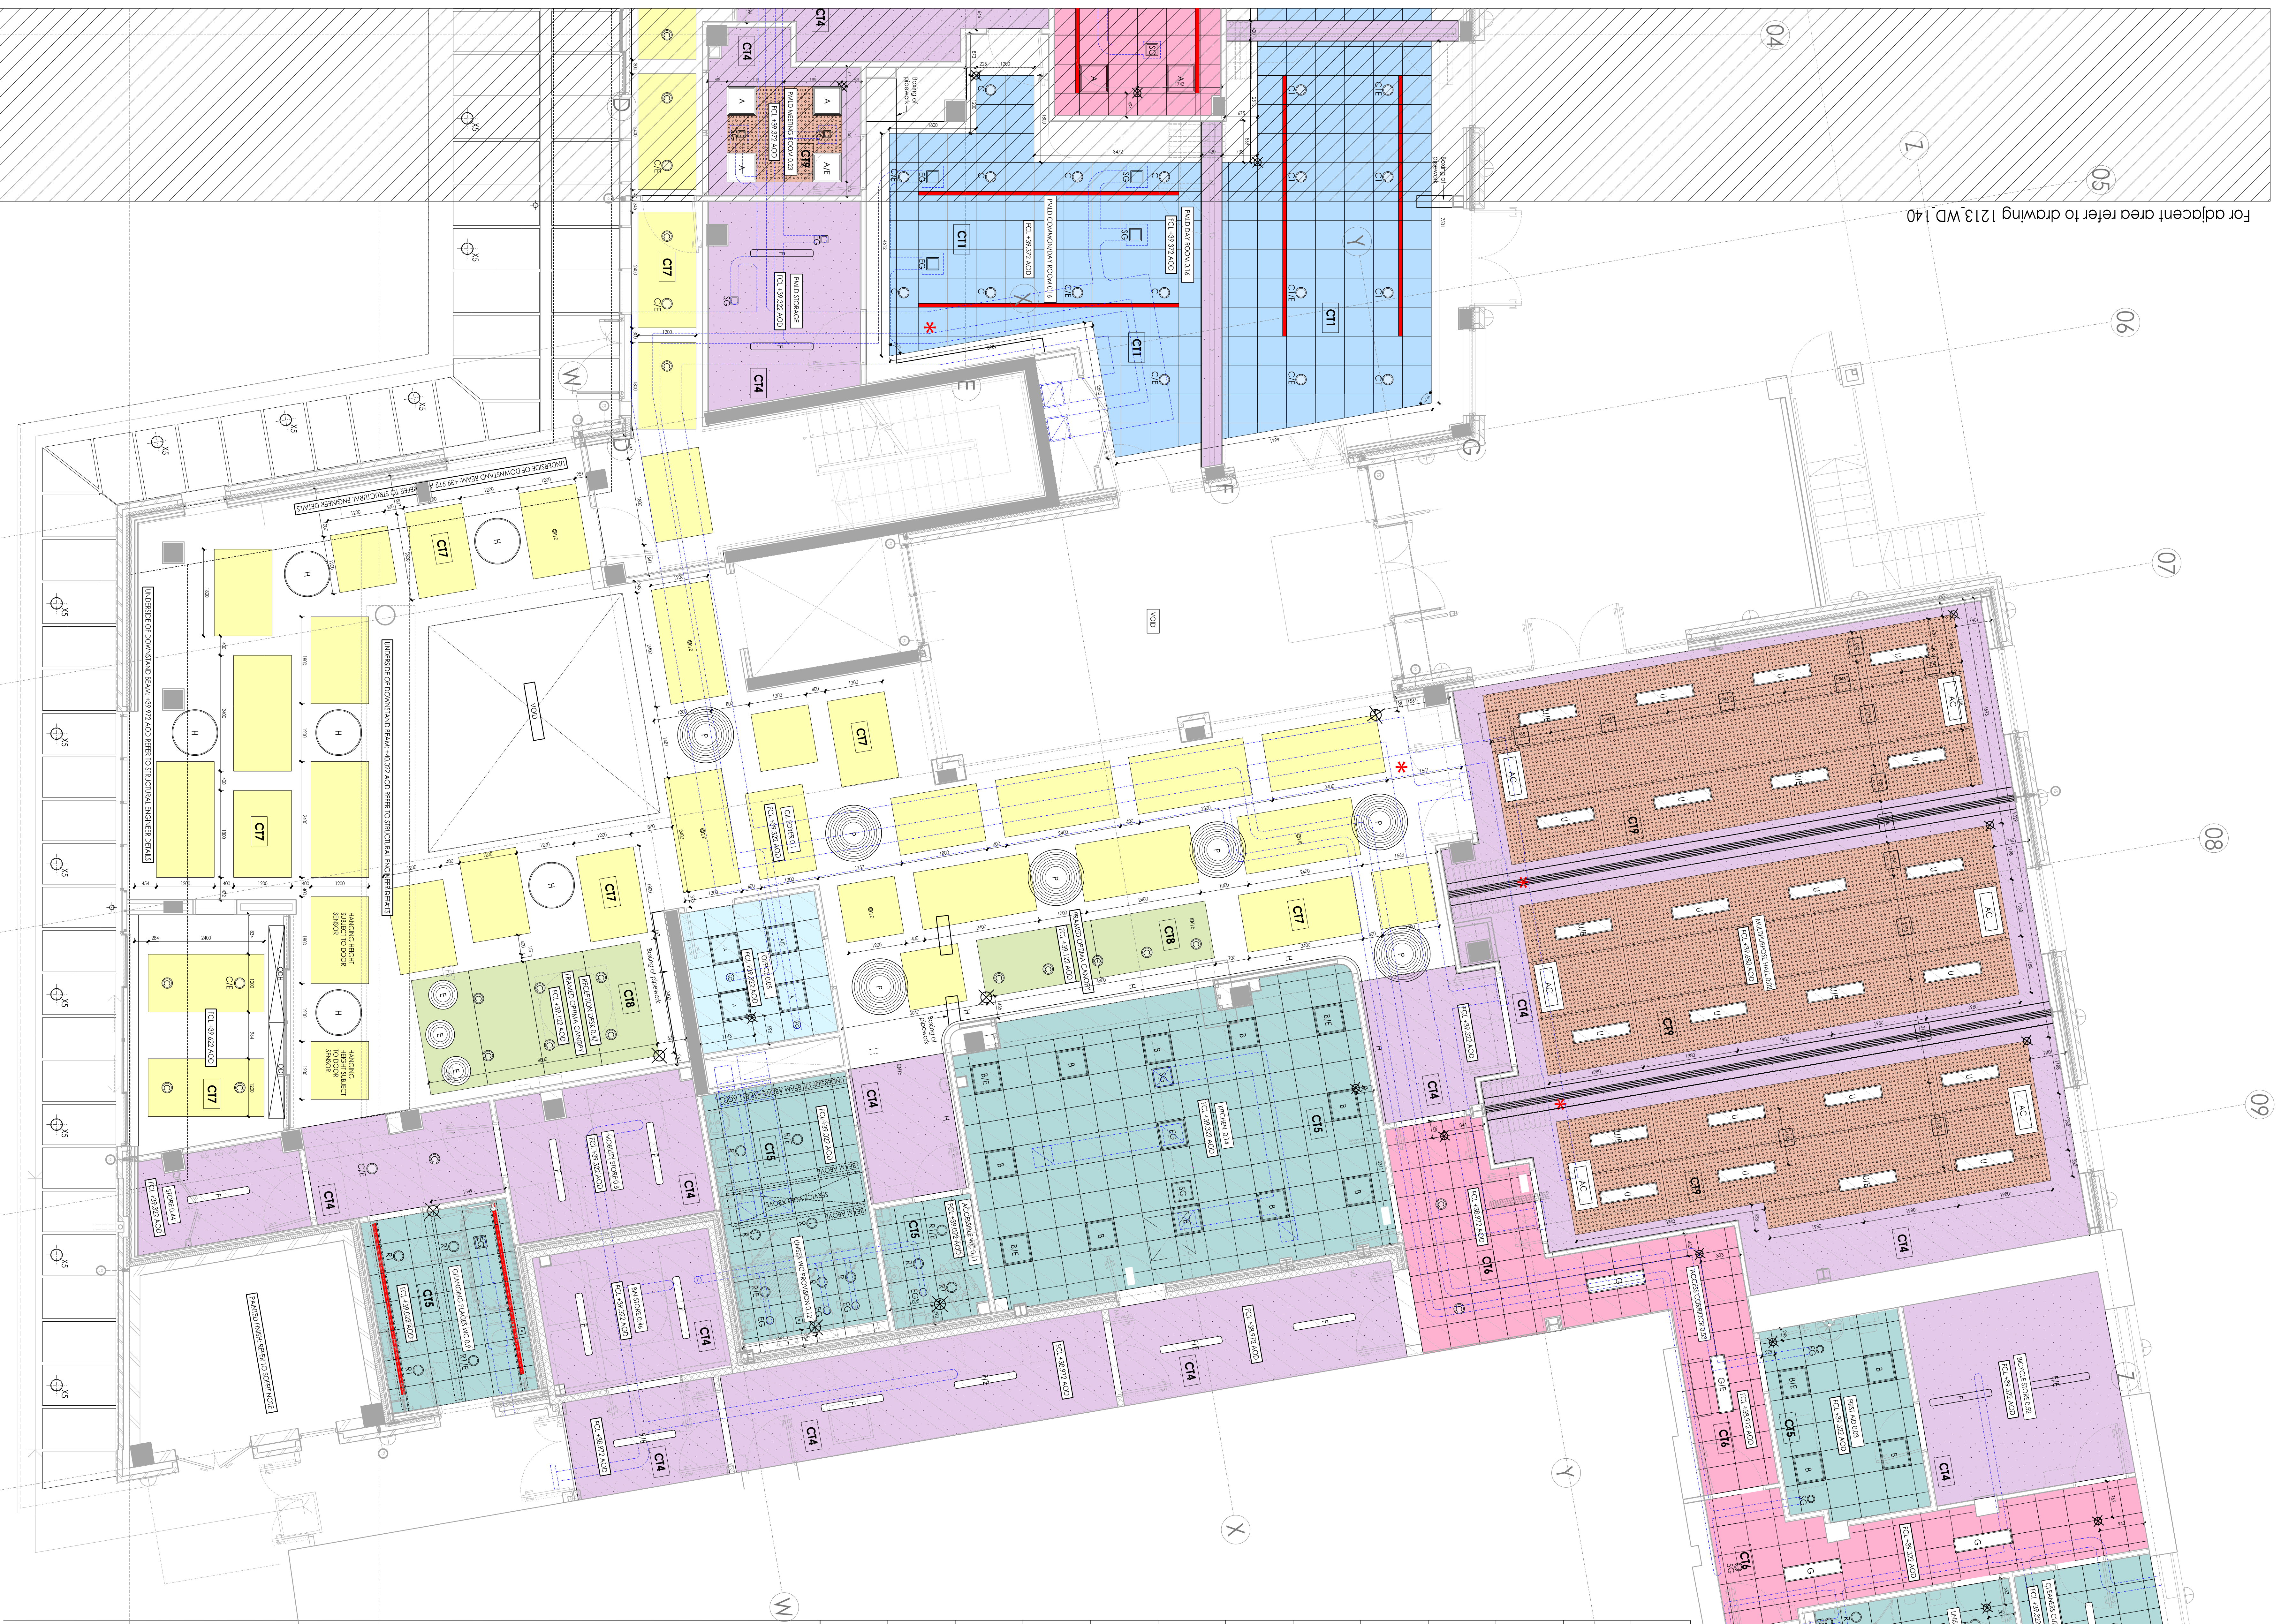

For adjacent area refer to drawing 1213.WD.140

For adjacent area refer to drawing 1213.WD.140

KEY
CEILING TYPES

- CT1: Armstrong Axiom C** suspended canopy system. Exposed concrete ceiling to perimeter to allow for positive cooling. 600 x 600 Ultimec+ Vector ceiling tile.
- CT2: Armstrong Axiom C** suspended ceiling system. No exposed perimeter. 600 x 600 Ultimec+ Vector ceiling tile.
- CT3: Armstrong Axiom C** suspended canopy system. Exposed concrete ceiling to perimeter to allow for positive cooling. 600 x 600 Ultimec+ Vector ceiling tile.
- CT4: Flatboard**
- CT5: Armstrong Hydroboard** ceiling system. Preclude 24 corrosive resistant suspended ceiling system with 600 x 600 Armstrong Hydroboard ceiling tiles.
- CT6: Proprietary suspended ceiling system:** with 600 x 600 Ultimec+ ceiling tiles.
- CT7: Armstrong Optima Canopy:** Independently suspended preformed acoustic canopy. 1200 x 1200/1800/2400
- CT8: Feature Armstrong Optima Canopy:** Multiple connected Optima Canopy panels with concealed aluminium frame system for lowered ceiling.
- CT9: Acoustic Flatboard:** Ceiling M&E system with Reglone 12/20/66 boards.

Radiation:
 Ceings under steel deck roof to receive 100mm Rockwool Fibre Insulation

Host Trunk location:

Indicative position of **ceiling fixing eyes** for window maintenance. Position & sizing to be confirmed by manufacturer.

ELECTRICAL / VENTILATION REFER TO SPECIALIST M&E DRAWINGS FOR DETAILS

- Sealing out position
- Extract Cable (Varying types)
- Supply Cable (Varying types)
- Ventilation Ductwork: Refer to M&E drawings for detailed information.
- Drainage locations: Refer to M&E drawings for detailed information.
- Beam locations: Refer to Structural Engineers drawings for detailed information.
- Recessed LED Light panel
- Recessed LED Light panel
- Recessed LED Downlight
- 1/8 Denolux Emergency luminaire
- Feature pendant lamp
- Dust & Moisture resistant LED
- Recessed LED Light panel
- 1/8 Denolux Emergency luminaire
- Feature pendant lamp
- Linear LED separable strip light
- Suspended LED globe light
- Suspended LED Light
- Suspended dome pendant
- Recessed LED Lights
- LED Emergency lighting
- Suspended Fluoresc LED
- Dislodged Alarm pull cord

- External Recessed Light
- All Conditioning Unit
- Overhead Door Header

GENERAL NOTE:

For detailed location & sizing of beams refer to structural engineers drawings.

For electrical & ventilation layouts and specifications refer to specialist M&E drawings. Access hatch locations in non-pendant ceiling locations to be confirmed by M&E engineers.

Location of disabled alarm pull cords (indicated by 'D' shown), to be positioned in relation to disabled WC layouts.

M&E drawings to be updated to locations marked with an 'X' to avoid ceiling clashes.

RC SOFFIT NOTE:
 * Generally: Where ceiling soffits are visible on room margins or spaces between canopies they will receive 1 coat of paint or dust sealer and an additional 2 further coats, colour RBC by client.
 Sub-note: Ceiling to receive 2 coats of white emulsion for dust proofing

PCIKO 3, 5, 8, 10, 12, 998, 1000

GREENWOOD CENTRE
 Ground Floor
 Retailed Ceiling Plan
 (2 of 2)
 CONSTRUCTION
 DATE: 15/04/24
 DRAWN: 2017/24
 CHECKED: JF
 PROJECT: 1213.WD.141