




existing
photographs
scale nts

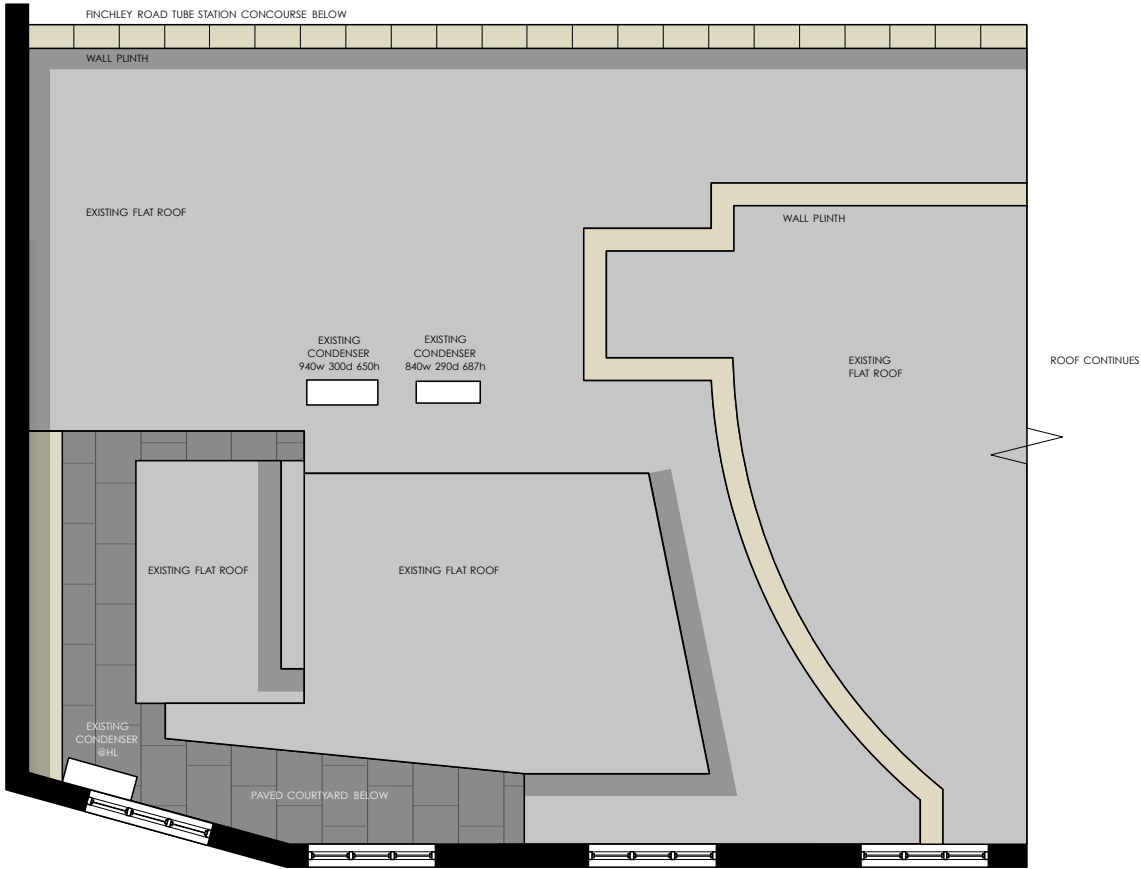

existing
HVAC roof plan
scale 1:100

	CLIENT ★ PRET ★		<div>01M2M3M4M5M10M</div> <div>SCALE 1:100METRES</div>		<div>NORTH</div>	All dimensions to be confirmed on site by Contractor. Structural works to be confirmed by Structural Engineer. All elements to comply with statutory requirements.
	PROJECT FINCHLEY ROAD 219 FINCHLEY ROAD LONDON NW3 6LP		TITLE existing roof layout			
	DRAWING No. TD18-PM93-S1.3		REVISION .	DATE 20.06.18	SCALE @ A3 1:100	
						Tannerdesign