


This drawing is to be read in conjunction with all relevant specifications and drawings issued. For discrepancies or omissions contact Mobile CAD Surveying Solutions Ltd prior to work commencing. The contractor is to check and verify all building and site dimensions and levels before work commences.

© COPYRIGHT Mobile CAD Surveying Solutions Ltd 2017


DO NOT SCALE THIS DRAWING - CHECK ALL DIMENSIONS ON SITE

Note:
Areas drawn indicatively noted and indicated by grey dashed line as line below

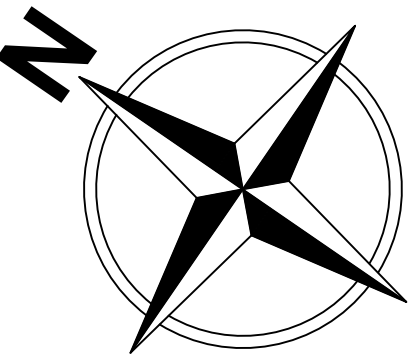


Compass Note:
Geographical orientation indicated is for indicative purposes only.

Abbreviations Key:					
I/C	-	Inspection Chamber	GAS	-	Gas Supply
M/H	-	Manhole	ES	-	Electrical Supply
G	-	Drainage Gully	PO	-	Post Office
CD	-	Channel Drain	CATV	-	Community Antenna
RE	-	Rodding Eye		-	Television
RWP	-	Rain Water Pipe	TSSU	-	Traffic Light Signals
S+VP	-	Soil & Vent Pipe	T.P	-	Telegraph Pole
WM	-	Water Meter	B.	-	Bollard
ST	-	Stop Tap	L.P.	-	Lamp Post
SV	-	Stop Valve			
FH	-	Fire Hydrant			
IL	-	Invert Level			
BT	-	British Telecoms			

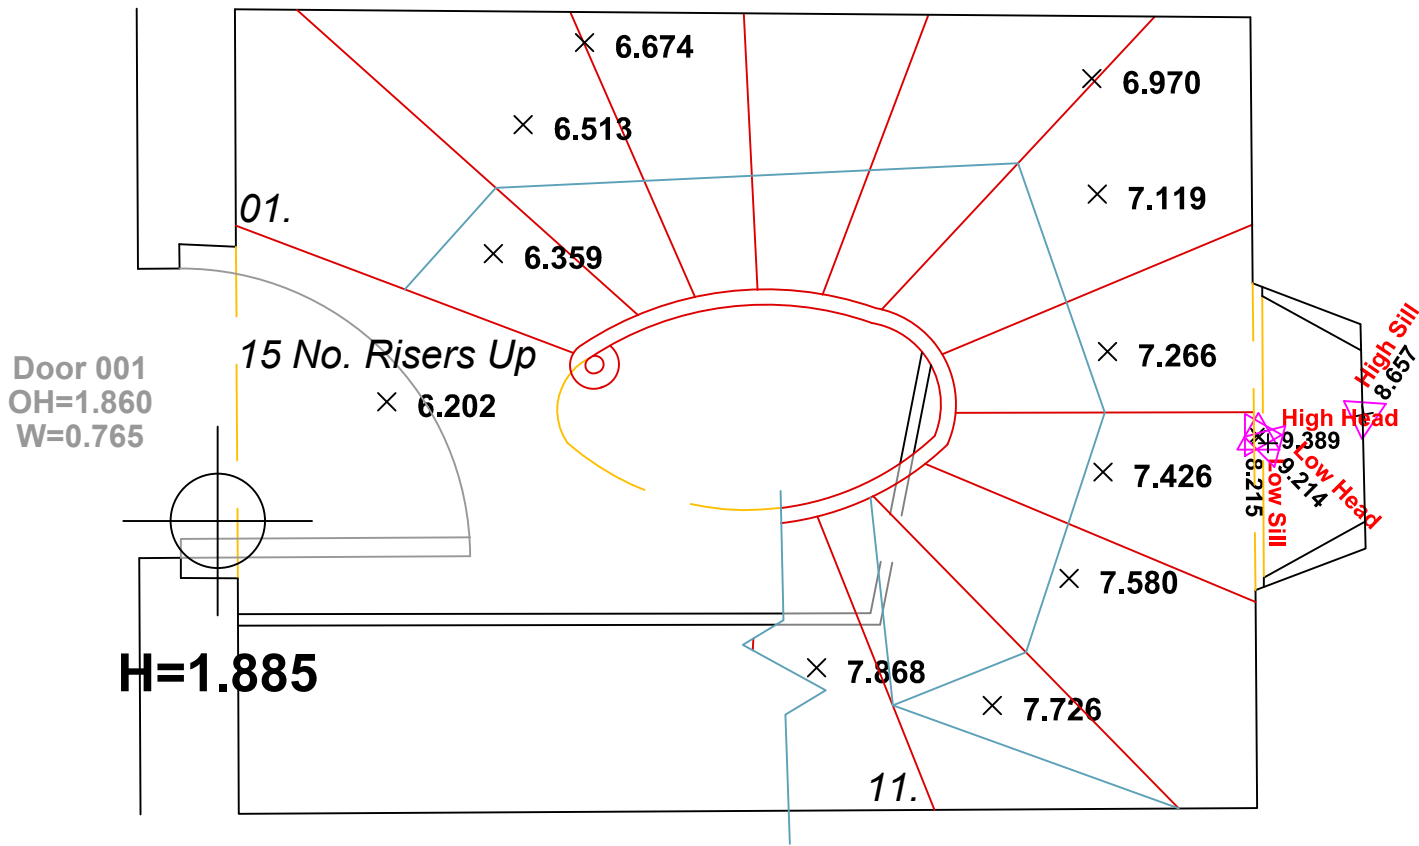


Basement

1:20 Scale

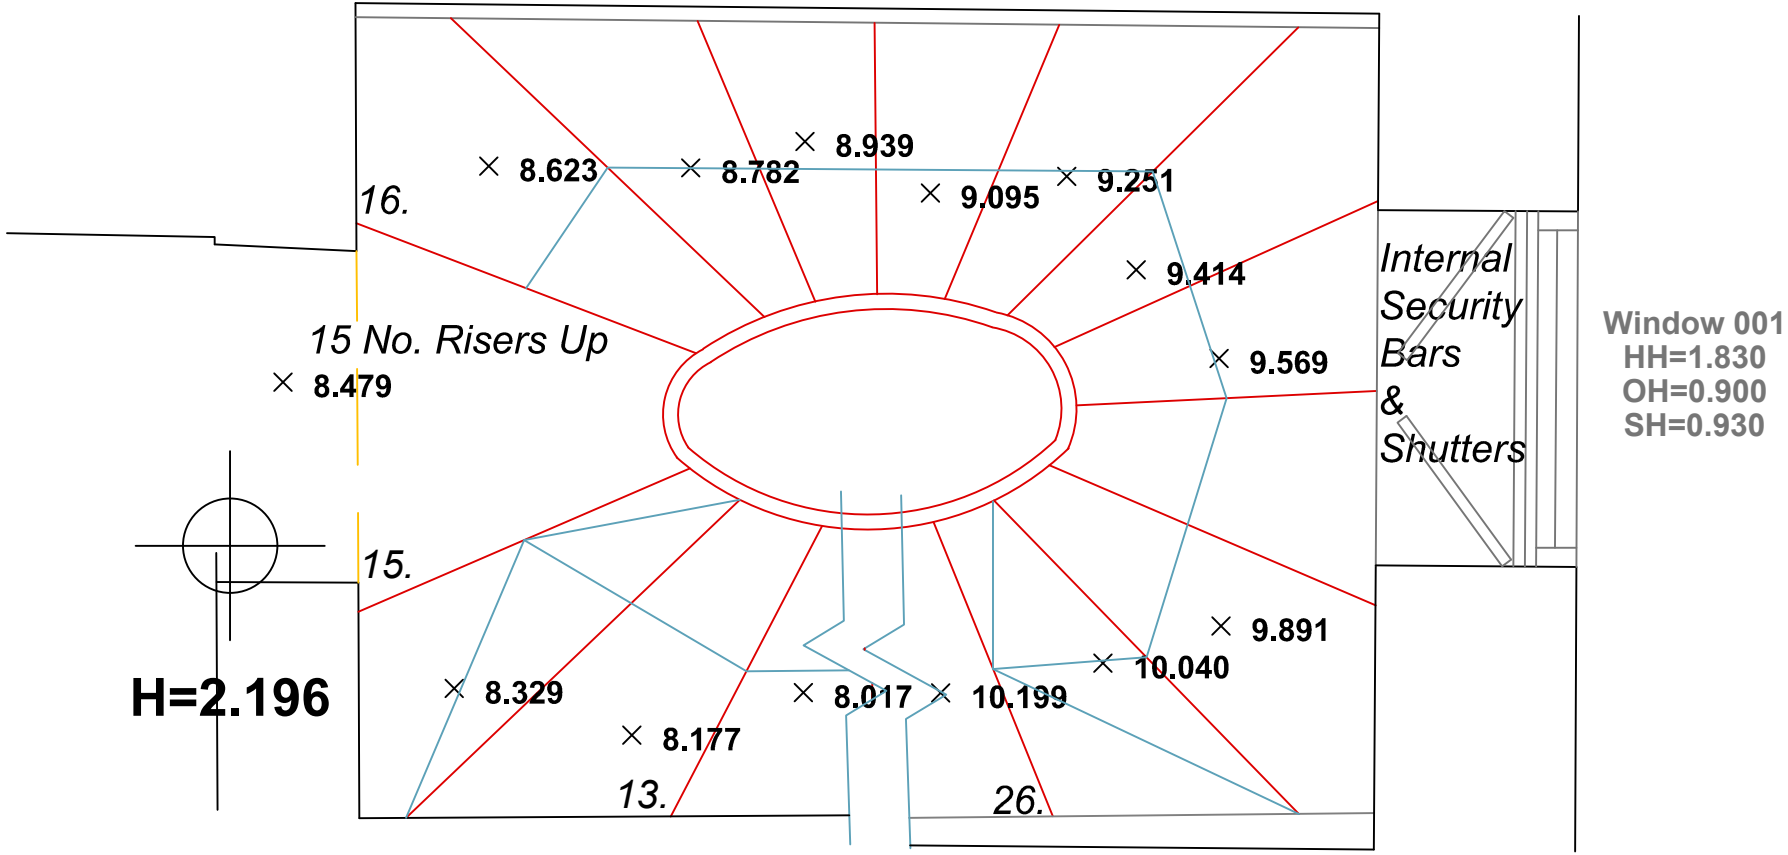


Lower Ground Floor

1:20 Scale

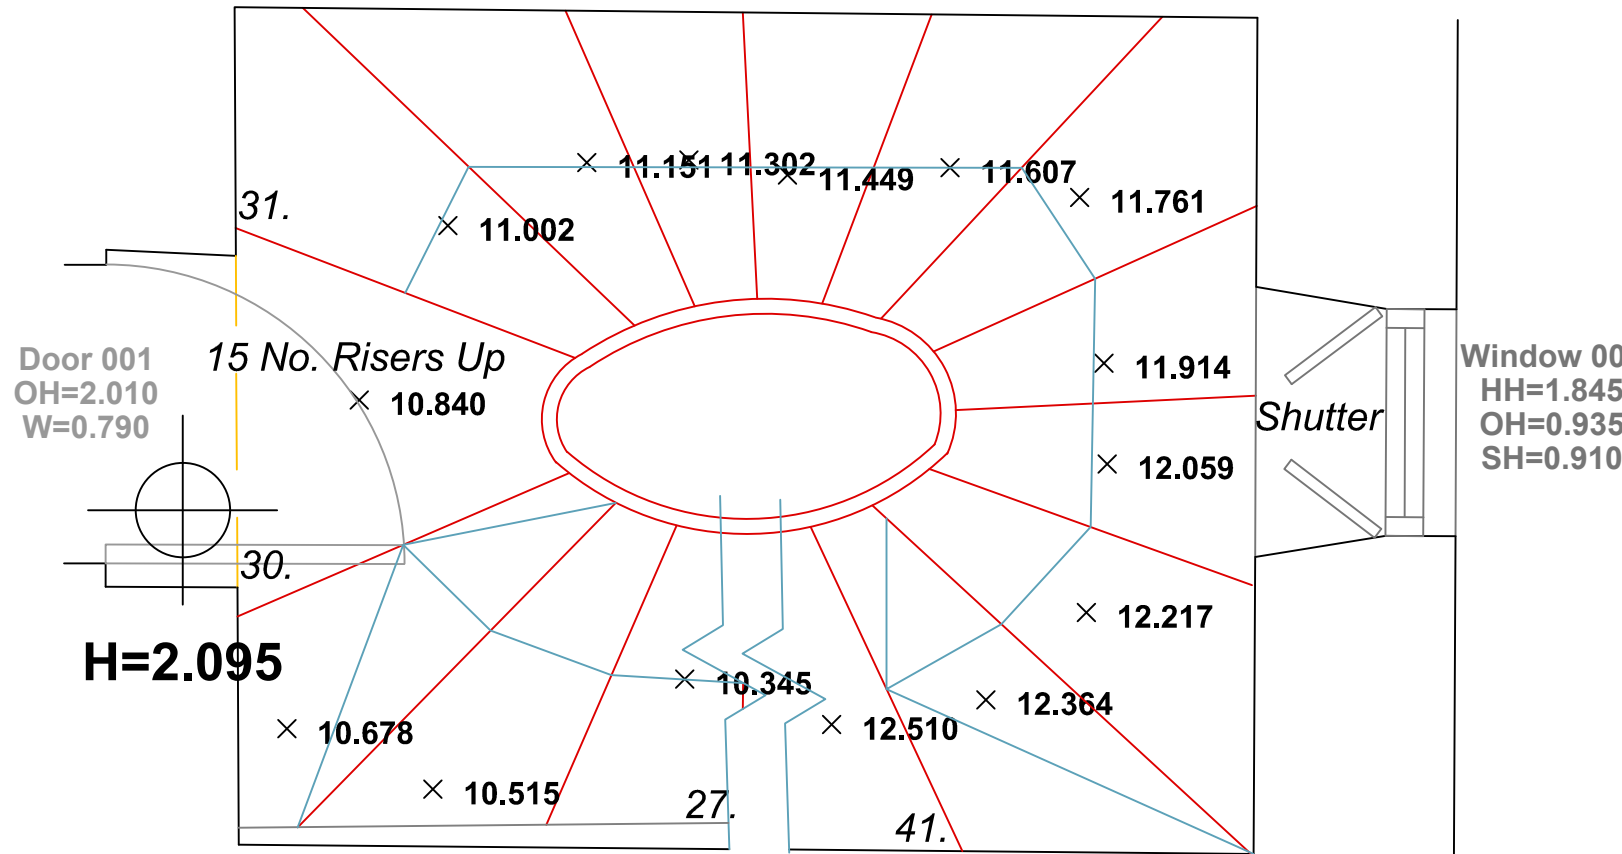

Ground Floor

1:20 Scale

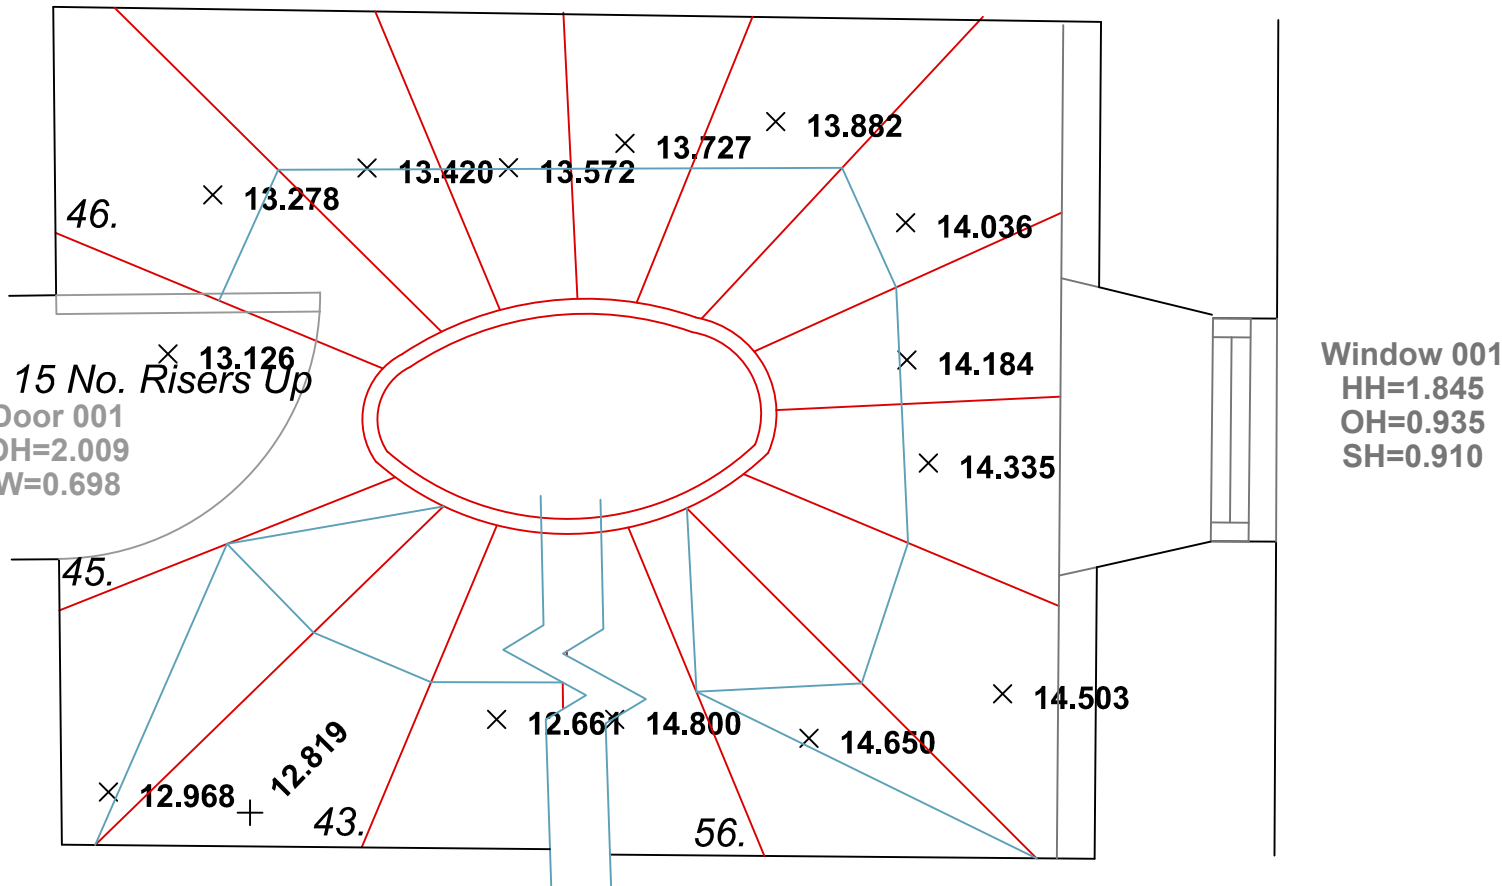

Ground - 1st Mezzanine

1:20 Scale

Rev	Date	Amendments
-----	------	------------



www.mobiledcadsurveying.co.uk
surveys@mobcad.co.uk
Pontefrac Head Office:
Unit 11, 2 Harropwell Lane
Pontefrac
West Yorkshire
WF8 1QY
01977 525 076

London Office:
Kemp House
152 - 160 City Road
London
EC2V 2NX
020 3188 1197

Project: Measured Building Survey

Address: 66 Lincoln Inn Fields,
London,
WC2A 3LH

Drawing No: 1878 - 01

Drawing Title: Basement - Mezzanine Floor Plans

Drawing Date: January 2017

Drawing Size: Scale as Shown @ A1


Drawn By: JH Checked By: JW Issue

This drawing is to be read in conjunction with all relevant specifications and drawings issued. For discrepancies or omissions contact Mobile CAD Surveying Solutions Ltd prior to work commencing. The contractor is to check and verify all building and site dimensions and levels before work commences.

© COPYRIGHT Mobile CAD Surveying Solutions Ltd 2017

DO NOT SCALE THIS DRAWING - CHECK ALL DIMENSIONS ON SITE


Note:
Areas drawn indicatively noted and indicated by grey dashed line as line below

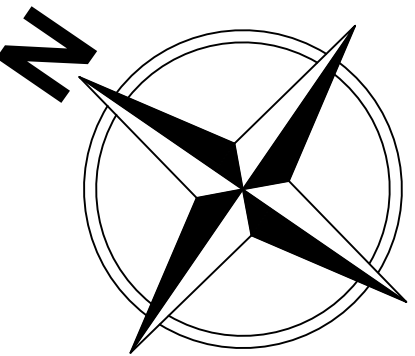

Compass Note:
Geographical orientation indicated is for indicative purposes only.


Abbreviations Key:

I/C - Inspection Chamber	GAS - Gas Supply
M/H - Manhole	ES - Electrical Supply
G - Drainage Gully	PO - Post Office
CD - Channel Drain	CATV - Community Antenna
RE - Rodding Eye	Television
RWP - Rain Water Pipe	TSSU - Traffic Light Signals
S+VP - Soil & Vent Pipe	T.P - Telegraph Pole
WM - Water Meter	B. - Bollard
ST - Stop Tap	L.P. - Lamp Post
SV - Stop Valve	
FH - Fire Hydrant	
IL - Invert Level	
BT - British Telecoms	

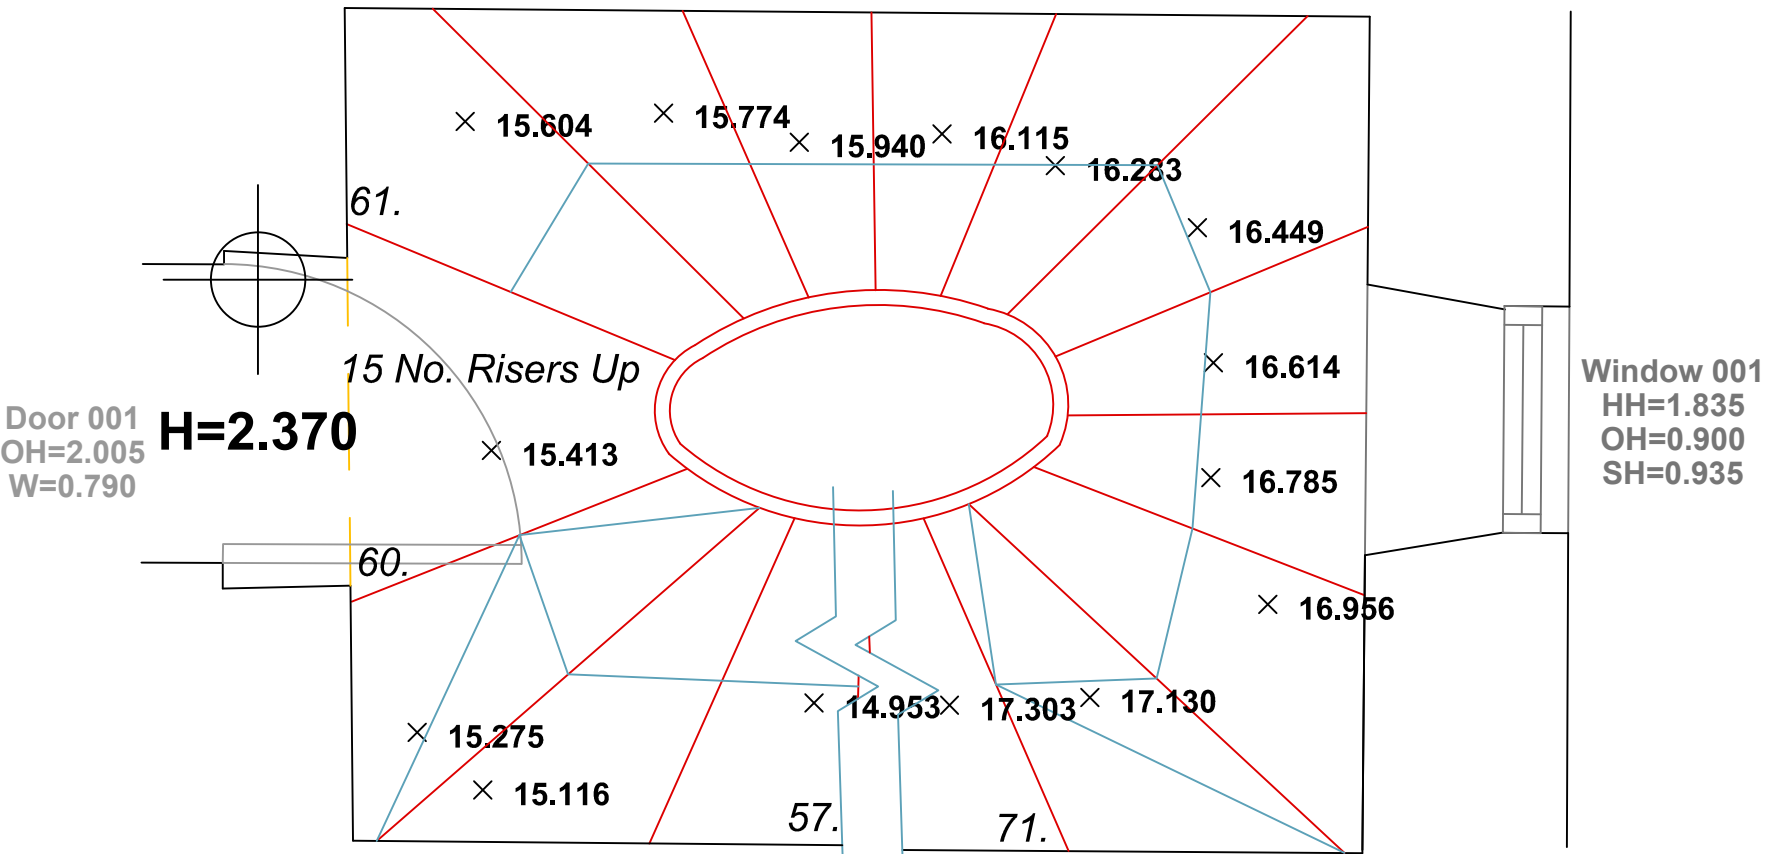


First Floor

1:20 Scale

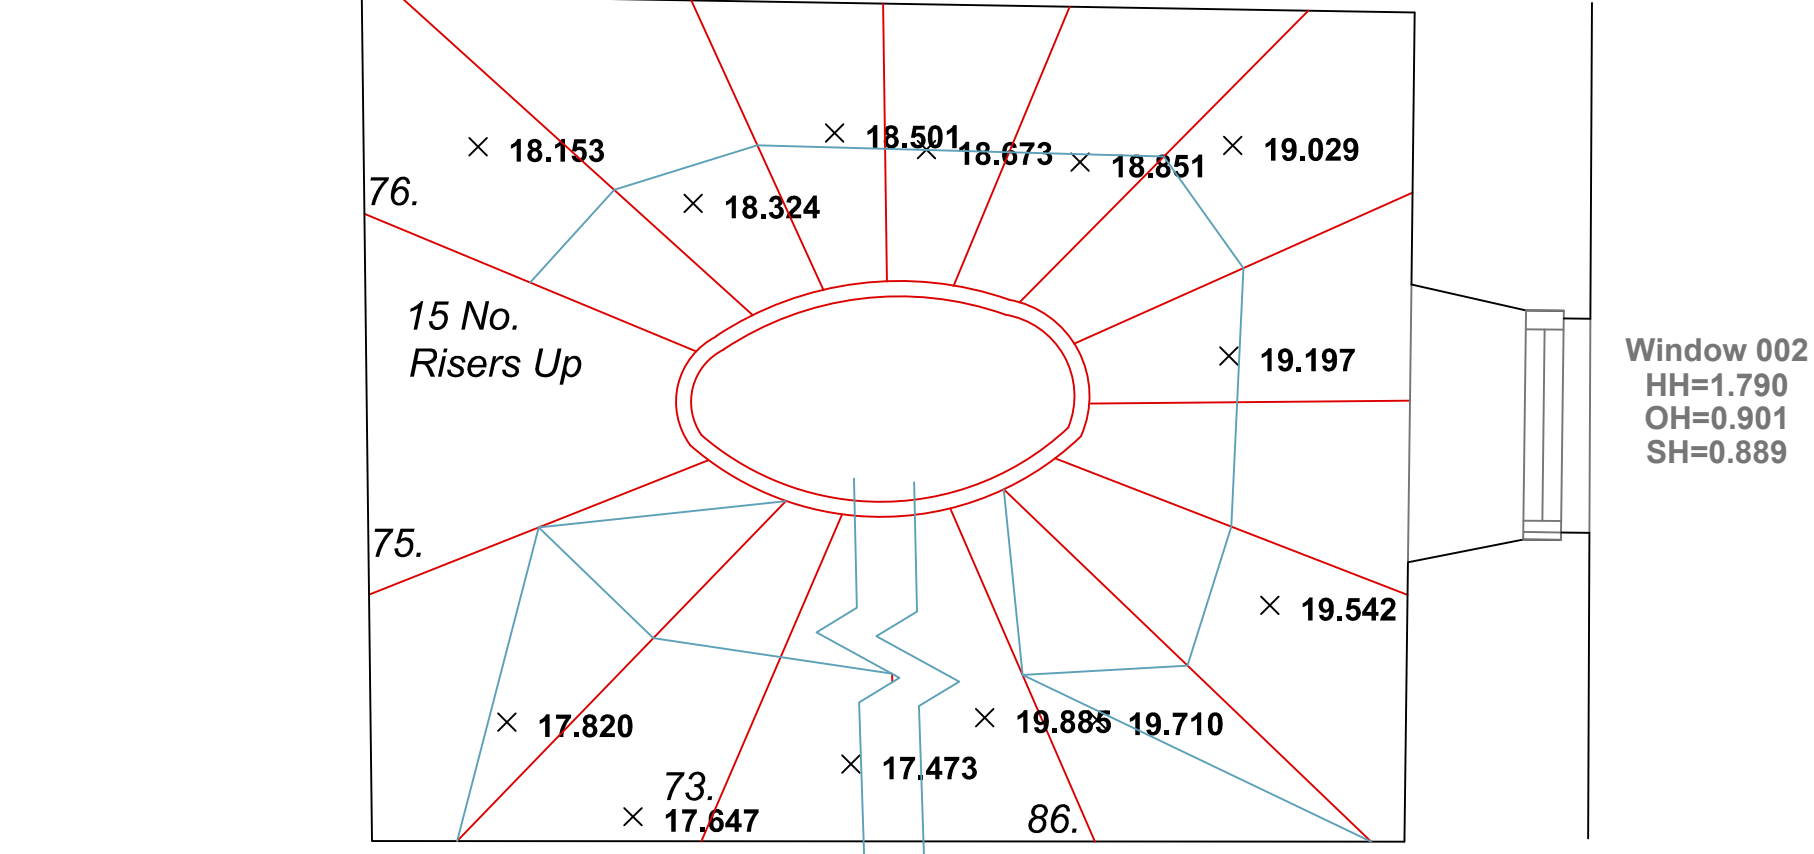


1st - 2nd Mezzanine

1:20 Scale

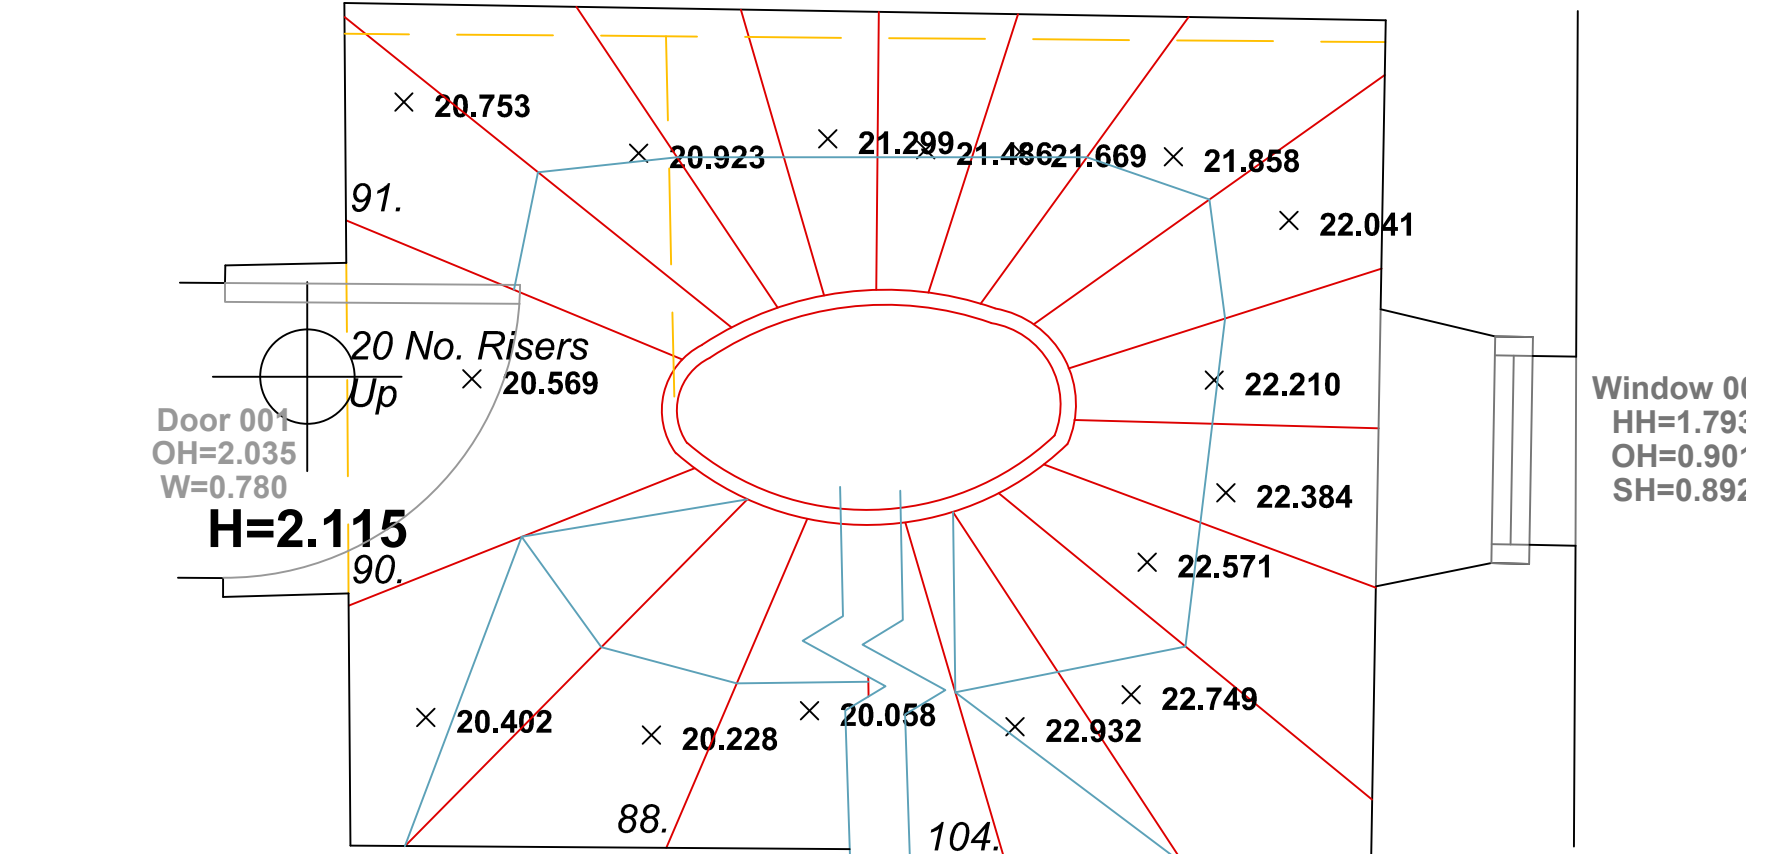

Second Floor

1:20 Scale

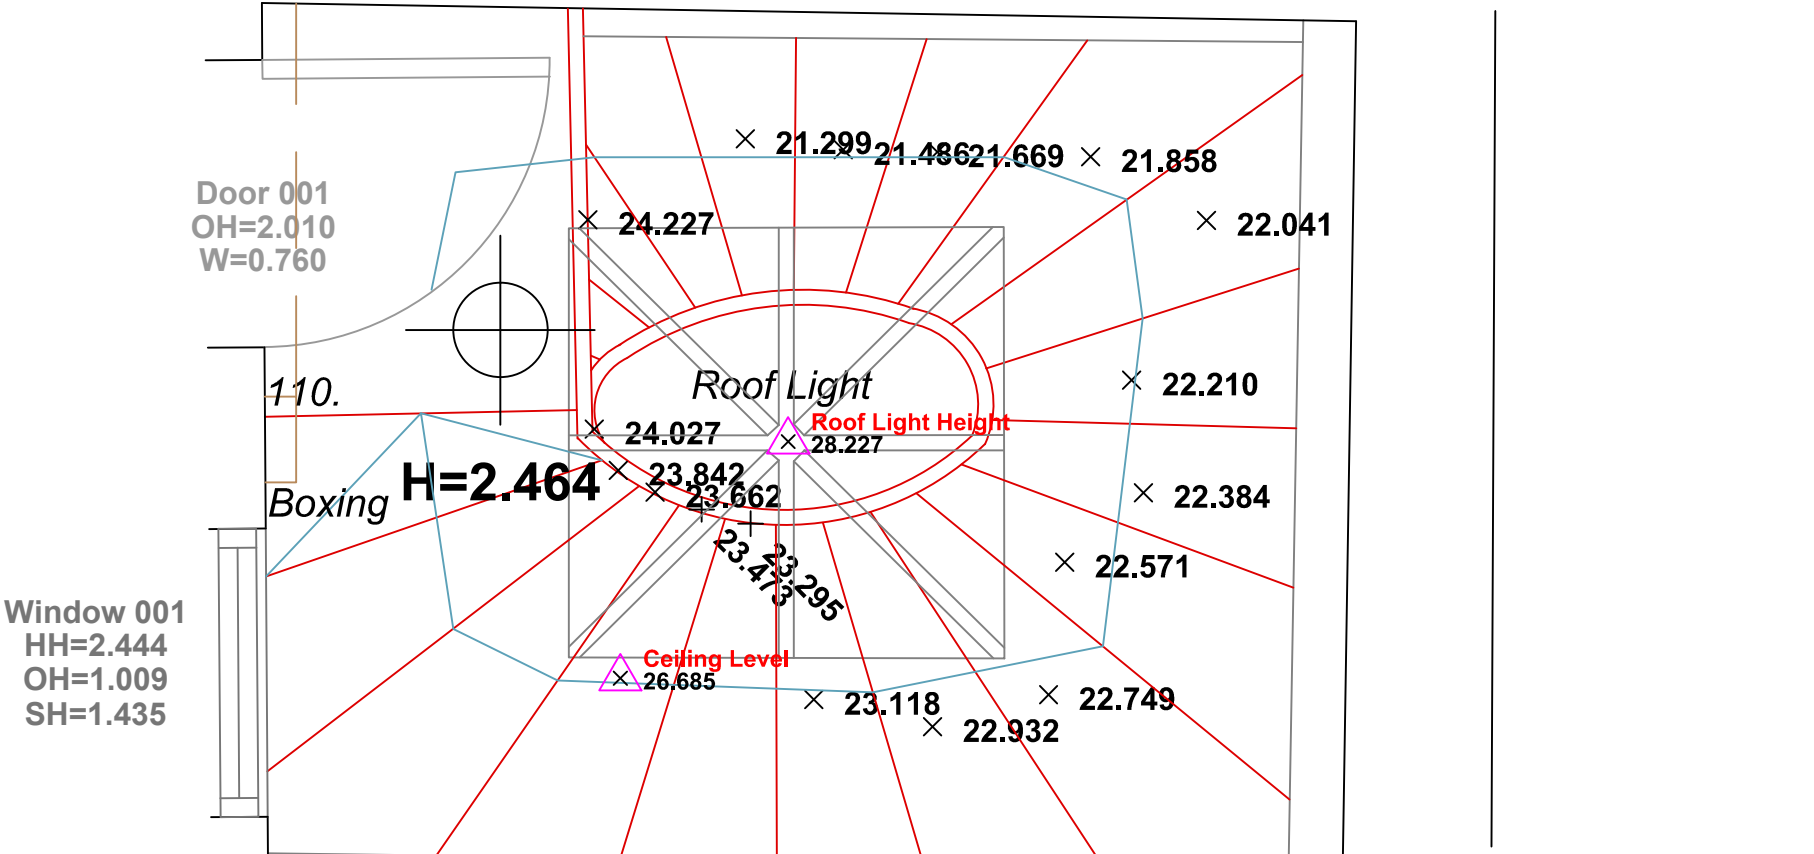

Third Floor

1:20 Scale

Rev	Date	Amendments
-----	------	------------

Mobile CAD Surveying office & on site...™

www.mobiledcadsurveying.co.uk
surveys@mobcad.co.uk

Pontefract Head Office:
Unit 11, 2 Hamopwell Lane
Pontefract
West Yorkshire
WF8 1QY
01977 525 076


London Office:
Kemp House
152 - 160 City Road
London
EC2V 2NX
020 3198 1197

Project:	Measured Building Survey
Address:	66 Lincoln Inn Fields, London, WC2A 3LH
Drawing No:	1878 - 02
Drawing Title:	1st - 3rd Floor Plans
Drawing Date:	January 2017
Drawing Size:	Scale as Shown @ A1
Drawn By:	JH
Checked By:	JW
Issue	-

This drawing is to be read in conjunction with all relevant specifications and drawings issued. For discrepancies or omissions contact Mobile CAD Surveying Solutions Ltd prior to work commencing. The contractor is to check and verify all building and site dimensions and levels before work commences.

© COPYRIGHT Mobile CAD Surveying Solutions Ltd 2017
DO NOT SCALE THIS DRAWING - CHECK ALL DIMENSIONS ON SITE



Note:
Areas drawn indicatively noted and indicated by grey dashed line as line below

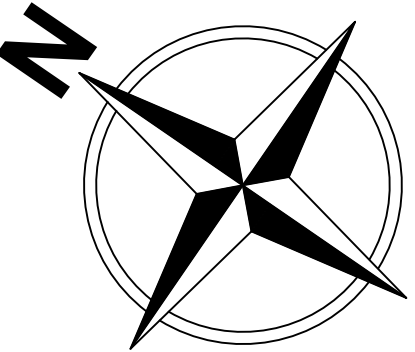

Compass Note:
Geographical orientation indicated is for indicative purposes only.

Abbreviations Key:

I/C	-	Inspection Chamber	GAS	-	Gas Supply
M/H	-	Manhole	ES	-	Electrical Supply
G	-	Drainage Gully	PO	-	Post Office
CD	-	Channel Drain	CATV	-	Community Antenna
RE	-	Rodding Eye		-	Television
RWP	-	Rain Water Pipe	TSSU	-	Traffic Light Signals
S+VP	-	Soil & Vent Pipe	T.P	-	Telegraph Pole
WM	-	Water Meter	B.	-	Bollard
ST	-	Stop Tap	L.P.	-	Lamp Post
SV	-	Stop Valve			
FH	-	Fire Hydrant			
IL	-	Invert Level			
BT	-	British Telecoms			

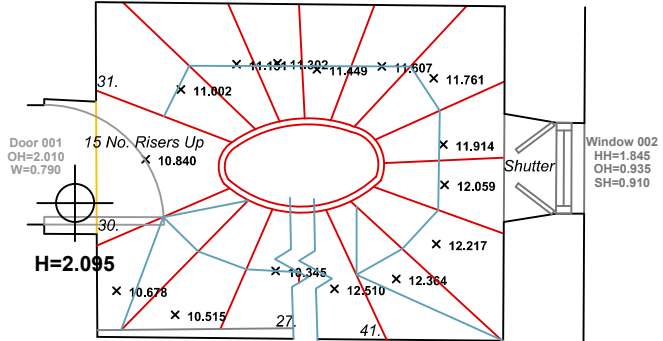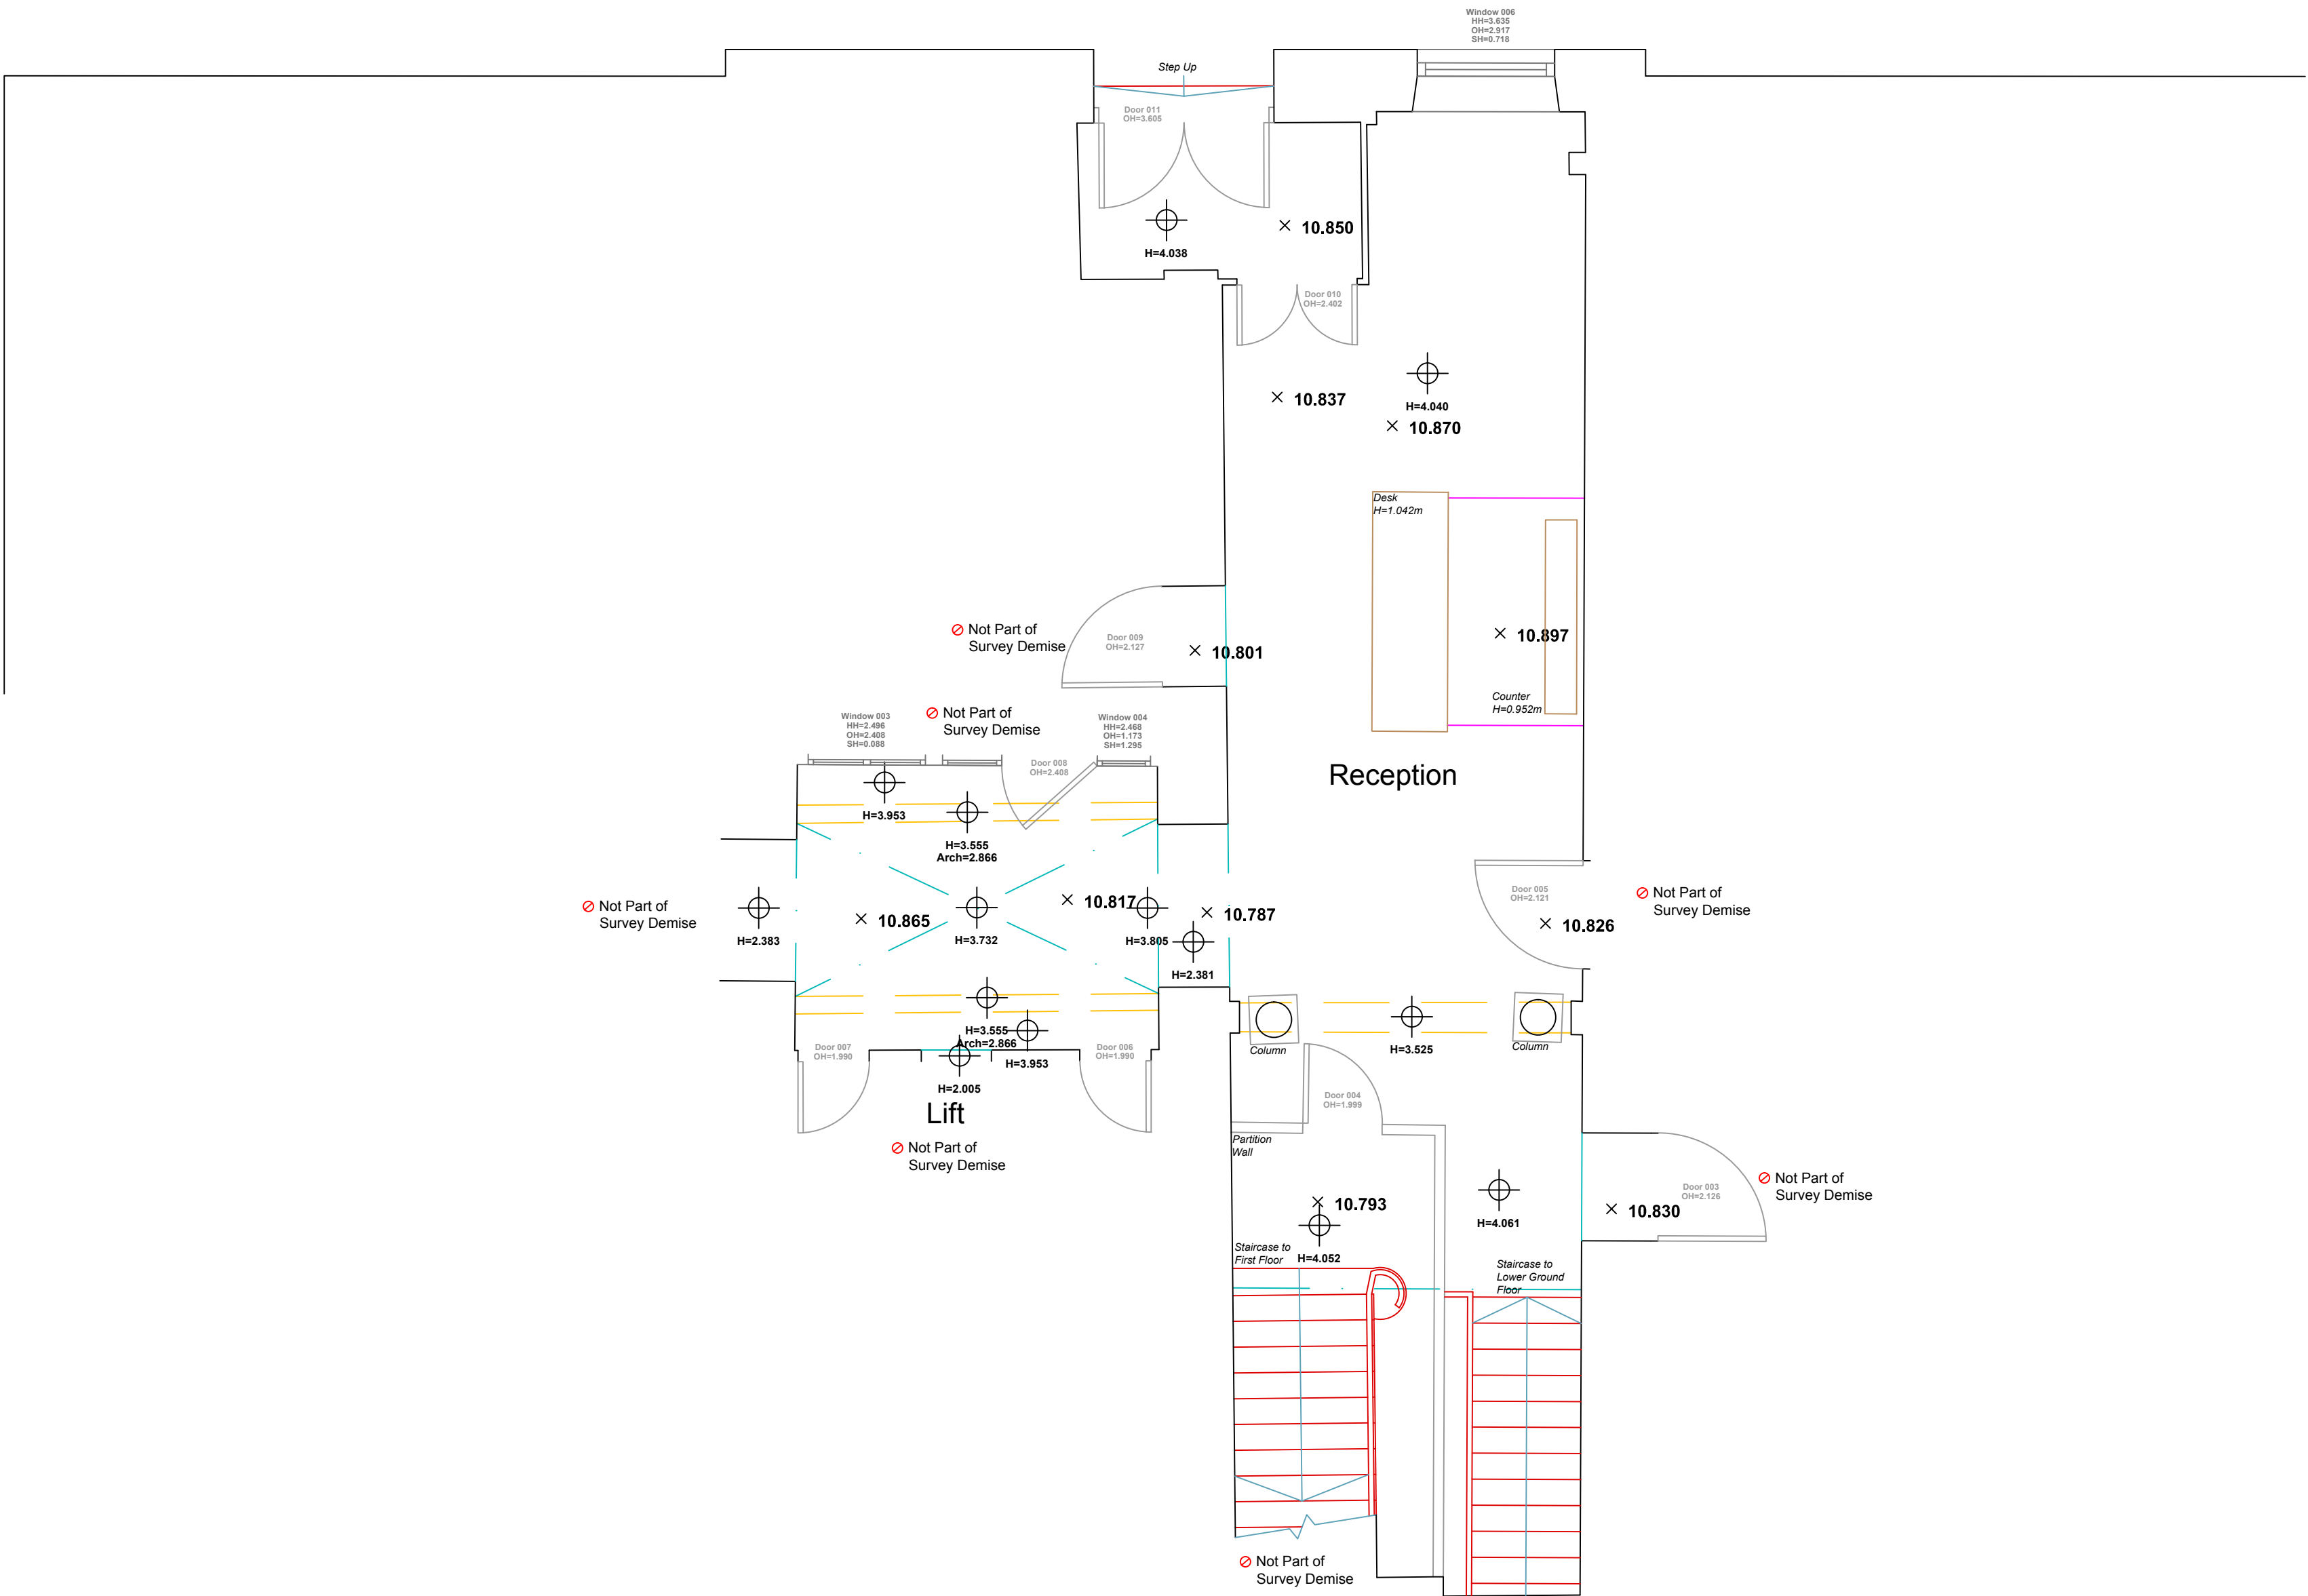

Reception & Ground Floor Staircase

1:50 Scale

Rev	Date	Amendments
-----	------	------------

Mobile CAD Surveying
office & on site...™

www.mobiledcadsurveying.co.uk
surveys@mobcad.co.uk

Pontefract Head Office:
Unit 11, 2 Harropwell Lane
Pontefract
West Yorkshire
WF8 1QY
01977 525 076

London Office:
Kemp House
152 - 160 City Road
London
EC2V 2NX
020 3198 1197

Project:	Measured Building Survey
Address:	66 Lincoln Inn Fields, London, WC2A 3LH
Drawing No:	1878 - 03
Drawing Title:	Reception & Ground Floor Staircase
Drawing Date:	January 2017
Drawing Size:	Scale as Shown @ A1
Drawn By:	JH
Checked By:	MW
Issue	-