



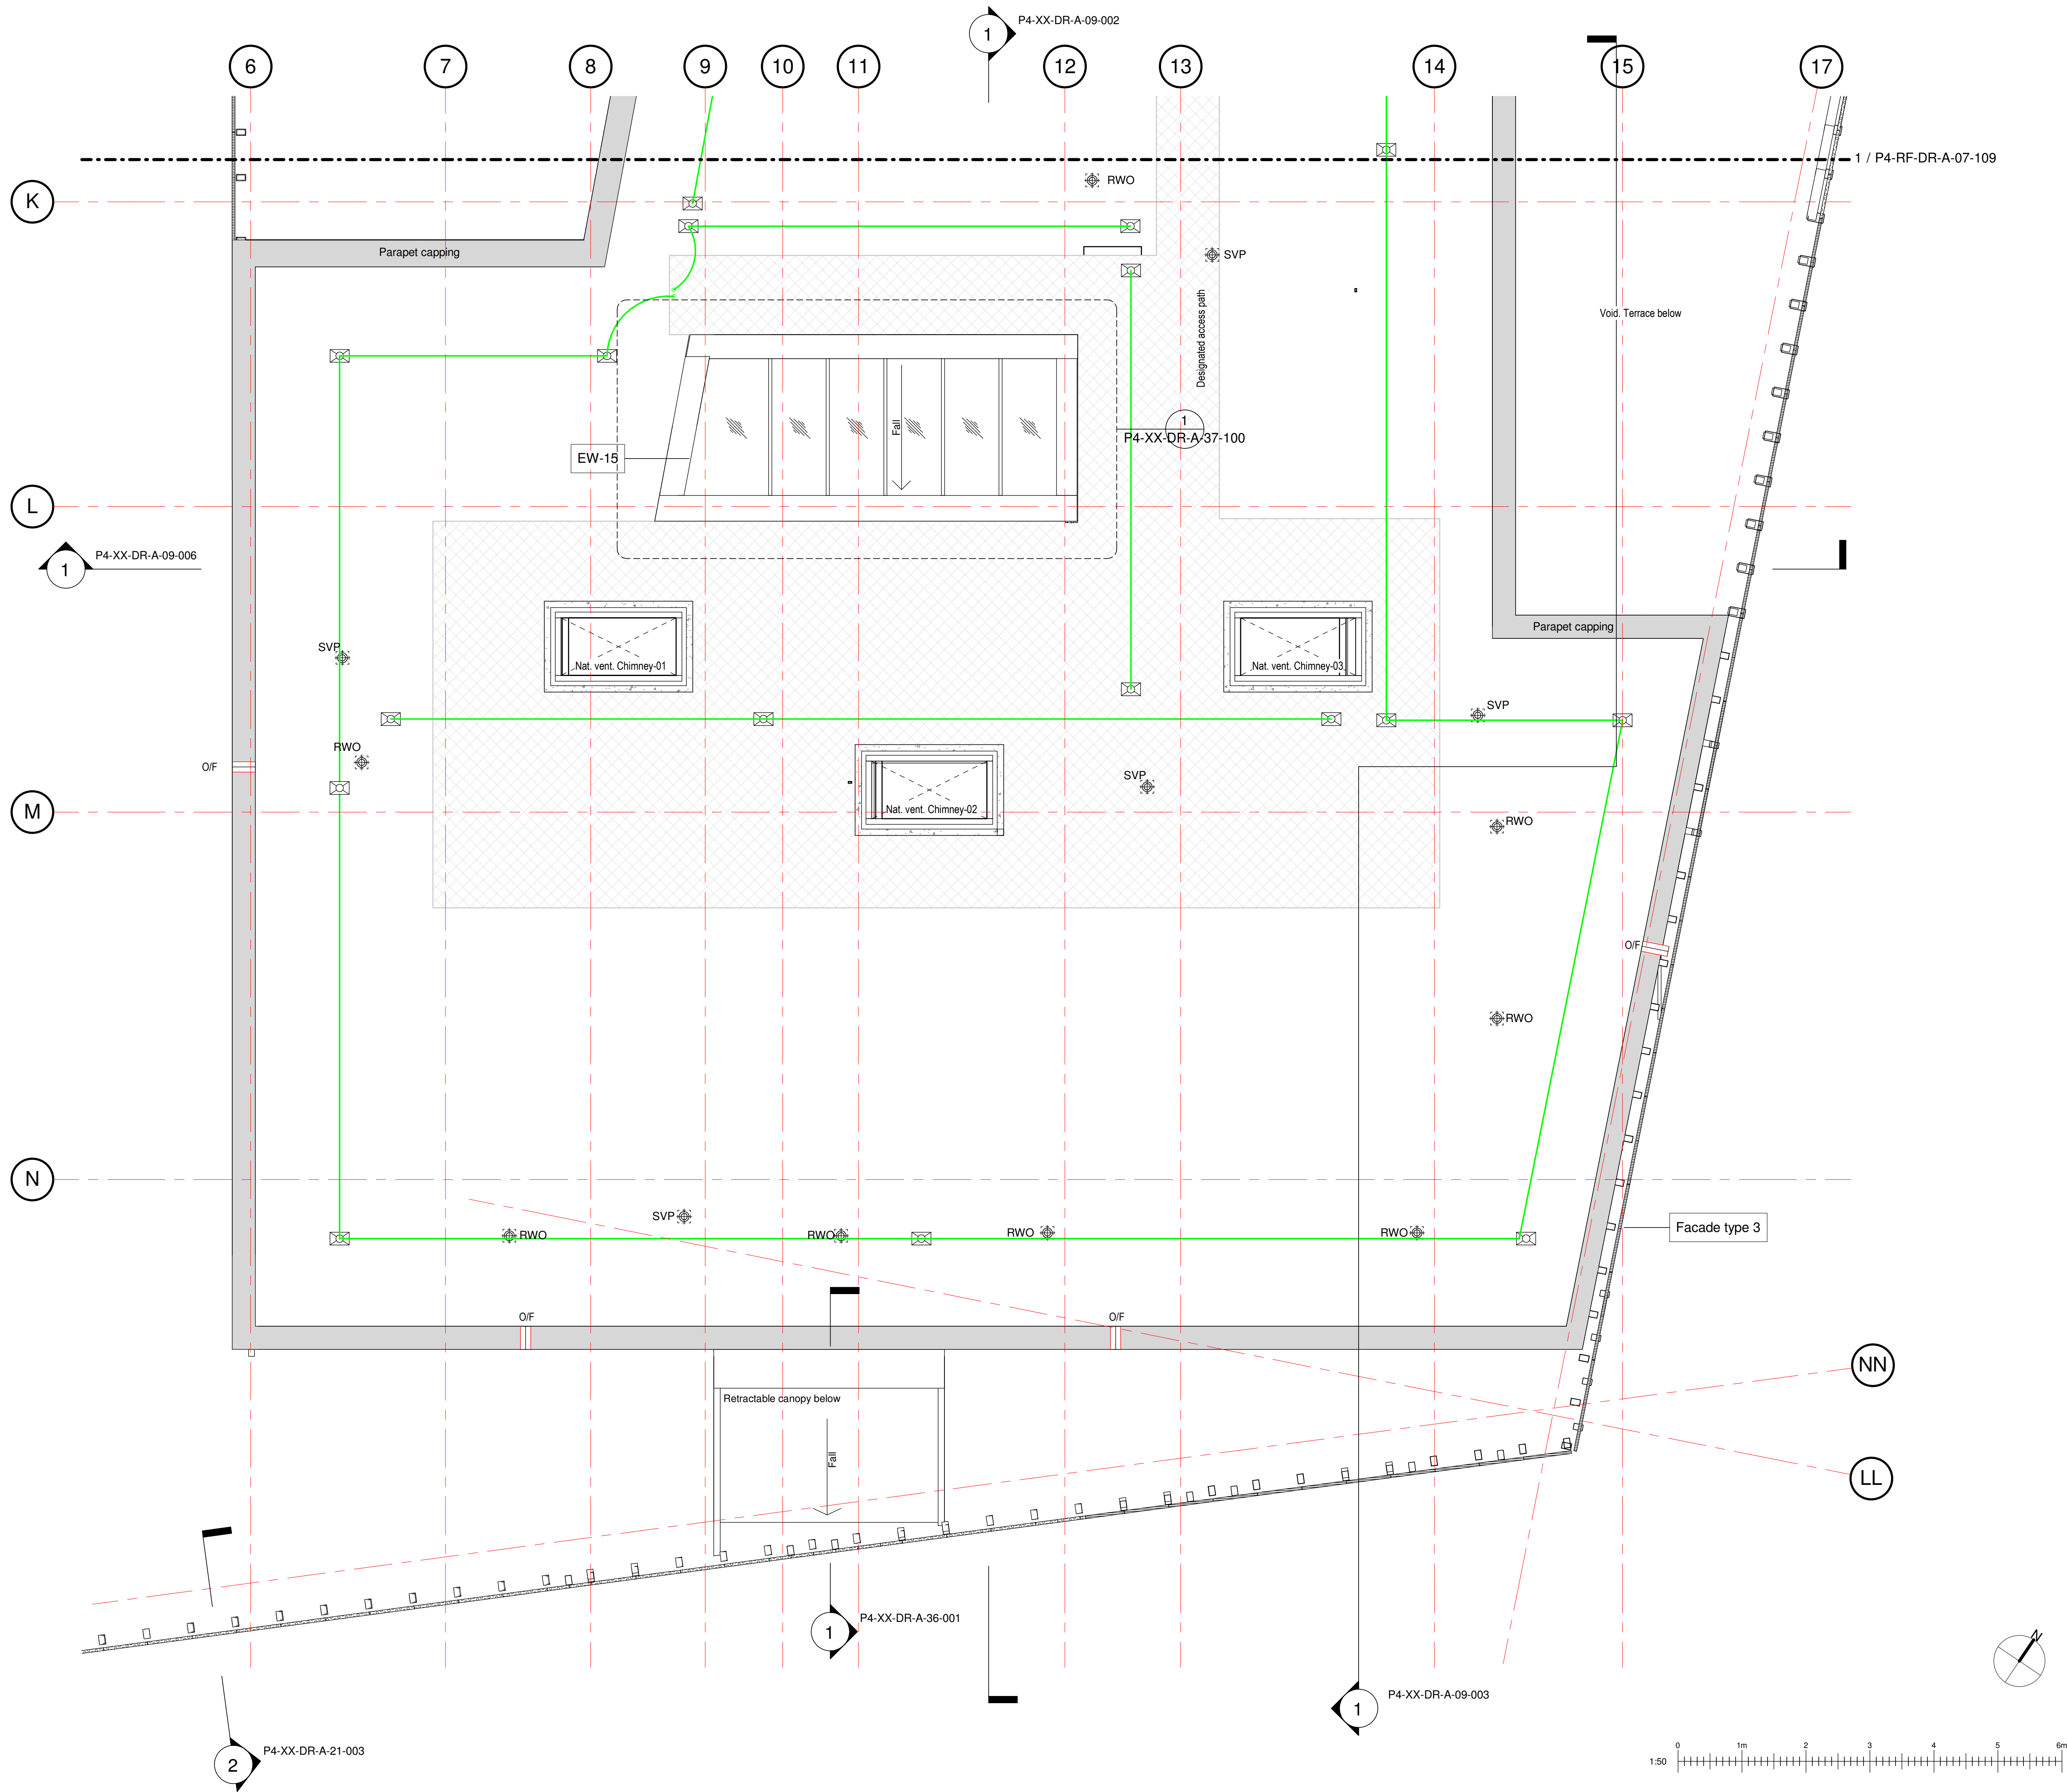

KEY PLAN - ROOF PLAN

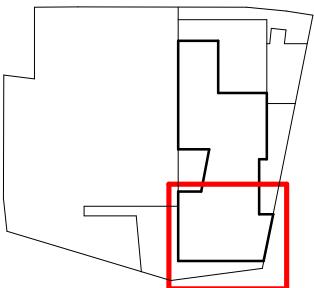

- SVP Soil vent pipe
- RWP Rain water pipe
- SS Stub stack
- Fall protection system
- O/F Overflow

C2	Discharge Planning Condition 7.	MB	NF	25/05/18
C1	Overflow outlets added. Construction Issue	ZC	MB	18/05/18
8	Latchways layout updated	ZC	MB	13/02/18
7	Co-ordinated RWO and Public Health. General revisions made	ZC	MB	31/01/18
6	Amendments per Hco Comments (22/12/17)	ZC	MB	19/01/18
5	CAD Issued for information	NS	NF	08/01/18
4	Wall Tags Added	ZC	NF	18/12/17
3	Amendments to allow CLT Coordination	ZC	MB	08/12/17
2	Amendments further to DLM 22/11/17. Door and window tags added. Issued for coordination	ZC	MB	01/12/17
1	Preliminary Issue	ZC	MB	16/11/17

status: CONSTRUCTION

This drawing is protected under The Copyright, Designs and Patents Act 1988. Do not scale. Figured dimensions only are to be taken from this drawing. All dimensions are to be checked on site before any work is put in hand. If in doubt, ASK.

PTAL

PETER TAYLOR ASSOCIATES LIMITED
7 OURZON STREET
MAYFAIR LONDON W1J 5HG
-
TELEPHONE + 44 (0)20 7495 3837
FACSIMILE + 44 (0)20 7493 3475
EMAIL MAYFAIR@PTAL.CO.UK
-
WWW.PTAL.CO.UK

client: Neilcott Construction Group
Excel House
Cray Avenue
Orpington
Kent
BR5 3ST



project: Central Somers Town
Plot 4

title: GA Roof Plan - Part 3

scale: 1 : 50 @ A1
date: 16/11/17
drawn: ZC
checked: MB

Project ID: 170025 Originator: PTA Drawing No: P4-RF-DR-A-07-110 revision: C2